



P. O. Box 5666 Brandon MS 39047
Ph: (601) 914-4853 Fax: (601) 608-7866
EMAIL: ashish@mishraarch.com
WEB: www.mishraarch.com

CIVIL:
Benchmark Engineering & Surveying
101 Highpointe Court Suite B
Brandon, MS 39042
Phone: (601) 591-1077
Fax: (601) 591-0711
Email: abonds@benchmarkms.net


STRUCTURAL:
S. K. International, Inc.
130 Main Street
Huntsville, AL 35811
Phone: (256) 852-3098
Fax: (256) 851-0686
Email: skint97@aol.com

ELECTRICAL:
William Council Tuberville
3080 Stage Post Drive, Suite 107
Memphis, TN 38116
Phone: (931) 676-3266

MECHANICAL:
Powell and Associates
886 Joe Dr
Collierville TN 38017-1415
Phone: (662) 890-4220
Fax: (662) 890-4224
Email: ROB@RHPowell.com

[illegible]

Information contained on this drawing and in all digital files associated is authorized for use on the project named herein only and is the property of MISHRA ARCHITECTURE PLLC and may not be reproduced in any manner without express written or verbal permission from authorized individuals. Original drawing is 24"x36" and scales are as indicated. © 2008 MISHRA ARCHITECTURE PLLC

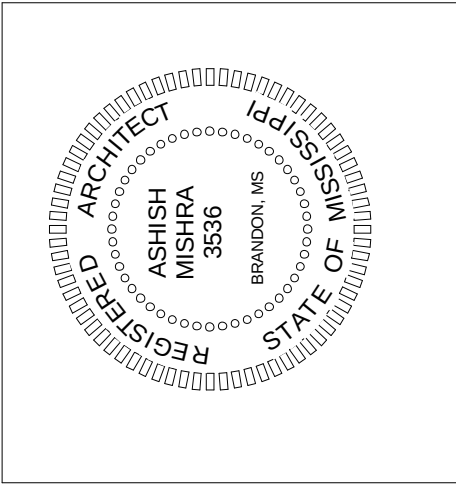

KEY PLAN

BAPS, INC.

YOGI YOUTH
CENTER


Greenway Drive
Jackson, MS 39206

Cover Sheet

Phase	Construction Documents
1	1
2	2
3	3
100	100

Project No.	07-051	Sheet No. A000
Prepared by	Author	
Checked by	Checker	
Date	Feb. 27, 2009	

CONSTRUCTION

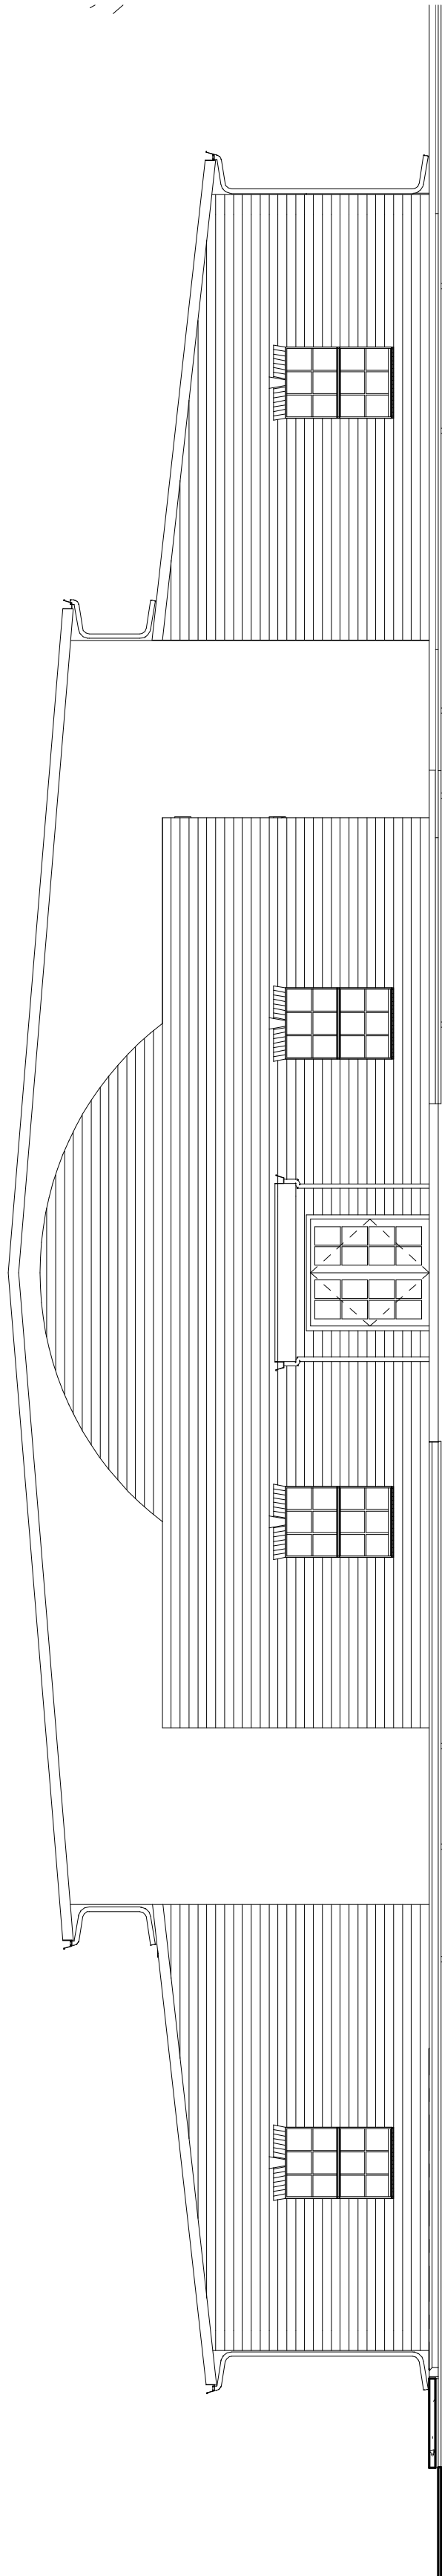

YOGI YOUTH CENTER


Discipline	Sheet Number	Drawing List	Sheet Name
0	A000	Cover Sheet	
1	C1.1	General Construction Notes	
1	C1.2	Typical Section & Miscellaneous Details	
1	C2.1	Site Plan	
1	C3.1	Utility Layout	
1	C3.2	Grading and Drainage Layout	
1	C3.3	Erosion Control Layout	
1	C4.1	Utility Infrastructure Details	
2	A001	Site Plan	
2	A101	First Floor Plan	
2	A102	Second Floor Plan	
2	A103	Roof Plan	
2	A201	First Floor Reflected Ceiling Plan	
2	A301	Elevations	
2	A302	Elevations/Sections	
2	A401	Details	
2	A402	Finish, Door & Window Schedule	
2	A501	First Floor Fire Wall Plan	
2	A502	Second Floor Fire Wall Plan	
3	S1.1	Foundation Plan	
3	S1.2	Foundation Plan	
4	M101	Ground Floor Mechanical	
4	M102	Second Floor Mechanical	
4	M103	Mechanical Notes	
5	P101	Ground Floor Plumbing	
5	P102	Second Floor Plumbing	
5	P103	Plumbing Notes	
6	F100	Fire Protection Site Plan	
6	F101	First Floor Plan Fire Protection	
6	F102	Second Floor Plan Fire Protection	
7	E100	Electrical Site Plan	
7	E101	Ground Floor Power Plan	
7	E102	Second Floor Power Plan	
7	E103	Ground Floor Lighting Plan	
7	E104	Second Floor Lighting Plan	
7	E105	Schedules and Diagrams	

1
2
3
4
5
6
7

ABBREVIATIONS

[illegible]

SYMBOL LEGEND

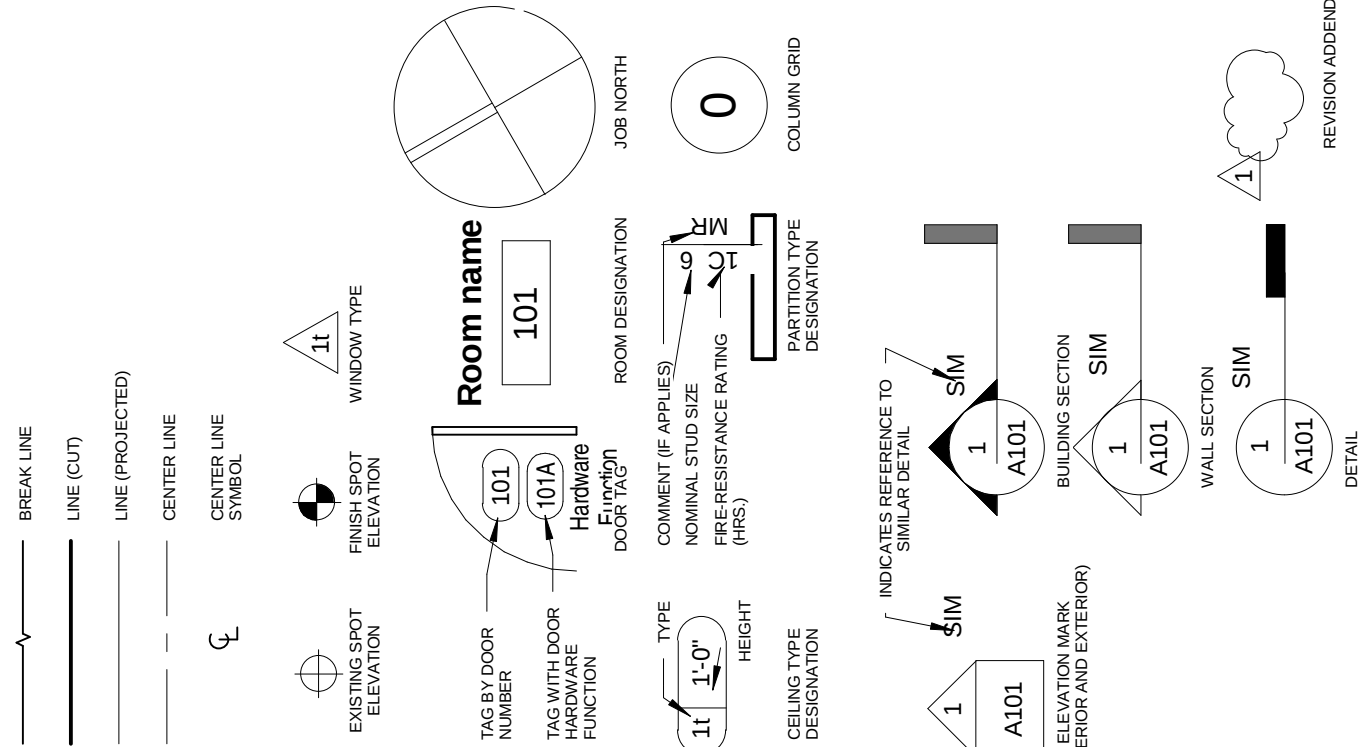[illegible]