



STATIC PRESSURE:	50 PSI
RESIDUAL PRESSURE:	50 PSI
FLOW:	750 GPM
DATE OF TEST:	9-25-08
TEST BY: JACKSON FIRE DEPARTMENT	

- 1 PUBLIC WATER MAIN PIPING TO BE CLASS 50 DUCTILE IRON.
- 2
- 3 PRIVATE WATER MAIN PIPING TO BE CLASS 150 PVC C-9000.
- 4
- 5 ALL FITTINGS TO BE MECHANICAL JOINT.
- 6
- 7 CONCRETE ALL TURNS.
- 8
- 9 MIN. DEPTH OF BURY 3'-0".
- 10
- 11 ALL PIPE UNDER BLDG. TO BE DUCTILE IRON.
- 12
- 13 INDICATE HYDRAULIC CALCULATION REFERENCE POINT.
- 14
- 15 LOCATE ALL FIRE HYDRANTS WITHIN 3'-0" OF CURB.

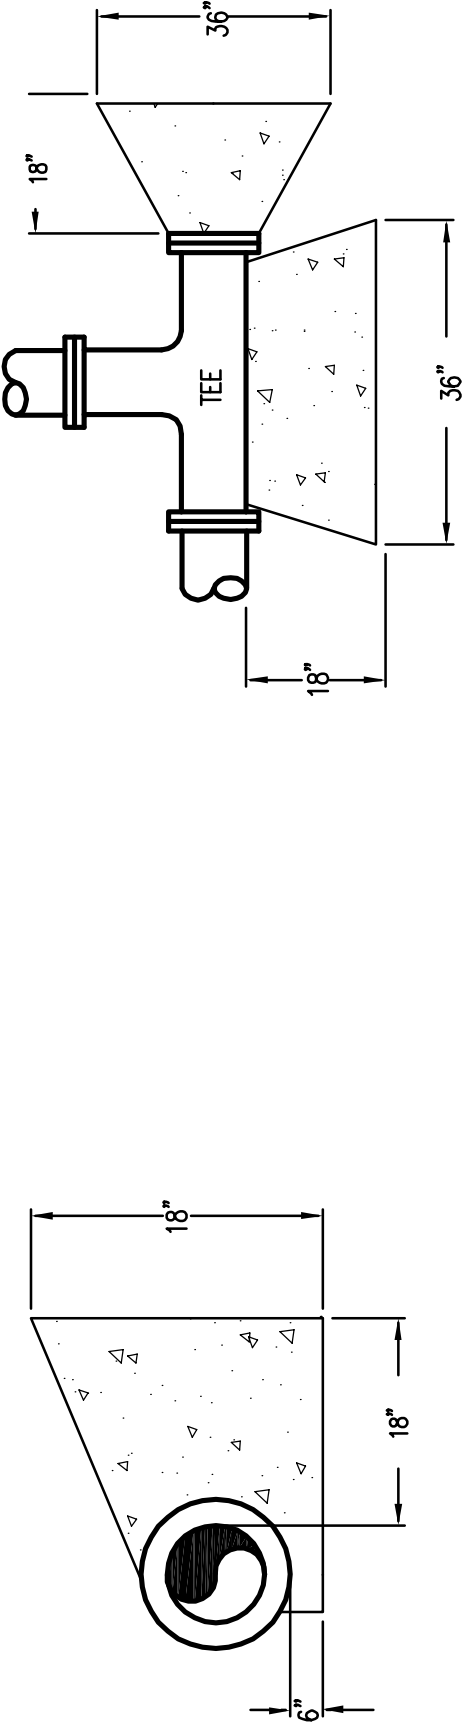

SCALE: NONE

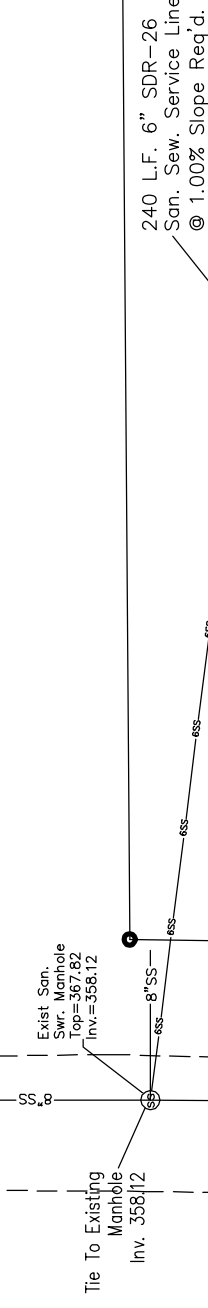


SCALE: NONE



SCALE: NONE



SCALE: 1" = 30'-0"

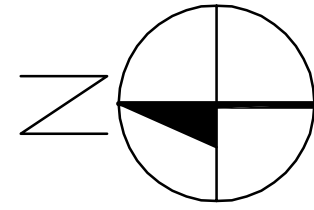

PHONE: (601) 914-4853 FAX: (601) 326-2253
Email: ashish@mishraarch.com Web: www.mishraarch.com

CIVIL ENGINEER:
LEINCHMANN ENG.
 04 Mary Ann Drive
 Brandon, MS 39042
 PHONE: (601) 591-1077
 FAX: (601) 591-0711
 EMAIL: mikebes@bellsouth.net

STRUCTURAL ENGINEER:
S. K. INTERNATIONAL, INC.
 130 MAIN STREET
 HUNTSVILLE, AL 35811
 PHONE: (256) 852-3098
 FAX: (256) 851-0686
 EMAIL: skint91@aol.com

WILLIAM COUNCIL
TUBERVILLE
1980 TRANSPORT
MEMPHIS, TN 38116
PHONE: (901) 826-8059

NAME: _____
ADDRESS: _____
CITY: _____
STATE: _____
PHONE: _____
FAX: _____
EMAIL: _____

[illegible]

FIRE PROTECTION SITE PLAN

Project number	
Date	10-07-2008

Drawn by	
Checked by	

Scale