



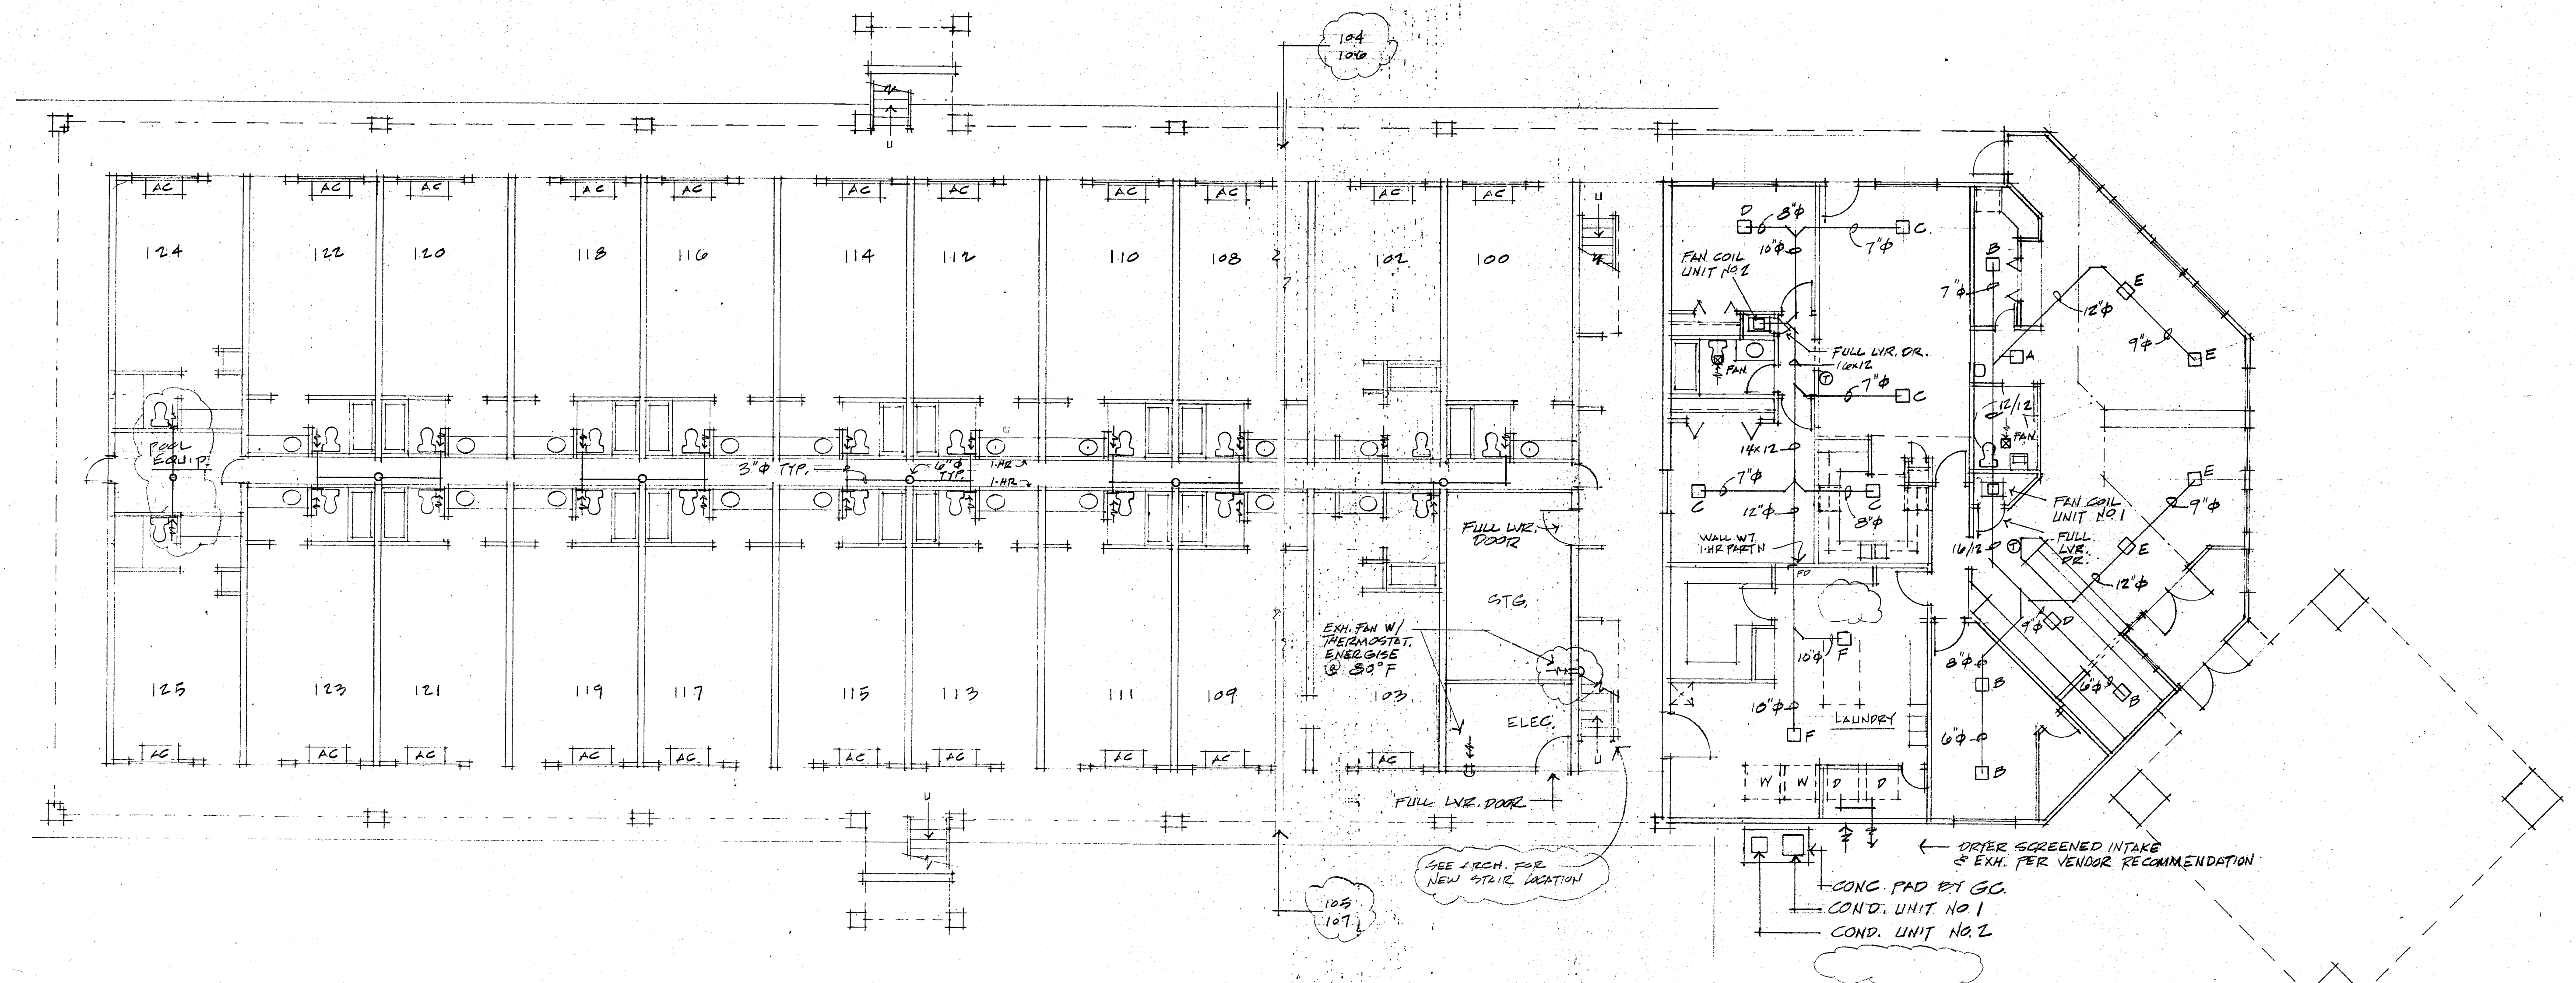


GROUND FLOOR PLAN


1/8" = 1'-0"

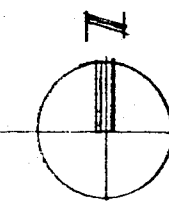

NOTE:
PROVIDE 12" Ø DUCT FROM A 12" x 18" RA
GRILLE IN CLG. OF LAUNDRY BACK TO
FAN COIL UNIT #2 ROOM.

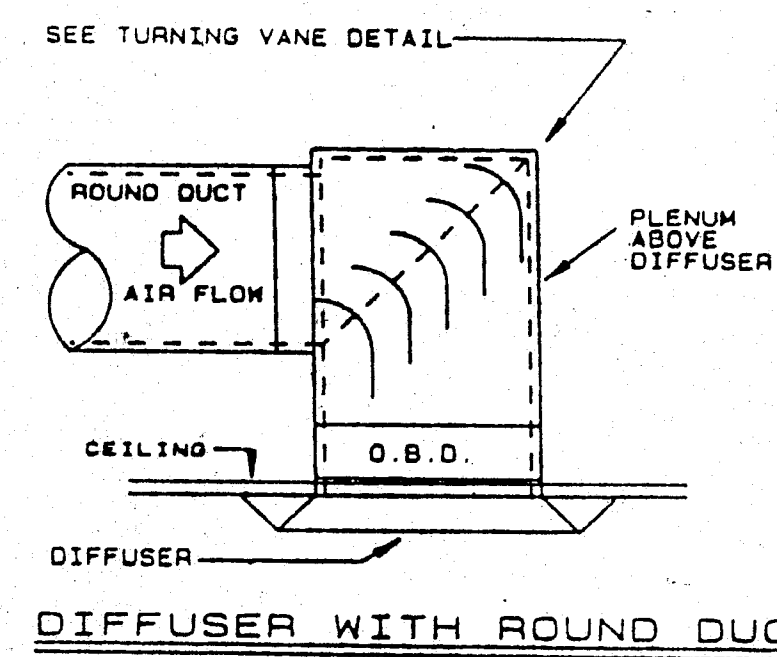

DIFFUSER WITH ROUND DUCT

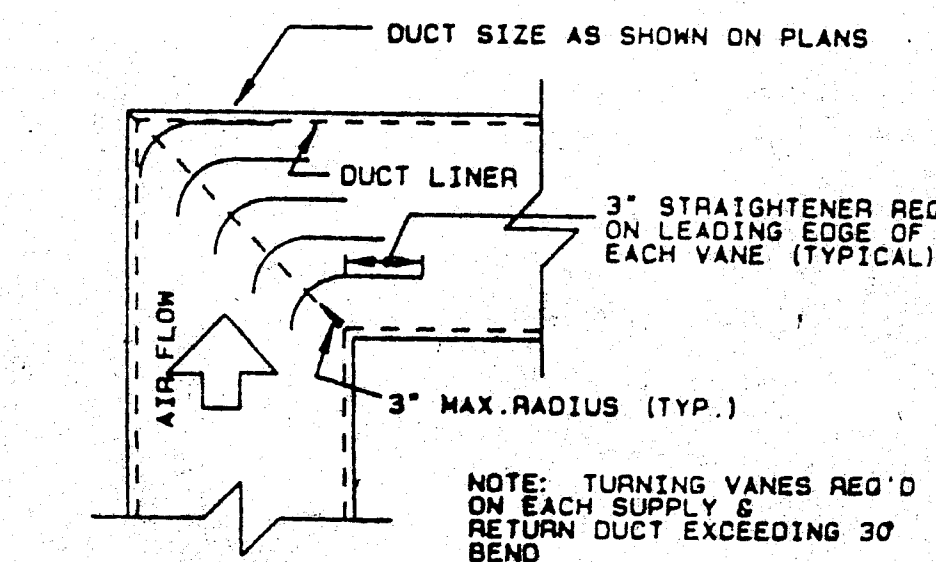

TURNING VANE DETAIL

CEILING DIFFUSER SCHED.			
MARK	SIZE	CFM	REMARKS
A	6 x 6	30	4 WAY
B	8 x 8	100	
C	10 x 10	150	
D	10 x 10	200	
E	12 x 12	300	
F	15 x 15	400	

REV. 7-13-92

BEST WESTERN PEARL, MS		DESIGN CONSORTIUM HOTEL CONSULTANTS MEMPHIS, TENNESSEE	
GROUND FLOOR MECHANICAL PLAN	DATE	7-15-92	M-1
	SCALE		
	JOB NO.		