


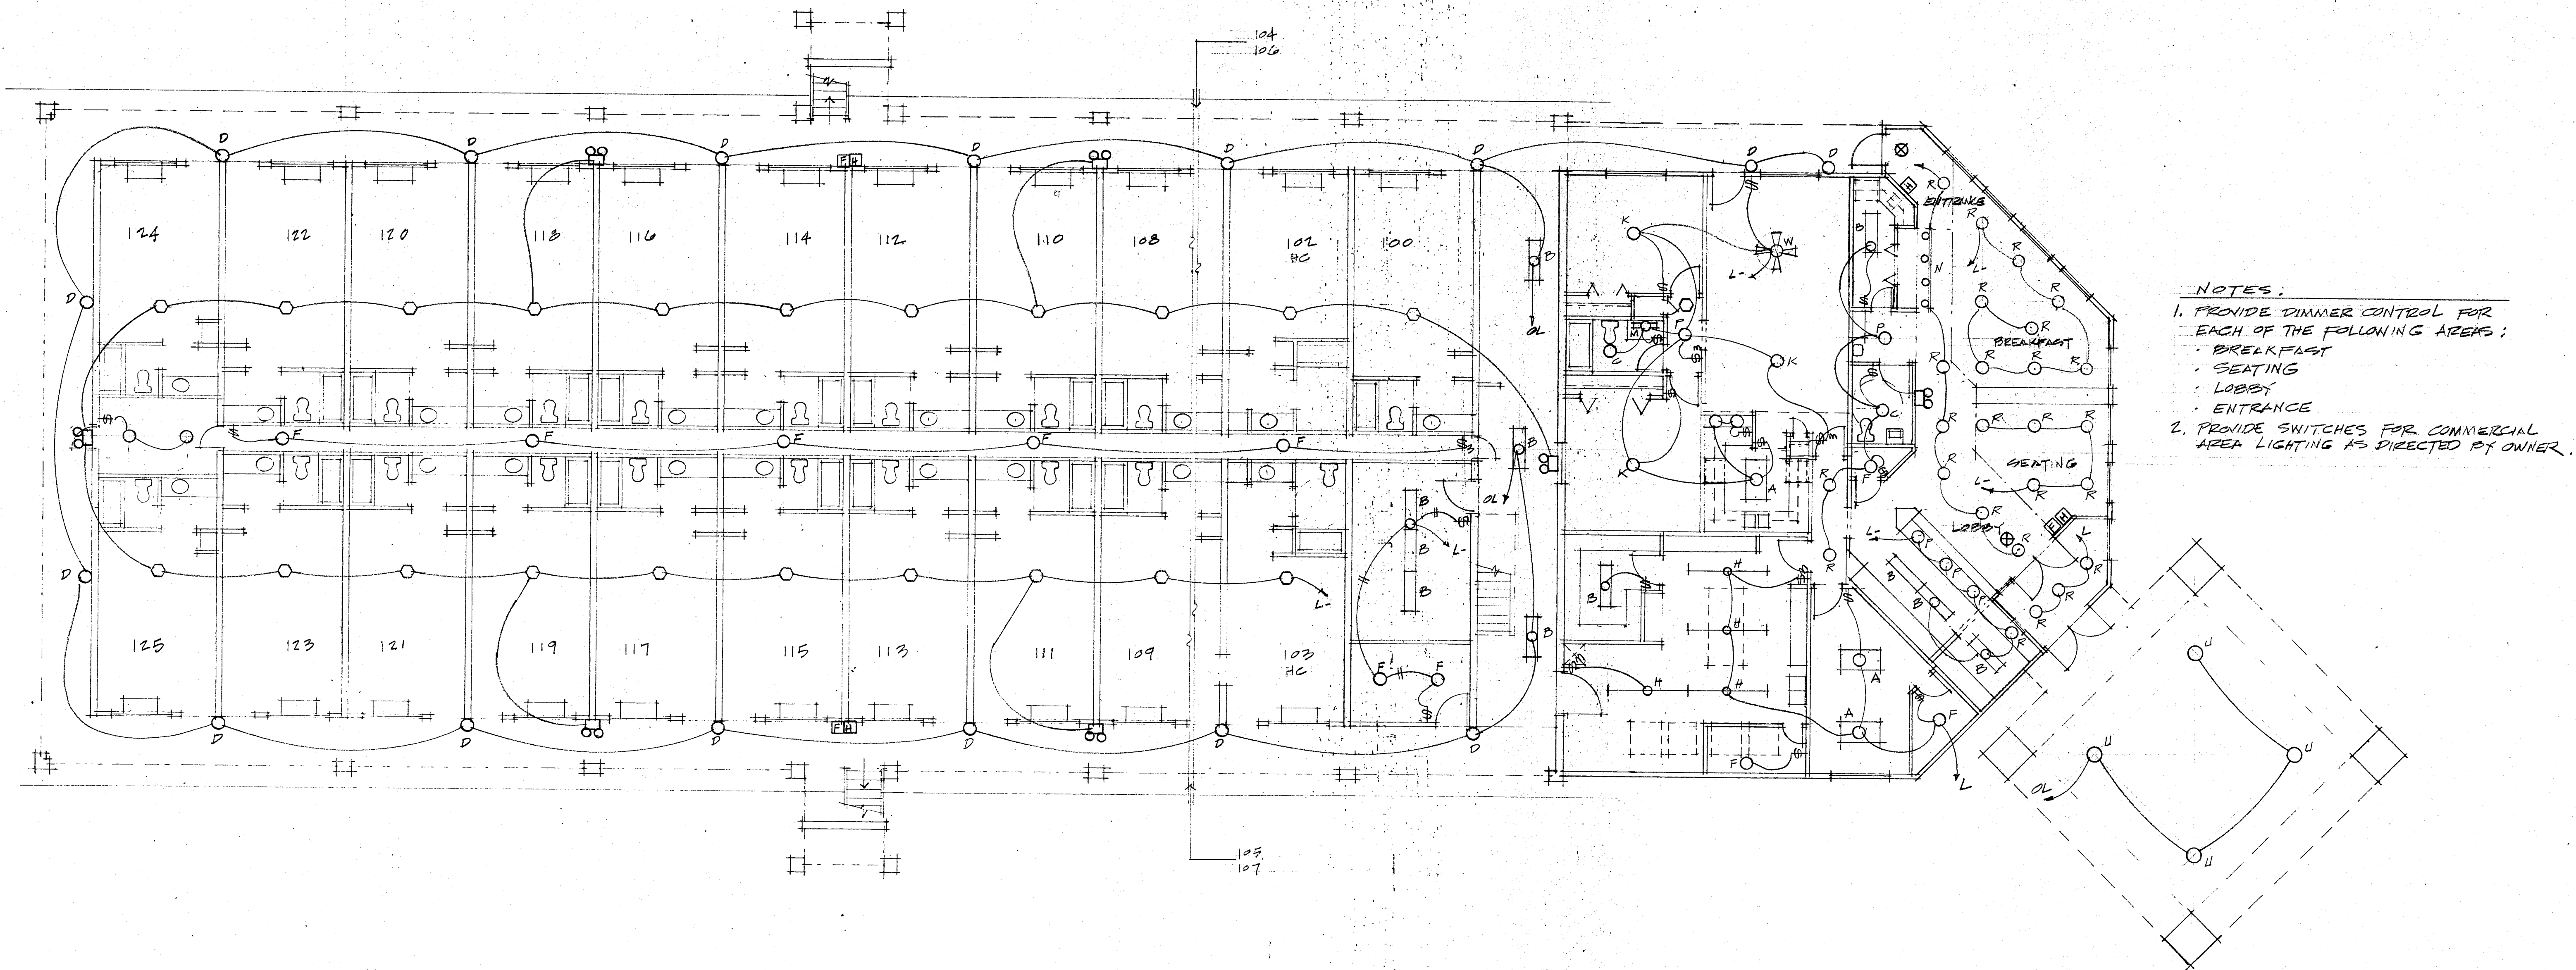

- NOTES:
1. PROVIDE DIMMER CONTROL FOR EACH OF THE FOLLOWING AREAS:
 • BREAKFAST
 • SEATING
 • LOBBY
 • ENTRANCE
 2. PROVIDE SWITCHES FOR COMMERCIAL AREA LIGHTING AS DIRECTED BY OWNER.

GROUND FLOOR PLAN
 LIGHTING
 1/8" = 1'-0"

BEST WESTERN PEARL, MS	DESIGN CONSORTIUM HOTEL CONSULTANTS MEMPHIS, TENNESSEE		
	DATE 4/27/92	7-15-92	E-1
	SCALE		
GROUND FLOOR LIGHTING PLAN	JOB NO.		

REV. 7-13-92

12/15/92