



NOTES

- 1.
2. SUBMIT ALTERNATE TO PROVIDE INDICATING LIGHT PANEL AT THE FRONT DESK TO INDICATE SMOKE DETECTOR STATUS ROOM BY ROOM.
3. CONFER W/ OWNER FOR REGISTRATION AREA REQUIREMENTS, AND LOCATIONS FOR POWER, TELEPHONE & COMPUTER SYSTEMS.

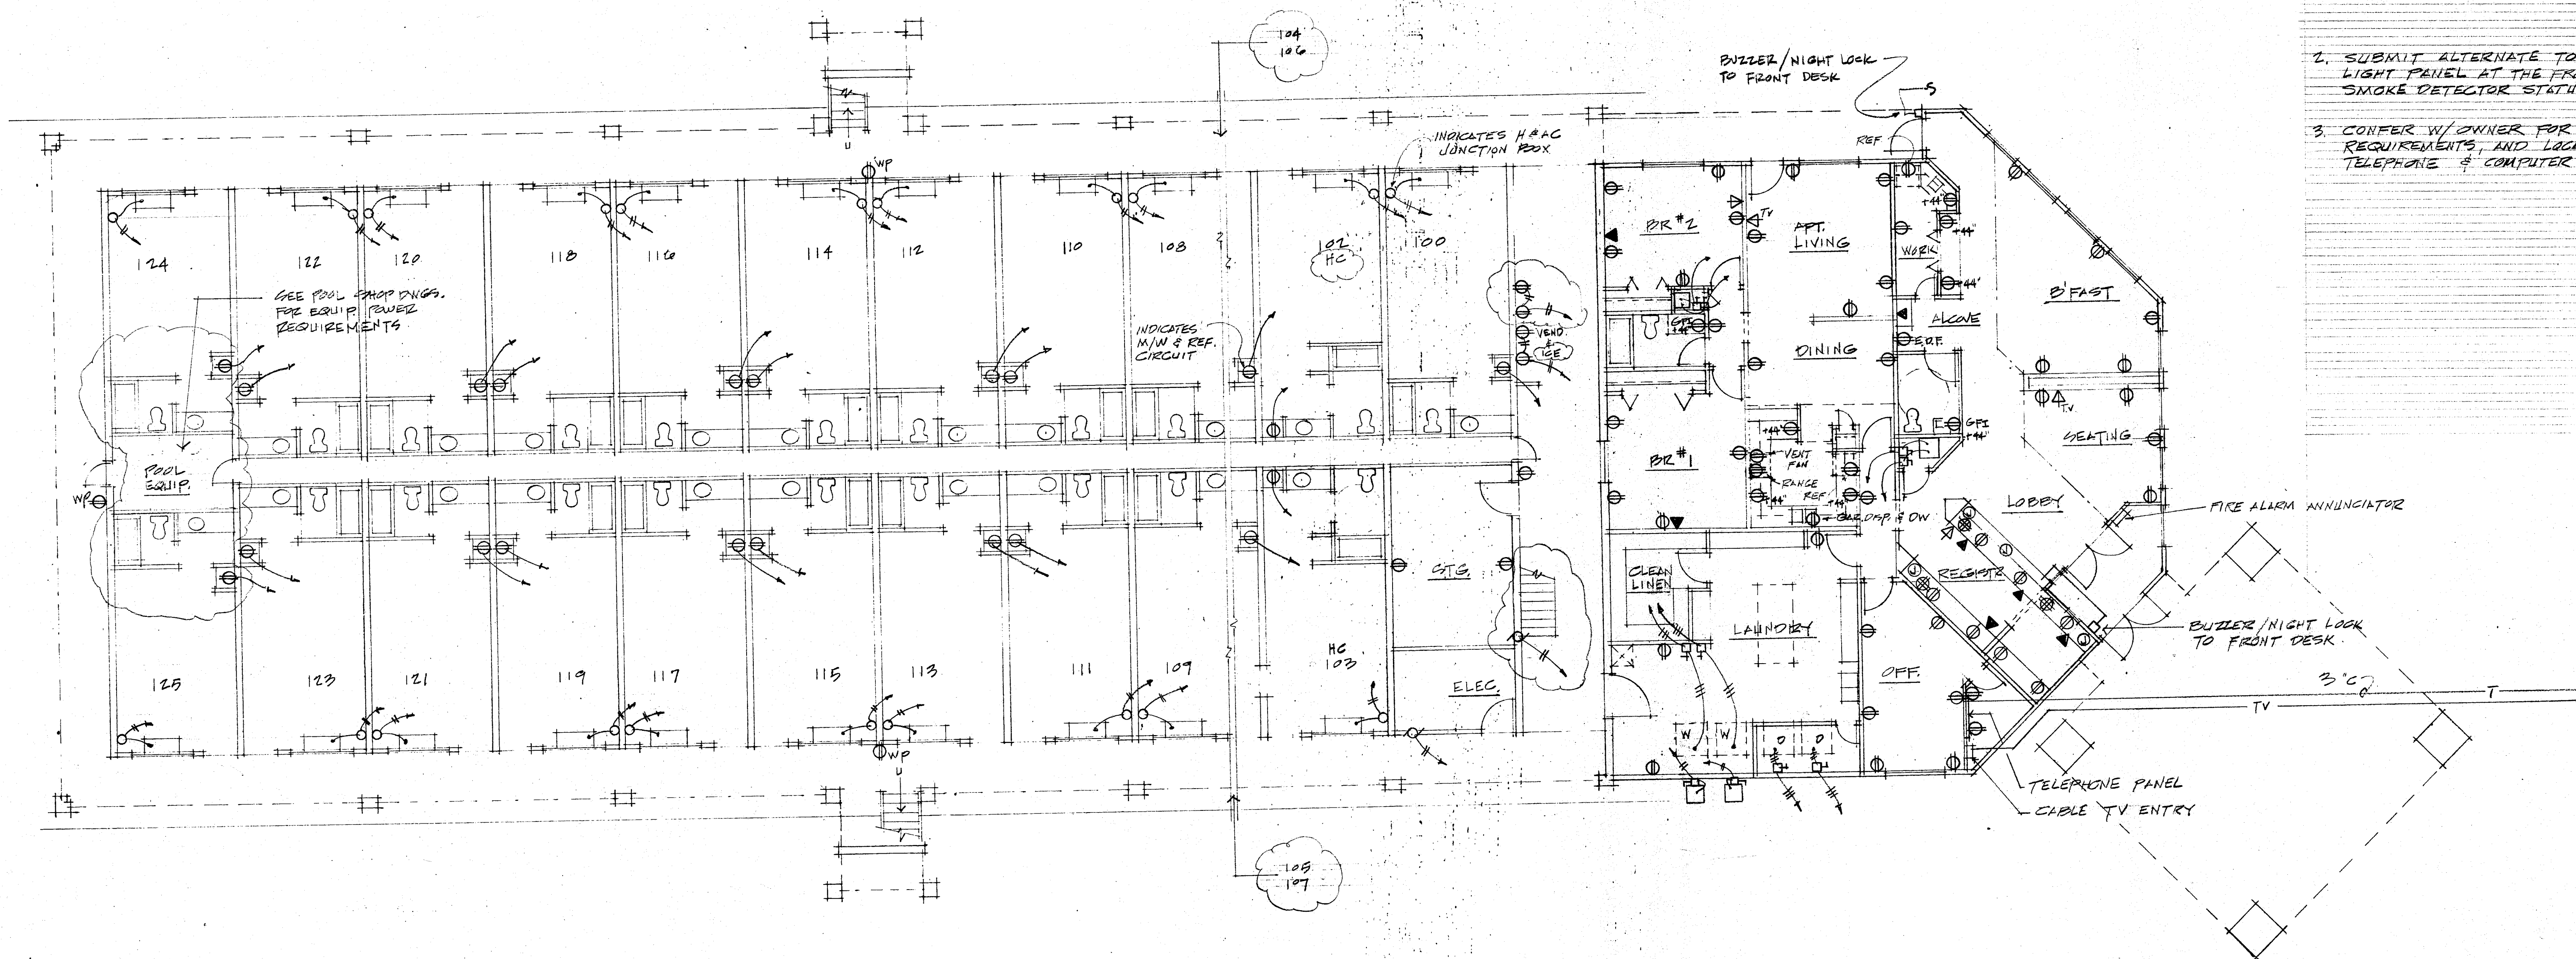

GROUND FLOOR PLAN
POWER

1/8" = 1'-0"

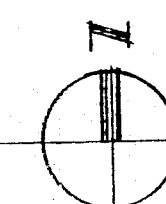

REV. 7-13-92

BEST WESTERN PEARL, MS	DESIGN CONSORTIUM HOTEL CONSULTANTS MEMPHIS, TENNESSEE		
GROUND FLOOR POWER PLAN	DATE 7-15-92	7-15-92	E-2
	SCALE	JOB NO.	