

ELECTRICAL NOTES

- ALL ELECTRICAL WORK SHALL BE PERFORMED IN STRICT ACCORDANCE WITH THE LATEST EDITION OF THE NATIONAL ELECTRICAL CODE AND ALL STATE AND LOCAL CODES.
- FIRE ALARM SYSTEM SHALL CONSIST OF VIBRATING HORNS PRODUCING 101 DB AT 10 FT. SMOKE DETECTORS PRODUCING 85 DB AT 10 FT. PULL STATIONS, CONTROL PANEL, 4 ZONE ANNUNCIATOR PANEL, AND STANDBY POWER SUPPLY WITH RECHARGEABLE BATTERIES. ALL COMPONENTS SHALL BE MONACO, OR EQUAL.
- THE INSTALLATION OF THE PROPOSED FIRE ALARM SYSTEM SHALL BE IN ACCORDANCE WITH NFPA #72A, 79 EDITION. WORKING DRAWINGS INCLUDING A COPY OF THE MANUFACTURER'S SPECIFICATION LITERATURE AND A DIAGRAM OF THE ANNUNCIATOR FACE PLATE WITH ZONING NOMENCLATURE, SHALL BE SUBMITTED PRIOR TO INSTALLATION AND APPROVED BY ALL STATE & LOCAL FIRE MARSHALLS OFFICE.
- THE BUILDING FIRE ALARM SYSTEM SHALL BE CLEARLY HEARD THRU-OUT THE PROPOSED TENANT SPACE, REGARDLESS OF THE NORMAL NOISES OF OCCUPANCY.
- PROPOSED SPOT TYPE SMOKE DETECTORS FOR EACH ROOM SHALL BE INSTALLED IN ACCORDANCE WITH NFPA #72E, 1978 EDITION.
- CONTRACTOR SHALL COORDINATE WITH INTERIOR DESIGN DRAWINGS FOR EXACT LOCATION OF ALL RECEPTACLES AND LIGHT FIXTURES. ALL LIGHT FIXTURES SHALL BE AS SELECTED BY INTERIOR DESIGNERS & OWNER.
- GROUNDING OF TELEPHONE EQUIPMENT SHALL BE MINIMUM 8'-0" ROD IN GROUND AND COMPLY WITH ALL CODES.
- CONTRACTOR SHALL PROVIDE ALL CONDUIT NECESSARY FOR ALL SERVICES INCLUDING TELEPHONE, TELEVISION, & FIRE ALARM.
- CONTRACTOR SHALL SUBMIT WIRING DIAGRAMS FOR APPROVAL PRIOR TO INSTALLATION.
- ALL EXTERIOR LIGHTS SHALL BE CONTROLLED FROM THE ELEC. RM.
- PROVIDE AUDIO/VISIO SYSTEM FOR COM. AREA TO BE MONITORED IN MOB'S APT.
- ELEC. CONTR. SHALL CONFER W/ ALL TRADES REGARDING ELEC. REQUIREMENTS & COORDINATE AS NECESSARY.

LIGHT FIXTURE SCHEDULE

MARK	DESCRIPTION
A	SURF. MOUNTED 2x4' FLUORESCENT, LITHONIA W/4 F40
B	SURFACE MOUNTED 1x4' FLUORESCENT, LITHONIA SWO 2224 W/2 F40
C	SURFACE MOUNTED CIRCLINE FLUORESCENT, PROGRESS 7370 W/1 32W
D	WALL MOUNTED FLUORESCENT PROGRESS P7110-10 W/1 PL-13
E	1x4 SURFACE MOUNTED FLUORESCENT, LITHONIA C240 W/2 F40
F	SURFACE MOUNTED INCANDESCENT KEYLESS SOCKET, PROGRESS 44, 100W
G	CEILING MOUNTED FLUORESCENT, PROGRESS P7110-10 W/1 PL-13
H	SURFACE MOUNTED 8' FLUORESCENT STRIP, LITHONIA C296 W2 F96T12
K	SURFACE MTD. INCAN. 3-60W, DEC. GLASS COVER
L	GROUND MOUNTED FLOOD LAMP, HI-TEK TFL 250M TA2 W/1 150W MH
M	1x2 SURFACE MOUNTED FLUORESCENT, LITHONIA C220 W/2 F20
N	SURFACE MTD. 8' TRACK W/4 INCLUD. LAMPS
O	EMERGENCY LIGHT, BATTERY PACK, LITHONIA ES1/ER-ELC
P	EMER. BAT. UNIT W/2 HEADS, LITHONIA ELU-3H W/2 12W, 12V PAR 18 HALOGEN LAMPS, MTD. @ 7'-8" AFF.
NOTE: ALL FIXTURES TO BE SELECTED AND/OR APPROVED BY OWNER AND/OR ARCHITECT/INTERIOR DESIGNERS. MODEL NO.'S ARE FOR REFERENCE ONLY.	
Q	SMOKE DETECTOR W/ BATTERY BACKUP
R	RECESSED DOWNLIGHT, LITHONIA AG-AR, CLEAR ALZAK REFLECTOR W/ 1-75W INCAN. LAMP
S	GAME AS P EXCEPT SURFACE MTD.
T	POST TOP LIGHT W/ 70W H.P.S. LAMP, SPALDING YN1-70-HPS, BLACK FINISH
U	AREA LIGHT, 400 W HPS W/ TYPE III OPTIC. DISTRIBUTION, EMCO PAED-F-400-203-DS-F, BRONZE PTD. FINISH, 30 FT. SQ. TAPERED STL. PILE.
V	EXTERIOR RECESSED, LITHONIA A-10-1505-AC-TW, CLEAR ALZAK REFLECTOR, WHITE TRIM, 150 W. HPS LAMP
W	GROUND MTD. FLOODLIGHT, 250W MET. HALIDE 203 X INFRANOR 505-SF-CB-10-45-A-60/110-400H-203-E (MTD. ON 16"x16"x4" CONC. BASE W/ TOP 2" ABOVE FIN. GRADE)
X	CLG. MTD. LIGHT/FAN AS SELECTED
Y	WALL MTD. LIGHT FURN. BY OWNER, INSTALLED BY CONTR.
Z	EXT. WALL MTD. DBL. HEAD FLOOD LAMP, 2-150W MH

NOTE: ALL ENTRY DOOR LIGHTS AND BREEZEWAY LIGHTS SHALL BE SWITCHED AT THE ELEC. RM. ALL EXTERIOR PARKING AND AREA LIGHTING SHALL BE OPERATED BY PHOTO-ELECTRIC CELLS. ALL LIGHTS IN THE ENTRY PORTE COCHERE AND SIGN LIGHTS SHALL BE SWITCHED AT THE ELEC. RM. & BY PHOTO CELL


THRU-WALL A.C. UNITS

GENERAL ELECTRIC, AMANA OR APPROVED EQUAL, 9,000 BTUH COOLING CAPACITY, 208/1/60, 3.0 KW ELECTRIC RESISTANCE HEATER, MAXIMUM BREAKER SIZE 20 AMP. COMPLETE WITH WALL SLEEVE, EXTERIOR GRILLE, ETC. SUBMIT TO OWNER FOR APPROVAL. UNIT SHALL FIT INTO NOMINAL 42x18" WALL SLEEVE.
NOTE: DWGS. INDICATE DISCONNECT SW. IN UNIT BASE W/ NO EXPOSED CHORD. VERIFY IF OWNER WOULD PREFER TO CONNECT UNIT W/ EXPOSED CHORD INTO AN ADJACENT CONV. OUTLET. IN THIS CASE PROVIDE 60 FT. MIN. LINE CHORD W/ UNIT, DELETE WIRING IN BLAS & JUNCTION BOX & PROVIDE CONV. OUTLET ON FRONT WALL NEXT TO UNIT.

PANELBOARD SCHEDULE


PANEL	BUS/MAINS	BREAKERS	NO.	LOAD
A	225 MLO	20/1	42	GR. FLR. GUEST ROOMS LIGHTING, GEN. USE, MICROWAVE OVENS & REFR'S.
B	225 MLO	20/1	42	2ND FLR. GUEST ROOMS LIGHTING, GEN. USE, MICROWAVE OVENS & REFR'S.
H1	225 MLO	20/2	21	GR. FLR. GUEST RMS. H & A/C UNITS
H2	225 MLO	20/2	21	2ND FLR. GUEST RMS. H & A/C UNITS
L	225 MLO	00/3 20/1	1 15	COMMERCIAL PLUG LIGHTING & POWER, & BUILDING LIGHTING
OL	100 MLO	20/2 20/1		EXTERIOR LIGHTING & SIGNS
EQ	225 MLO	50/3 30/3 40/2 20/2 20/1	1 1 1 6 4	WASHERS, DRYERS, A/C, HEAT. COILS, CONDENSING UNITS, POOL EQUIPMENT
MDP	800 MLO	225/3 200/3 150/3	3 2 1	PANEL SERVICE

NOTE: LABEL ALL PANELS W/ LOADS FOR OWNER'S REFERENCE

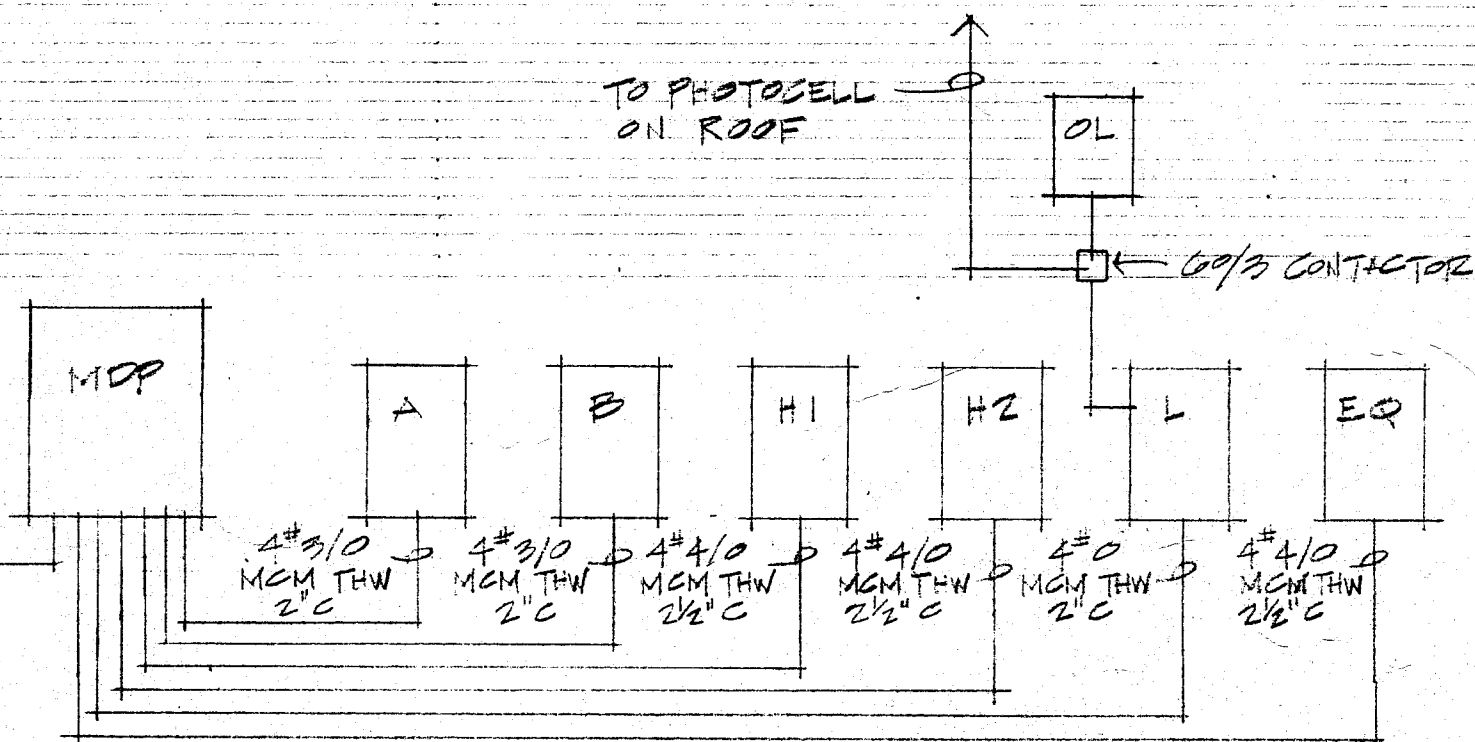


ELECTRICAL RISER DIAGRAM

MODIFY PANELBOARD SCHEDULE AND RISER DIAGRAM AS REQUIRED FOR ADDITIONAL GUEST ROOMS

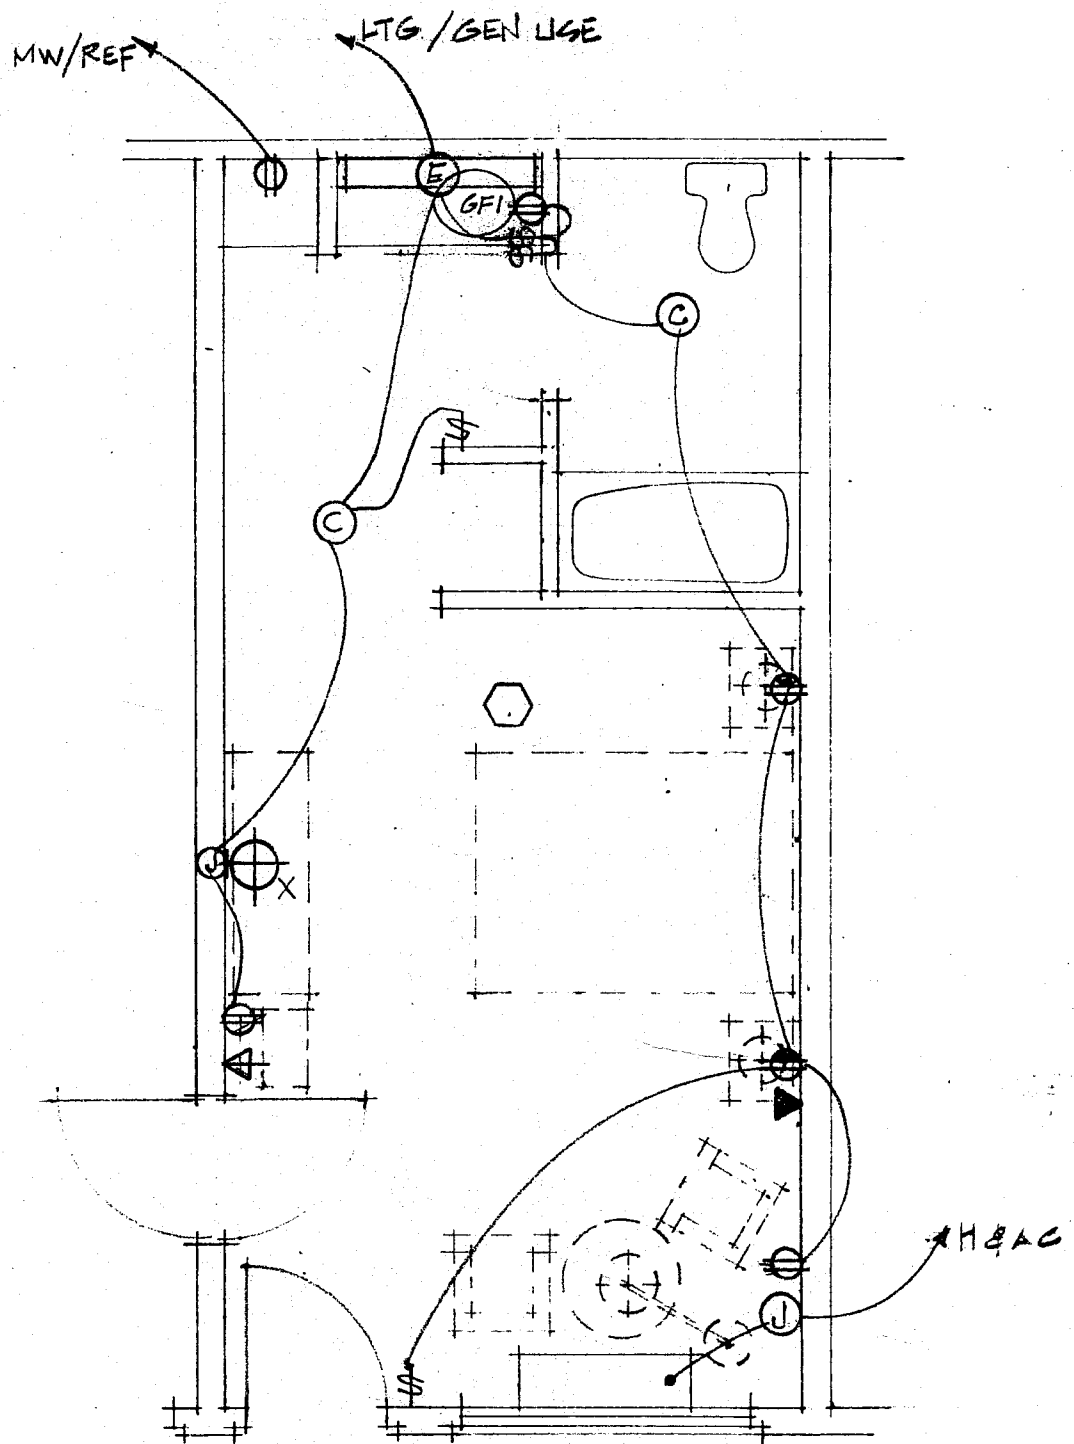


HANDICAPPED

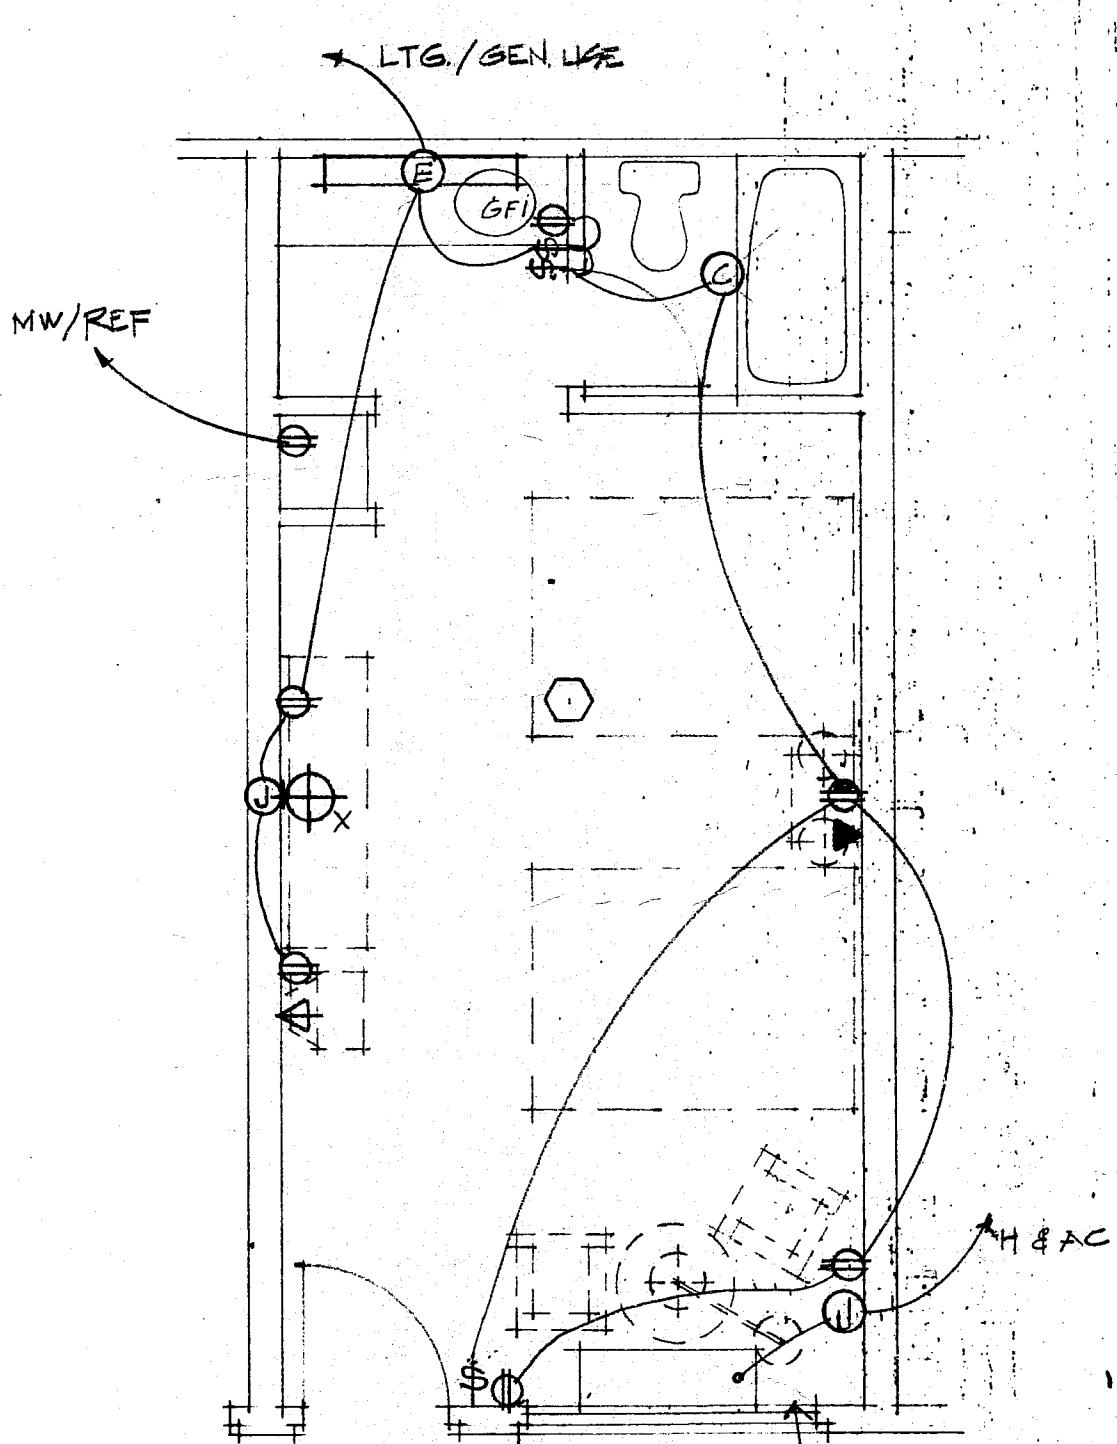

DOUBLE DOUBLE

SEE A.C. UNITS NOTE FOR PLUG-IN OPTION (CTIP)

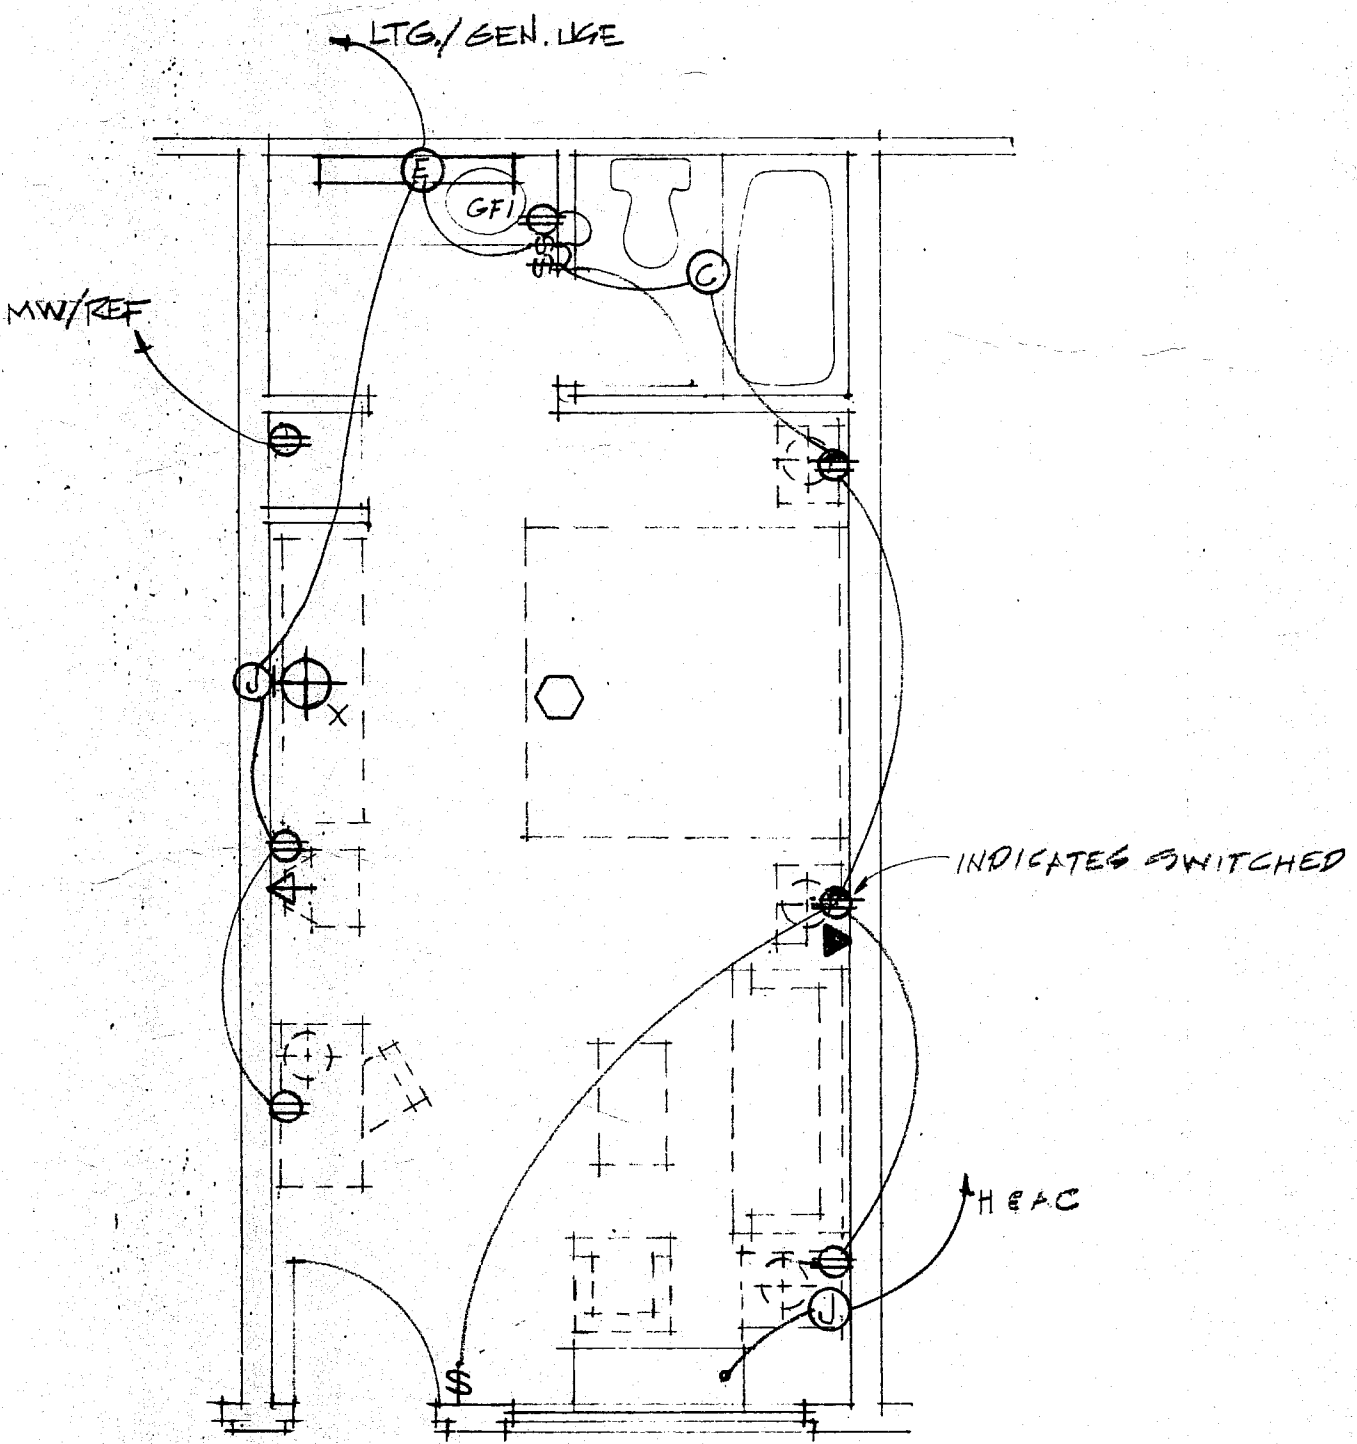

KING STUDY

LARGE SCALE R.U. ELECTRICAL PLANS (TYP)

SCALE 1/4" = 1'-0"

BEST WESTERN
PEARL, MS

DESIGN CONSORTIUM
HOTEL CONSULTANTS
MEMPHIS, TENNESSEE

NOTES, SCHEDULES, PANEL
DETAILS & TYP. GUEST RMS

DATE
7/15/92

SCALE
E-4

JOB NO.

REV. 7-13-92