


1st FLOOR REFLECTED CEILING PLAN

SCALE: 3/32" = 1'-0"


- GENERAL NOTES:
1. VERIFY ALL FINISHES WITH ROOM FINISH SCHEDULE
 2. SEE ELECTRICAL PLANS FOR LIGHTING PLACEMENT AND LOCATIONS
 3. VERIFY ALL ACOUSTICAL TILE GRIDS WITH HVAC AND LIGHTING

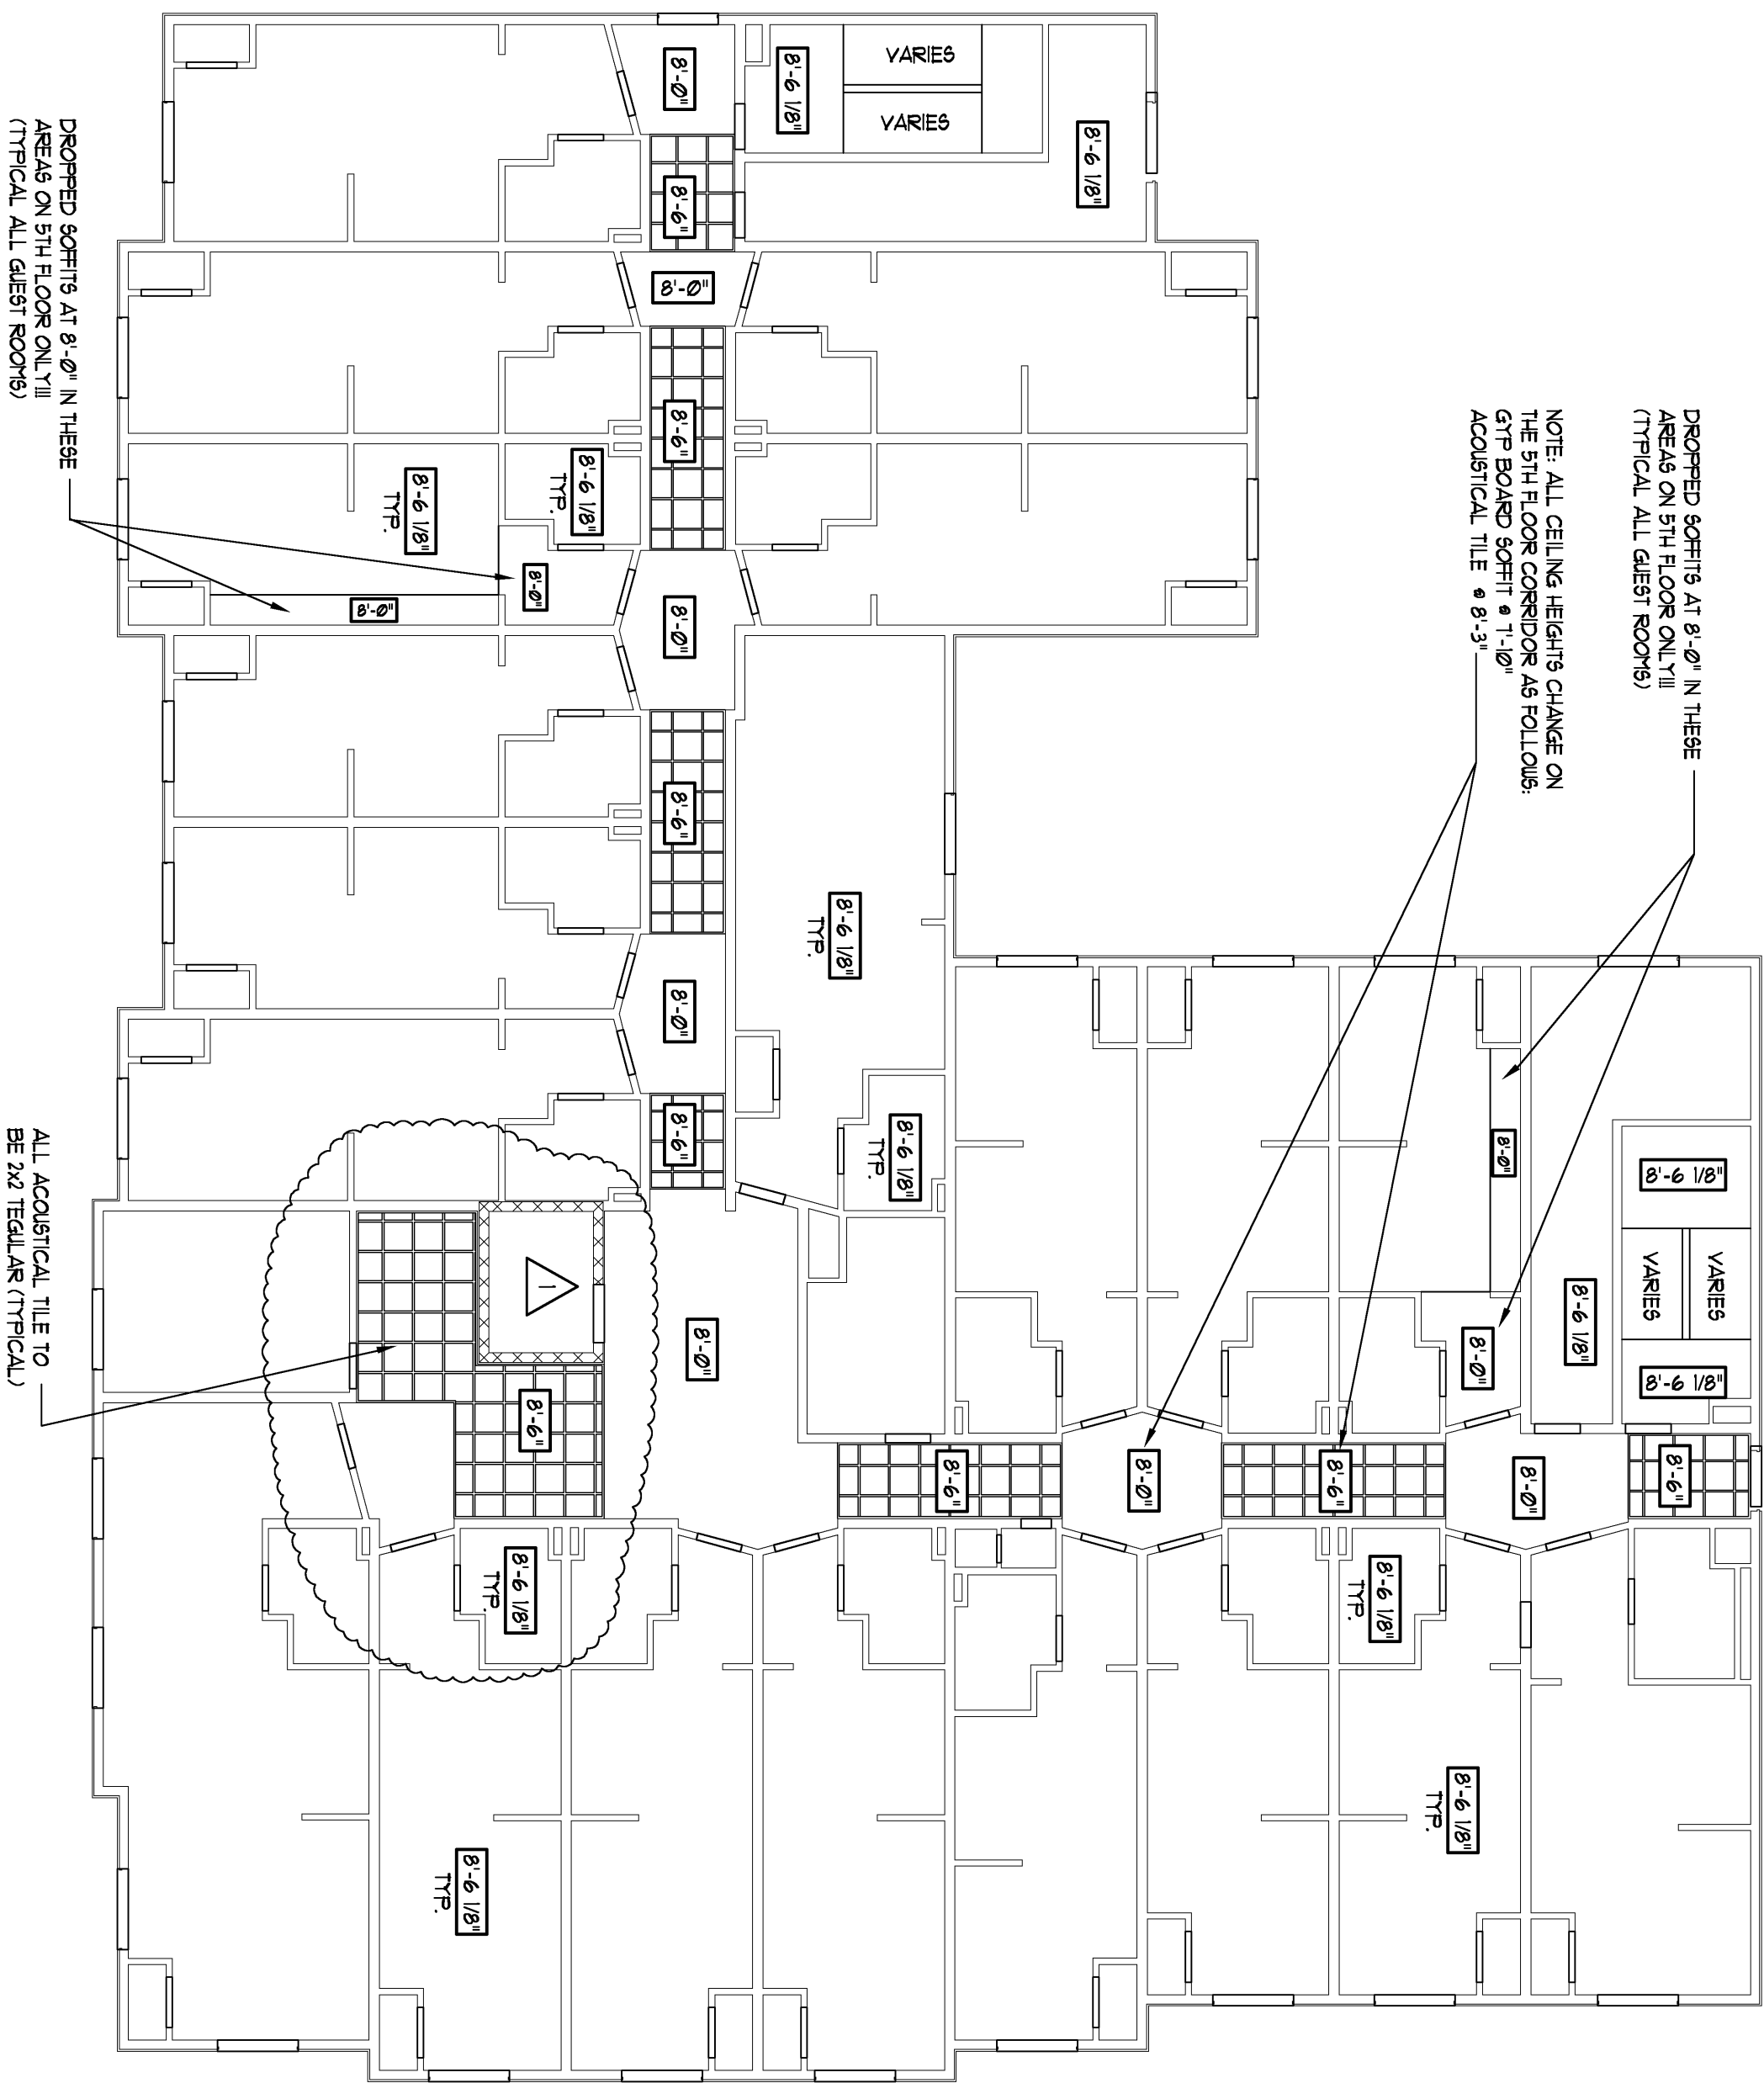

TYPICAL UPPER FLOOR REFLECTED CEILING PLAN

SCALE: 3/32" = 1'-0"

(THIRD FLOOR SHOW 2ND, 4TH & 5TH SIMILAR)

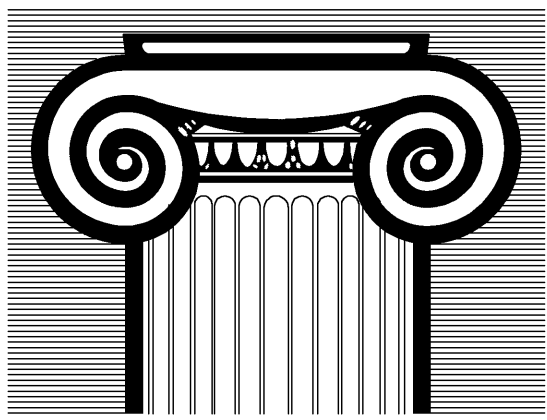


RICHARD F. STELDT
= ARCHITECT =
(262) 502-4500
N85 W16058 APPLETON AVE., MENOMONEE FALLS, WI 53051

Drawn: DDS
Approved:

3/15/08
REVISED PER APPROVAL

date	comments
12-14-07	Job: 2233-1107
12-14-07	Date: 12-14-07

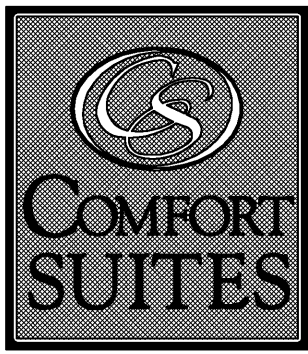

TO UNITS FLOWOOD, MS