



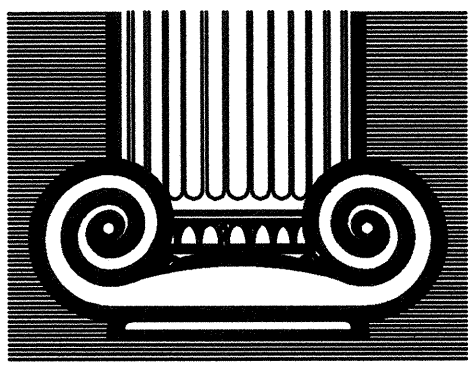

DRAWN:
APPROVED:


DATE COMMENTS
REVISIONS
JOB: 2233107
DATE: 12.14.07

FLOWOOD, MS

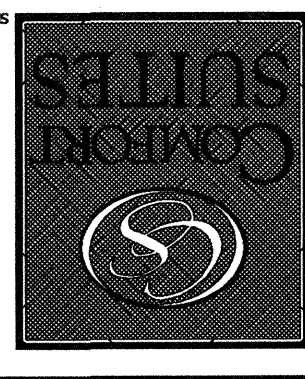


70 UNITS

SHEET
M2.0

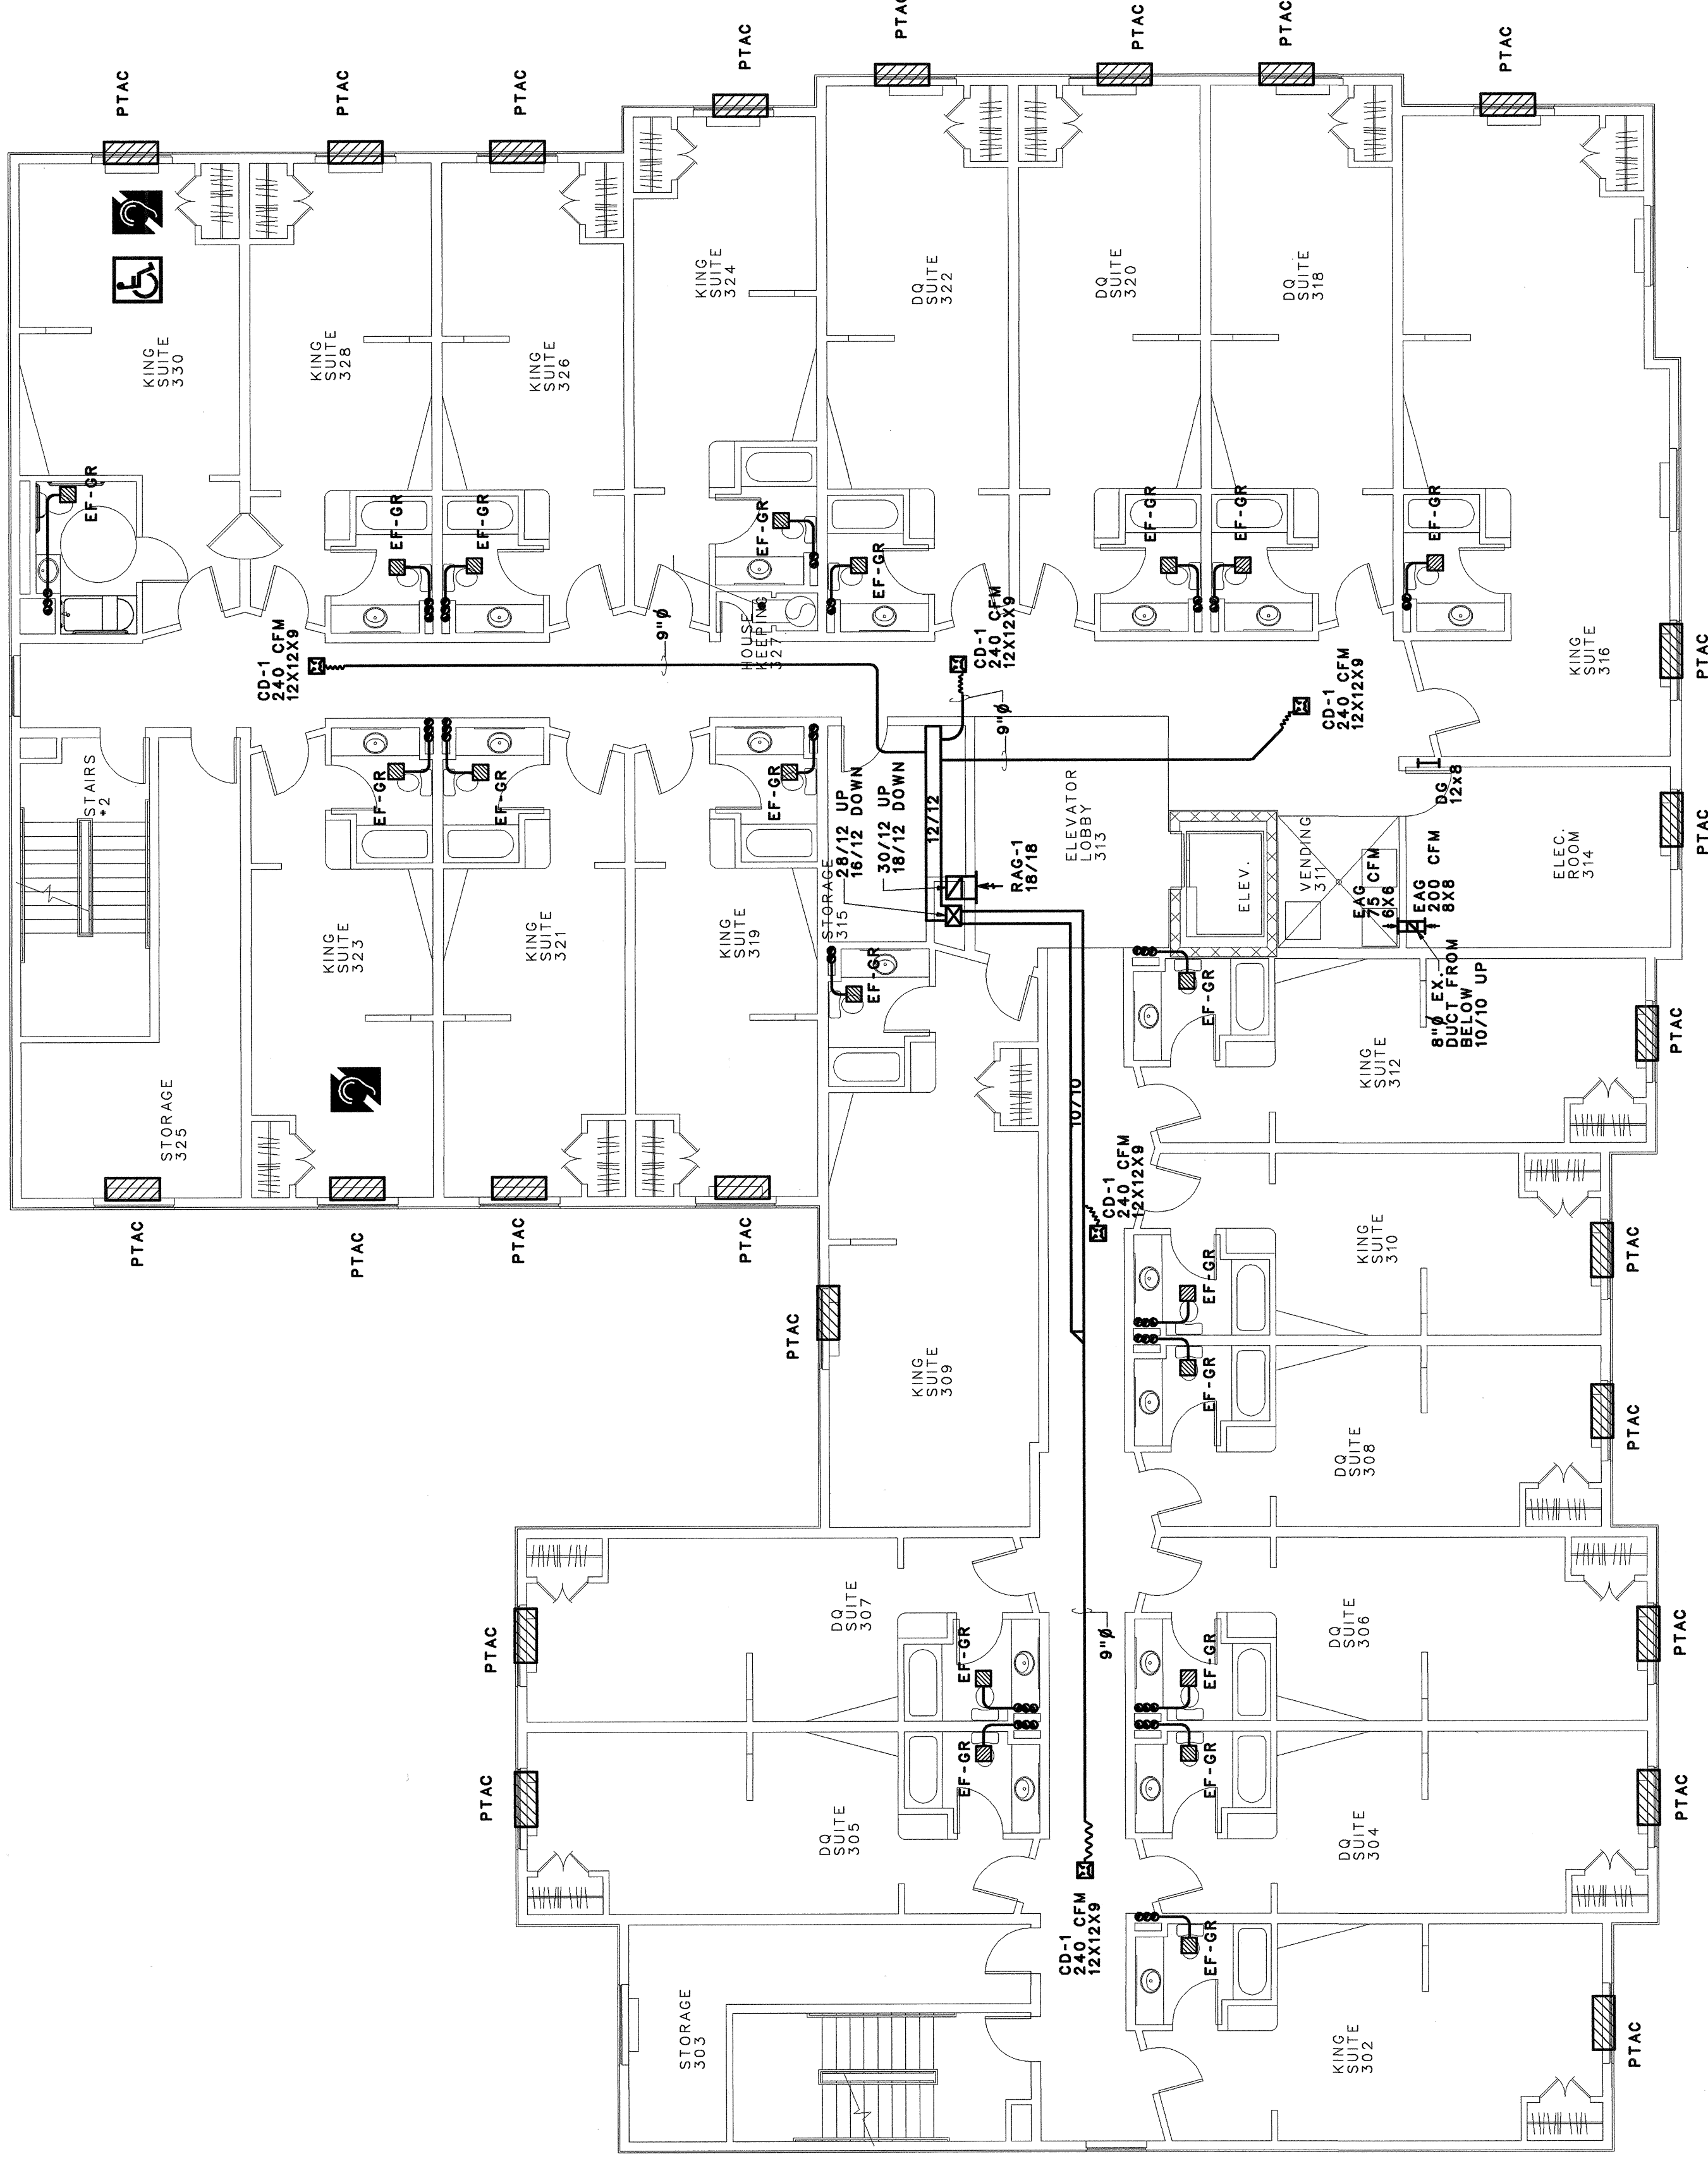

HVAC PLAN - THIRD FLOOR

SCALE: 1/8" = 1'-0"

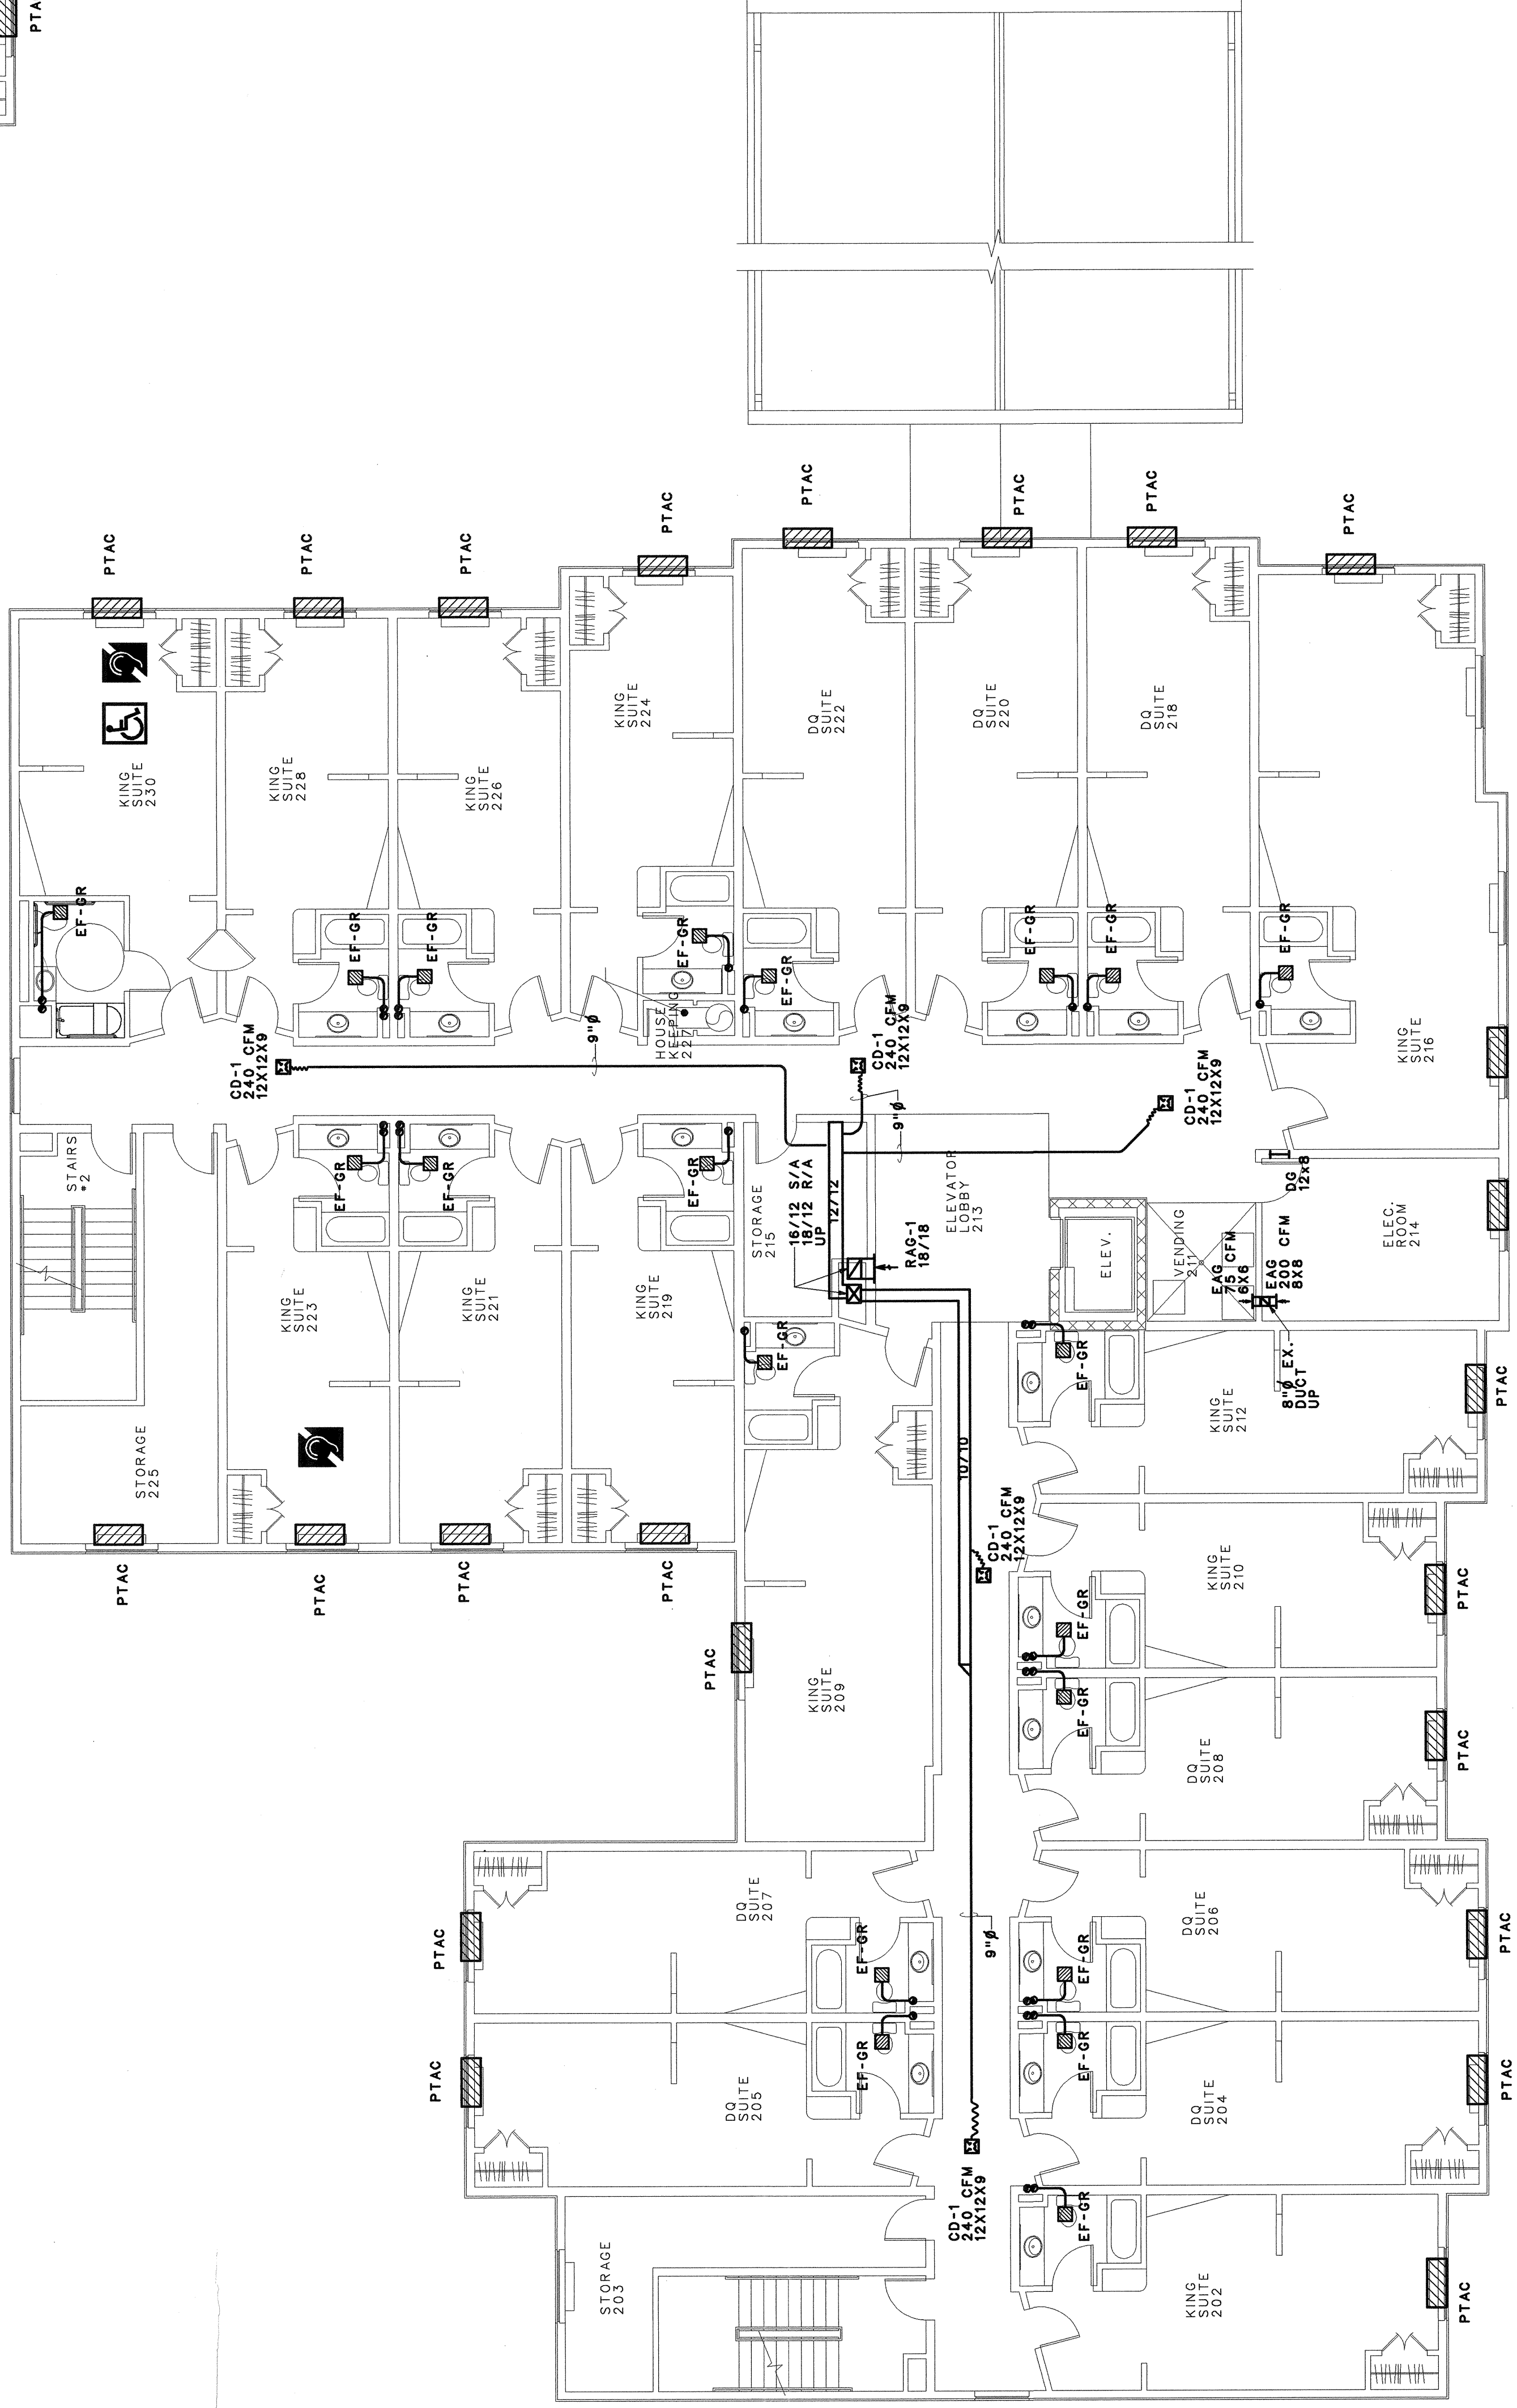

HVAC PLAN - SECOND FLOOR

SCALE: 1/8" = 1'-0"