



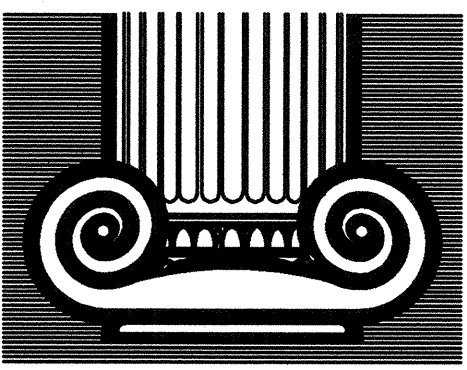

DRAWN:
APPROVED:


DATE COMMENTS
REVISIONS
JOB: 2223-107
DATE: 12-14-07

FLOWOOD, MS

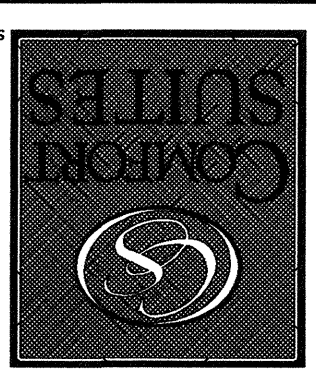


70 UNITS


SHEET
M3.0

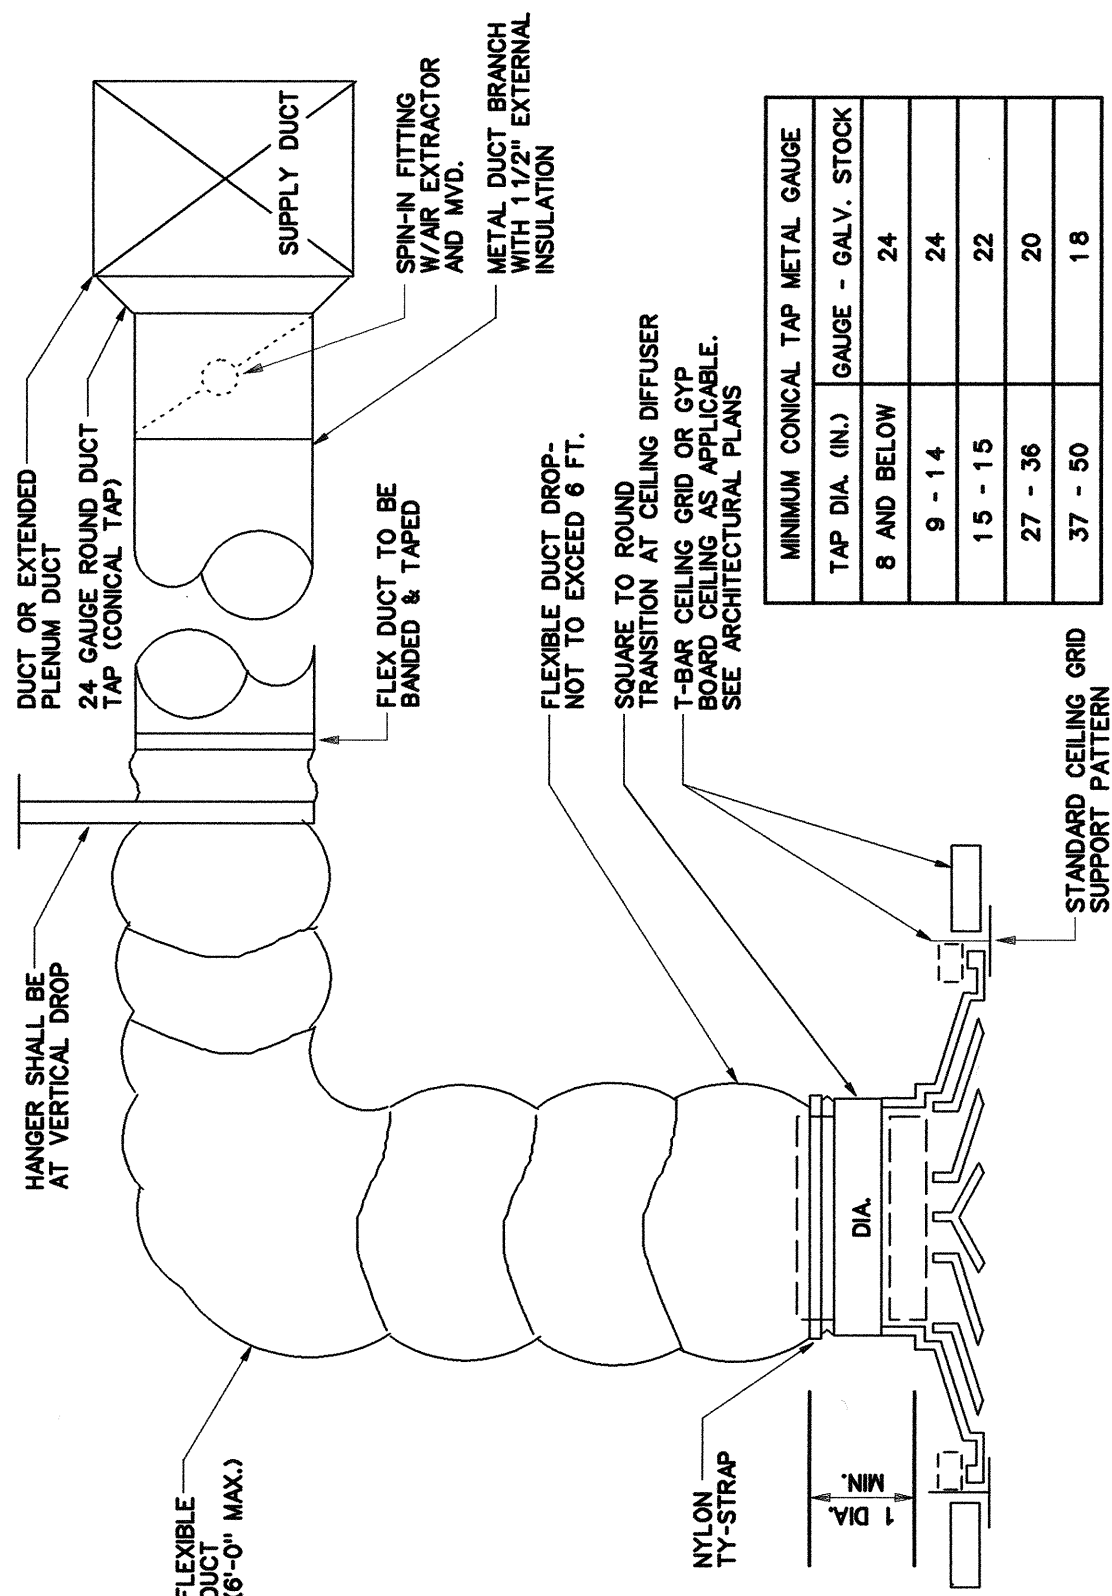


5 TYPICAL CEILING DIFFUSER DETAIL
N.T.S.

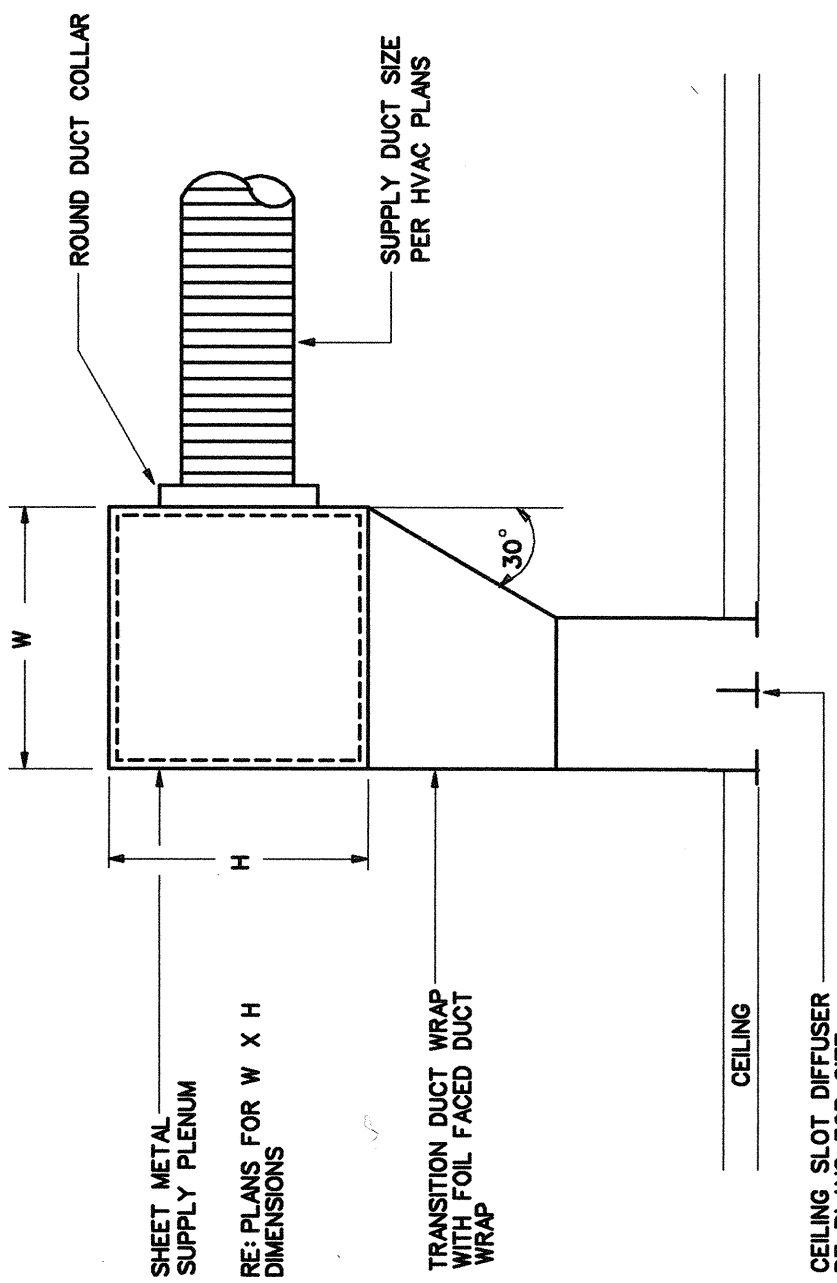


6 SLOT DIFFUSER INSTALLATION DETAIL
N.T.S.

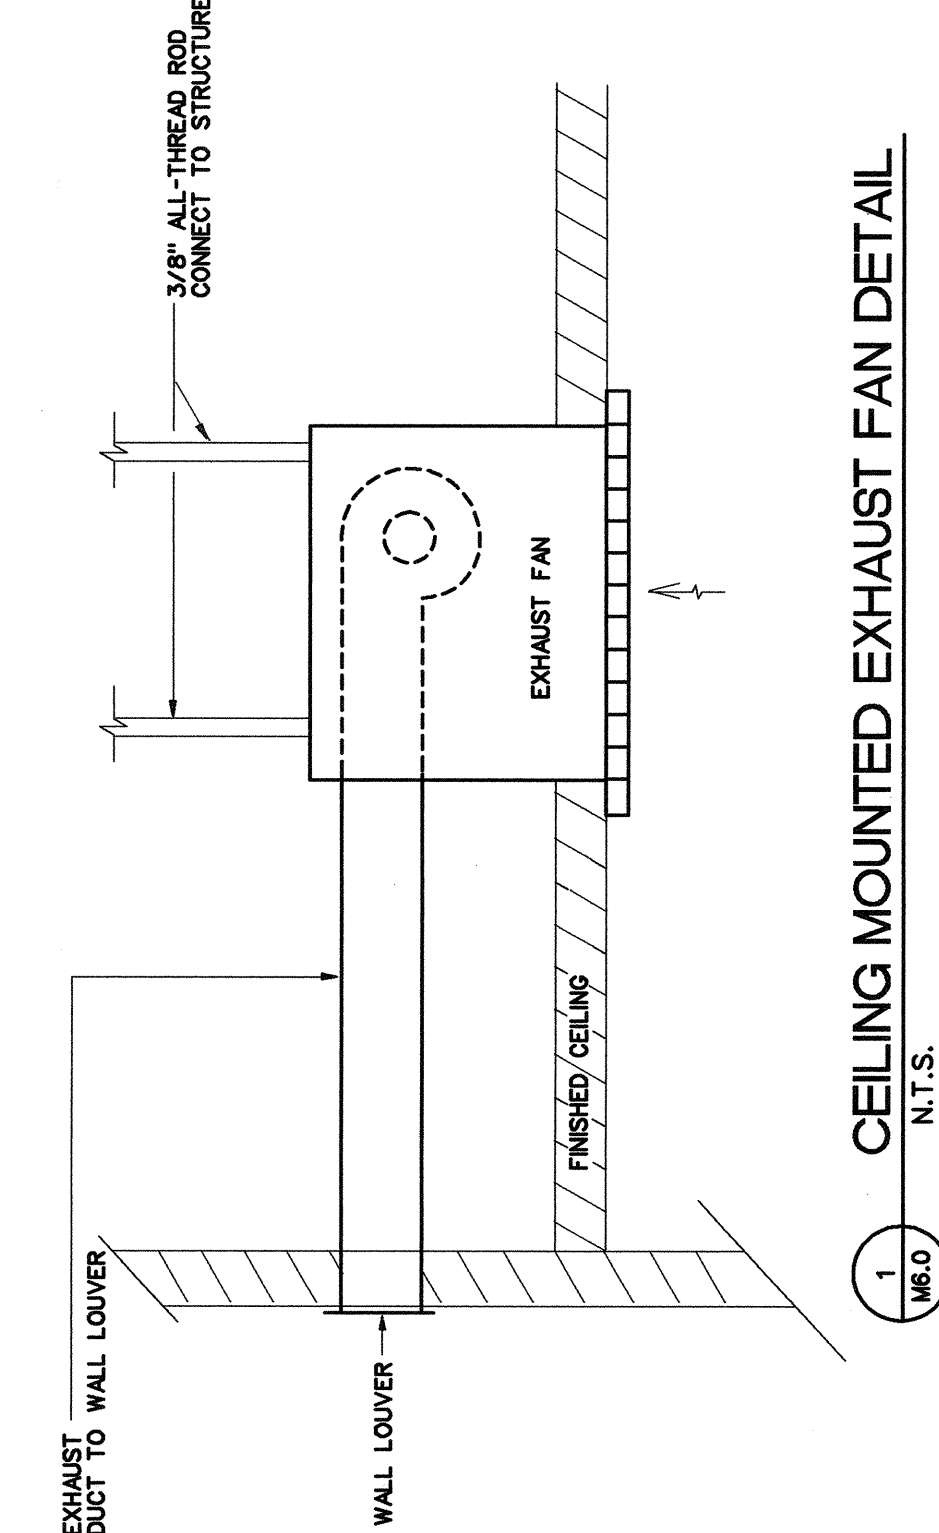


1 CEILING MOUNTED EXHAUST FAN DETAIL
N.T.S.

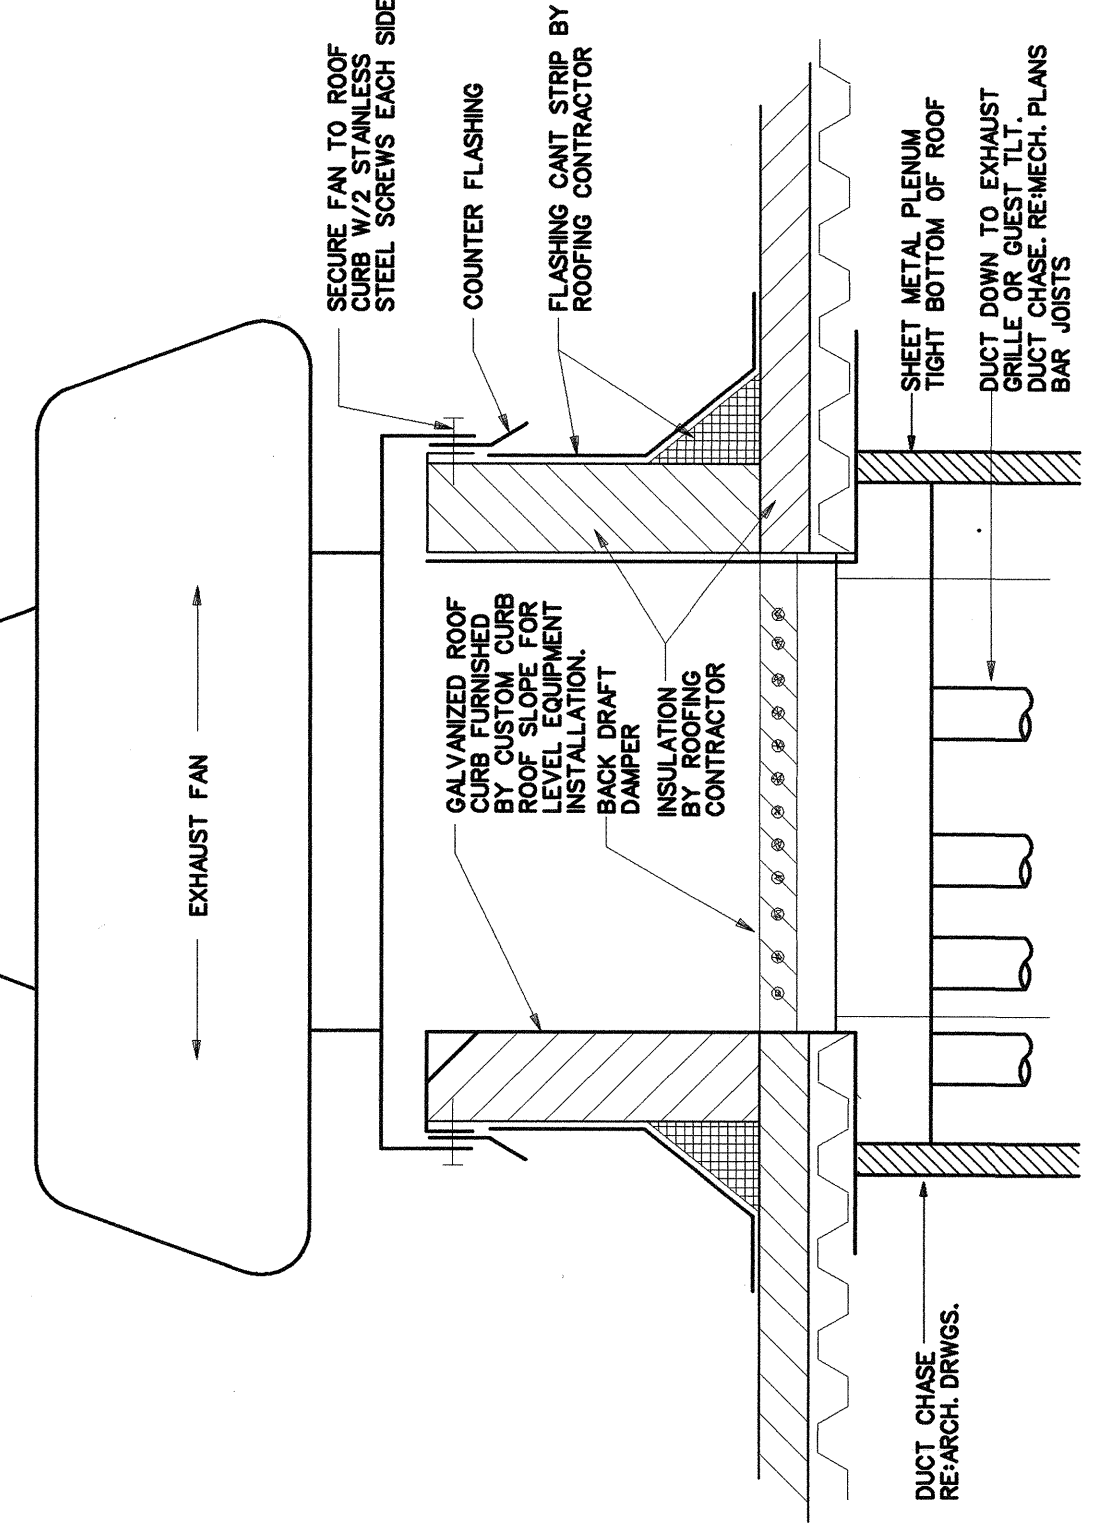


2 ROOF EXHAUST FAN INSTALLATION DETAIL (FLAT ROOF)
N.T.S.

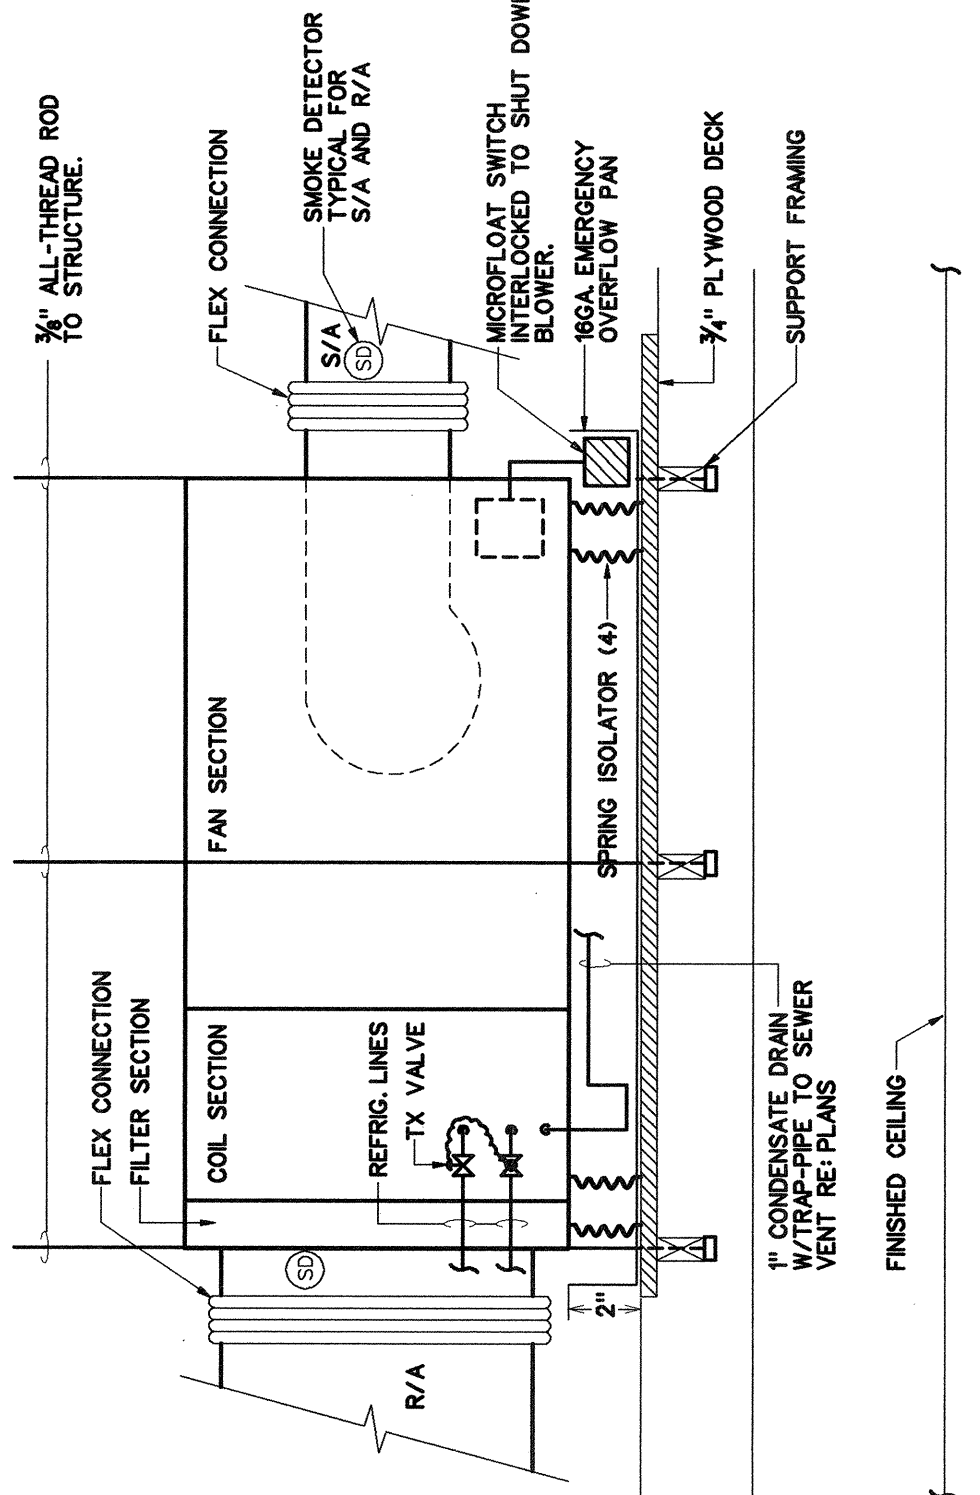

3 AHU ON PLATFORM W/ DRAIN PAN
N.T.S.

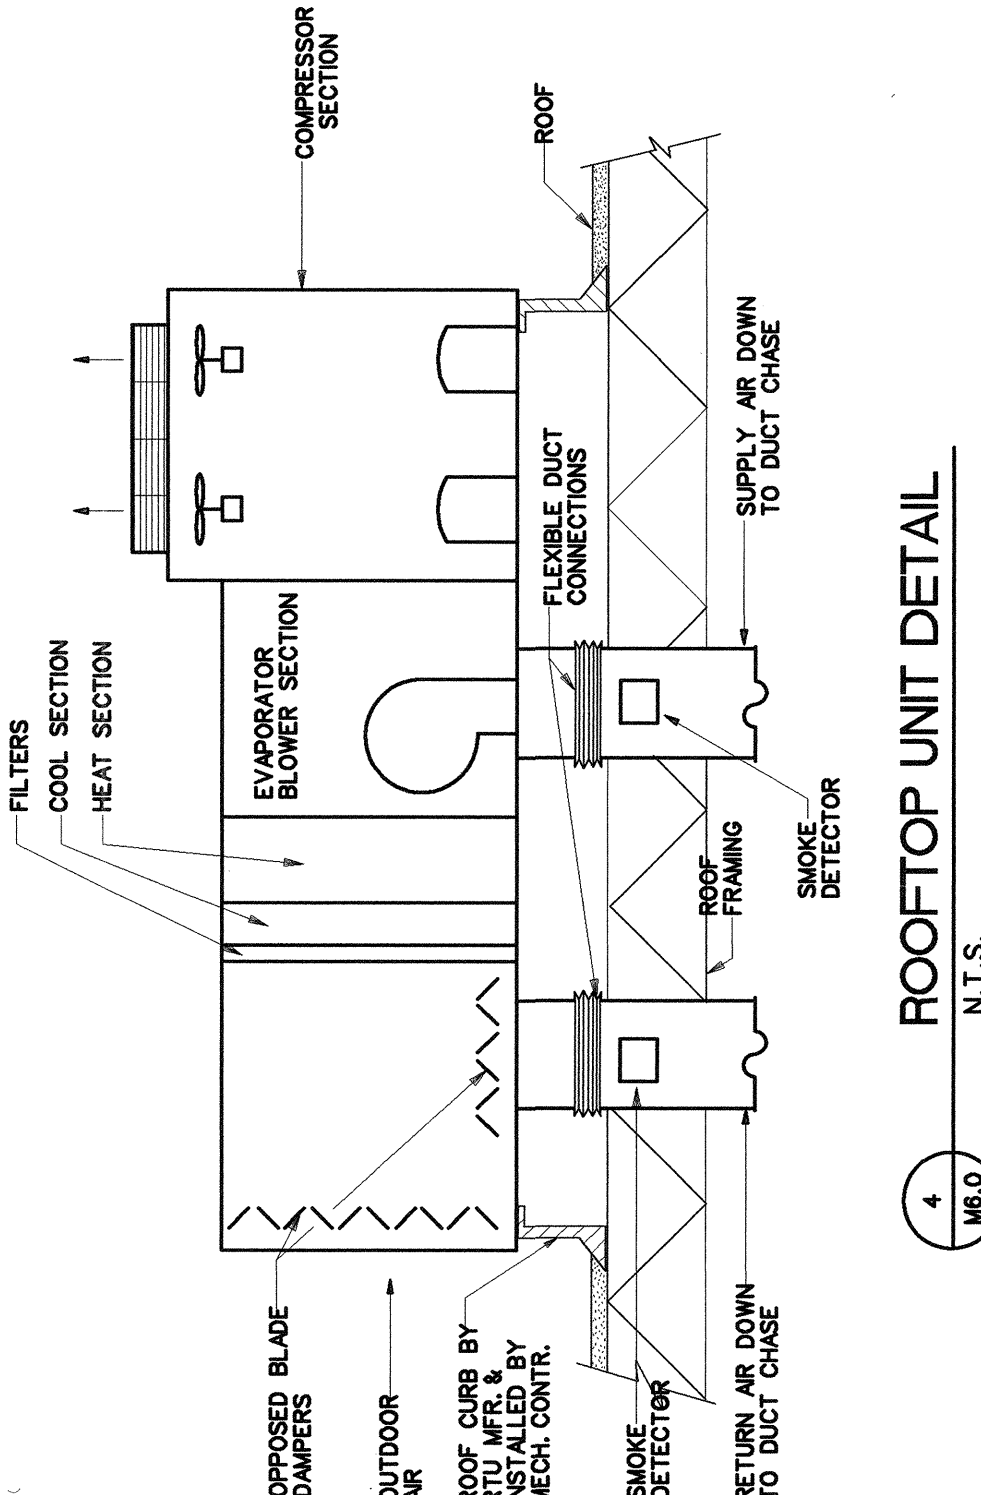

4 ROOFTOP UNIT DETAIL
N.T.S.

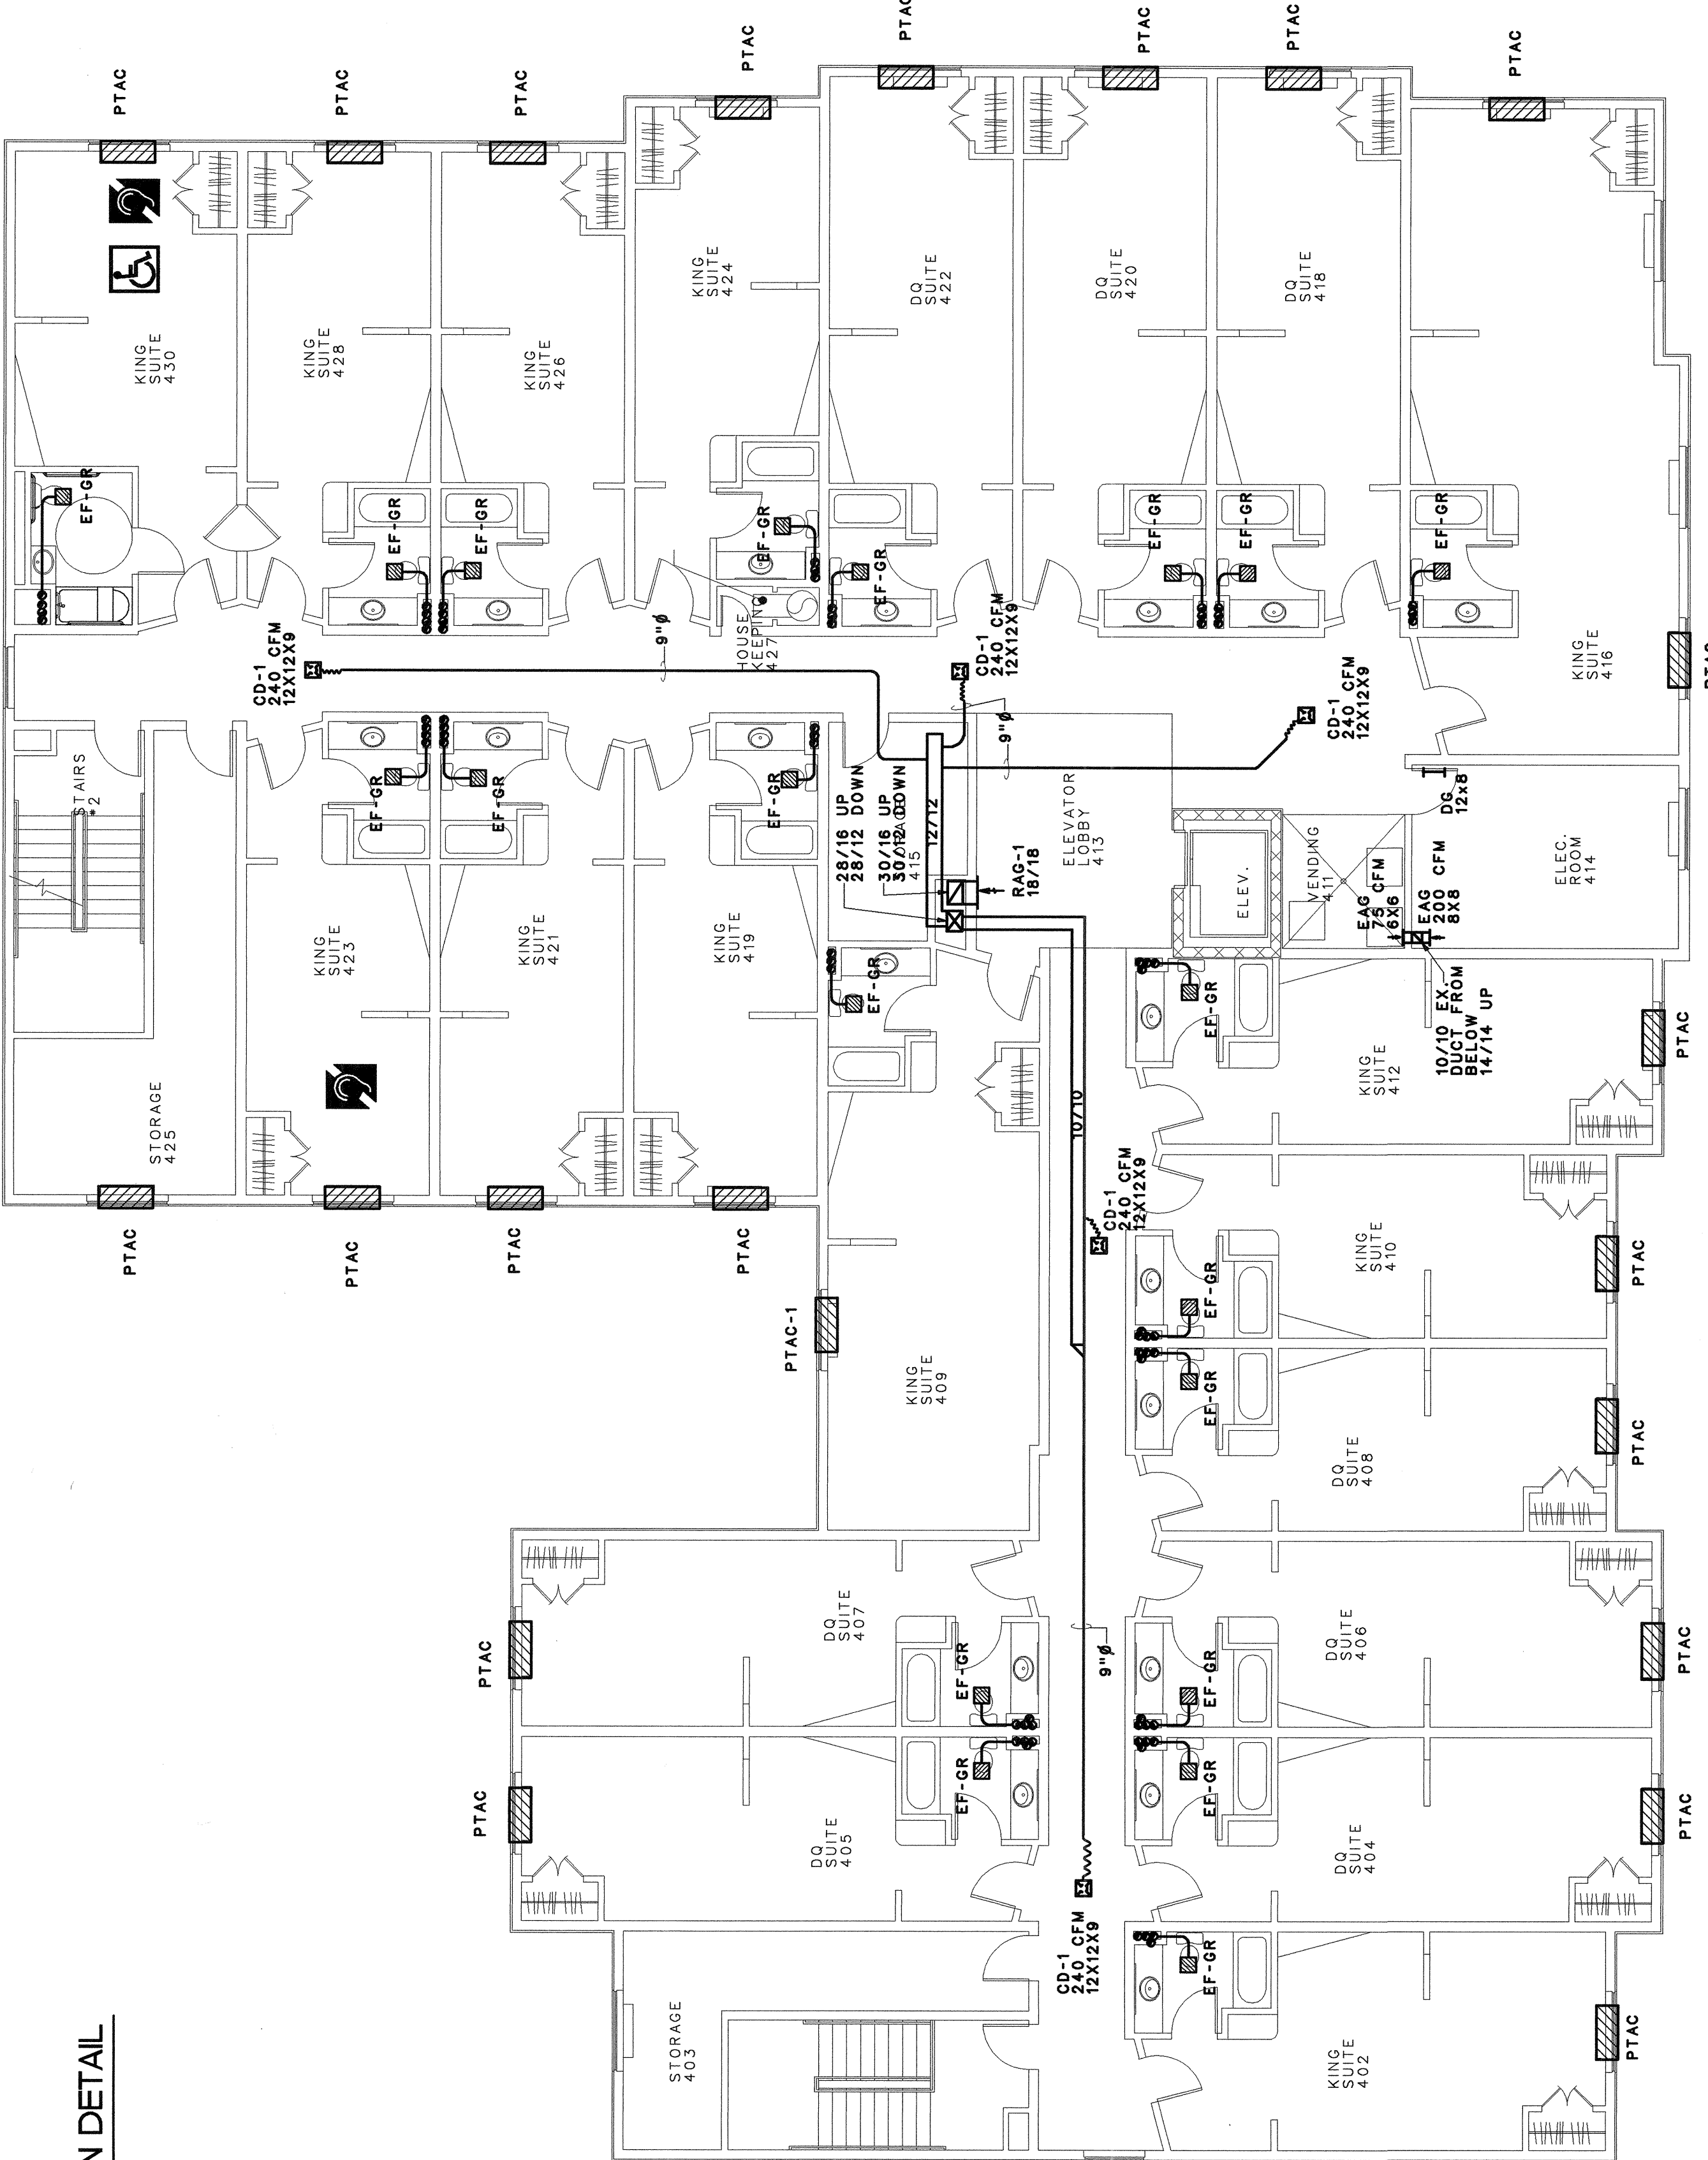

HVAC PLAN - FOURTH FLOOR
SCALE: 1/4" = 1'-0"