



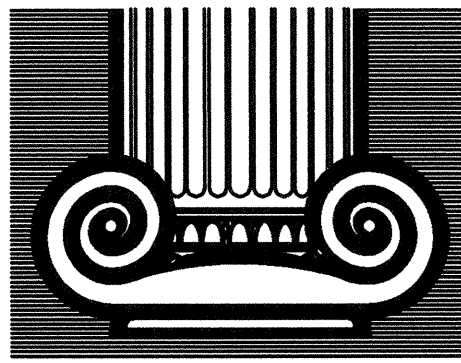

DRAWN:
APPROVED:

DATE COMMENTS
REVISIONS
JOB# 2293-1107
DATE 12-14-07


FLOWOOD, MS

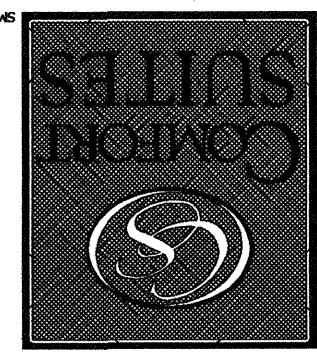


70 UNITS

SHEET
E1.0

FIRE ALARM SYMBOL SCHEDULE	
①	WALL MOUNTED SMOKE DETECTOR 8" BELOW FINISH CEILING
②	CEILING MOUNTED SMOKE DETECTOR
③	CEILING MOUNTED SMOKE DETECTOR
④	CEILING MOUNTED SMOKE DETECTOR
⑤	CEILING MOUNTED SMOKE DETECTOR
⑥	CEILING MOUNTED SMOKE DETECTOR
⑦	CEILING MOUNTED SMOKE DETECTOR
⑧	CEILING MOUNTED SMOKE DETECTOR
⑨	CEILING MOUNTED SMOKE DETECTOR
⑩	CEILING MOUNTED SMOKE DETECTOR
⑪	CEILING MOUNTED SMOKE DETECTOR
⑫	CEILING MOUNTED SMOKE DETECTOR
⑬	CEILING MOUNTED SMOKE DETECTOR
⑭	CEILING MOUNTED SMOKE DETECTOR
⑮	CEILING MOUNTED SMOKE DETECTOR
⑯	CEILING MOUNTED SMOKE DETECTOR
⑰	CEILING MOUNTED SMOKE DETECTOR
⑱	CEILING MOUNTED SMOKE DETECTOR
⑲	CEILING MOUNTED SMOKE DETECTOR
⑳	CEILING MOUNTED SMOKE DETECTOR
㉑	CEILING MOUNTED SMOKE DETECTOR
㉒	CEILING MOUNTED SMOKE DETECTOR
㉓	CEILING MOUNTED SMOKE DETECTOR
㉔	CEILING MOUNTED SMOKE DETECTOR
㉕	CEILING MOUNTED SMOKE DETECTOR
㉖	CEILING MOUNTED SMOKE DETECTOR
㉗	CEILING MOUNTED SMOKE DETECTOR
㉘	CEILING MOUNTED SMOKE DETECTOR
㉙	CEILING MOUNTED SMOKE DETECTOR
㉚	CEILING MOUNTED SMOKE DETECTOR
㉛	CEILING MOUNTED SMOKE DETECTOR
㉜	CEILING MOUNTED SMOKE DETECTOR
㉝	CEILING MOUNTED SMOKE DETECTOR
㉞	CEILING MOUNTED SMOKE DETECTOR
㉟	CEILING MOUNTED SMOKE DETECTOR
㊱	CEILING MOUNTED SMOKE DETECTOR
㊲	CEILING MOUNTED SMOKE DETECTOR
㊳	CEILING MOUNTED SMOKE DETECTOR
㊴	CEILING MOUNTED SMOKE DETECTOR
㊵	CEILING MOUNTED SMOKE DETECTOR
㊶	CEILING MOUNTED SMOKE DETECTOR
㊷	CEILING MOUNTED SMOKE DETECTOR
㊸	CEILING MOUNTED SMOKE DETECTOR
㊹	CEILING MOUNTED SMOKE DETECTOR
㊺	CEILING MOUNTED SMOKE DETECTOR
㊻	CEILING MOUNTED SMOKE DETECTOR
㊼	CEILING MOUNTED SMOKE DETECTOR
㊽	CEILING MOUNTED SMOKE DETECTOR
㊾	CEILING MOUNTED SMOKE DETECTOR
㊿	CEILING MOUNTED SMOKE DETECTOR

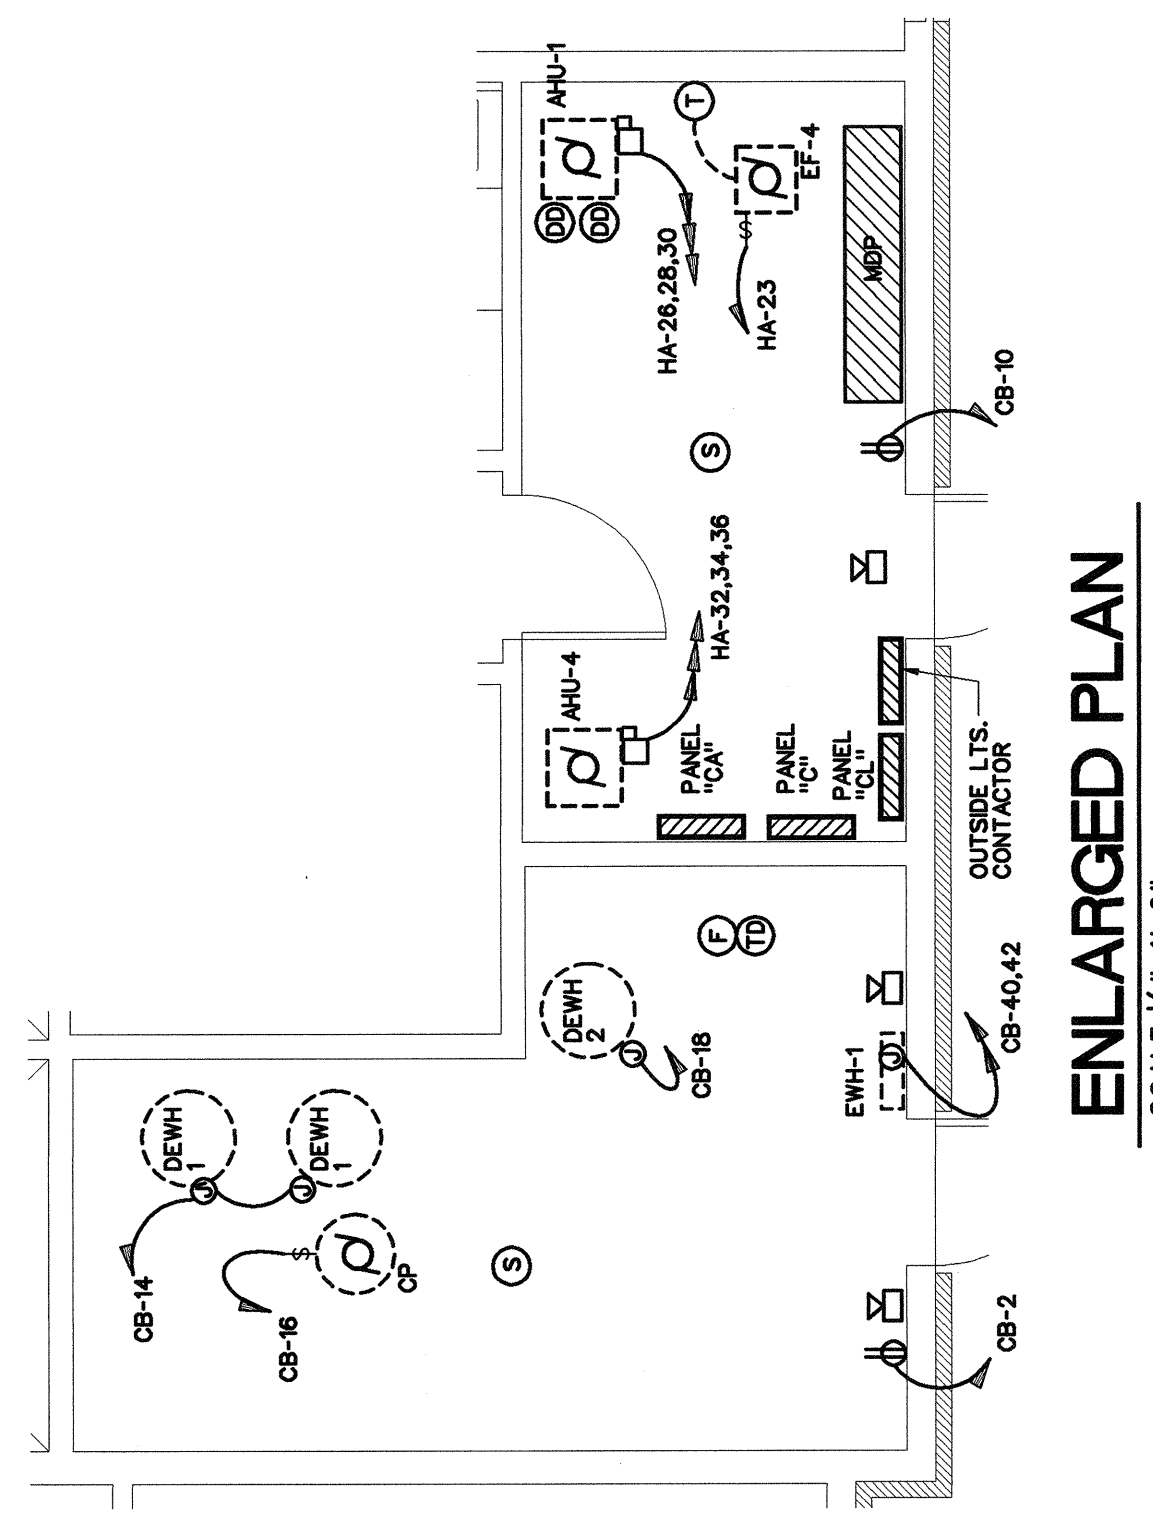

ENLARGED PLAN
SCALE 1/4" = 1'-0"

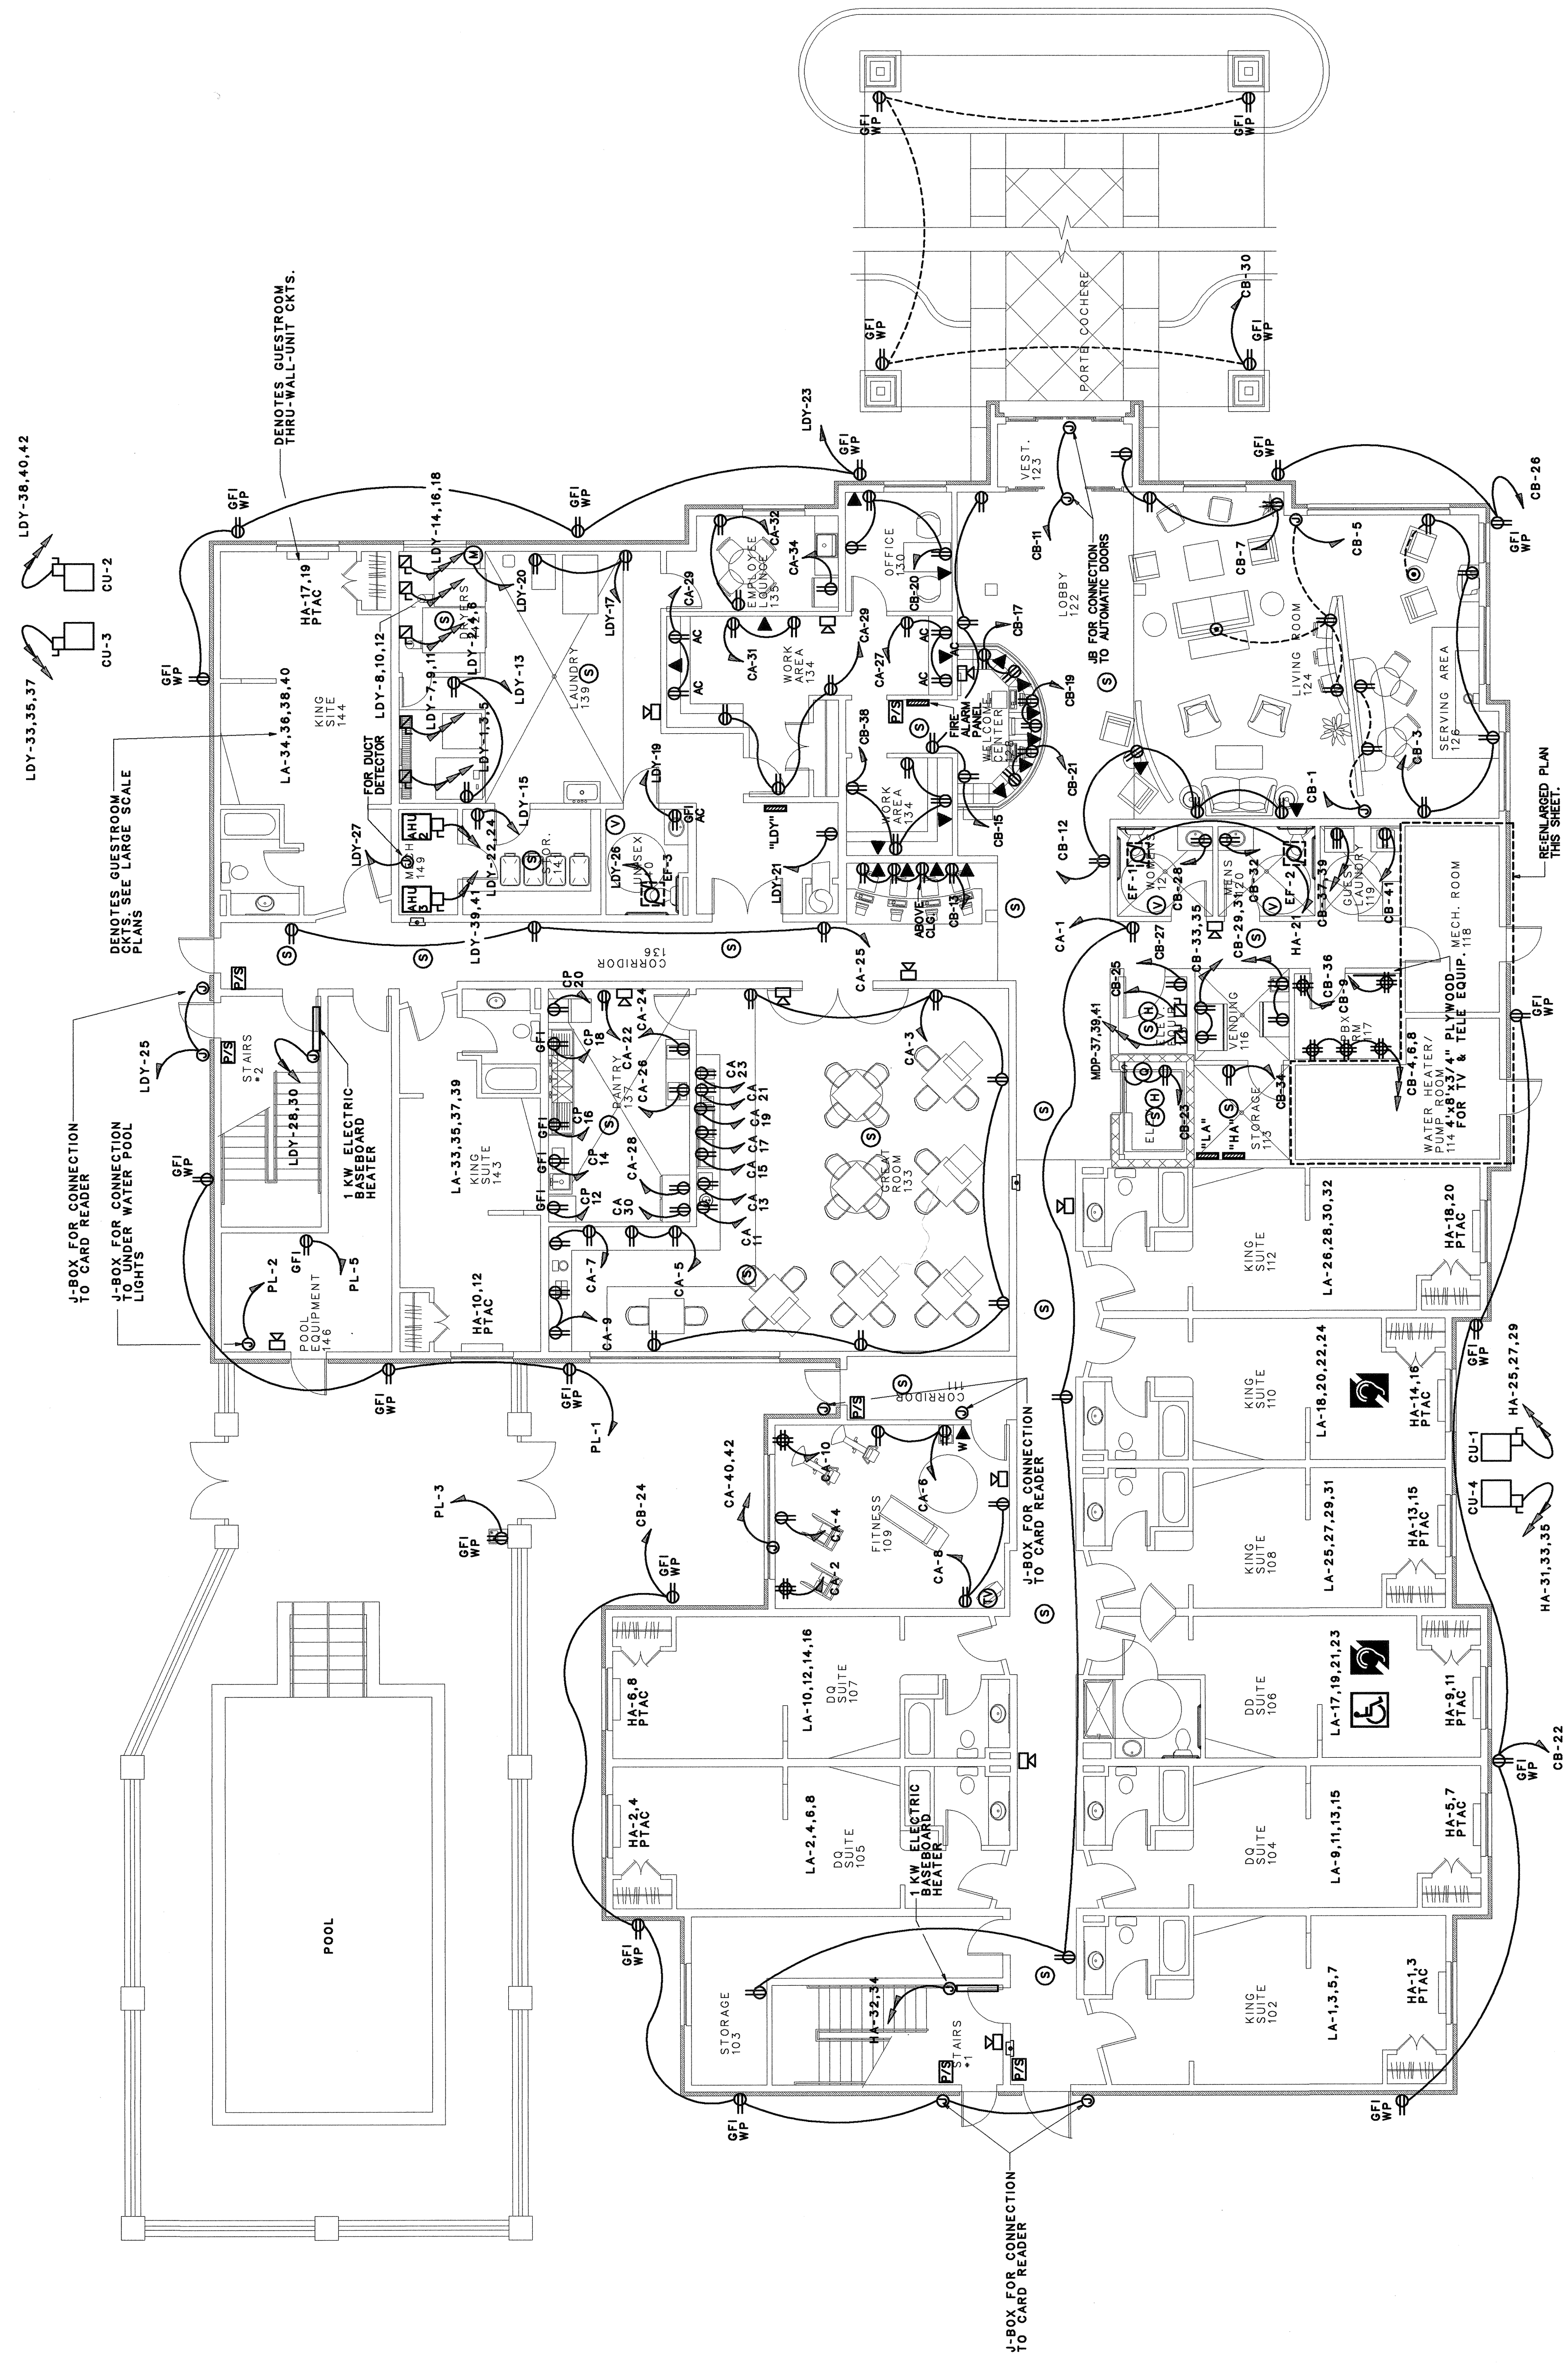

ELECTRICAL POWER PLAN- FIRST FLOOR
SCALE 1/8" = 1'-0"