


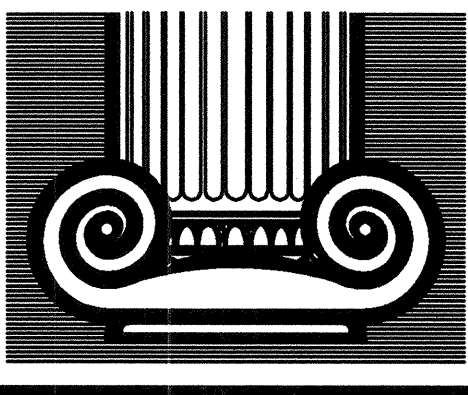


DRAWN:

APPROVED:

DATE COMMENTS  
REVISIONS  
JOB# 2232-1107  
DATE 12-14-07


FLOWOOD, MS

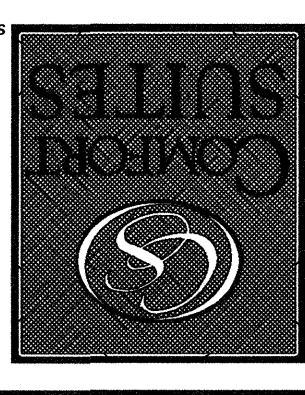


70 UNITS

SHEET

E20

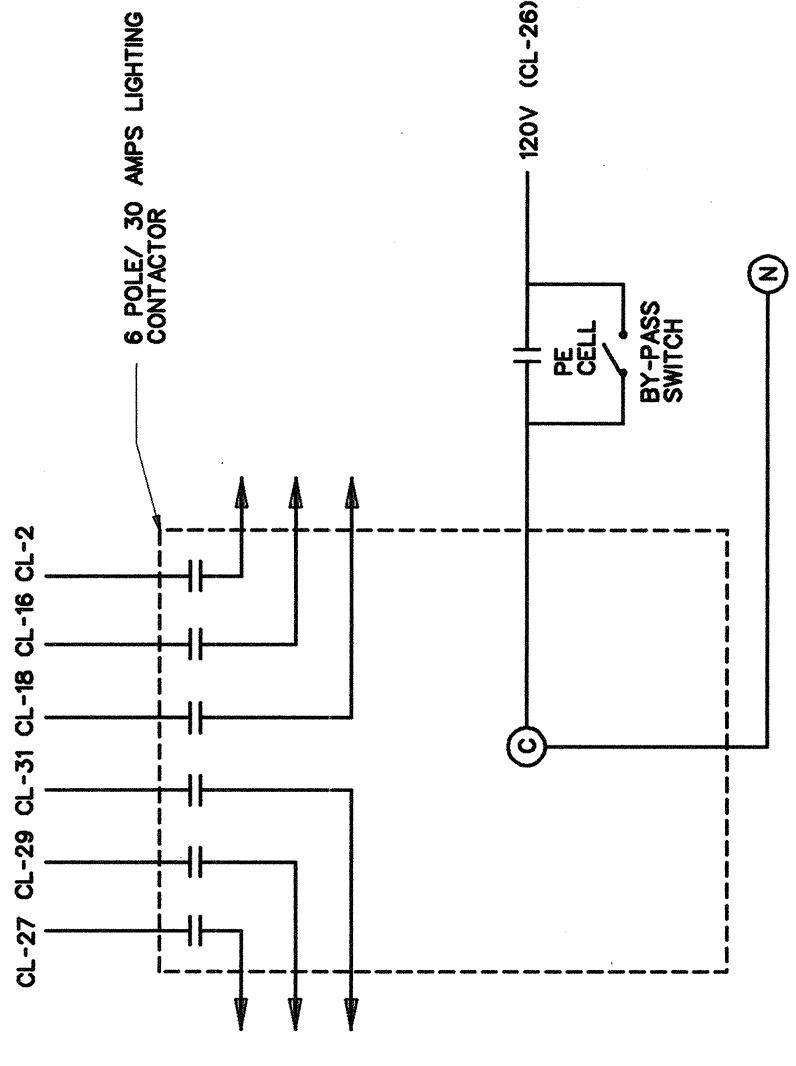

OUTSIDE LIGHTING CONTROL  
N.T.S.

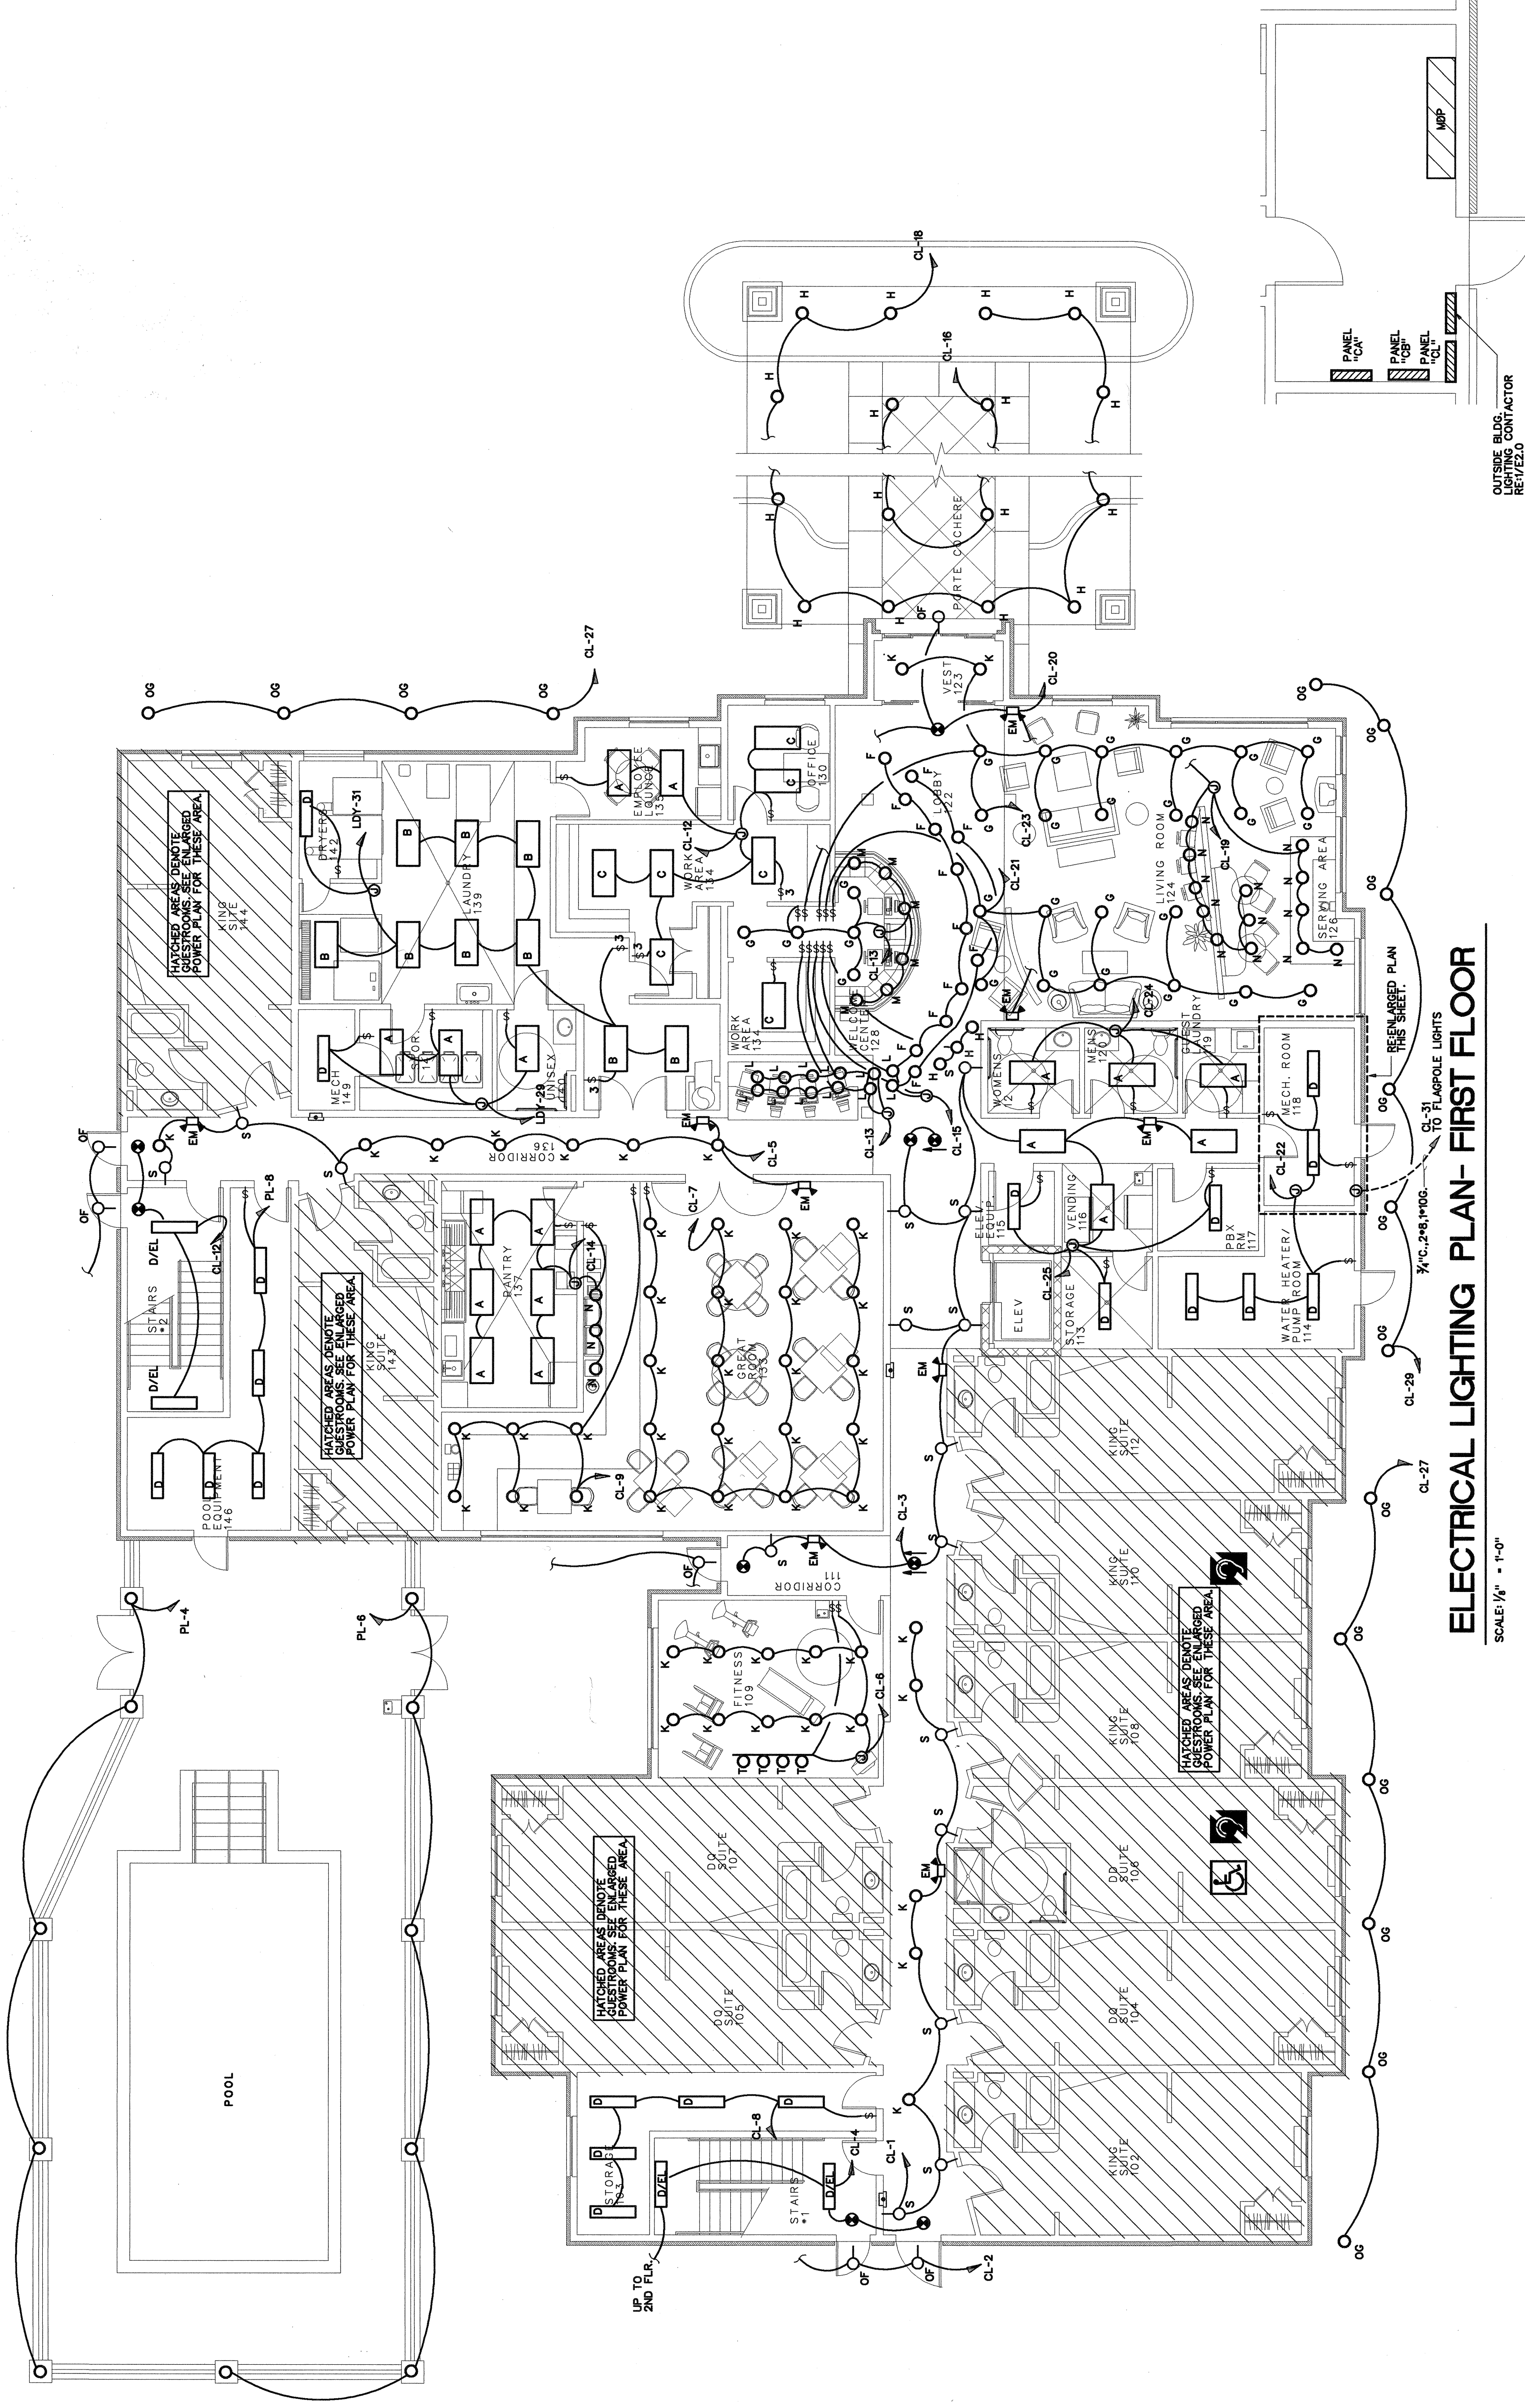

ELECTRICAL LIGHTING PLAN- FIRST FLOOR  
SCALE 1/8" = 1'-0"

ENLARGED MECH. ROOM  
SCALE 1/4" = 1'-0"

OUTSIDE LIGHTING CONTROL  
REV 1/2/07