



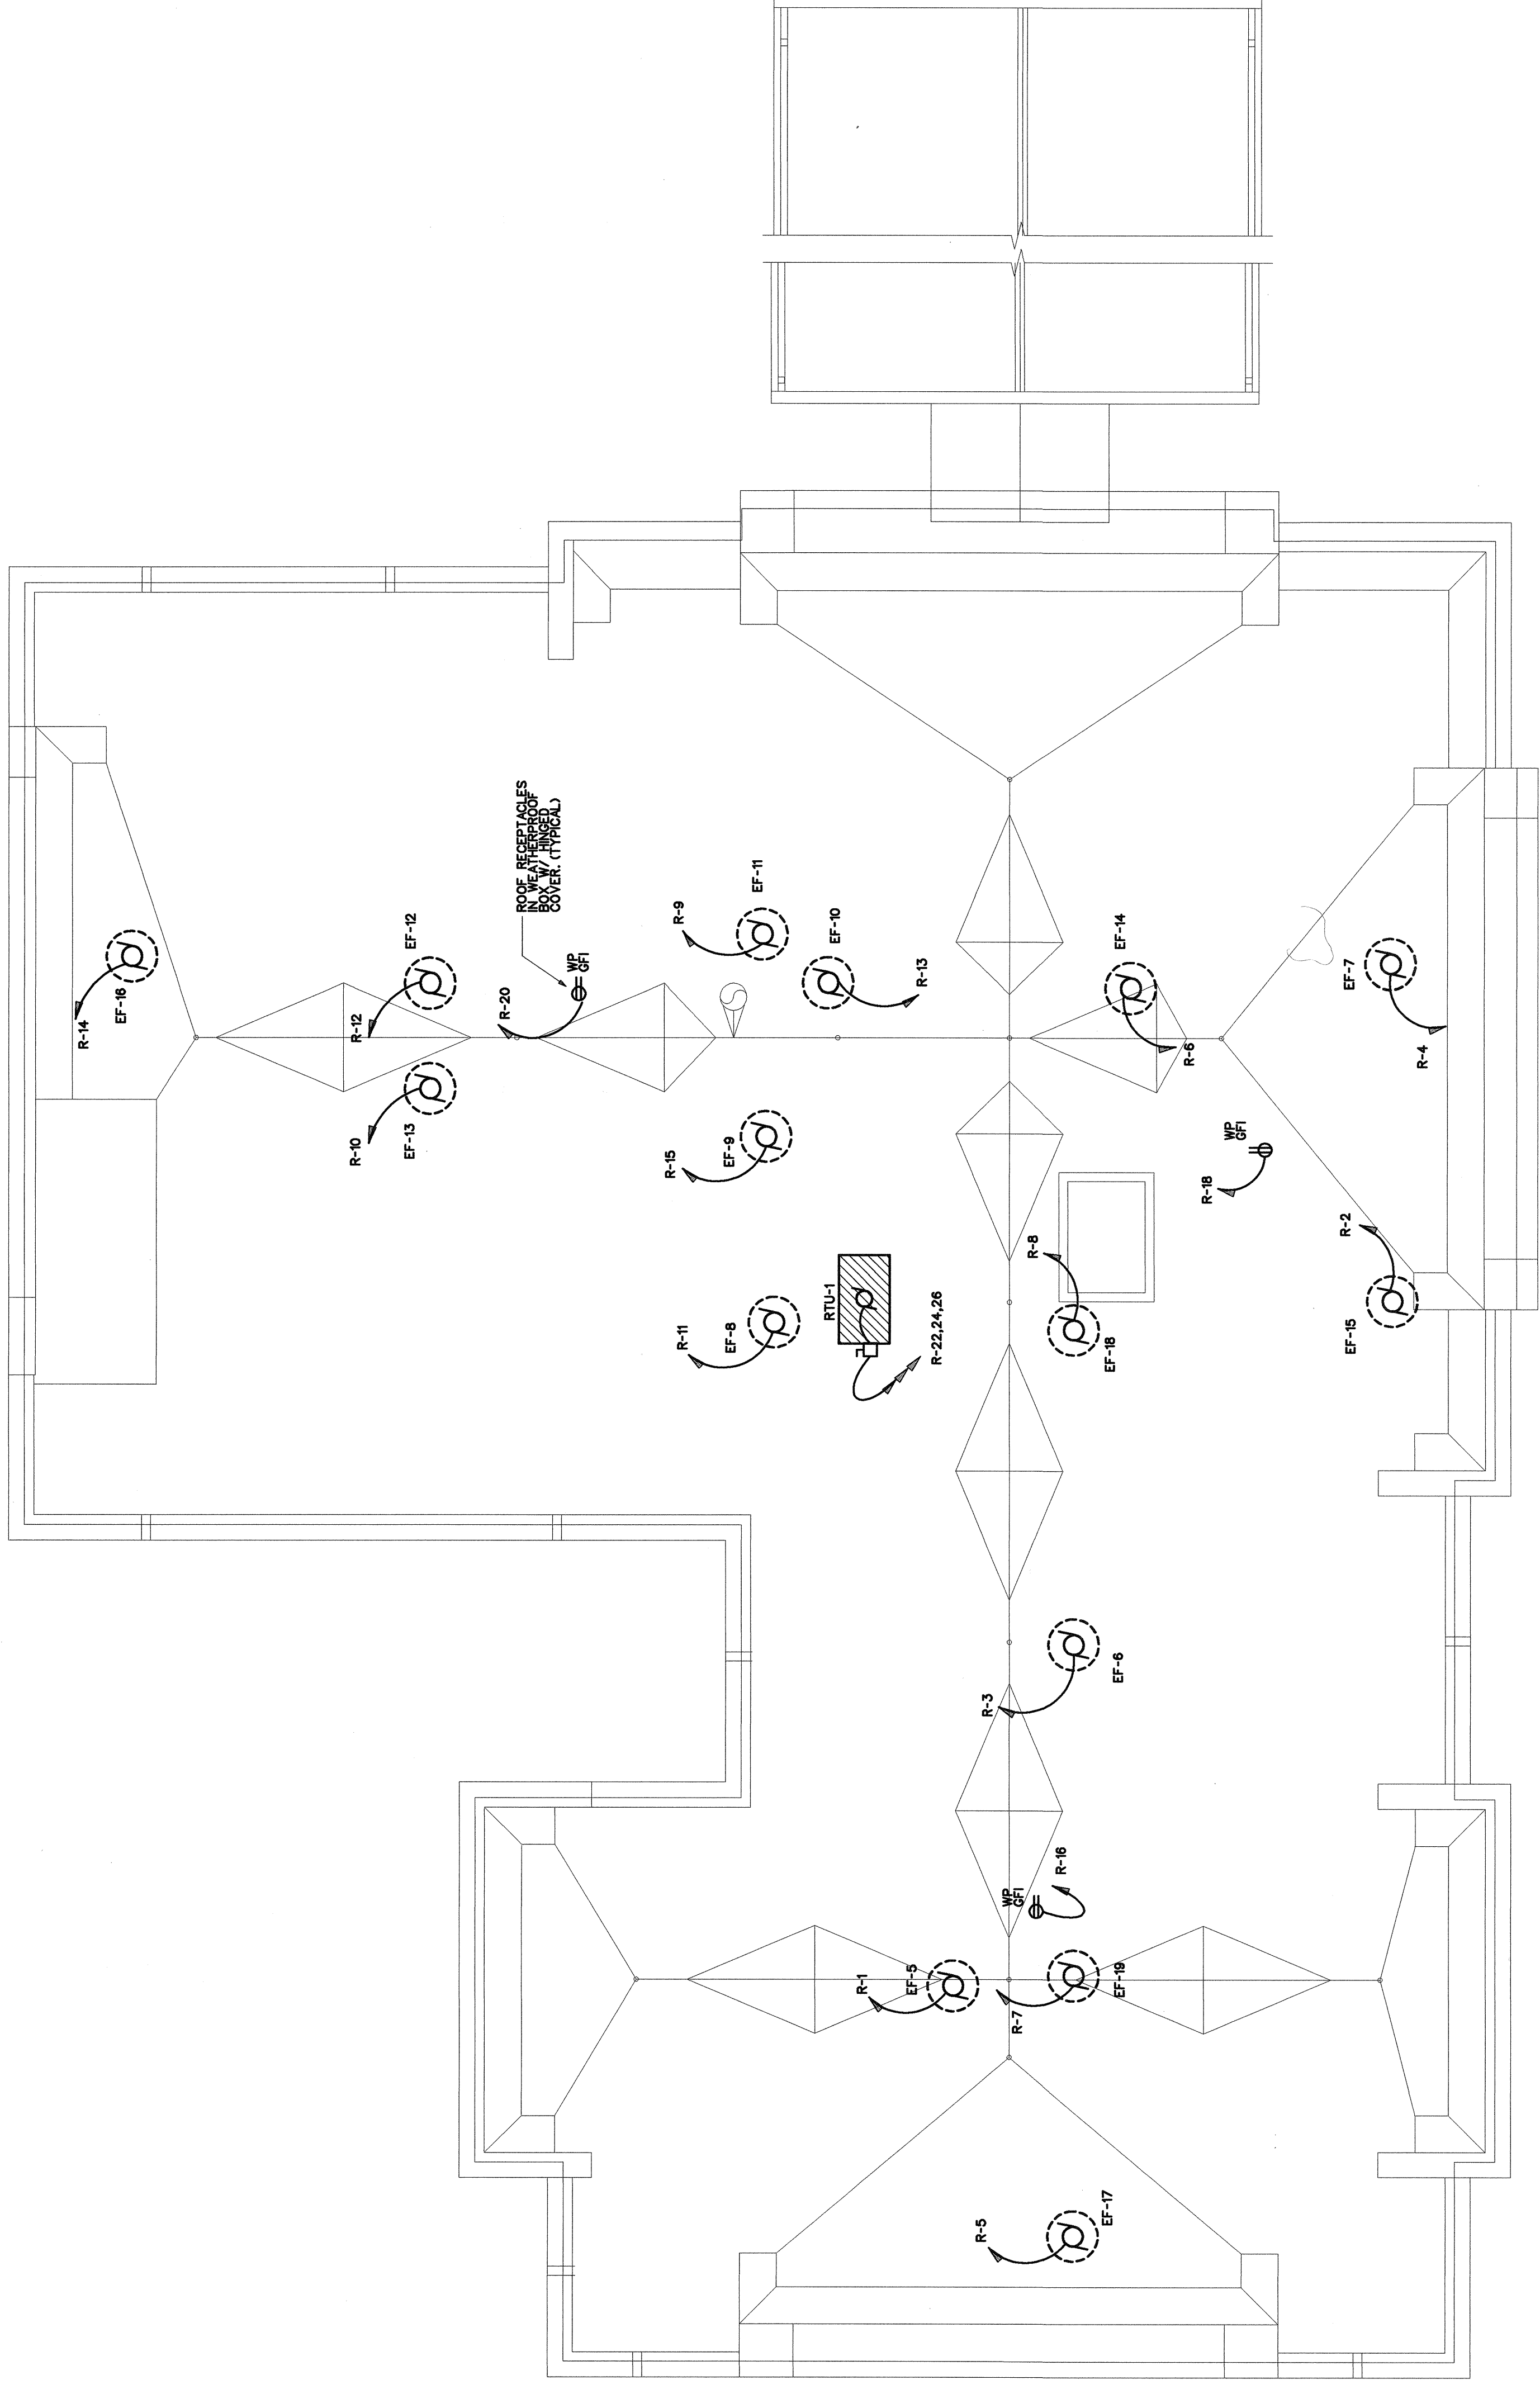

ELECTRICAL PLAN - ROOF

SCALE: 1/8" = 1'-0"

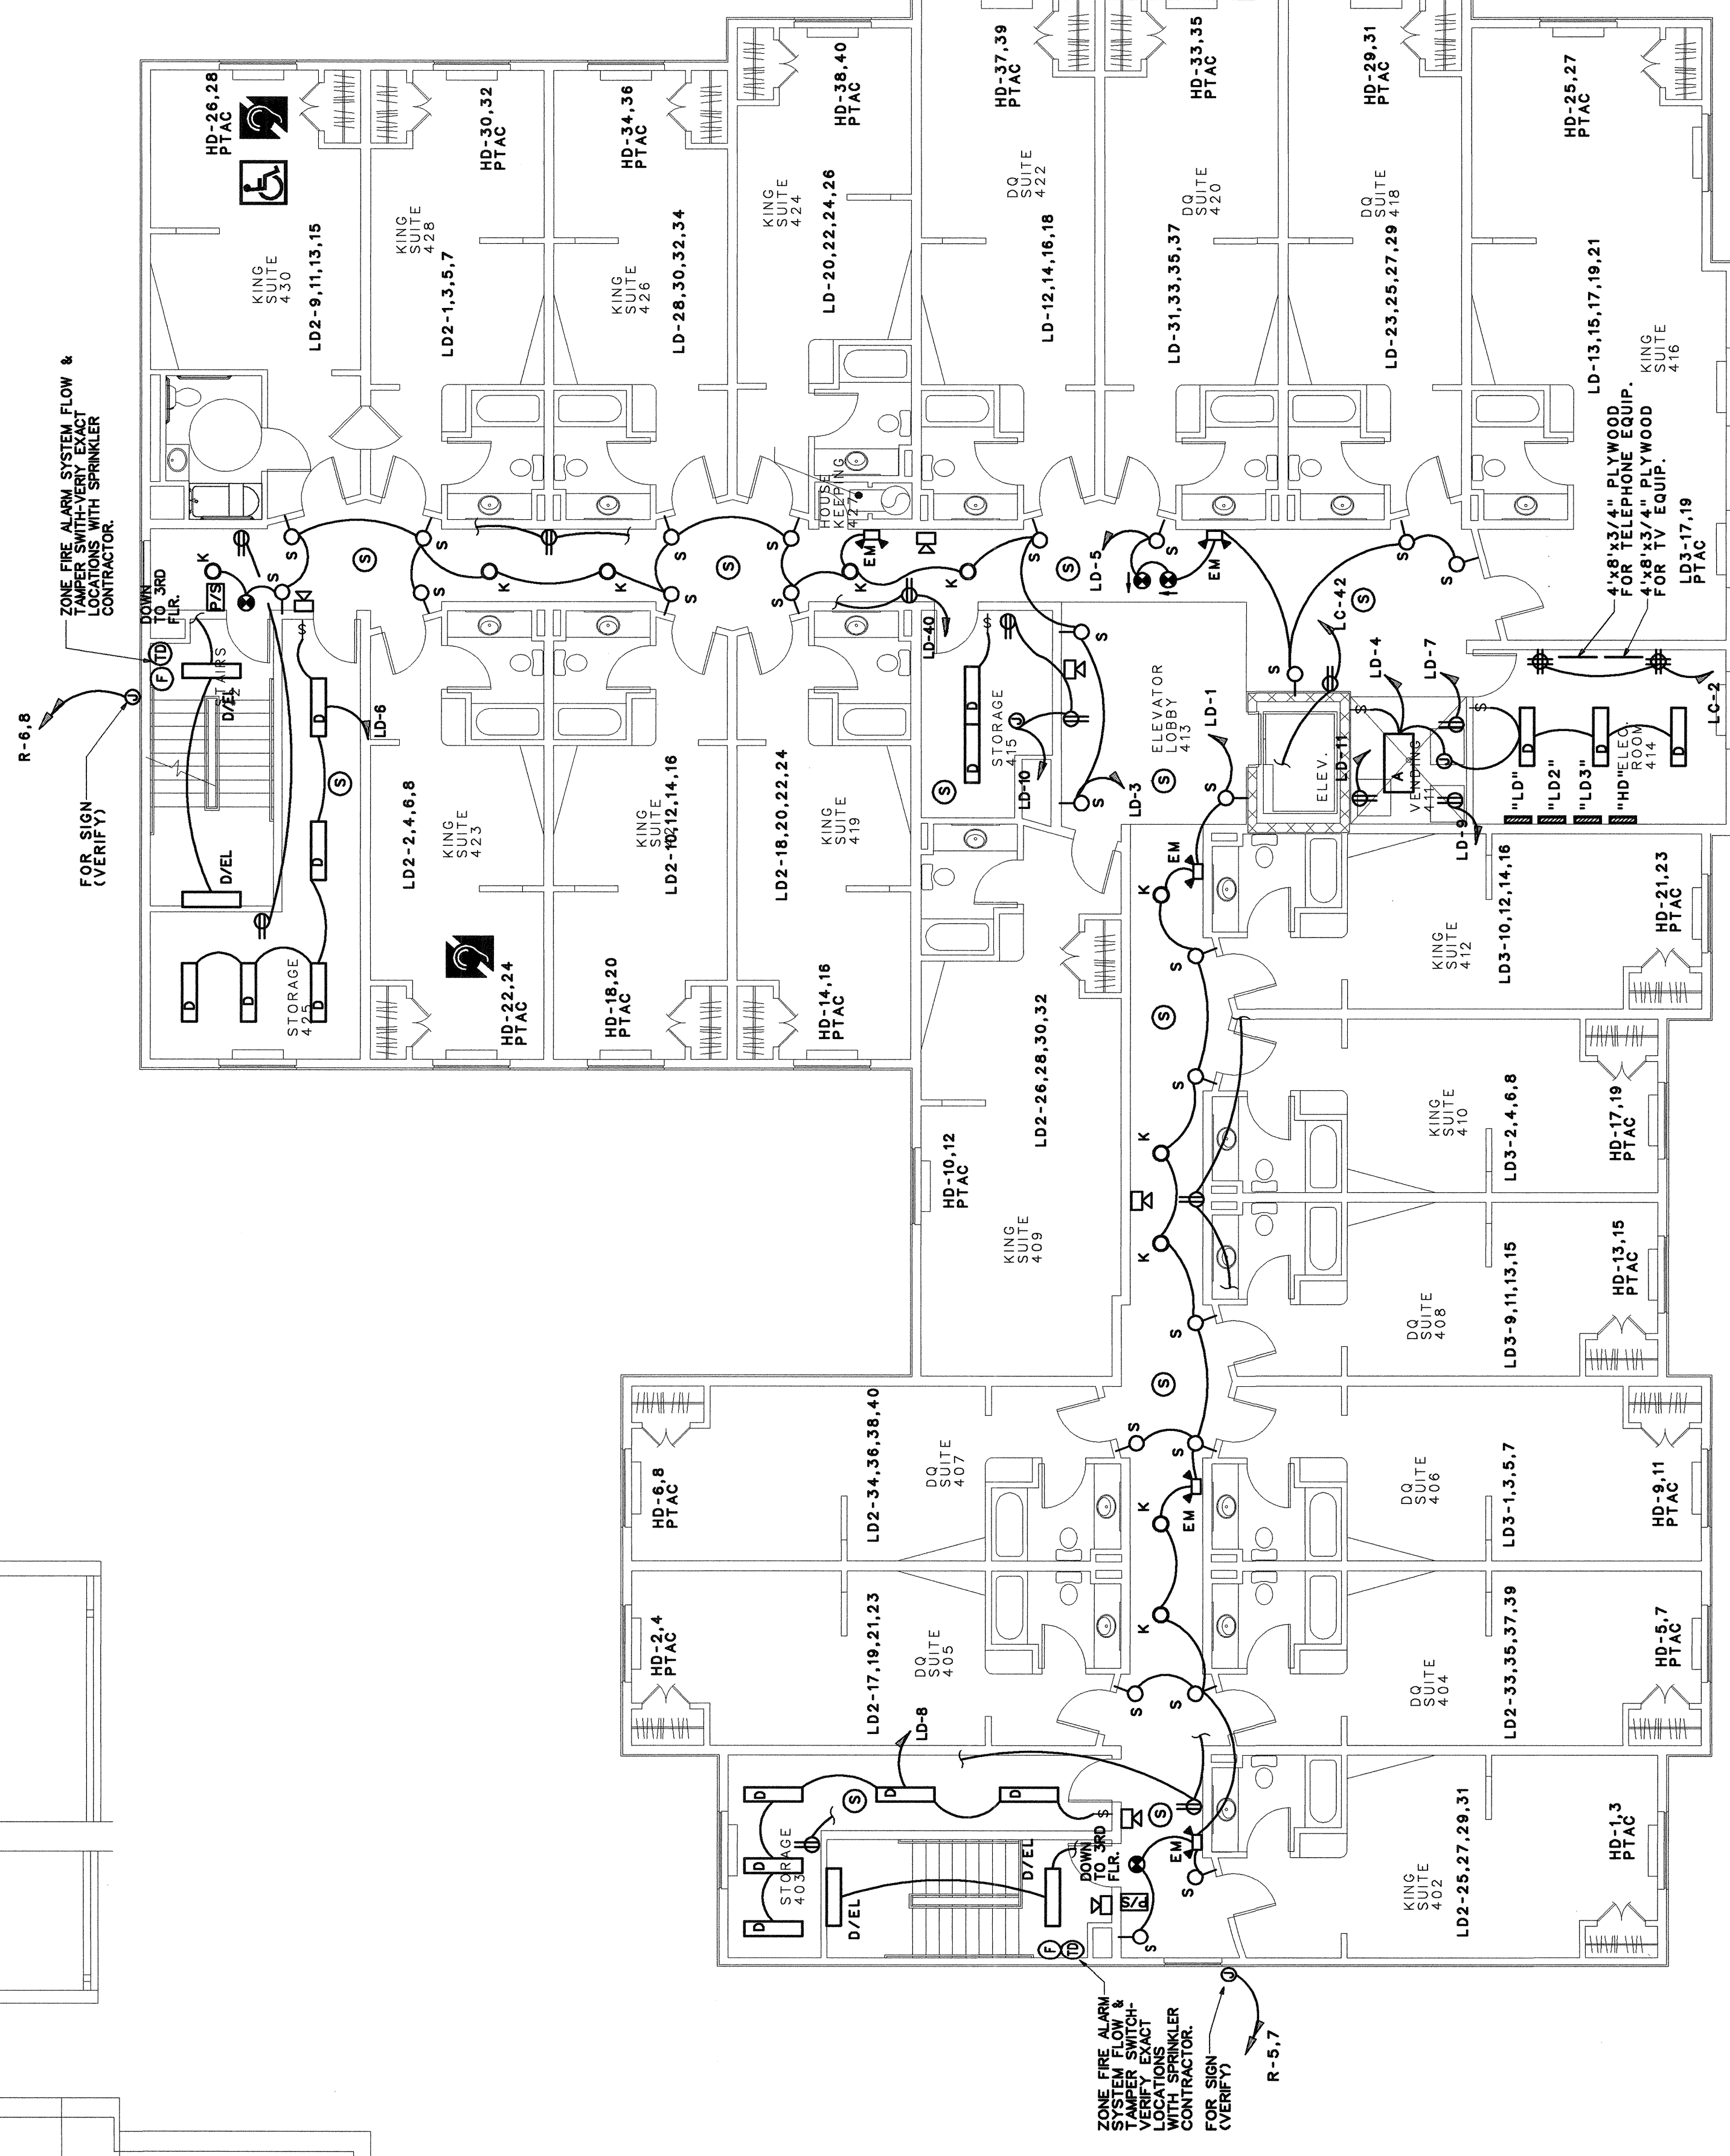

ELECTRICAL PLAN - FOURTH FLOOR

SCALE: 1/8" = 1'-0"