



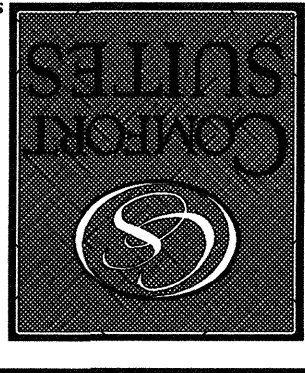

DATE	COMMENTS
REVISIONS	
JOB: 2233-1107	
DATE: 12.14.07	

RICHARD F. STELDT & ASSOCIATES, LTD.
ARCHITECTS
2621 502-4500
NBS 161058 APPLETON AVE., MENOMONEE FALLS, WI 53051

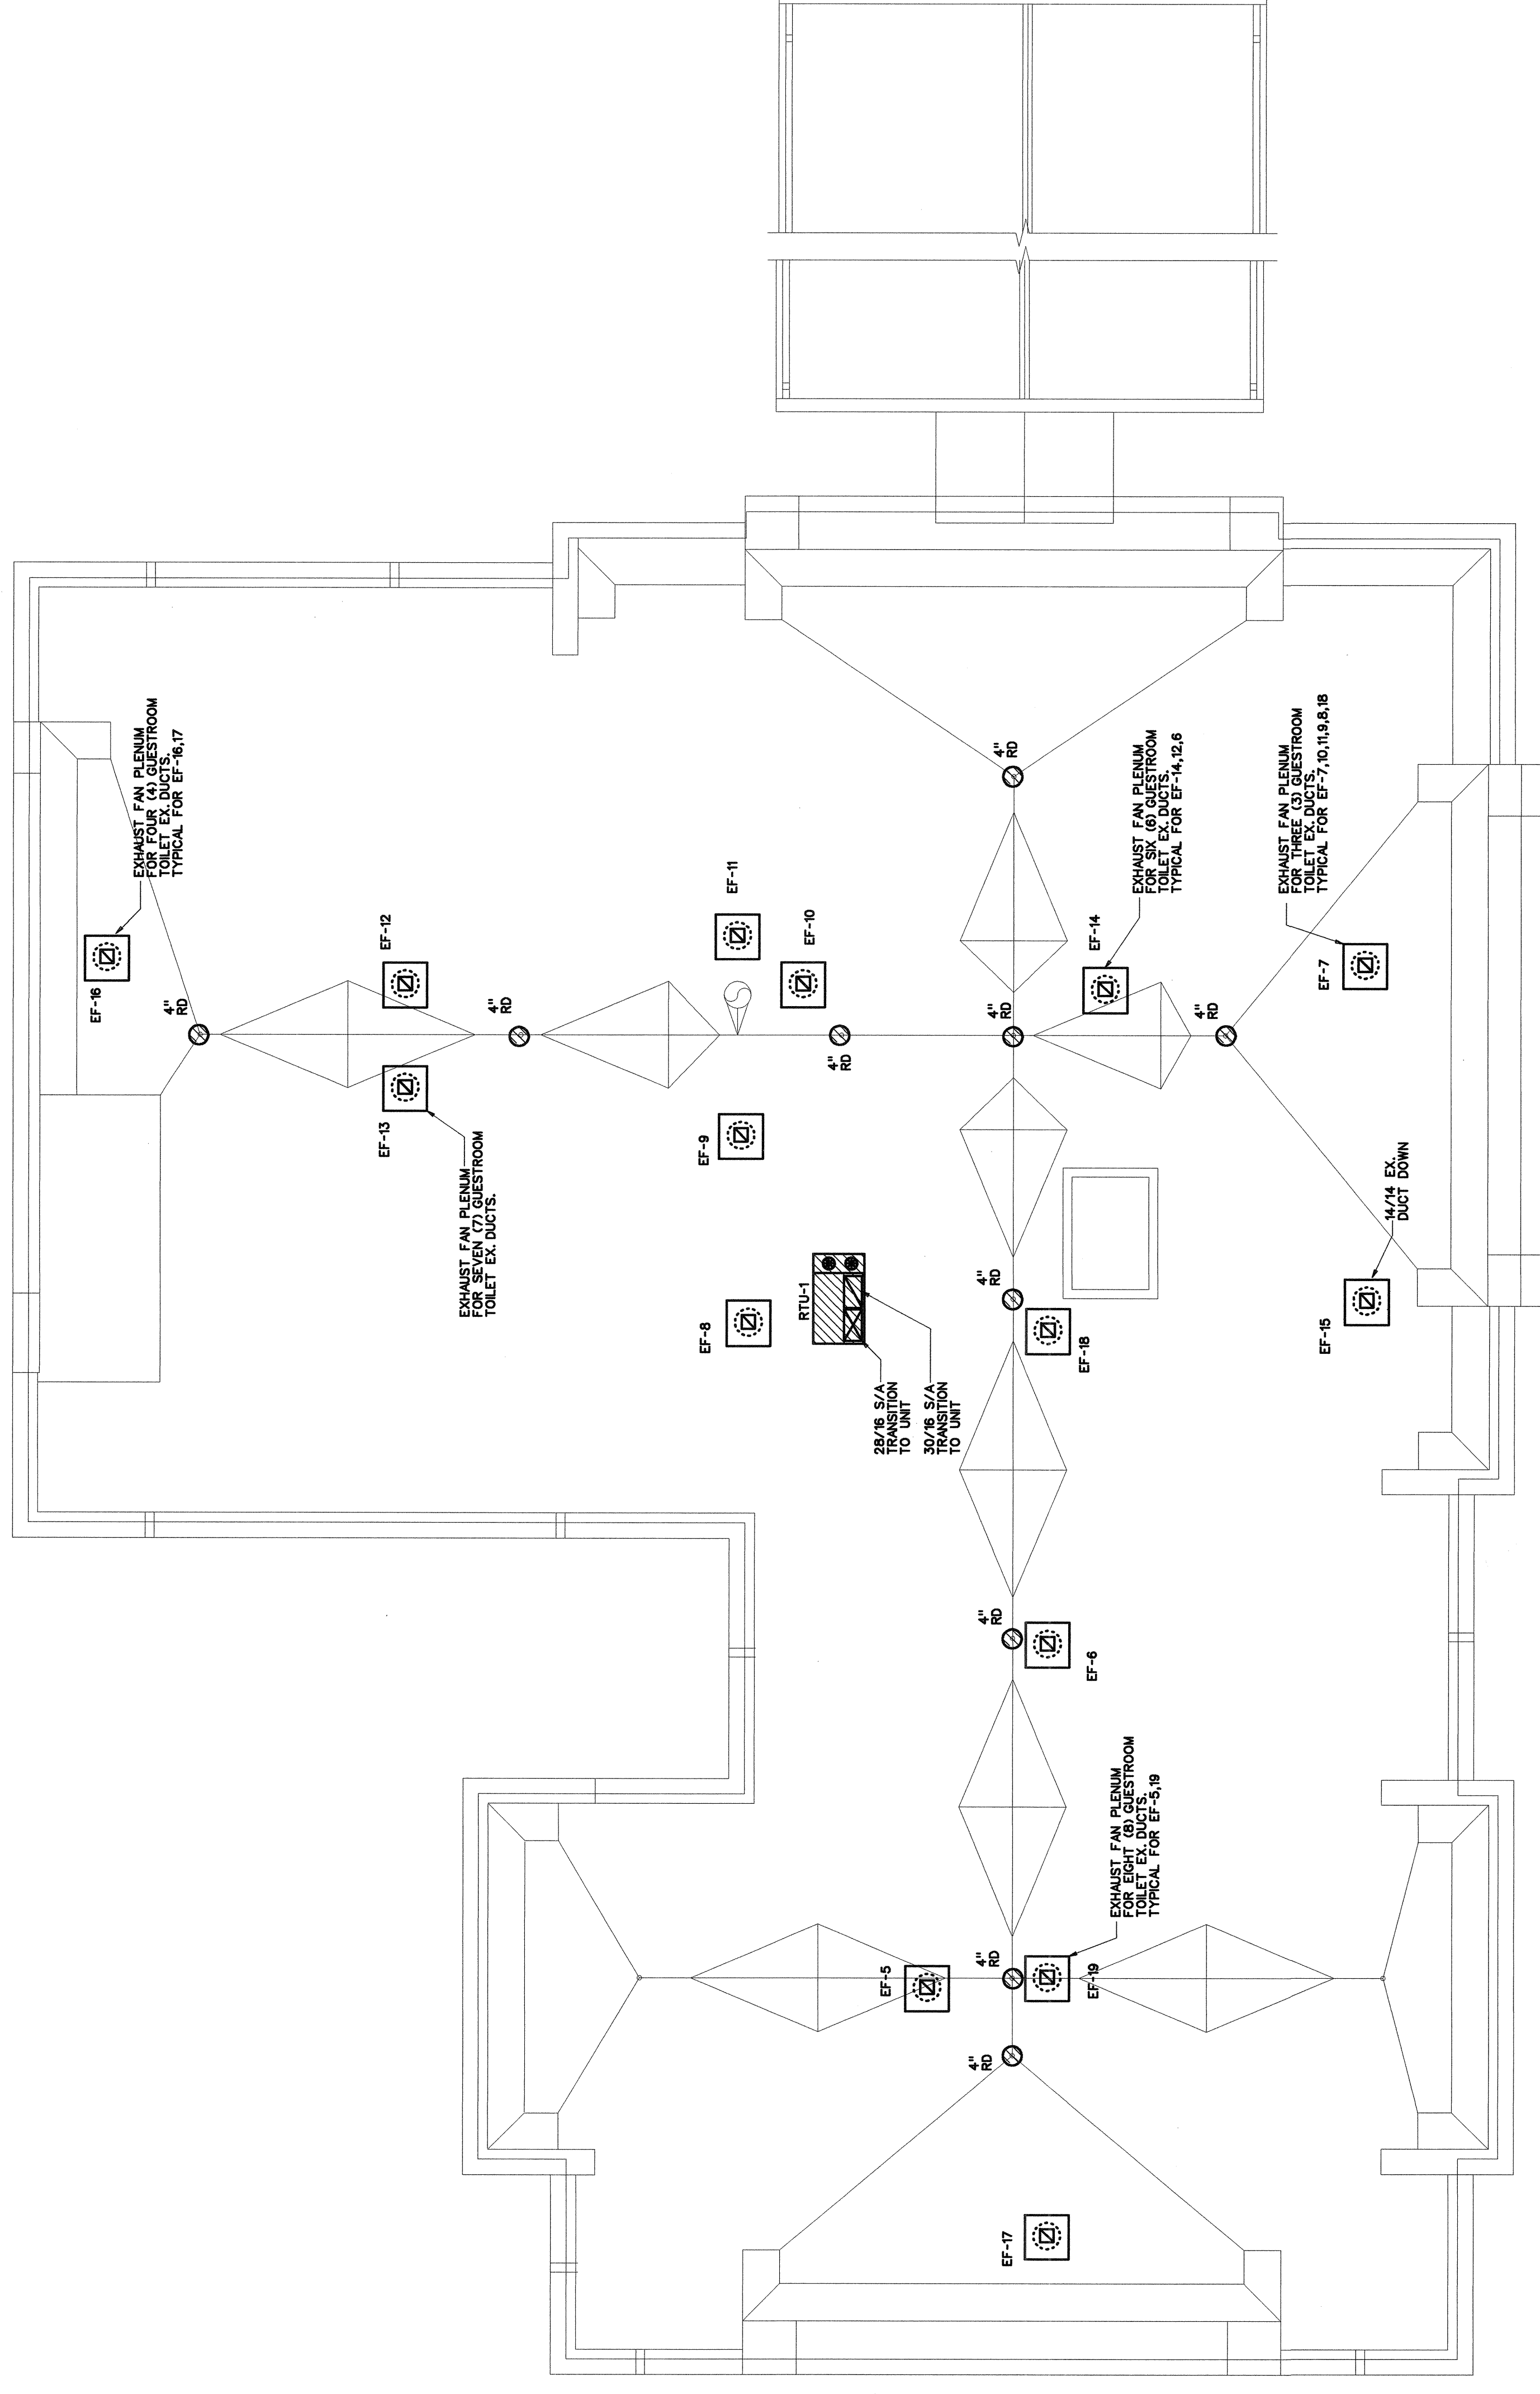

PLUMBING/HVAC PLAN - ROOF

SCALE: 1/8" = 1'-0"

EXHAUST CHASE RISER

N.T.S.

