

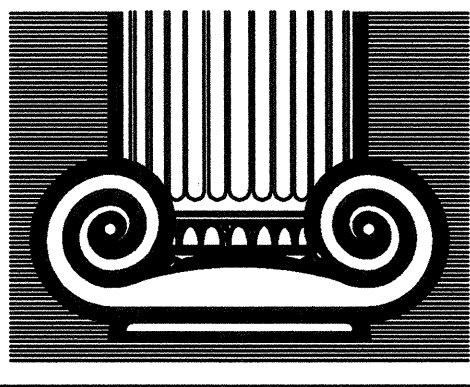


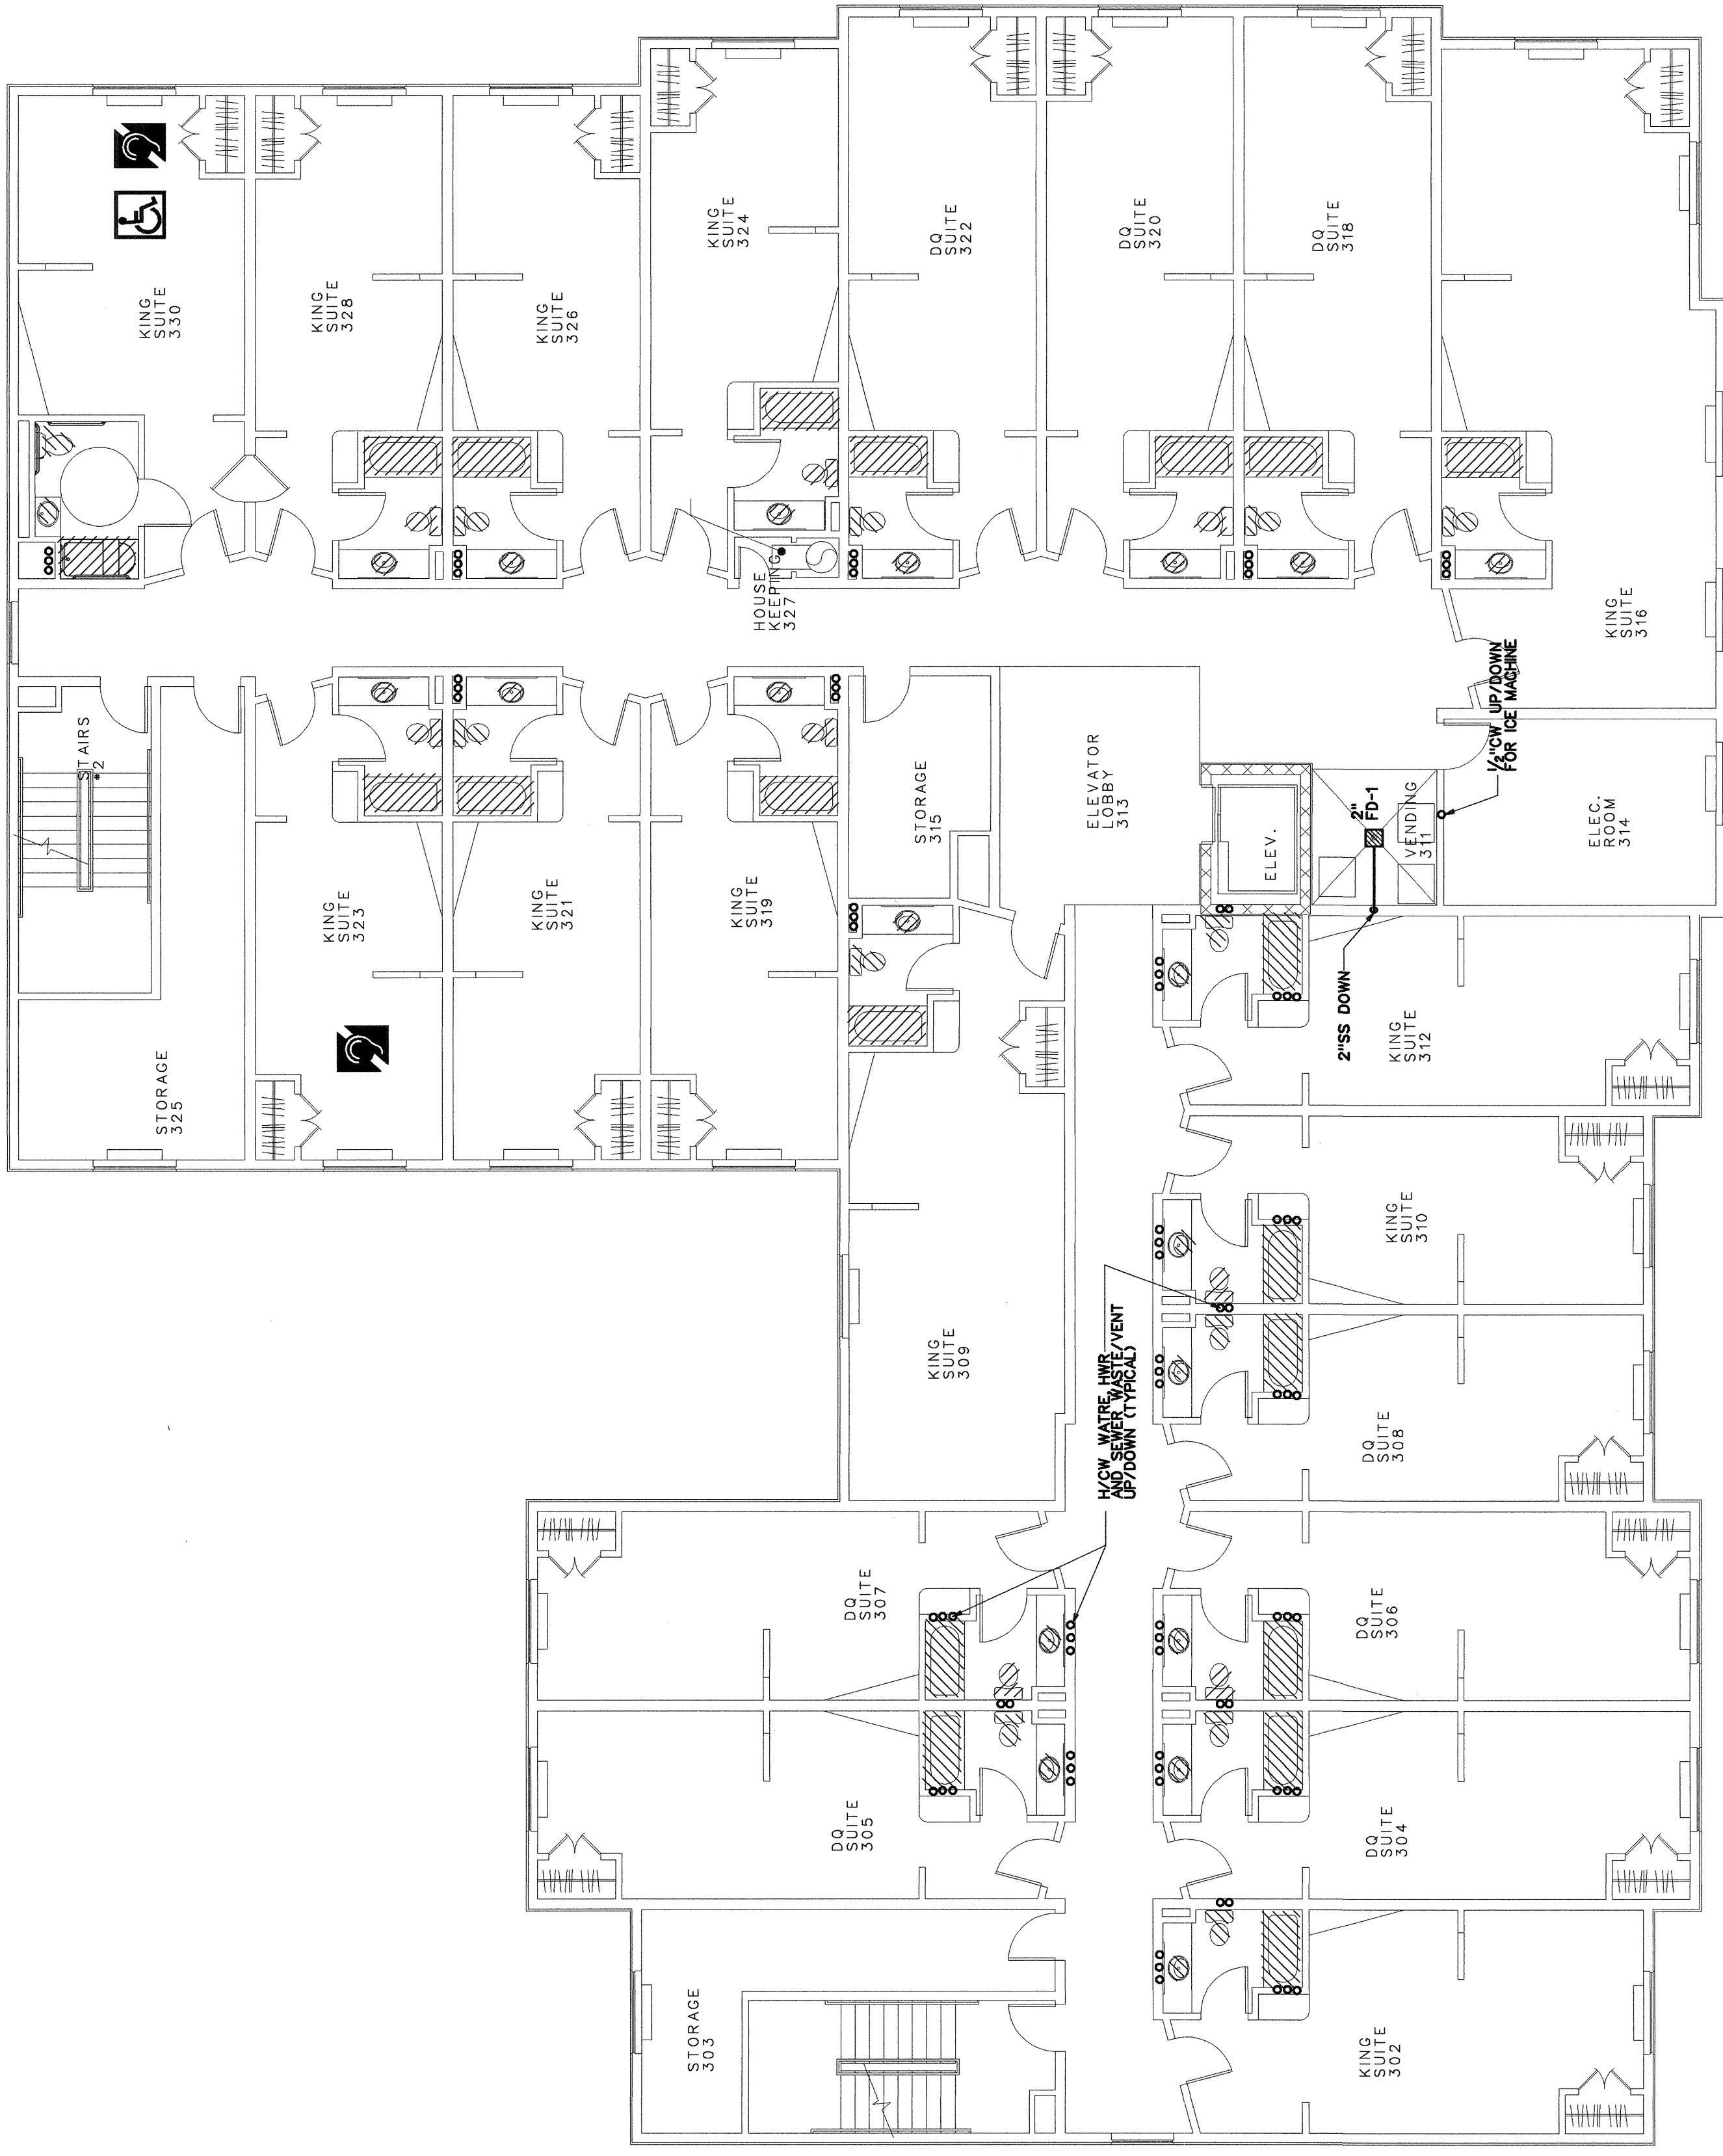


DRAWN:
APPROVED:

DATE COMMENTS
REVISIONS
JOB# 22-03-107
DATE 12-14-07

FLOWOOD, MS
70 UNITS

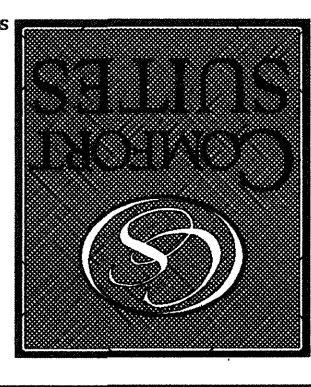

PLUMBING PLAN - THIRD FLOOR
SCALE: 1/8" = 1'-0"

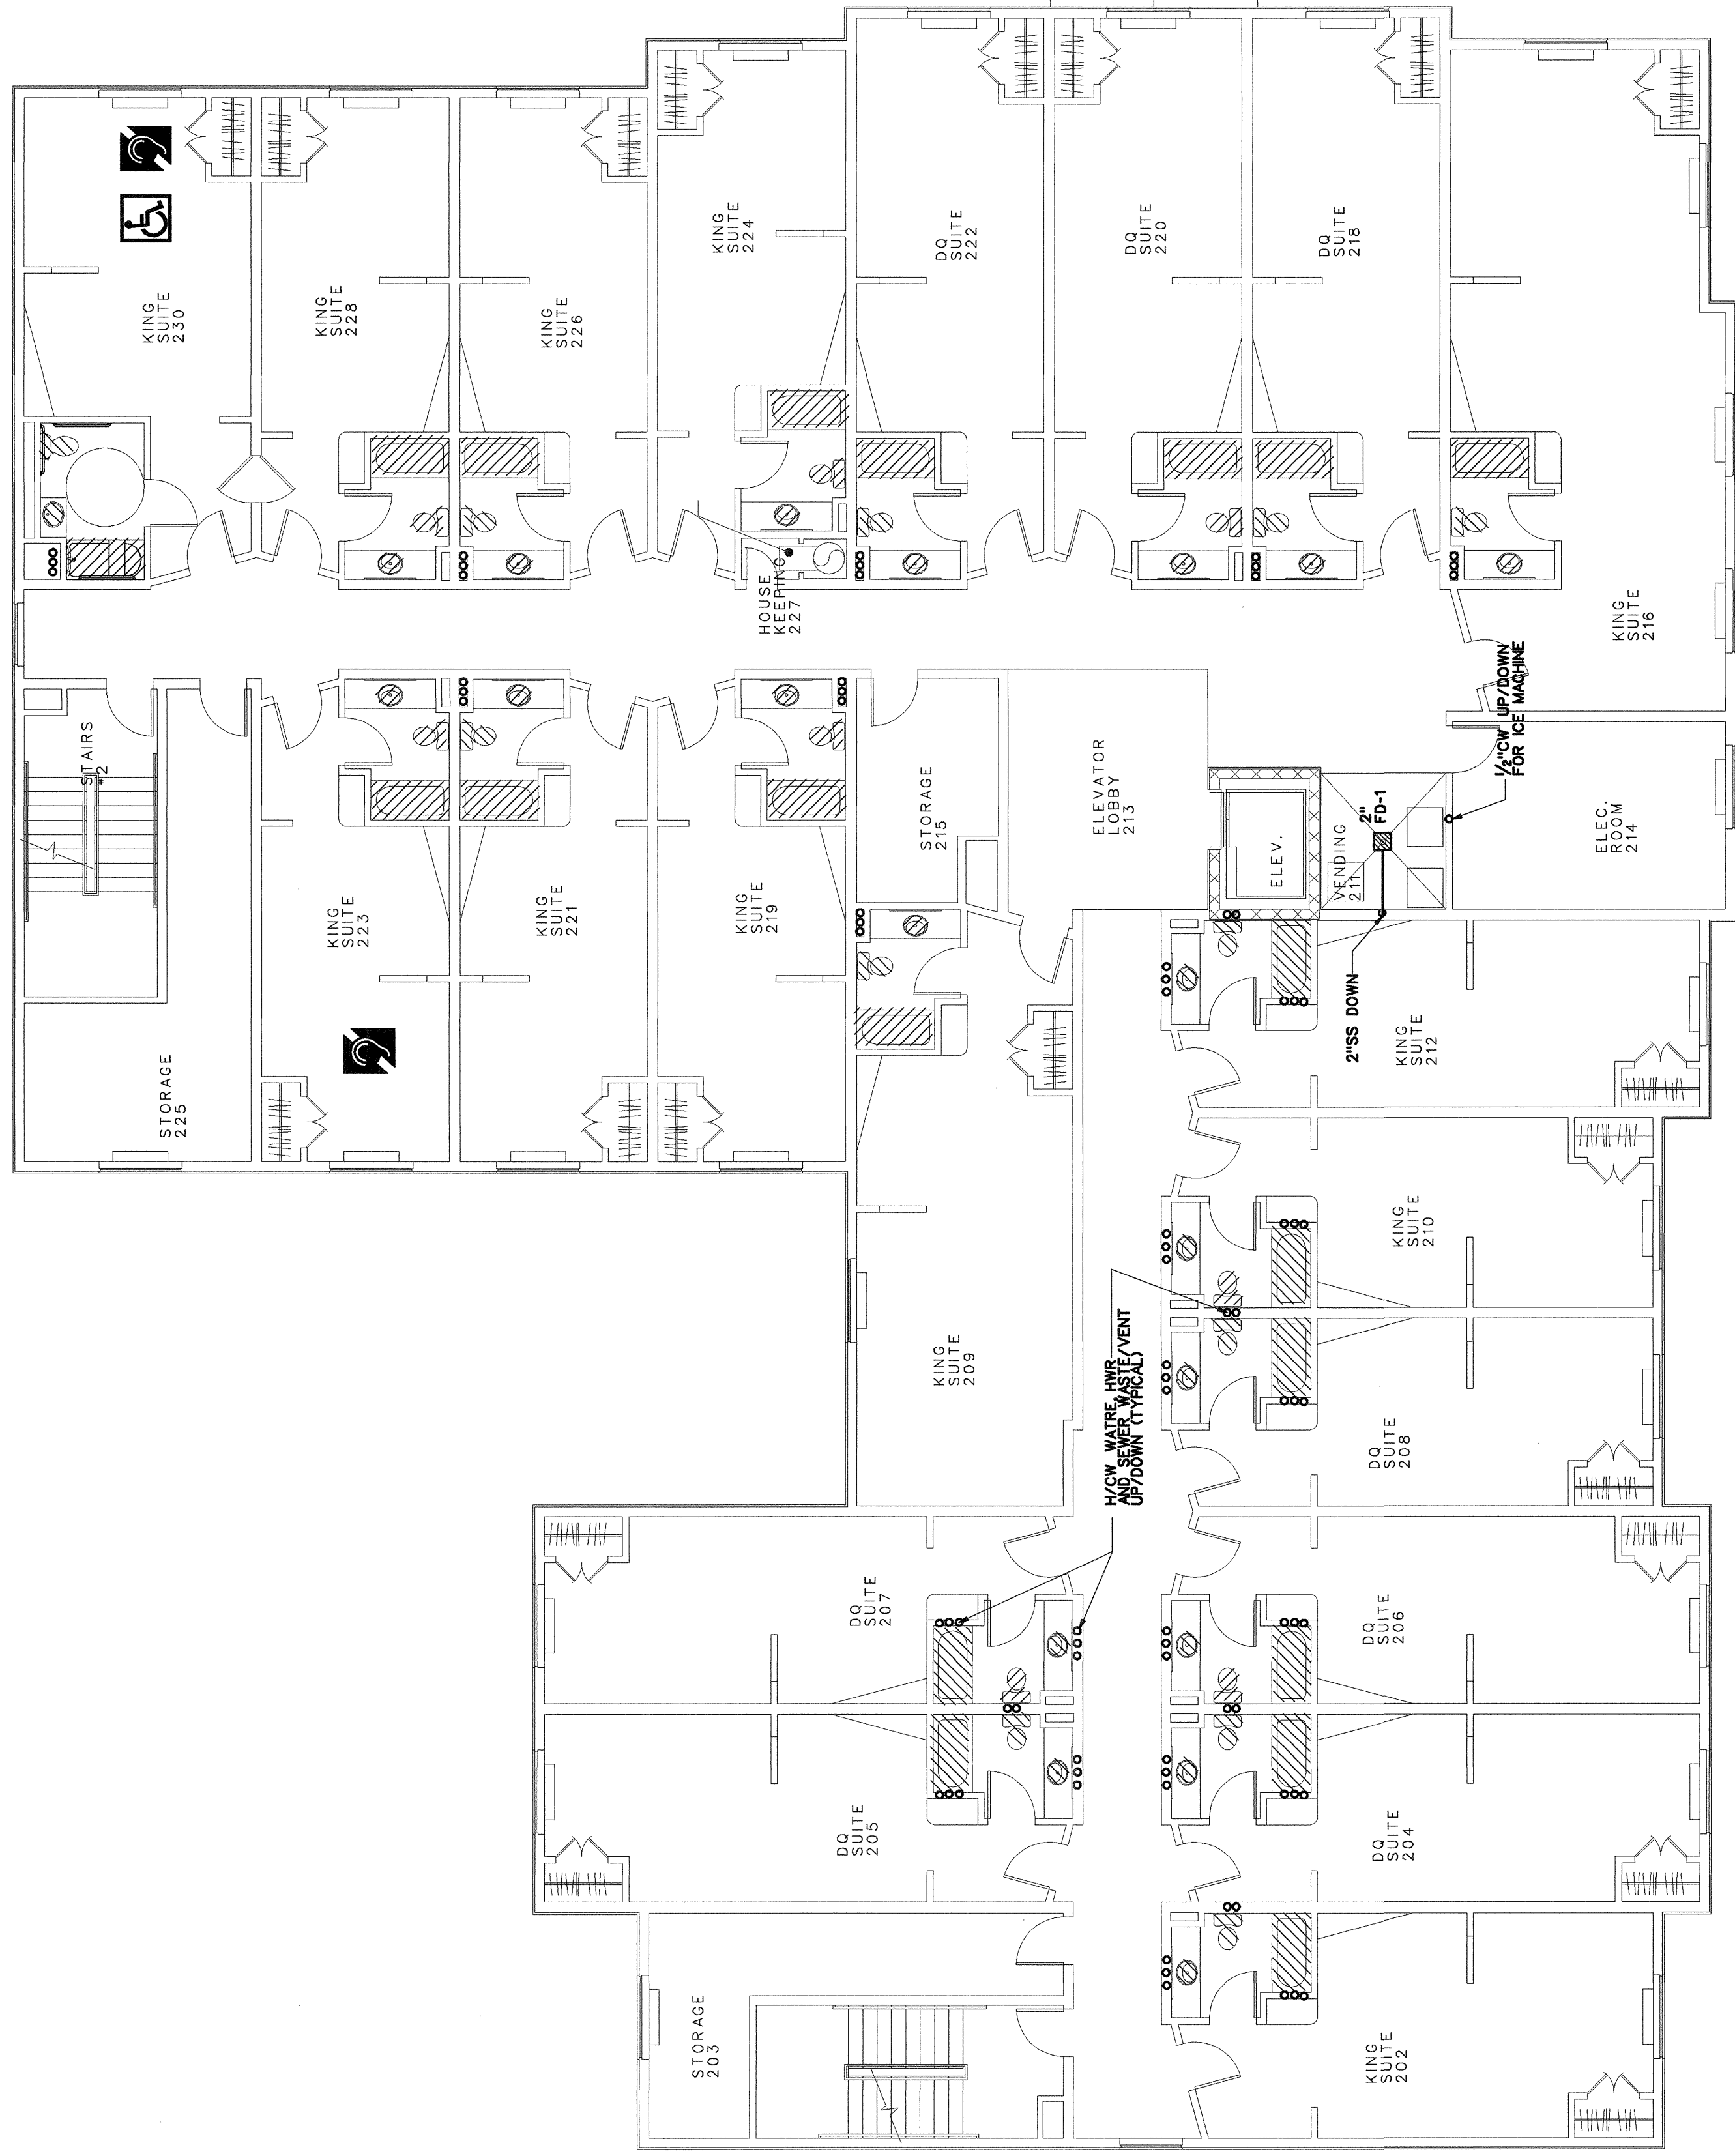

PLUMBING PLAN - SECOND FLOOR
SCALE: 1/8" = 1'-0"