


Richard Molenaar
ARCHITECT

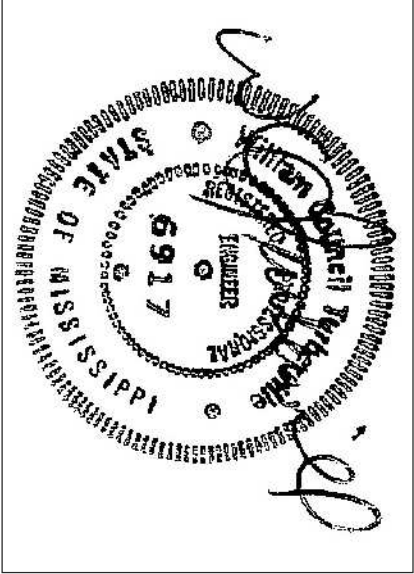

Riverview Drive Pearl, Mississippi

SHEET TITLE:


GROUND FLOOR LIGHTING PLAN

PROJECT NO. 09017 LATEST REVISION: 12-02-2011

DRAWN BY: SMU CHECKED BY: SMU SHEET NUMBER:

DATE: 9/07/11

E202

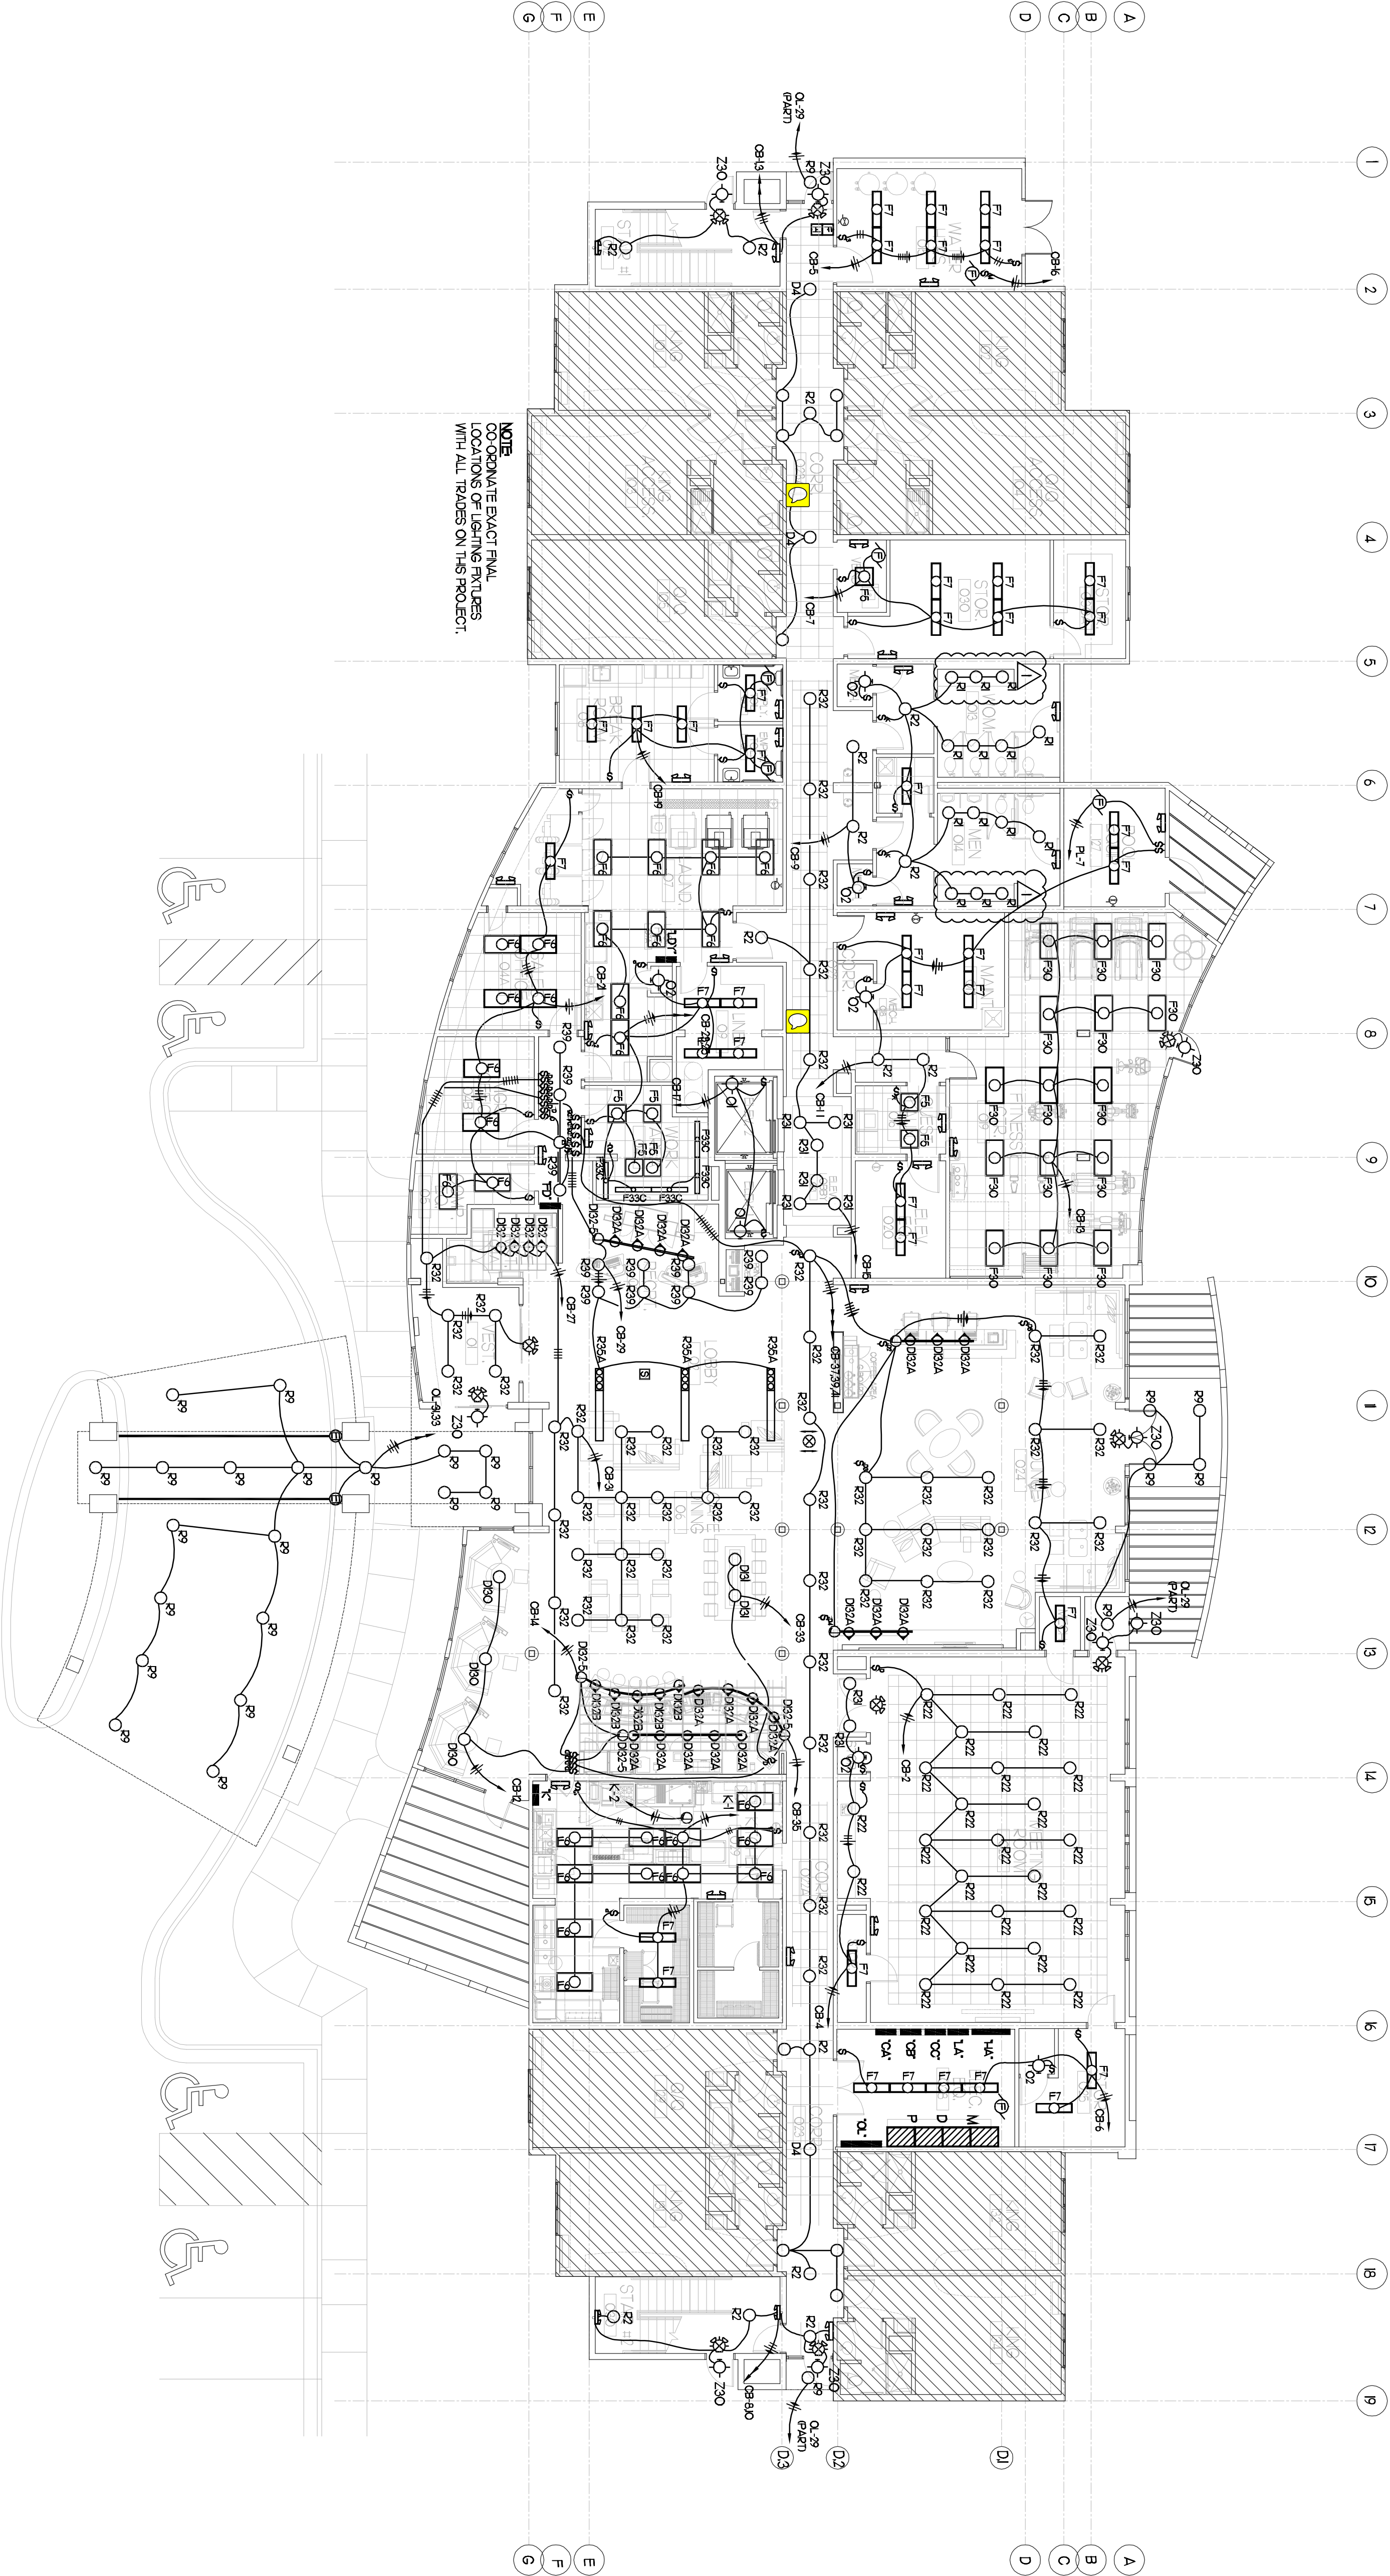

GROUND FLOOR LIGHTING PLAN
SCALE: 1/8" = 1'-0"