



Richard Molenaar

ARCHITECT

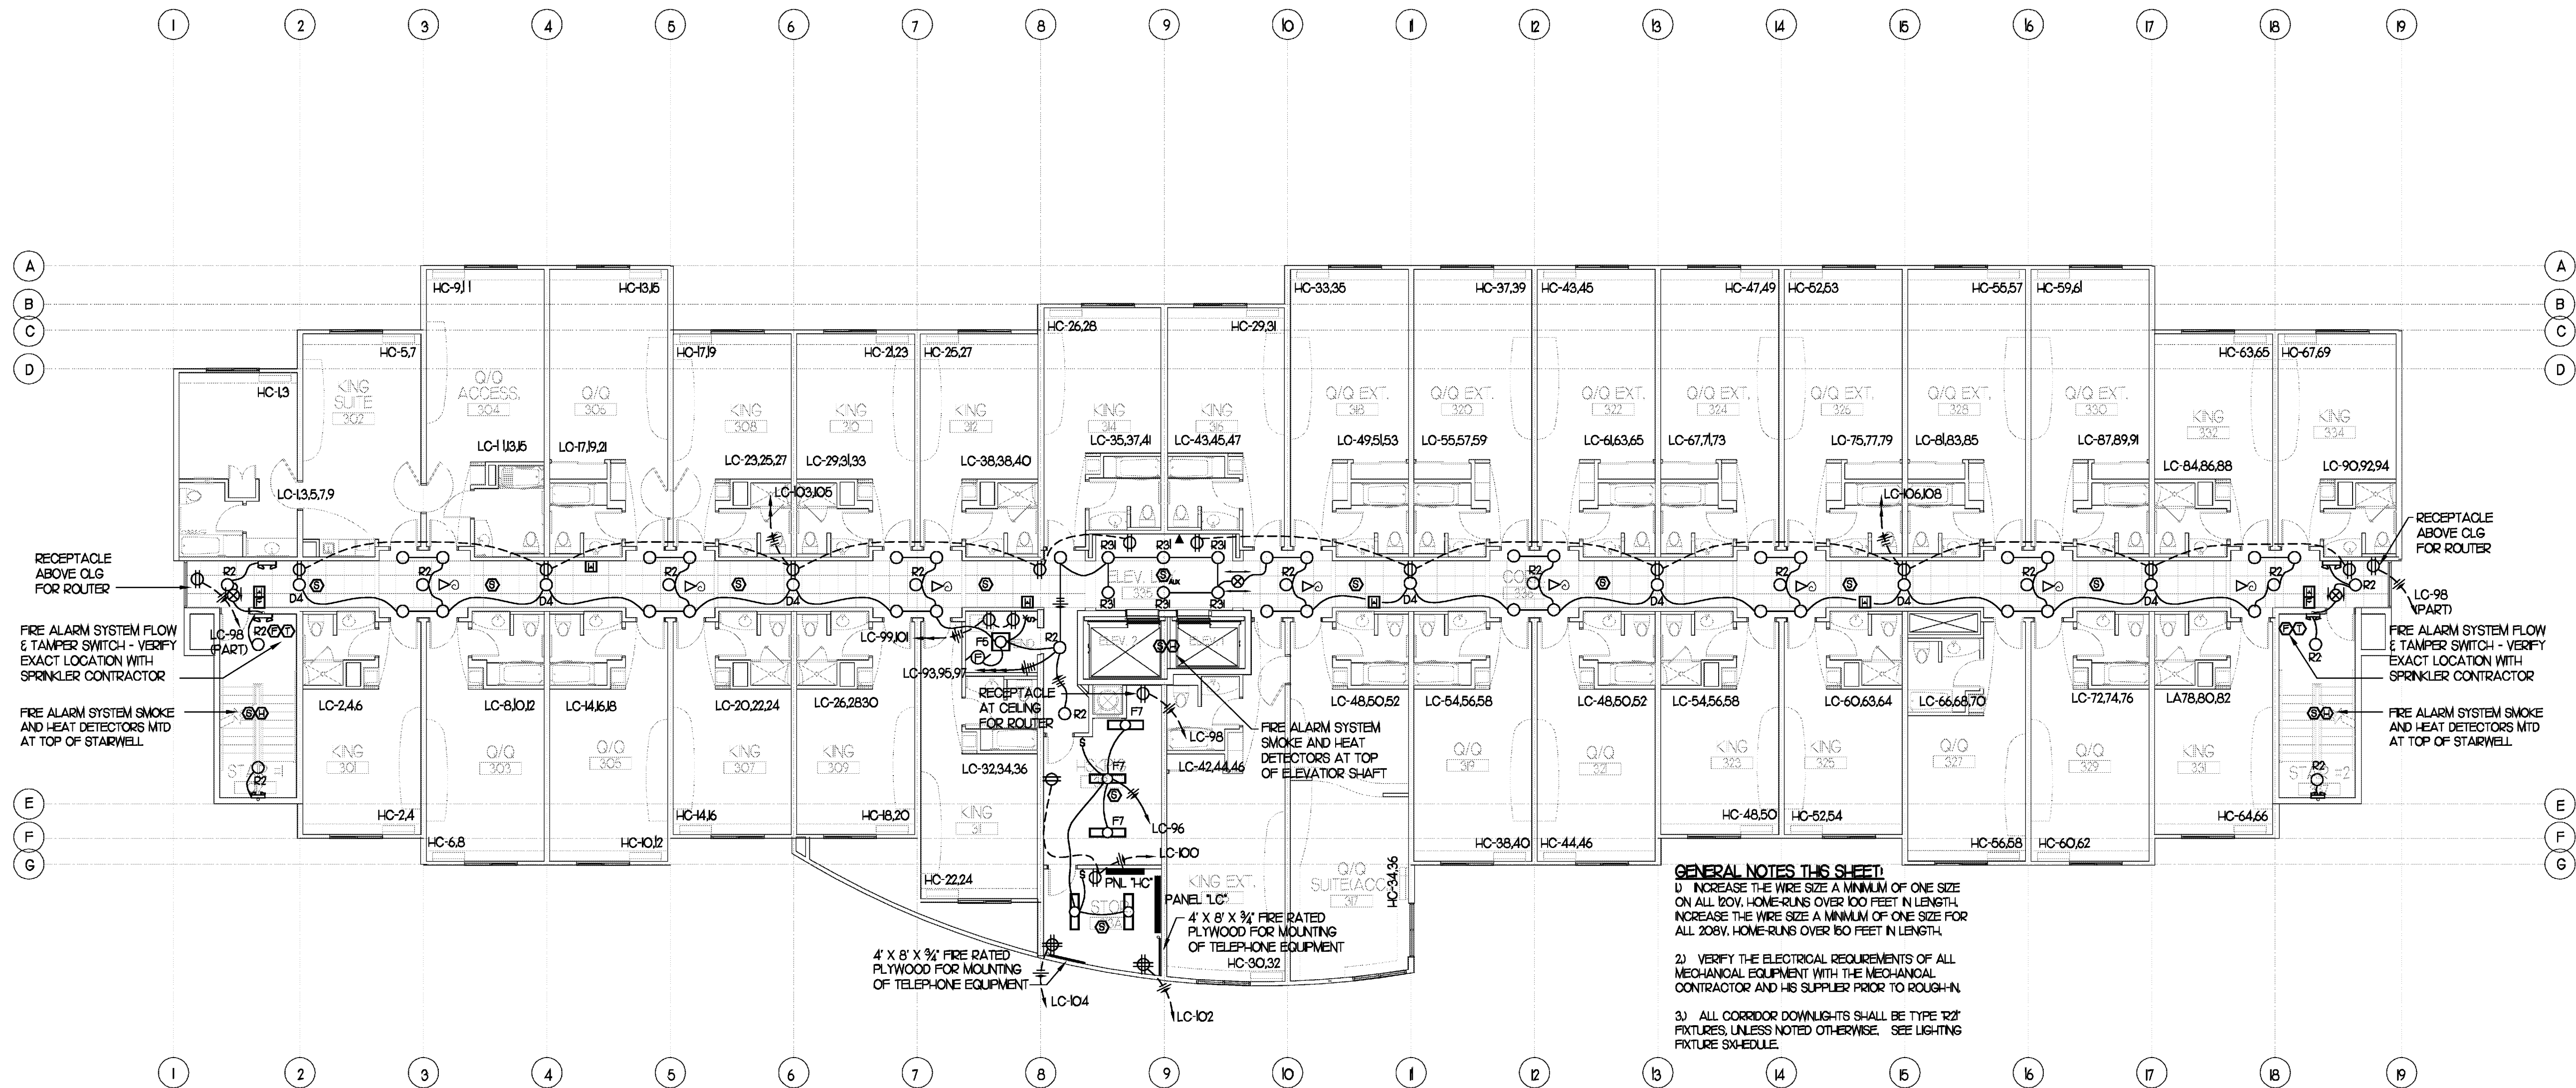

THIRD FLOOR ELECTRICAL PLAN
SCALE: 1/8" = 1'-0"

GENERAL NOTES THIS SHEET:
1) INCREASE THE WIRE SIZE A MINIMUM OF ONE SIZE ON ALL 120V. HOME-RUNS OVER 100 FEET IN LENGTH. INCREASE THE WIRE SIZE A MINIMUM OF ONE SIZE FOR ALL 208V. HOME-RUNS OVER 150 FEET IN LENGTH.
2) VERIFY THE ELECTRICAL REQUIREMENTS OF ALL MECHANICAL EQUIPMENT WITH THE MECHANICAL CONTRACTOR AND HIS SUPPLIER PRIOR TO ROUGH-IN.
3) ALL CORRIDOR DOWNLIGHTS SHALL BE TYPE T2T FIXTURES, UNLESS NOTED OTHERWISE. SEE LIGHTING FIXTURE SCHEDULE.

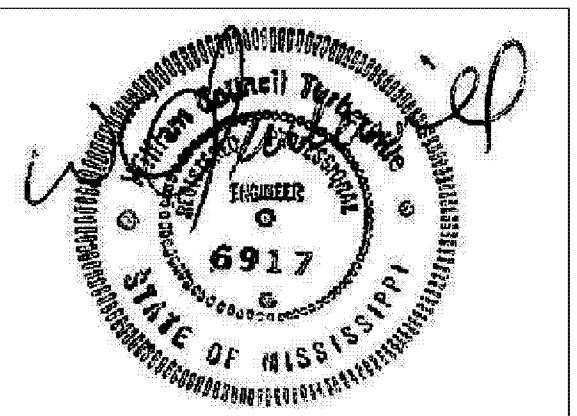

PROJECT NAME:



Riverwind Drive Pearl, Mississippi

SHEET TITLE:

THIRD FLOOR ELECTRICAL PLAN

PROJECT NO.

09017

LATEST REVISION:



DRAWN BY:

CHECKED BY:

SHEET NUMBER:

SMJ

SMJ

DATE:

9/01/11

E204