


Richard Molenaar
ARCHITECT

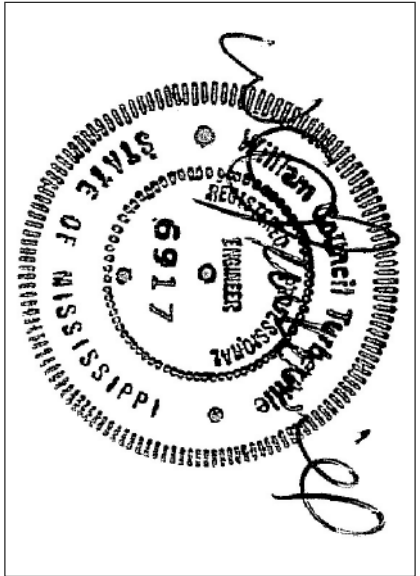

PROJECT NAME: Riverwind Drive Pearl, Mississippi

SHEET TITLE:

FOURTH FLOOR ELECTRICAL PLAN

PROJECT NO. 09017

LAST REVISION:


DRAWN BY: SMJ

CHECKED BY: SMJ

SHEET NUMBER:

DATE: 9/01/11

E205

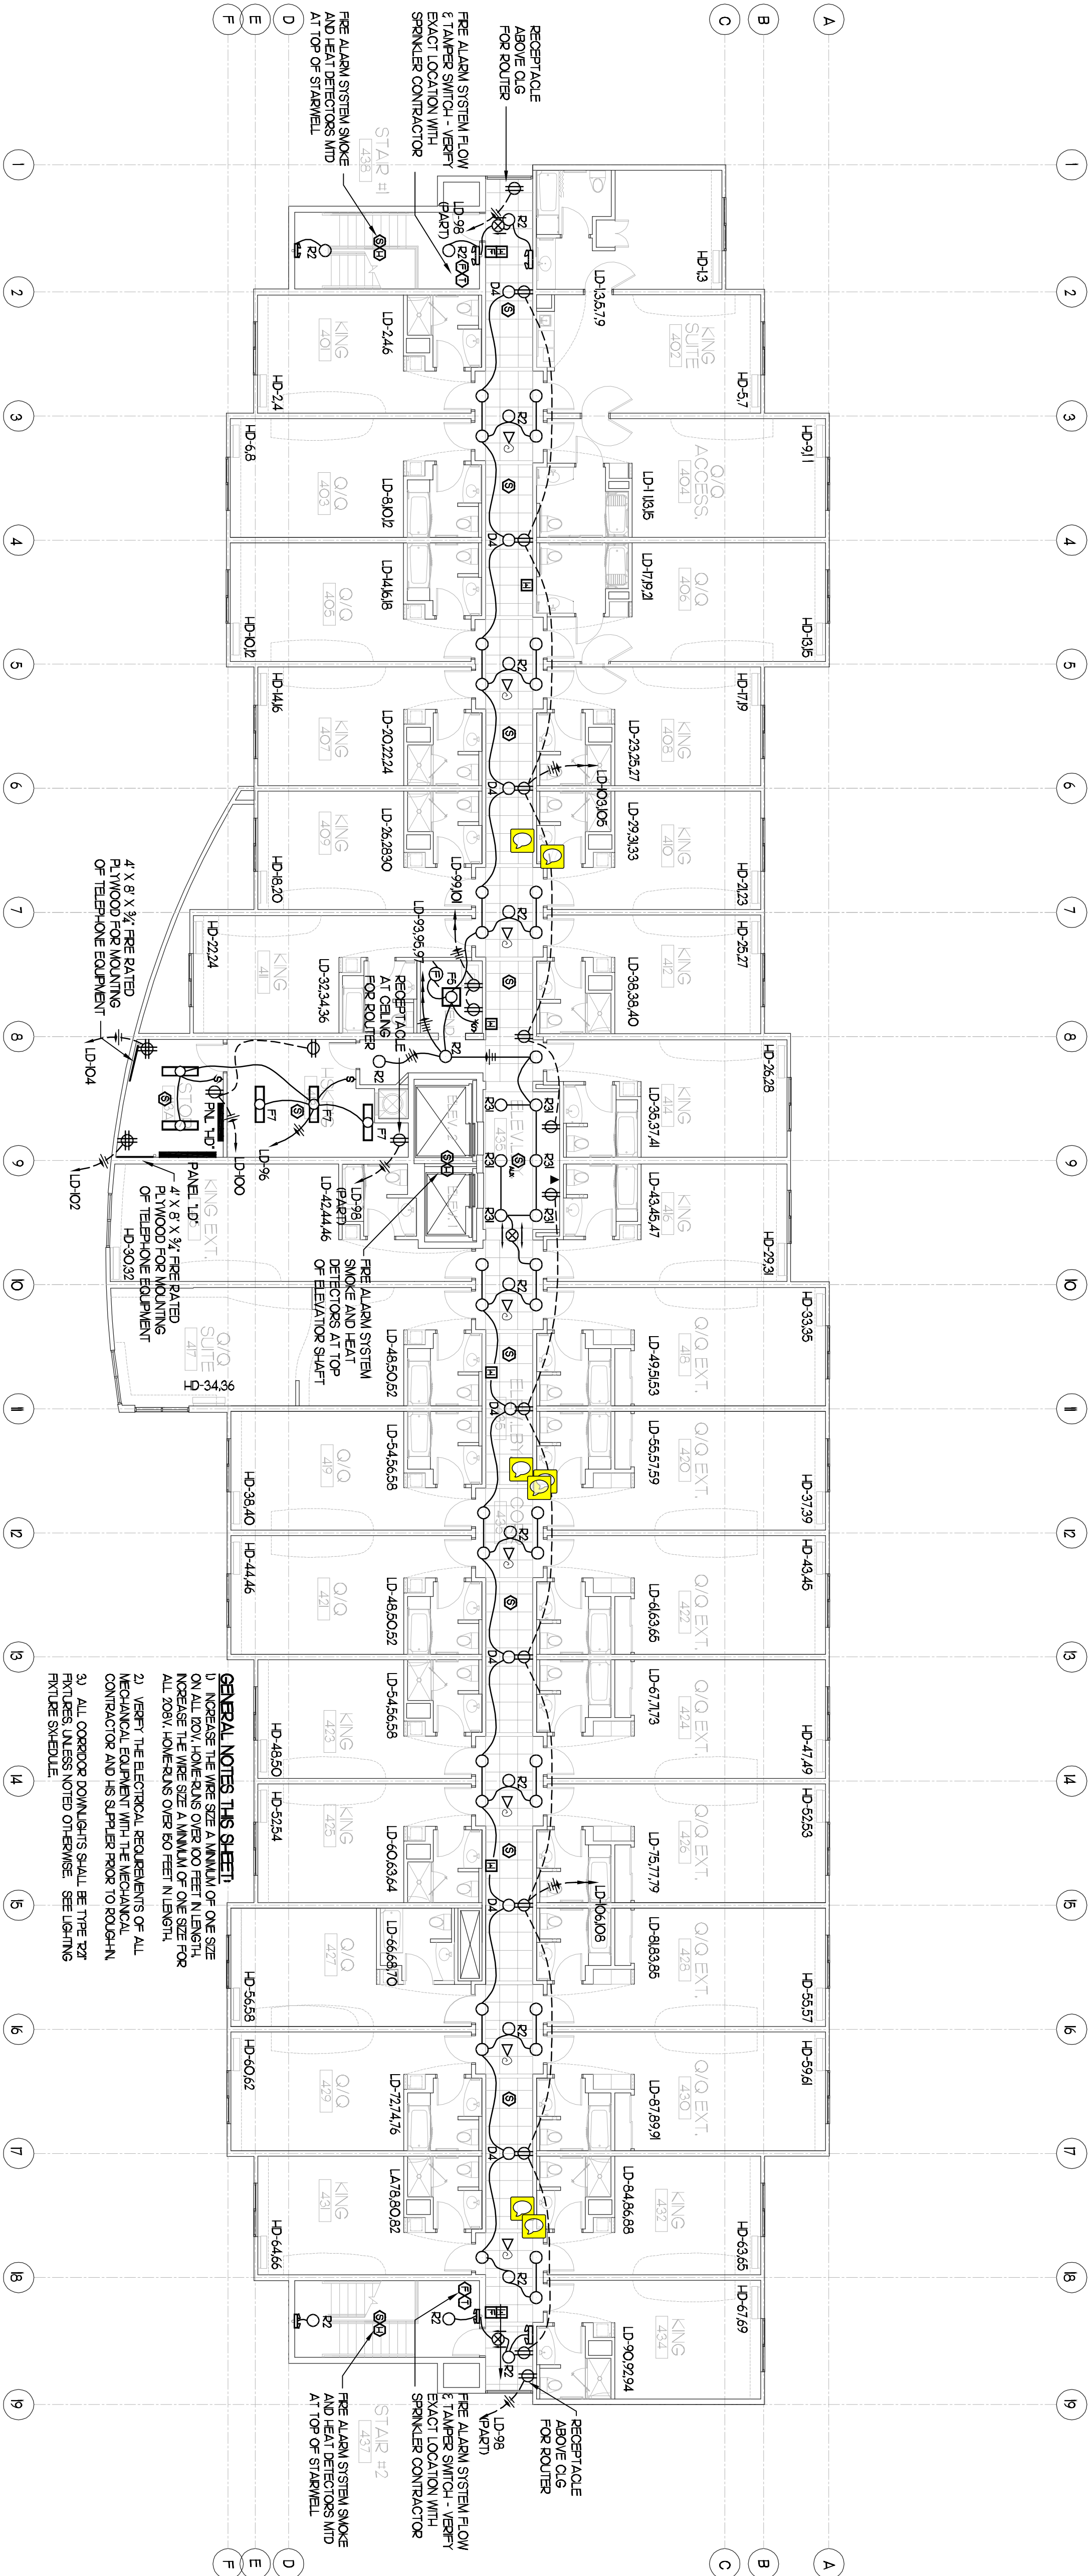

FOURTH FLOOR ELECTRICAL PLAN
SCALE: 1/8" = 1'-0"

GENERAL NOTES THIS SHEET:
1) NOISE: THE WIRE SIZE A MINIMUM OF ONE SIZE
LARGER THAN THE WIRE SIZE A MINIMUM OF ONE SIZE
LARGER THAN THE WIRE SIZE A MINIMUM OF ONE SIZE FOR
ALL ROOMS, HALLWAYS OVER 50 FEET IN LENGTH.
2) VERIFY THE ELECTRICAL REQUIREMENTS OF ALL
EQUIPMENT, ESPECIALLY THE WIRING AND THE
CONTRACTOR AND HIS SUPPLIER ROOM TO ROOM.
3) ALL CORRIDOR DOWNLIGHTS SHALL BE TYPE T24
FITTERS, UNLESS NOTED OTHERWISE. SEE LIGHTING
FINISH SCHEDULE.