



Richard Molenaar

ARCHITECT

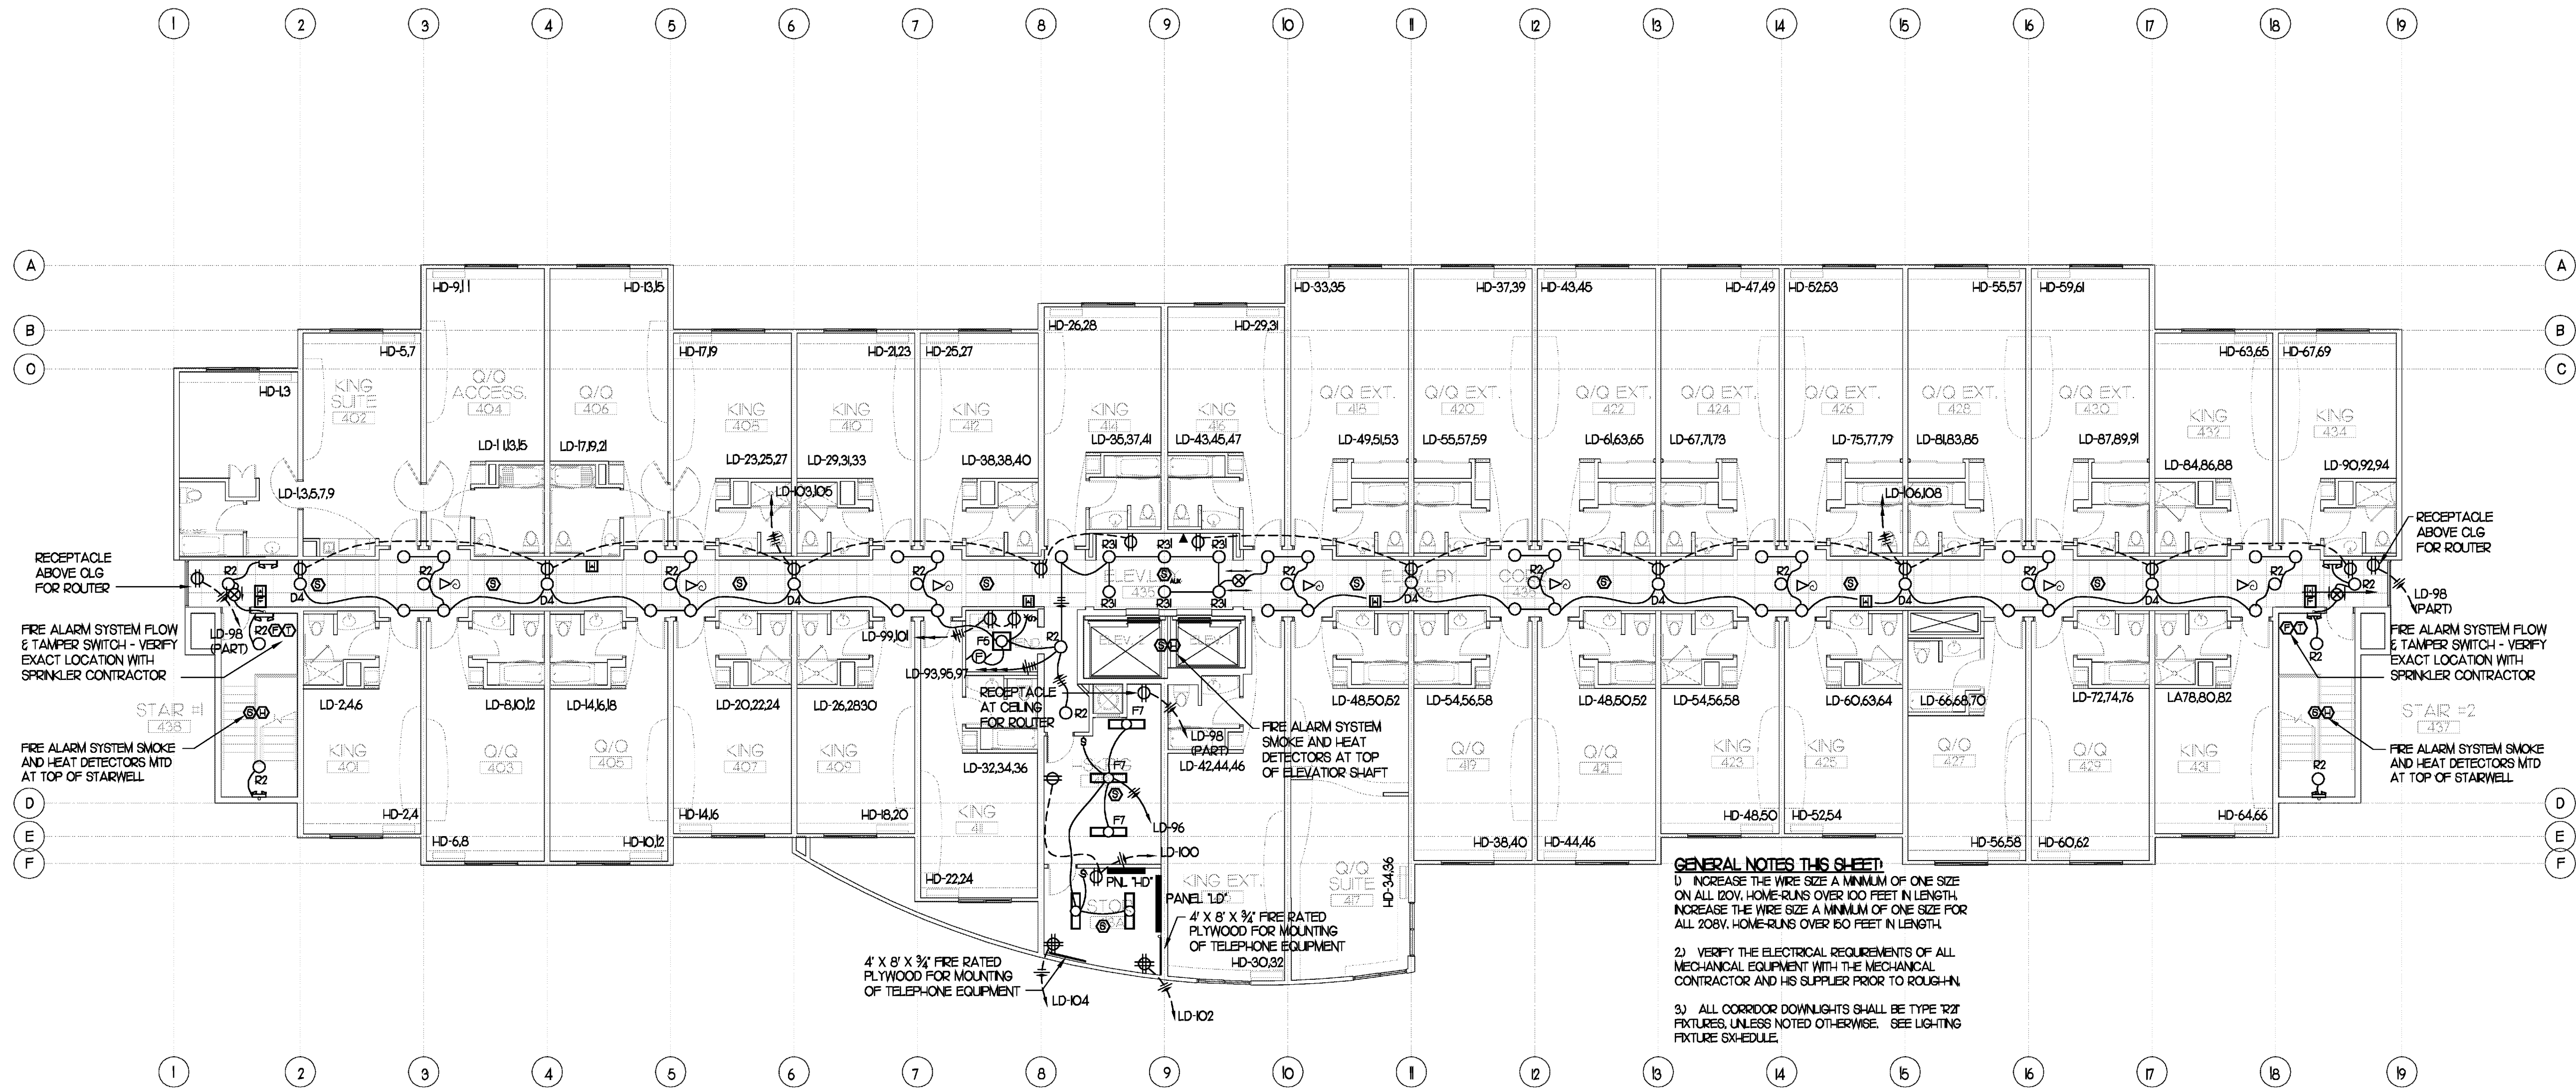

FOURTH FLOOR ELECTRICAL PLAN  
SCALE: 1/8" = 1'-0"

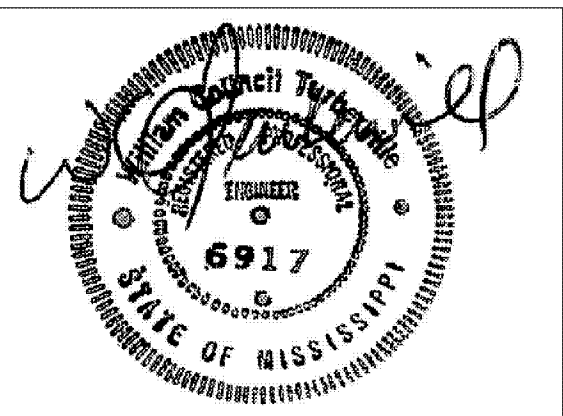

PROJECT NAME:



Riverwind Drive Pearl, Mississippi

SHEET TITLE:

FOURTH FLOOR ELECTRICAL PLAN

PROJECT NO.

09017

LATEST REVISION:



DRAWN BY:

SMJ

CHECKED BY:

SMJ

SHEET NUMBER:

DATE:

9/01/11

E205