

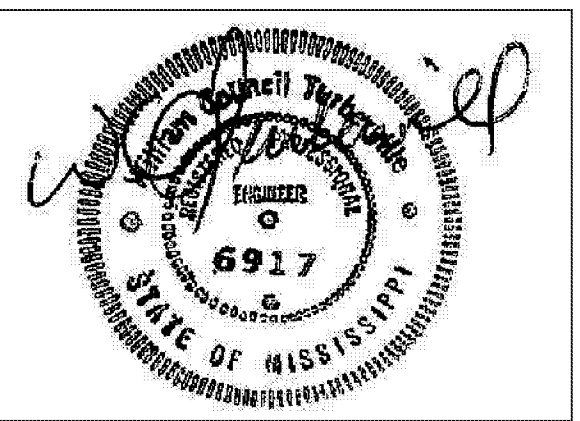


Richard Molenaar
ARCHITECT

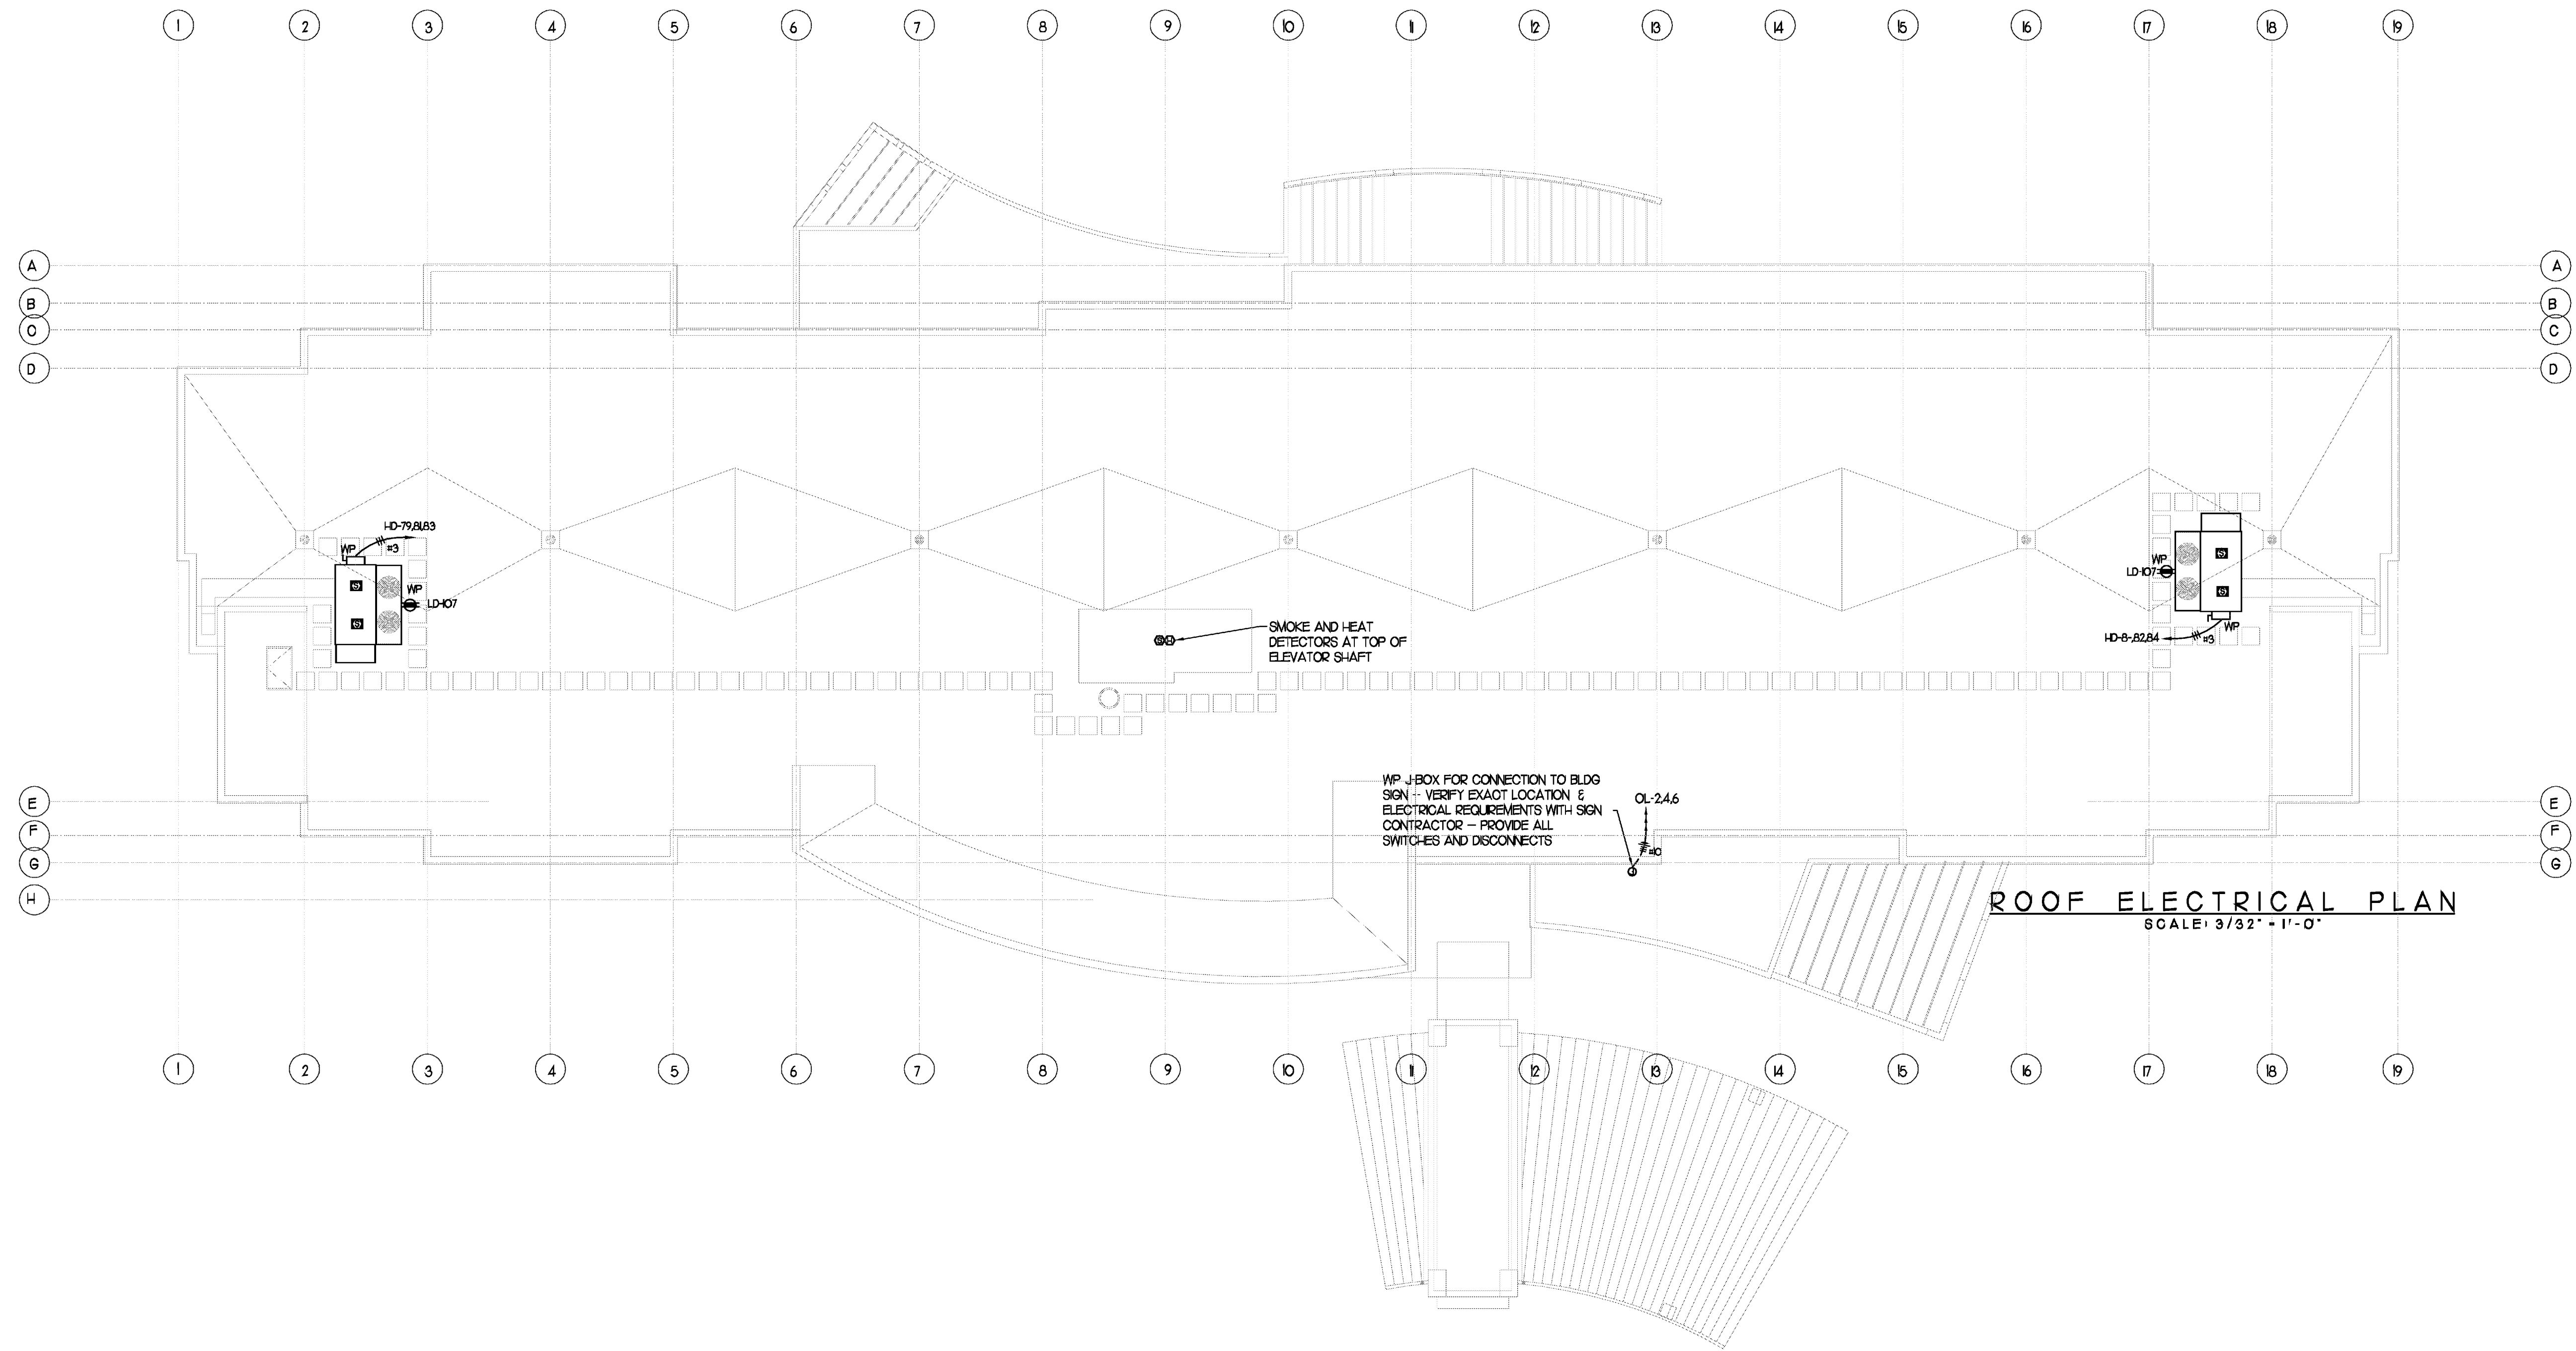

PROJECT NAME:

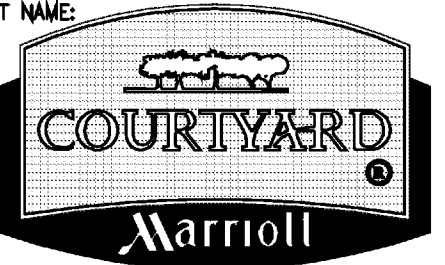

Riverwind Drive Pearl, Mississippi

SHEET TITLE:

ROOF ELECTRICAL PLAN

PROJECT NO.
09017

LATEST REVISION:



DRAWN BY:

CHECKED BY:

SHEET NUMBER:

DATE:

9/01/11

E206