




Richard Molenaar


ARCHITECT

| ELECTRICAL CONNECTIONS SCHEDULE | | | | | | | | | | | | |
|---------------------------------|------------|--------------------------------|----------|---------|-------|-------|-----------------------------|------|-------|-----------------|-----------|-------------------------------------------------|
| NUMBER | CONNECTION | SERVICE TO | ITEM NO. | VOLT | PHASE | HP | AMPS | KW | WATTS | LOCATION | AFF. | REMARKS |
| KITCHEN | | | | | | | | | | | | |
| | JUNCT. BOX | WALK-IN COOLER (LITES) | K1 | 120 | 1 | - | 10.0 | - | - | FA | CLG | E.C. TO BRANCH TO CONNECTION AS REQUIRED |
| E2 | JUNCT. BOX | WALK-IN COOLER CONDENSER | K2 | 208-230 | 3 | 1.0 | - | - | - | VERIFY LOCATION | - | E.C. TO BRANCH TO CONNECTION AS REQUIRED |
| E3 | JUNCT. BOX | WALK-IN COOLER COIL | K3 | 120 | 1 | - | MOTOR 5.1/5 FAN 1.6 | - | - | WALL | 8'-0" | E.C. TO BRANCH TO CONNECTION AS REQUIRED |
| E4 | JUNCT. BOX | WALK-IN FREEZER (LITES) | K4 | 120 | 1 | - | 10.0 | - | - | FA | CLG | E.C. TO BRANCH TO CONNECTION AS REQUIRED |
| E5 | JUNCT. BOX | WALK-IN FREEZER CONDENSER | K5 | 208-230 | 3 | 1 1/2 | - | - | - | VERIFY LOCATION | - | E.C. TO BRANCH TO CONNECTION AS REQUIRED |
| E6 | JUNCT. BOX | WALK-IN FREEZER COIL | K6 | 208 | 1 | - | COIL FAN 1.0 COIL 1.7/2.7/8 | - | - | WALL | 8'-0" | E.C. TO BRANCH TO CONNECTION AS REQUIRED |
| E238B | DUPLEX | BAG-IN BOX | K238B | 120 | 1 | 1/3 | - | - | - | WALL | 12' | E.C. TO BRANCH TO CONNECTION AS REQUIRED |
| E34 | JUNCT. BOX | DISPOSER | K34 | 208-230 | 3 | 2.0 | 6.2 | - | - | WALL | 8' | E.C. TO BRANCH TO CONNECTION AS REQUIRED |
| E35 | JUNCT. BOX | DISH MACHINE | K35 | 208-240 | 3 | 2.0 | 3.3 | - | - | WALL | 12' | E.C. TO BRANCH TO CONNECTION AS REQUIRED |
| E37 | JUNCT. BOX | CONDENSATE HOOD FAN | K37 | 120 | 1 | 1/3 | 4.1 | - | - | ROOF | - | E.C. TO BRANCH TO CONNECTION AS REQUIRED |
| E47 | DUPLEX | REFRIGERATED SANDWICH UNIT | K47 | 120 | 1 | 1/3 | 8.6 | - | - | FLOOR | 4' T.O.B. | 5-15P E.C. TO BRANCH TO CONNECTION AS REQUIRED |
| E56 | DUPLEX | UNDERCOUNTER FREEZER | K56 | 120 | 1 | 1/4 | 3.2 | - | - | WALL | 12' | 5-15P E.C. TO BRANCH TO CONNECTION AS REQUIRED |
| E58 | DUPLEX | REFRIGERATED EQUIP. STAND | K58 | 120 | 1 | 1/3 | 8.1 | - | - | WALL | 12' | 5-15P E.C. TO BRANCH TO CONNECTION AS REQUIRED |
| E59 | DUPLEX | UNDERCOUNTER REFRIGERATOR | K59 | 120 | 1 | 1/6 | 4.6 | - | - | WALL | 12' | 5-5 E.C. TO BRANCH TO CONNECTION AS REQUIRED |
| E71 | JUNCT. BOX | EXHAUST HOOD (LITES) | K71 | 120 | 1 | - | - | - | 1000 | FA | CLG | E.C. TO BRANCH TO CONNECTION AS REQUIRED |
| E73 | JUNCT. BOX | EXHAUST HOOD FIRE CABINET | K73 | 120 | 1 | - | - | - | - | FA | CLG | E.C. TO BRANCH TO CONNECTION AS REQUIRED |
| E83 | DUPLEX | MOBILE FRYER FILTER | K83 | 120 | 1 | 1/3 | 5.0 | - | - | WALL | 12' | E.C. TO BRANCH TO CONNECTION AS REQUIRED |
| E89 | DUPLEX | CONVECTION OVEN | K89 | 120 | 1 | 1/3 | 6.0 | - | - | WALL | 24' | E.C. TO BRANCH TO CONNECTION AS REQUIRED |
| E91 | JUNCT. BOX | ICE MACHINE | K91 | 120 | 1 | - | 14.2 | - | - | WALL | 60' | E.C. TO BRANCH TO CONNECTION AS REQUIRED |
| E99 | DUPLEX | AIR POT COFFEE BREWER | K99 | 120-208 | 1 | - | 30.0 | - | - | WALL | 50' | E.C. TO BRANCH TO CONNECTION AS REQUIRED |
| E10 | DUPLEX | HEAT LAMP | K10 | 120 | 1 | - | - | - | 800 | FLOOR | 60' | E.C. TO BRANCH TO CONNECTION AS REQUIRED |
| E11 | DUPLEX | MICROWAVE OVEN | K11 | 120 | 1 | - | 9.6 | - | 1000 | FLOOR | 4' T.O.B. | 5-15P E.C. TO BRANCH TO CONNECTION AS REQUIRED |
| E13 | DUPLEX | FRY WARMER | K13 | 120 | 1 | - | 7.7 | - | 870 | WALL | 12' | 5-15P E.C. TO BRANCH TO CONNECTION AS REQUIRED |
| E17 | DUPLEX | TOASTER | K17 | 120 | 1 | - | 13.8 | 16 | - | FLOOR | 4' T.O.B. | 5-15P E.C. TO BRANCH TO CONNECTION AS REQUIRED |
| E30 | DUPLEX | PRINTERS (BY OTHERS - VERIFY) | K30 | 120 | 1 | - | 15.0 | - | - | WALL | 50' | E.C. TO BRANCH TO CONNECTION AS REQUIRED |
| E31 | DUPLEX | POS SYST. (BY OTHERS - VERIFY) | K31 | 120 | 1 | - | 15.0 | - | - | WALL | 50' | E.C. TO BRANCH TO CONNECTION AS REQUIRED |
| E32 | DUPLEX | BEER KEG COOLER | K32 | 120 | 1 | 1/3 | 8.5 | - | - | WALL | 50' | 5-15P E.C. TO BRANCH TO CONNECTION AS REQUIRED |
| MARKET | | | | | | | | | | | | |
| E631 | DUPLEX | MERCHANDISER REFRIGERATOR | M631 | 120 | 1 | 1/2 | 10.6 | - | - | WALL | 12' | 5-15P E.C. TO BRANCH TO CONNECTION AS REQUIRED |
| E639 | DUPLEX | MICROWAVE OVEN | M639 | 120 | 1 | - | 9.6 | - | 1000 | WALL | 12' | 5-15P E.C. TO BRANCH TO CONNECTION AS REQUIRED |
| S-BAR | | | | | | | | | | | | |
| E202 | DUPLEX | REFRIGERATED BACKBAR CABT | S202 | 120 | 1 | 1/3 | 7.6 | - | - | WALL | 12' | 5-15P E.C. TO BRANCH TO CONNECTION AS REQUIRED |
| E205 | DUPLEX | UNDERCOUNTER REFRIGERATOR | S205 | 120 | 1 | 1/8 | 2.5 | - | - | WALL | 12' | 5-15P E.C. TO BRANCH TO CONNECTION AS REQUIRED |
| E208 | DUPLEX | FOOD WARMER | S208 | 120 | 1 | - | 13.7 | - | 1650 | WALL | 50' | 5-15P E.C. TO BRANCH TO CONNECTION AS REQUIRED |
| E209 | DUPLEX | FRY WARMER | S209 | 120 | 1 | - | 7.7 | - | 870 | WALL | 12' | 5-15P E.C. TO BRANCH TO CONNECTION AS REQUIRED |
| E210 | DUPLEX | MICROWAVE/CONVECTION OVEN | S210 | 208 | 1 | - | 30.0 | 5.99 | 870 | WALL | 12' | 6-30P E.C. TO BRANCH TO CONNECTION AS REQUIRED |
| E28 | DUPLEX | SELF-SERVICE COMBO MERCH | S28 | 220 | 1 | - | 13.895 | - | - | FLOOR | 4' T.O.B. | 14-20P E.C. TO BRANCH TO CONNECTION AS REQUIRED |
| E224 | DUPLEX | BLENDER STATION | S224 | 120 | 1 | - | 13.0 | - | - | FLOOR | 4' T.O.B. | - E.C. TO BRANCH TO CONNECTION AS REQUIRED |
| E225 | DUPLEX | BLENDER | S225 | 120 | 1 | - | 13.0 | - | 1500 | FLOOR | - | - E.C. TO BRANCH TO CONNECTION AS REQUIRED |
| E226 | DUPLEX | SODA GUN + COCKTAIL STATION | S226 | 120 | 1 | - | 15.0 | - | - | FLOOR | 4' T.O.B. | - E.C. TO BRANCH TO CONNECTION AS REQUIRED |
| E228 | DUPLEX | GLASSWASHER | S228 | 208-240 | 1 | 1/2 | 12.9 | - | 2600 | FLOOR | - | - E.C. TO BRANCH TO CONNECTION AS REQUIRED |
| E229 | DUPLEX | SANDWICH MAKE UP UNIT | S229 | 120 | 1 | 1/3 | 8.6 | - | - | FLOOR | 12' | - E.C. TO BRANCH TO CONNECTION AS REQUIRED |
| VENDING | | | | | | | | | | | | |
| E551 | JUNCT. BOX | ICE MACHINE | V551 | 120 | 1 | - | 15.0 | - | - | WALL | 60' | E.C. TO BRANCH TO CONNECTION AS REQUIRED |
| CO | DUPLEX | CONVENIENCE OUTLET | CO | 120 | 1 | - | 15.0 | - | - | - | 50' | - E.C. TO BRANCH TO CONNECTION AS REQUIRED |
| CO1 | DUPLEX | CONVENIENCE OUTLET | CO1 | 120 | 1 | - | 15.0 | - | - | - | 4' T.O.B. | - E.C. TO BRANCH TO CONNECTION AS REQUIRED |



| EXHAUST HOOD REQUIREMENTS | | | | | | | | | | |
|---------------------------|------------|-------------------------------|----------|------|-------|-----|-----|----|------------------|------------------------------------------|
| NUMBER | CONNECTION | SERVICE TO | ITEM NO. | VOLT | PHASE | HP | CFM | WC | LOCATION | REMARKS |
| KITCHEN | | | | | | | | | | |
| E73 | JUNCT. BOX | EXHAUST FAN (EXHAUST) | K71 | 208 | 3 | 150 | | | TO BE DETERMINED | E.C. TO BRANCH TO CONNECTION AS REQUIRED |
| E73 | JUNCT. BOX | EXHAUST FAN (SUPPLY) | K71 | 208 | 3 | 150 | | | TO BE DETERMINED | E.C. TO BRANCH TO CONNECTION AS REQUIRED |
| E37 | JUNCT. BOX | CONDENSATE EXH. FAN (EXHAUST) | K37 | 120 | 1 | 1/3 | | | | E.C. TO BRANCH TO CONNECTION AS REQUIRED |

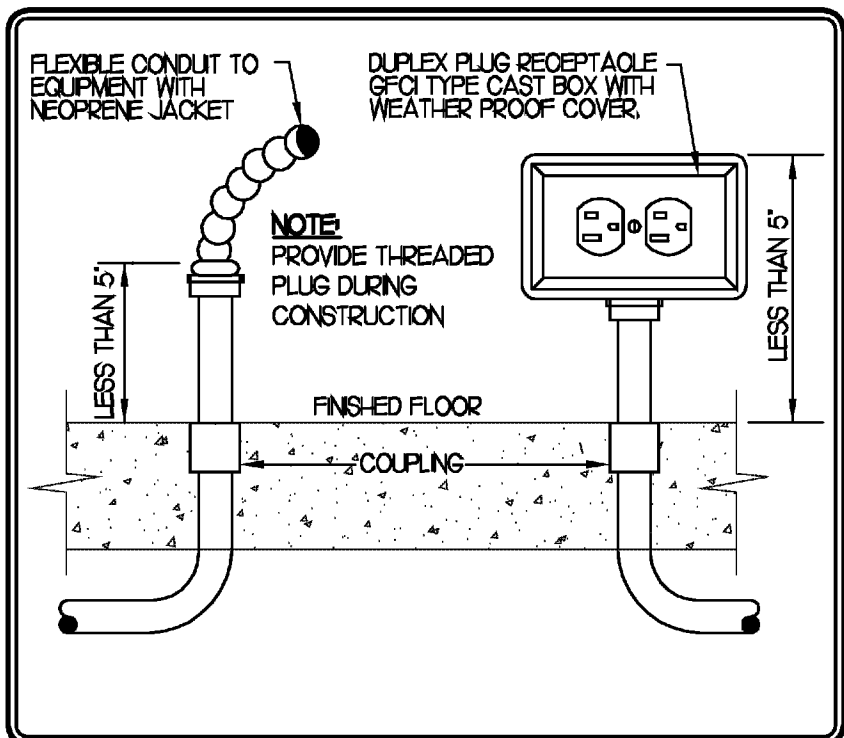

CONDUIT STUB-UP & RECEPTACLE DETAIL
NO SCALE

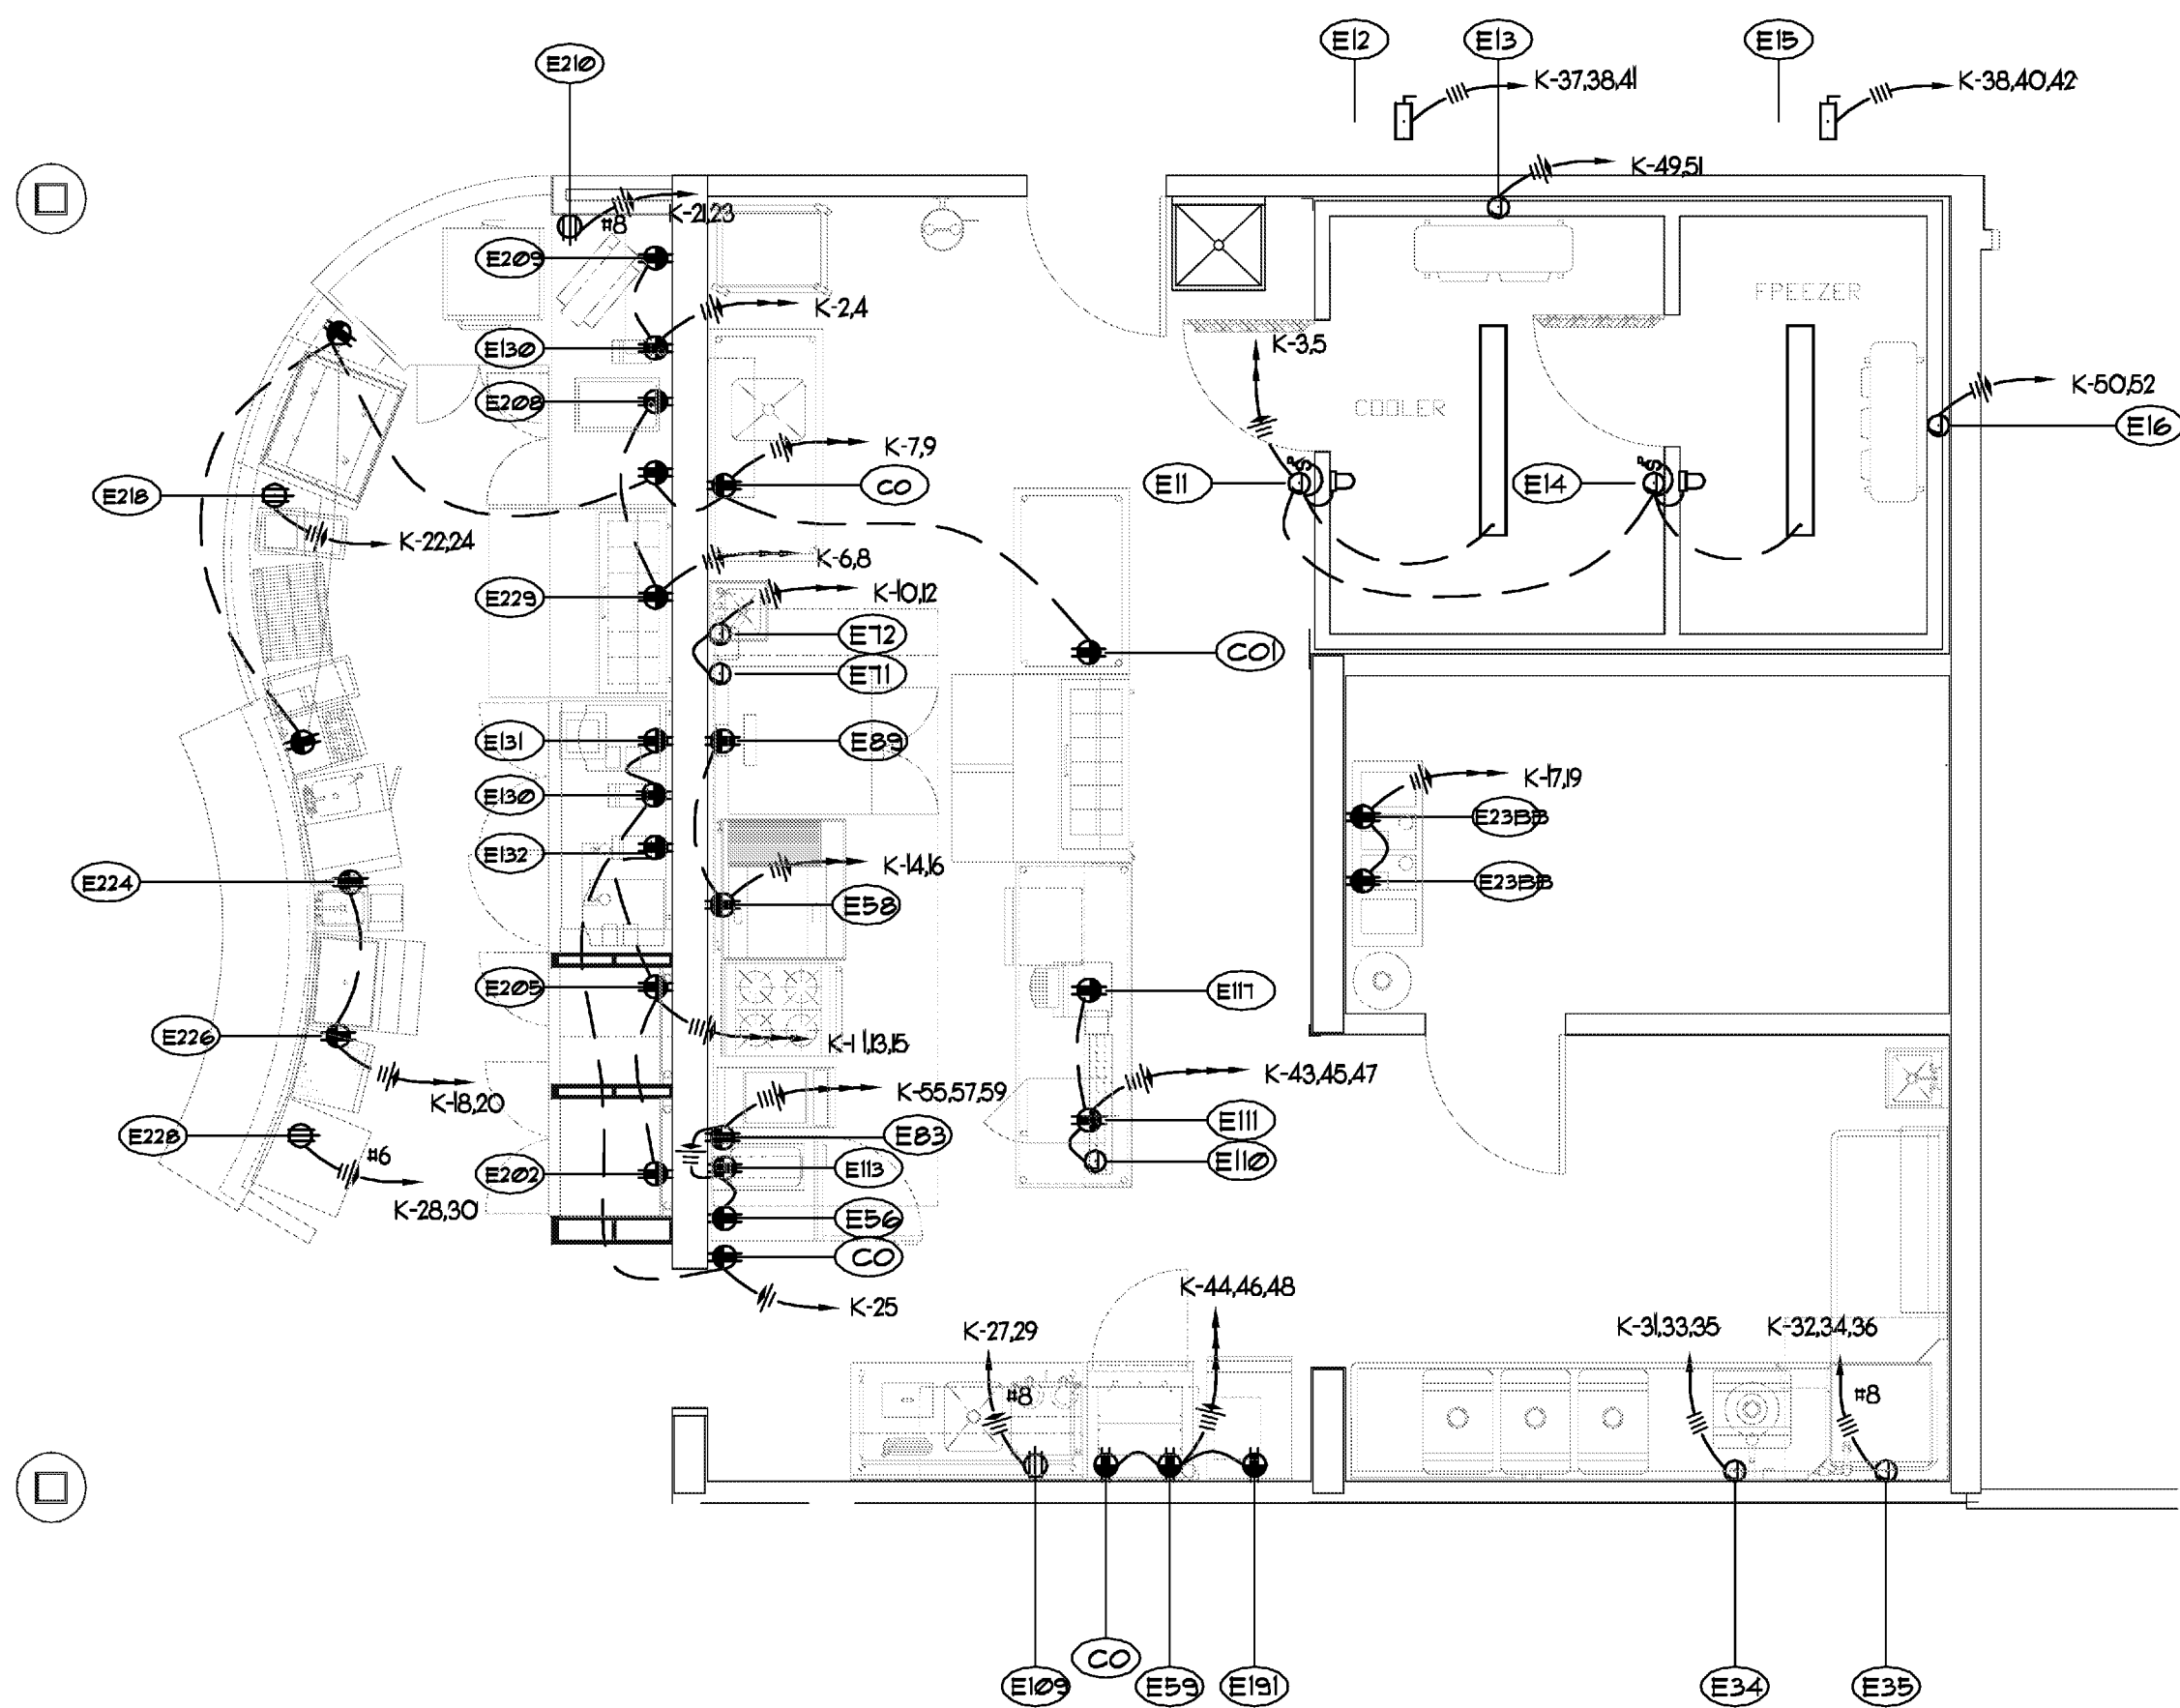

KITCHEN & BAR POWER PLAN
SCALE: 1/4" = 1'-0"

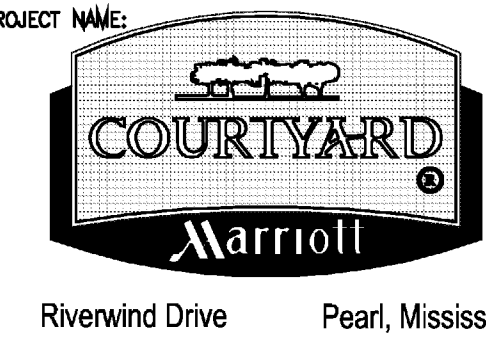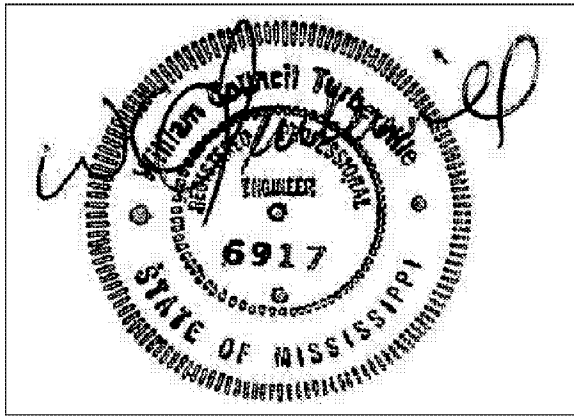

Riverwind Drive Pearl, Mississippi

SHEET TITLE:

TYPICAL GUESTROOM ELECTRICAL PLANS

PROJECT NO.

09017

LATEST REVISION:



DRAWN BY:

SMJ

CHECKED BY:

SMJ

SHEET NUMBER:

DATE:

9/01/11

E303