



Richard Molenaar
ARCHITECT

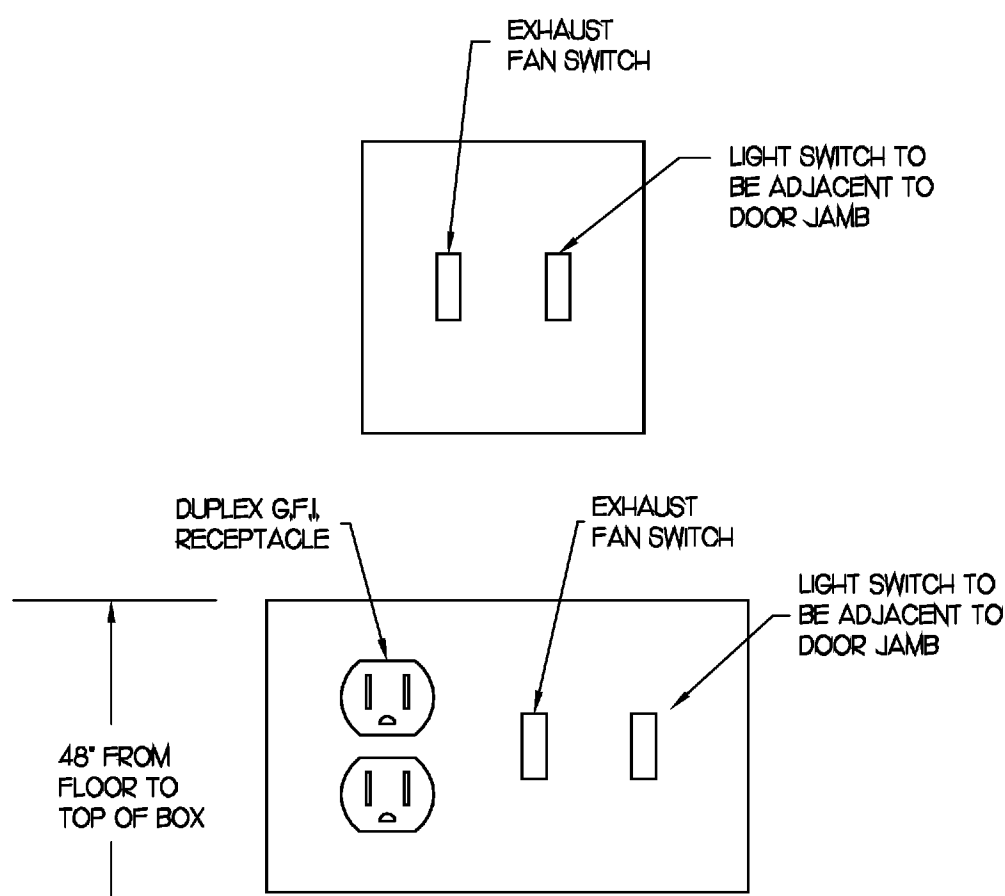


GUEST ROOM BATH
WALL SWITCH DETAILS
NO SCALE

NOTES:

- 1) ALL WORK SHALL CONFORM TO ALL LOCAL, STATE AND FEDERAL CODES INCLUDING THE LATEST EDITION OF THE NATIONAL ELECTRIC CODE AND ADA GUIDELINES.
- 2) ALL WIRE SIZES ARE BASED ON TYPE THW/THHN COPPER.
- 3) PROVIDE METERING EQUIPMENT AS DIRECTED BY LOCAL UTILITY.
- 4) PROVIDE CONCRETE PAD FOR UTILITY CO. TRANSFORMER AS DIRECTED BY LOCAL UTILITY COMPANY.
- 5) ELECTRICAL CONTRACTOR SHALL BE RESPONSIBLE FOR OBTAINING AND PURCHASING ALL NECESSARY LICENSES, PERMITS, & INSPECTIONS, AS WELL AS ANY OTHER NECESSARY FEES REGARDING THE ELECTRICAL INSTALLATION.
- 6) VERIFY ALL NECESSARY POWER COMPANY REQUIREMENTS FOR METERING, CT CABINETS, PRIMARY SERVICE CONDUITS AND ANY METERING CANS, SOCKETS, AND CONDUITS.
- 7) LOCATE LIGHTING CONTACTOR FOR PANEL "OL" NEXT TO THE PANEL AND THE PHOTOCELL CONTROLLING IT ON THE ROOF, ORIENTATED AS DIRECTED BY THE MANUFACTURER.
- 8) PAD MOUNTED TRANSFORMER BY LOCAL POWER COMPANY - PAD AS DIRECTED BY LOCAL POWER COMPANY. PROVIDE PRIMARY SERVICE ENTRANCE CONDUITS AND METERING CONDUITS & EQUIPMENT AS REQUIRED BY LOCAL POWER COMPANY.
- 9) ELECTRICAL CONTRACTOR SHALL PROVIDE NECESSARY 3" CONDUITS FROM THE TELEPHONE EQUIPMENT TO A POINT AND IN MANNER AS DIRECTED BY LOCAL TELEPHONE COMPANY.
- 10) ELECTRICAL CONTRACTOR SHALL PROVIDE NECESSARY 3" CONDUITS FROM THE PBX ROOM TO A POINT AND IN MANNER AS DIRECTED BY LOCAL SATELLITE / CABLE TELEVISION COMPANY.
- 11) PROVIDE UNDERGROUND ELECTRIC PRIMARY SERVICE ENTRANCE CONDUITS AS DIRECTED BY LOCAL UTILITY.
- 12) PROVIDE SURGE SUPPRESSORS AND LIGHTNING ARRESTORS ON SERVICE ENTRANCE.

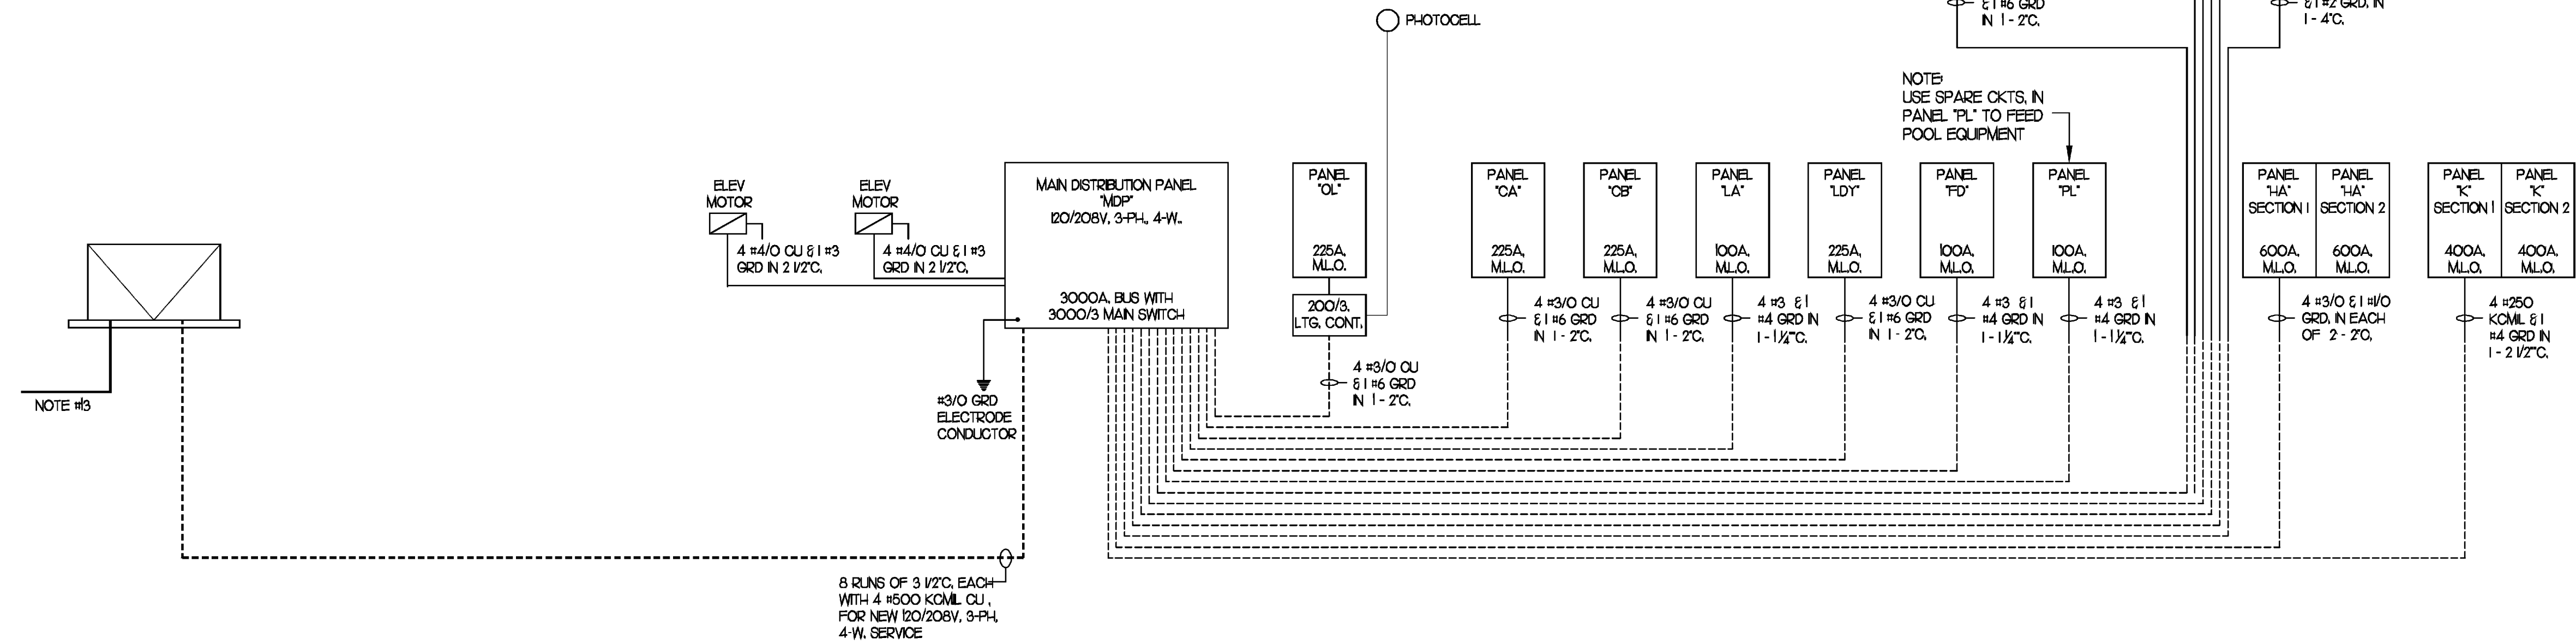


ELECTRICAL PANELBOARD ONE-LINE DIAGRAM
SCHEMATIC: NO SCALE

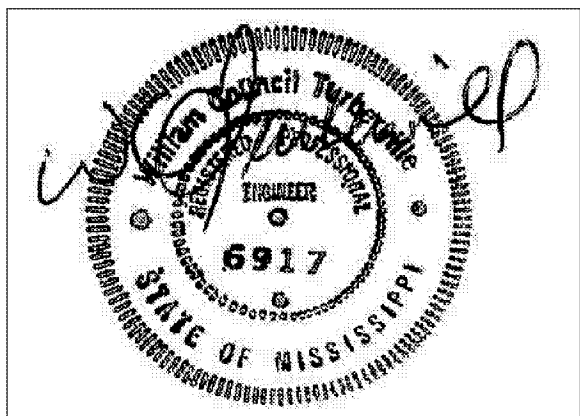

PROJECT NAME:
COURTYARD
Marriott
Riverwind Drive Pearl, Mississippi

SHEET TITLE:

ELECTRICAL PANELBOARDS ONE-LINE DIAGRAM

PROJECT NO. 09017 LATEST REVISION: 
DRAWN BY: SMJ CHECKED BY: SMJ SHEET NUMBER:
DATE: 9/01/11 **E401**