



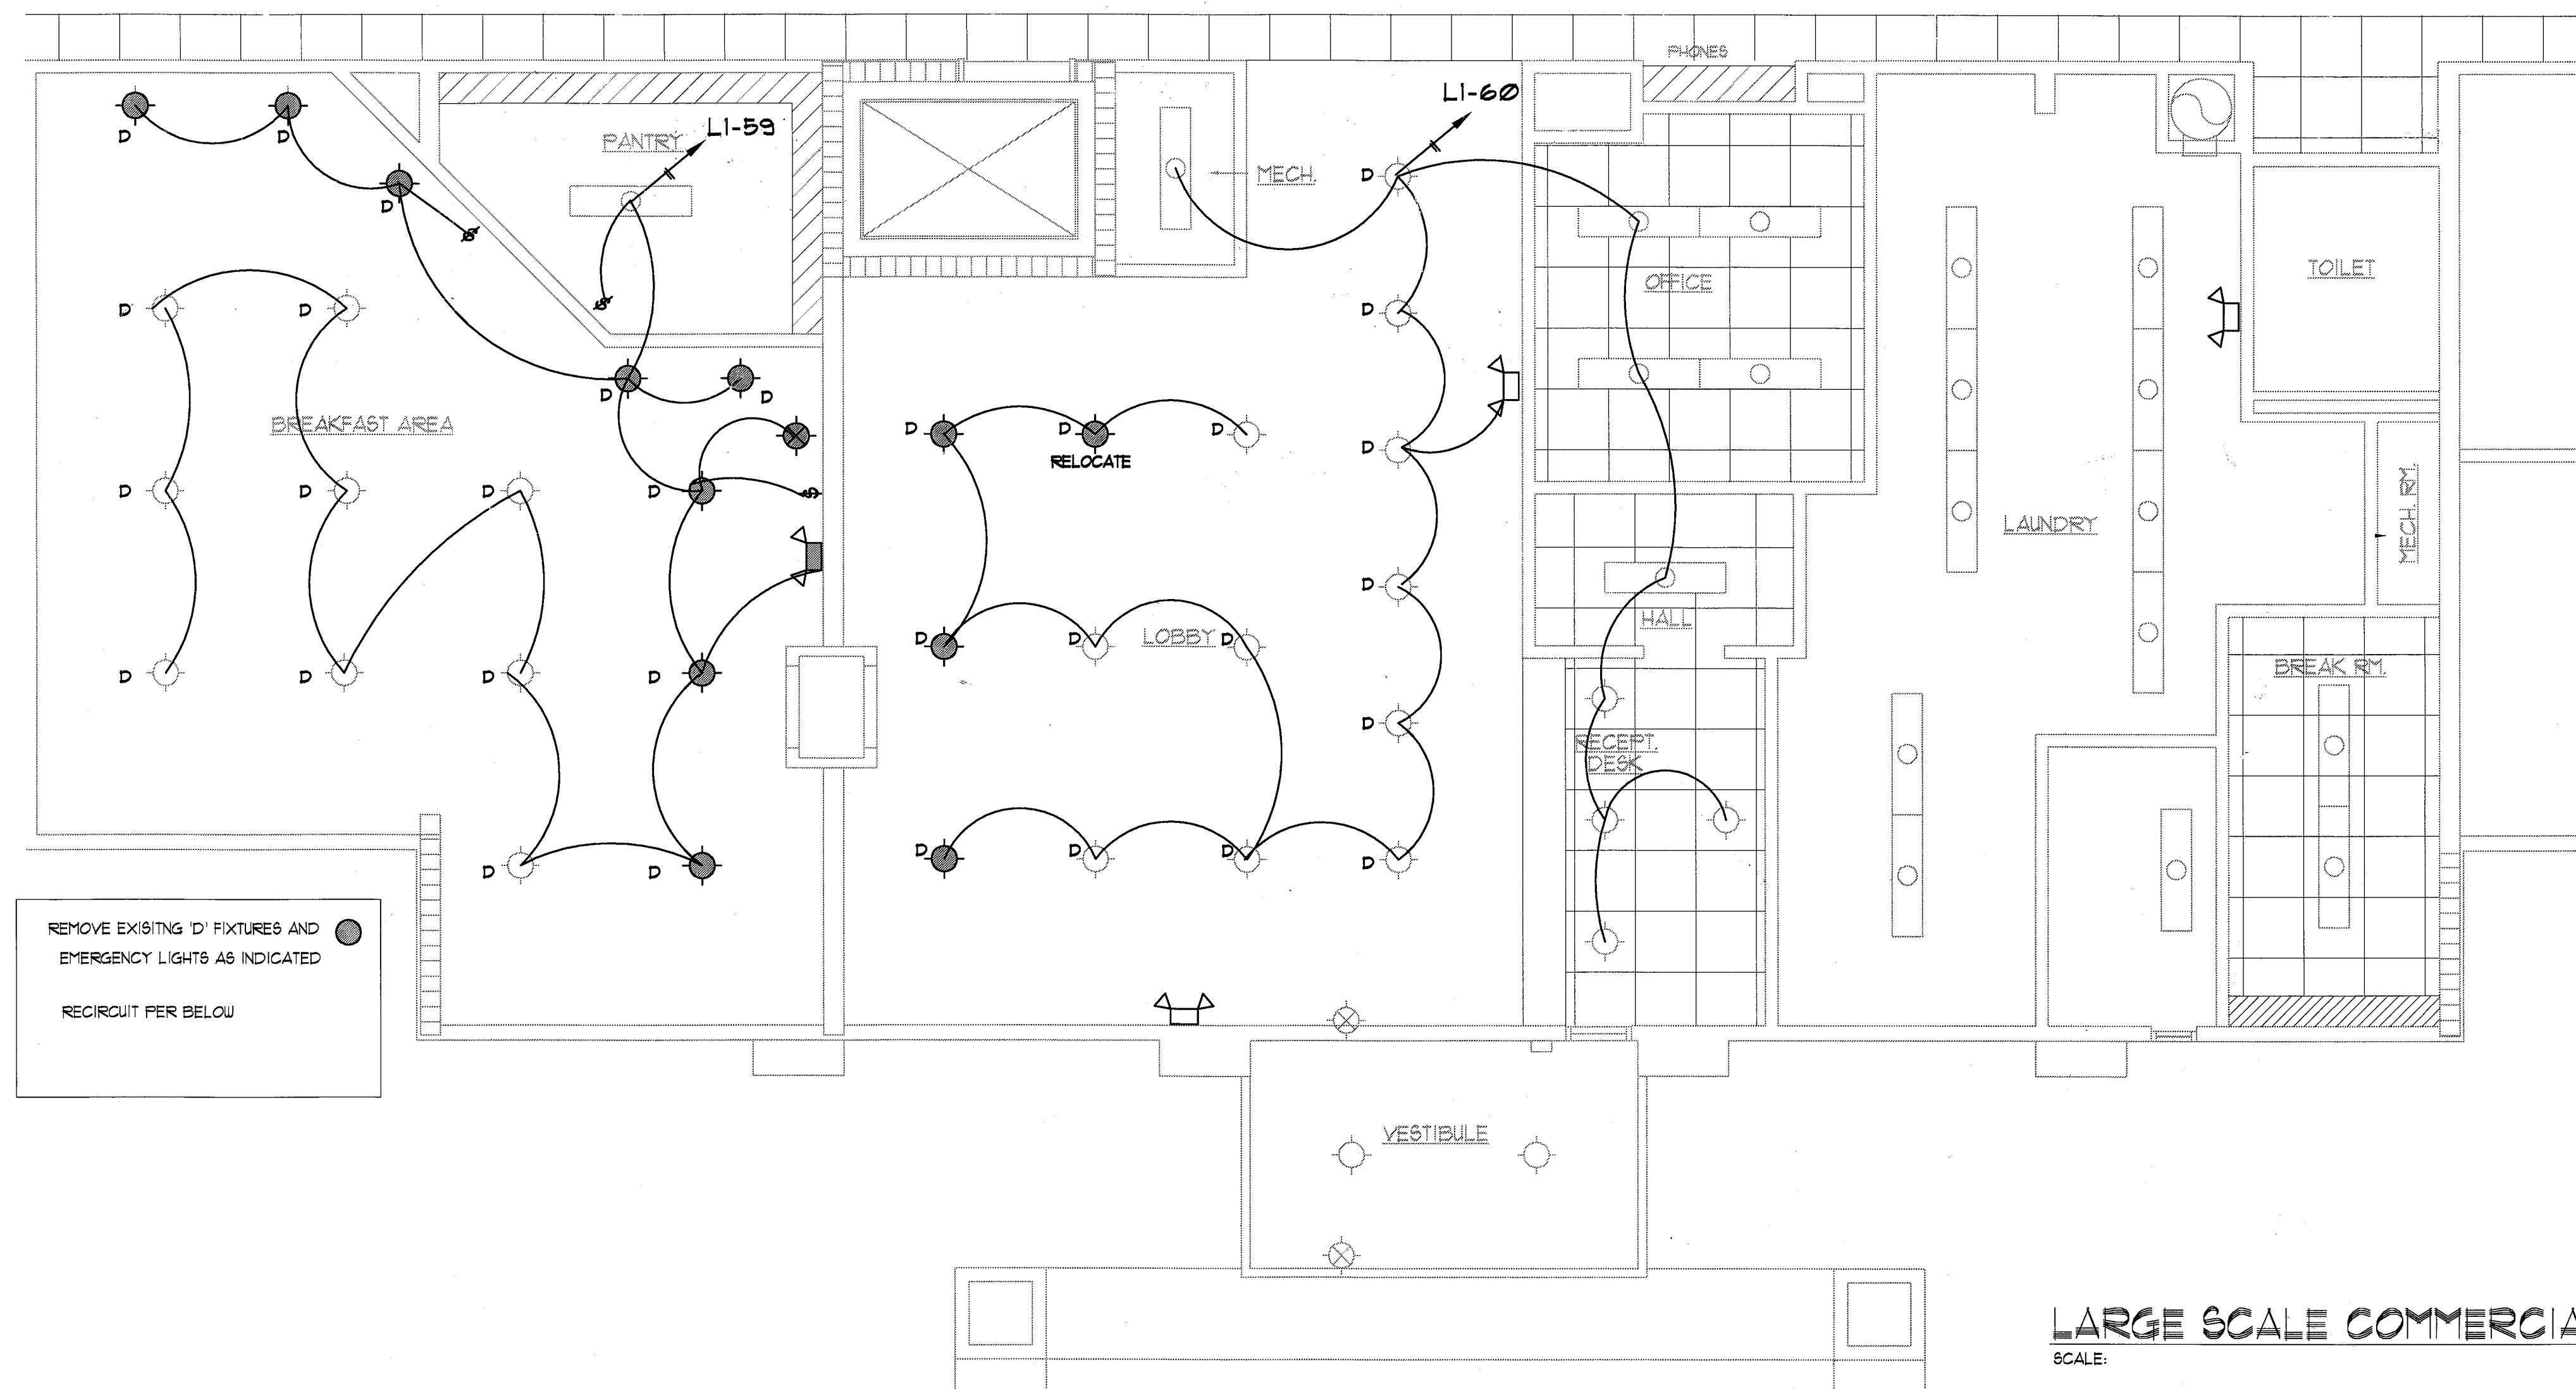

LARGE SCALE COMMERCIAL AREA DEMO LIGHTING PLAN

SCALE: 1/4" = 1'-0"

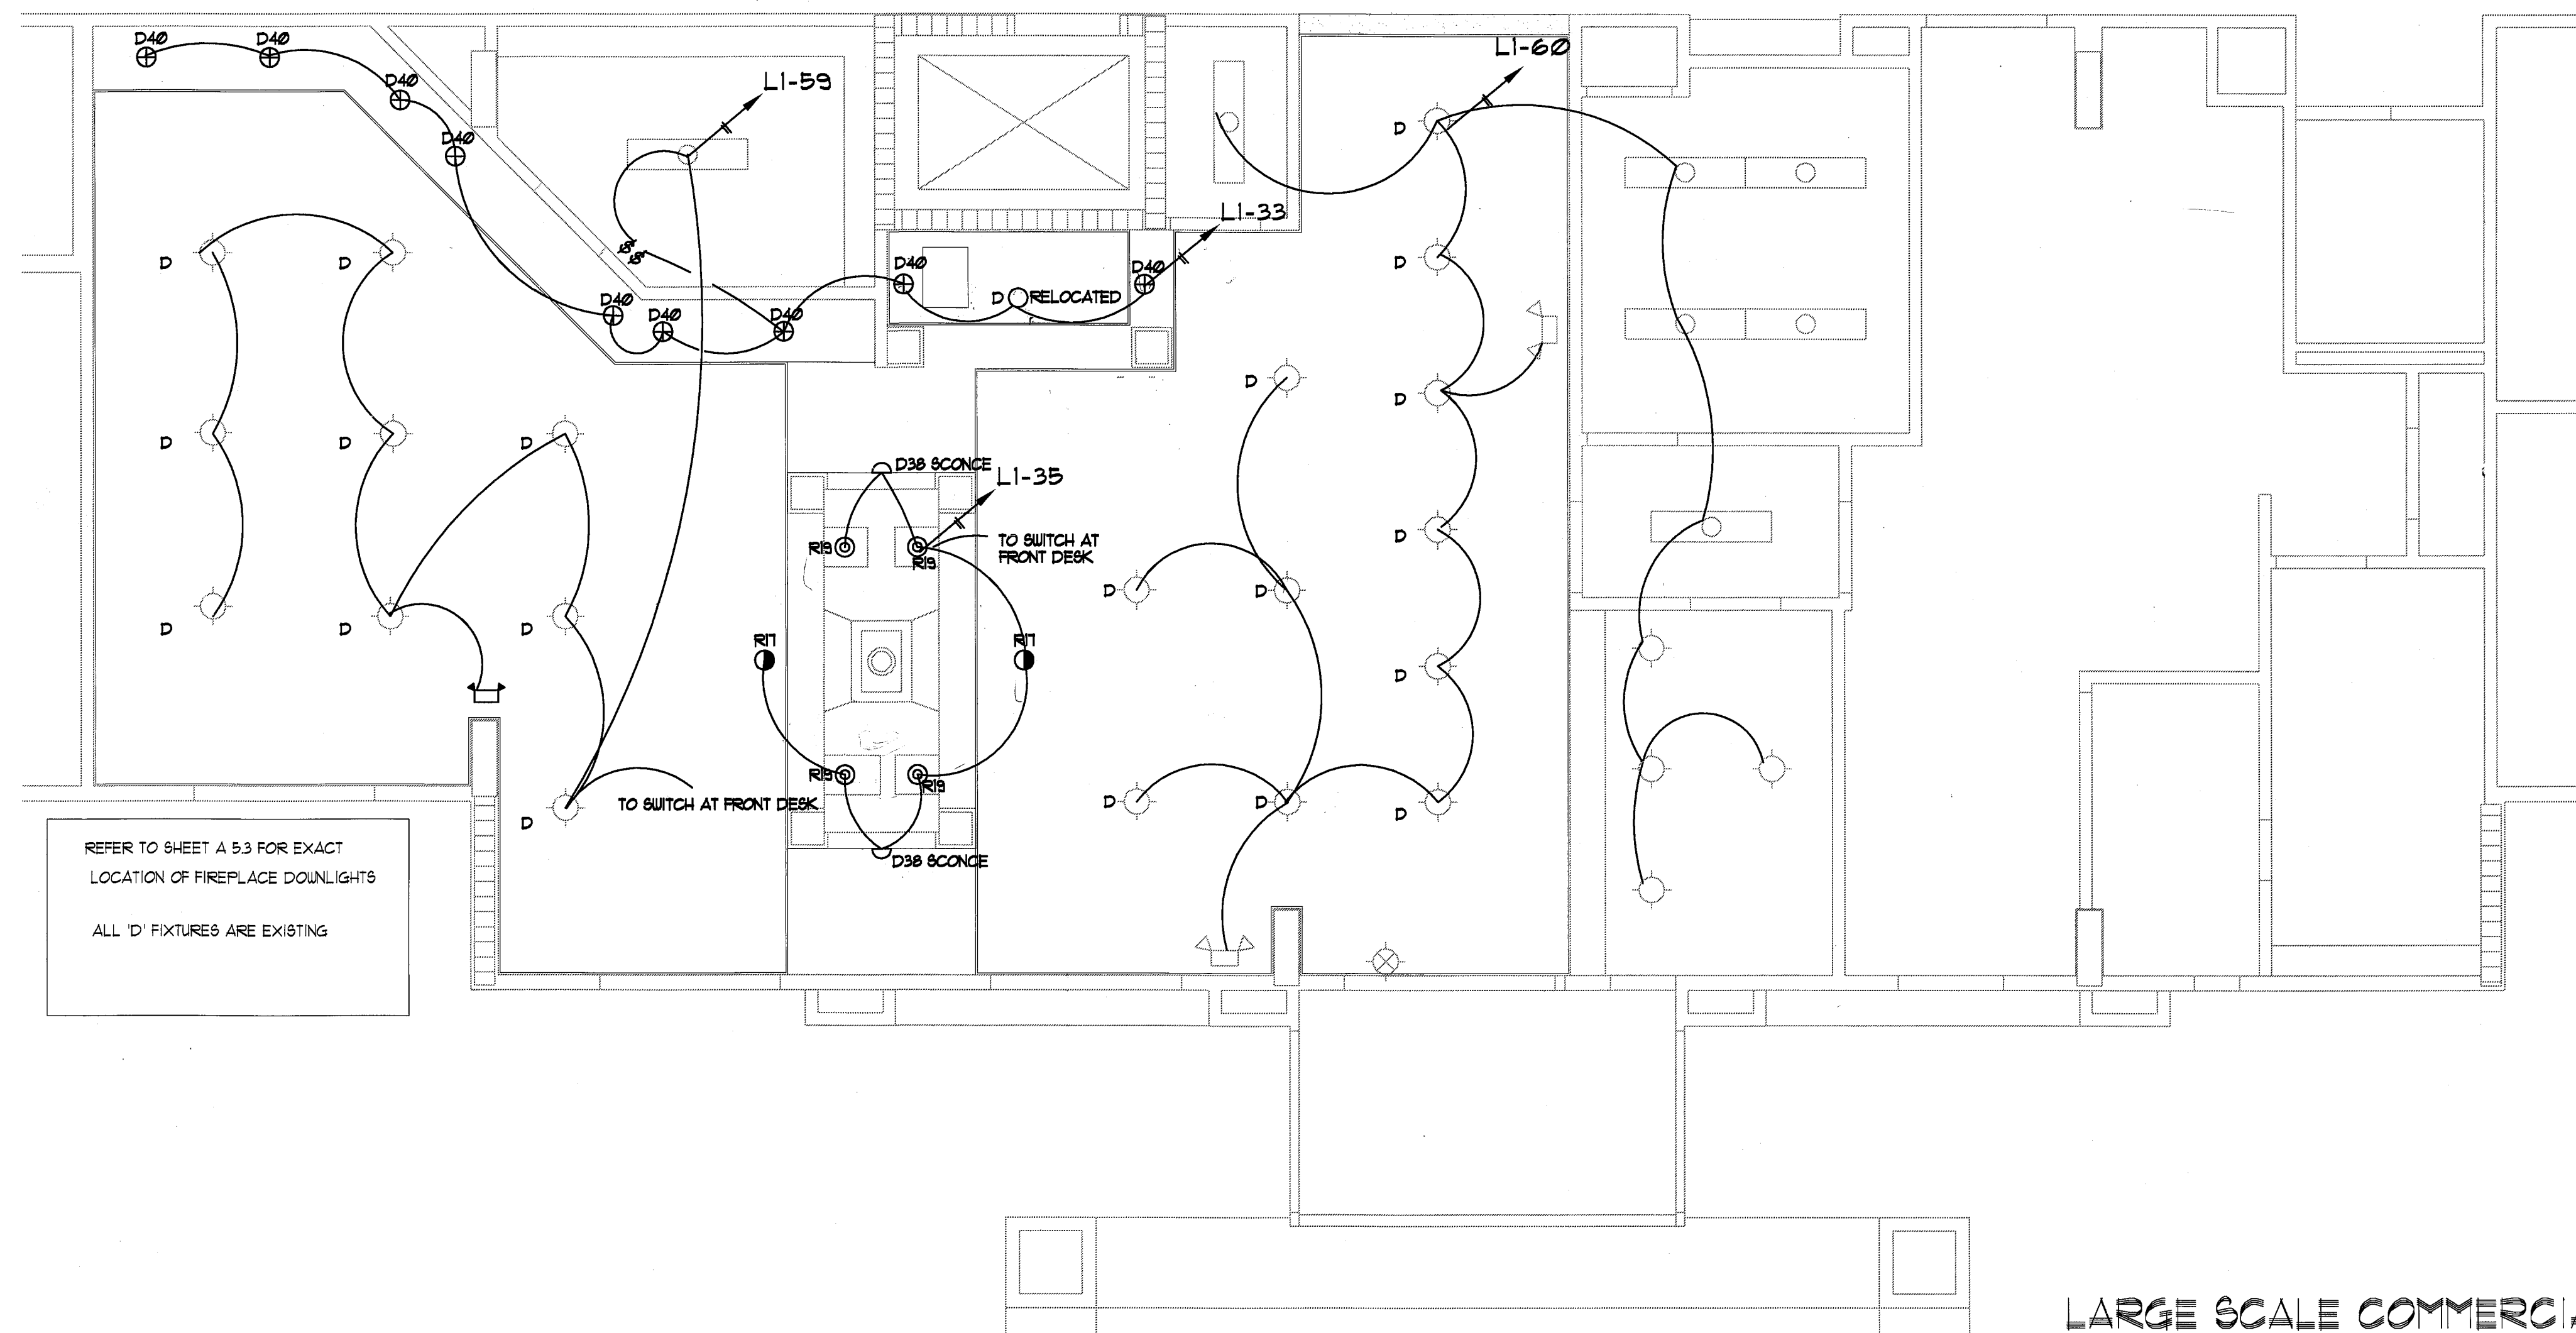

LARGE SCALE COMMERCIAL AREA REVISED LIGHTING PLAN

SCALE: 1/4" = 1'-0"

D40 Ship Mon ortves
D38 " " "

REFER TO SHEET E07 FOR
FIRE ALARM DETAILS, AND
SCHEDULES.

LLW Architects, Inc.
803 S. Mount Morat Suite 100B
Memphis, TN 38117
Business 901-683-7175
Fax 901-683-2885
e-mail: llw@llwarchitects.com

▲ revisions:

▲ seal:

Marriott
FAIRFIELD
INN & SUITES RENOVATION
Pearl, Mississippi

▲ title:
LARGE SCALE
COMMERCIAL
AREA LIGHTING
PLAN

▲ date: 10-08-04
▲ job: 1504
▲ file:
▲ scale: as noted
▲ drawn by: JEN

sheet
E05
of 1

COPYRIGHT BY LLW ARCHITECTS, INC. WARNING: UNAUTHORIZED COPYING VIOLATES U.S. COPYRIGHT LAWS AND WILL SUBJECT THE VIOLATOR TO LEGAL PROSECUTION.