

[illegible]

Information contained on this drawing and in all digital files associated is authorized for use on the project named herein only and is the property of MISHRA ARCHITECTURE PLLC and may not be reproduced in any manner without express written or verbal permission from authorized individuals. Original drawing is 24"x36" and scales are as indicated. ©2013 MISHRA ARCHITECTURE PLLC



KEY PLAN

Southern Hospitality
Services

Hampton Inn and Suites

5400 I-20 & Frontage Rd.
Monroe, LA 71201

Drawing Title

Enlarged Pool & King Studio
Plans Elevations

Phase
Construction Documents



Project No.	12-111	Sheet No.	
Prepared by	Author		
Checked by	Checker		A50
Date	Sept. 16, 2013		

Released for
PERMIT ONLY

Hampton Inn and Suites


GENERAL NOTES

1. HANDRAIL AND LADDER SHALL BE 1 1/2" DIA. STAINLESS STEEL.
2. THE POOL DRAWINGS & RELATED SPECS. ARE TO BE CONSIDERED AS MINIMUM REQUIREMENTS. THE G.C. & POOL CONTRACTOR ARE RESPONSIBLE FOR THE IMPLEMENTATION OF ALL APPLICABLE CODES ASSOCIATED WITH THE CONSTRUCTION TECHNIQUE OF THE POOL AREA & THE POOL EQUIPMENT ROOM.
3. DRAINAGE FOR THE DECK AREA MUST BE PROVIDED BY TRENCH DRAIN OR SLOPING DECK TOWARDS LANDSCAPED AREA. CONTRACTOR TO PROVIDE TWO POOL DRAINS.
4. AN EMERGENCY HOUSE PHONE MUST BE PROVIDED AT THE POOL. IT MUST BE IN A WEATHER TIGHT ENCLOSURE. WHEN THE RECEIVER IS LIFTED, THE PHONE MUST AUTOMATICALLY DIAL THE FRONT DECK. THE TOP OF THE PHONE MUST BE MOUNTED NO HIGHER THAN 48" FROM THE FLOOR.
5. GENERAL CONTRACTOR TO PROVIDE UNDERWATER LIGHTS AND CONNECTIONS TO POOL DRAINS.

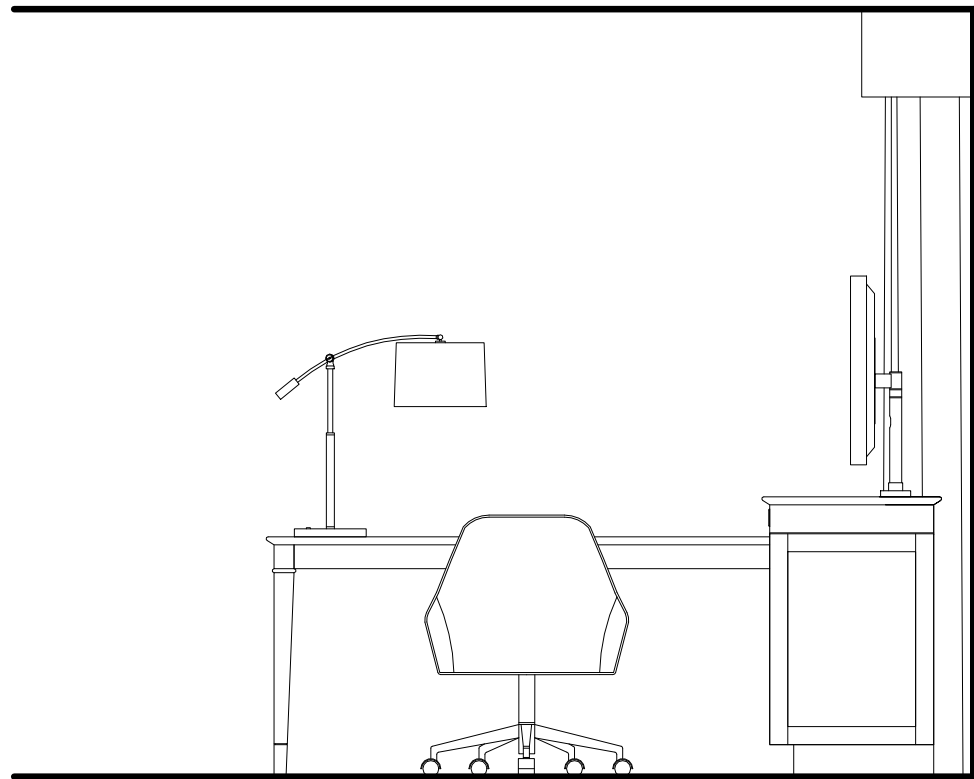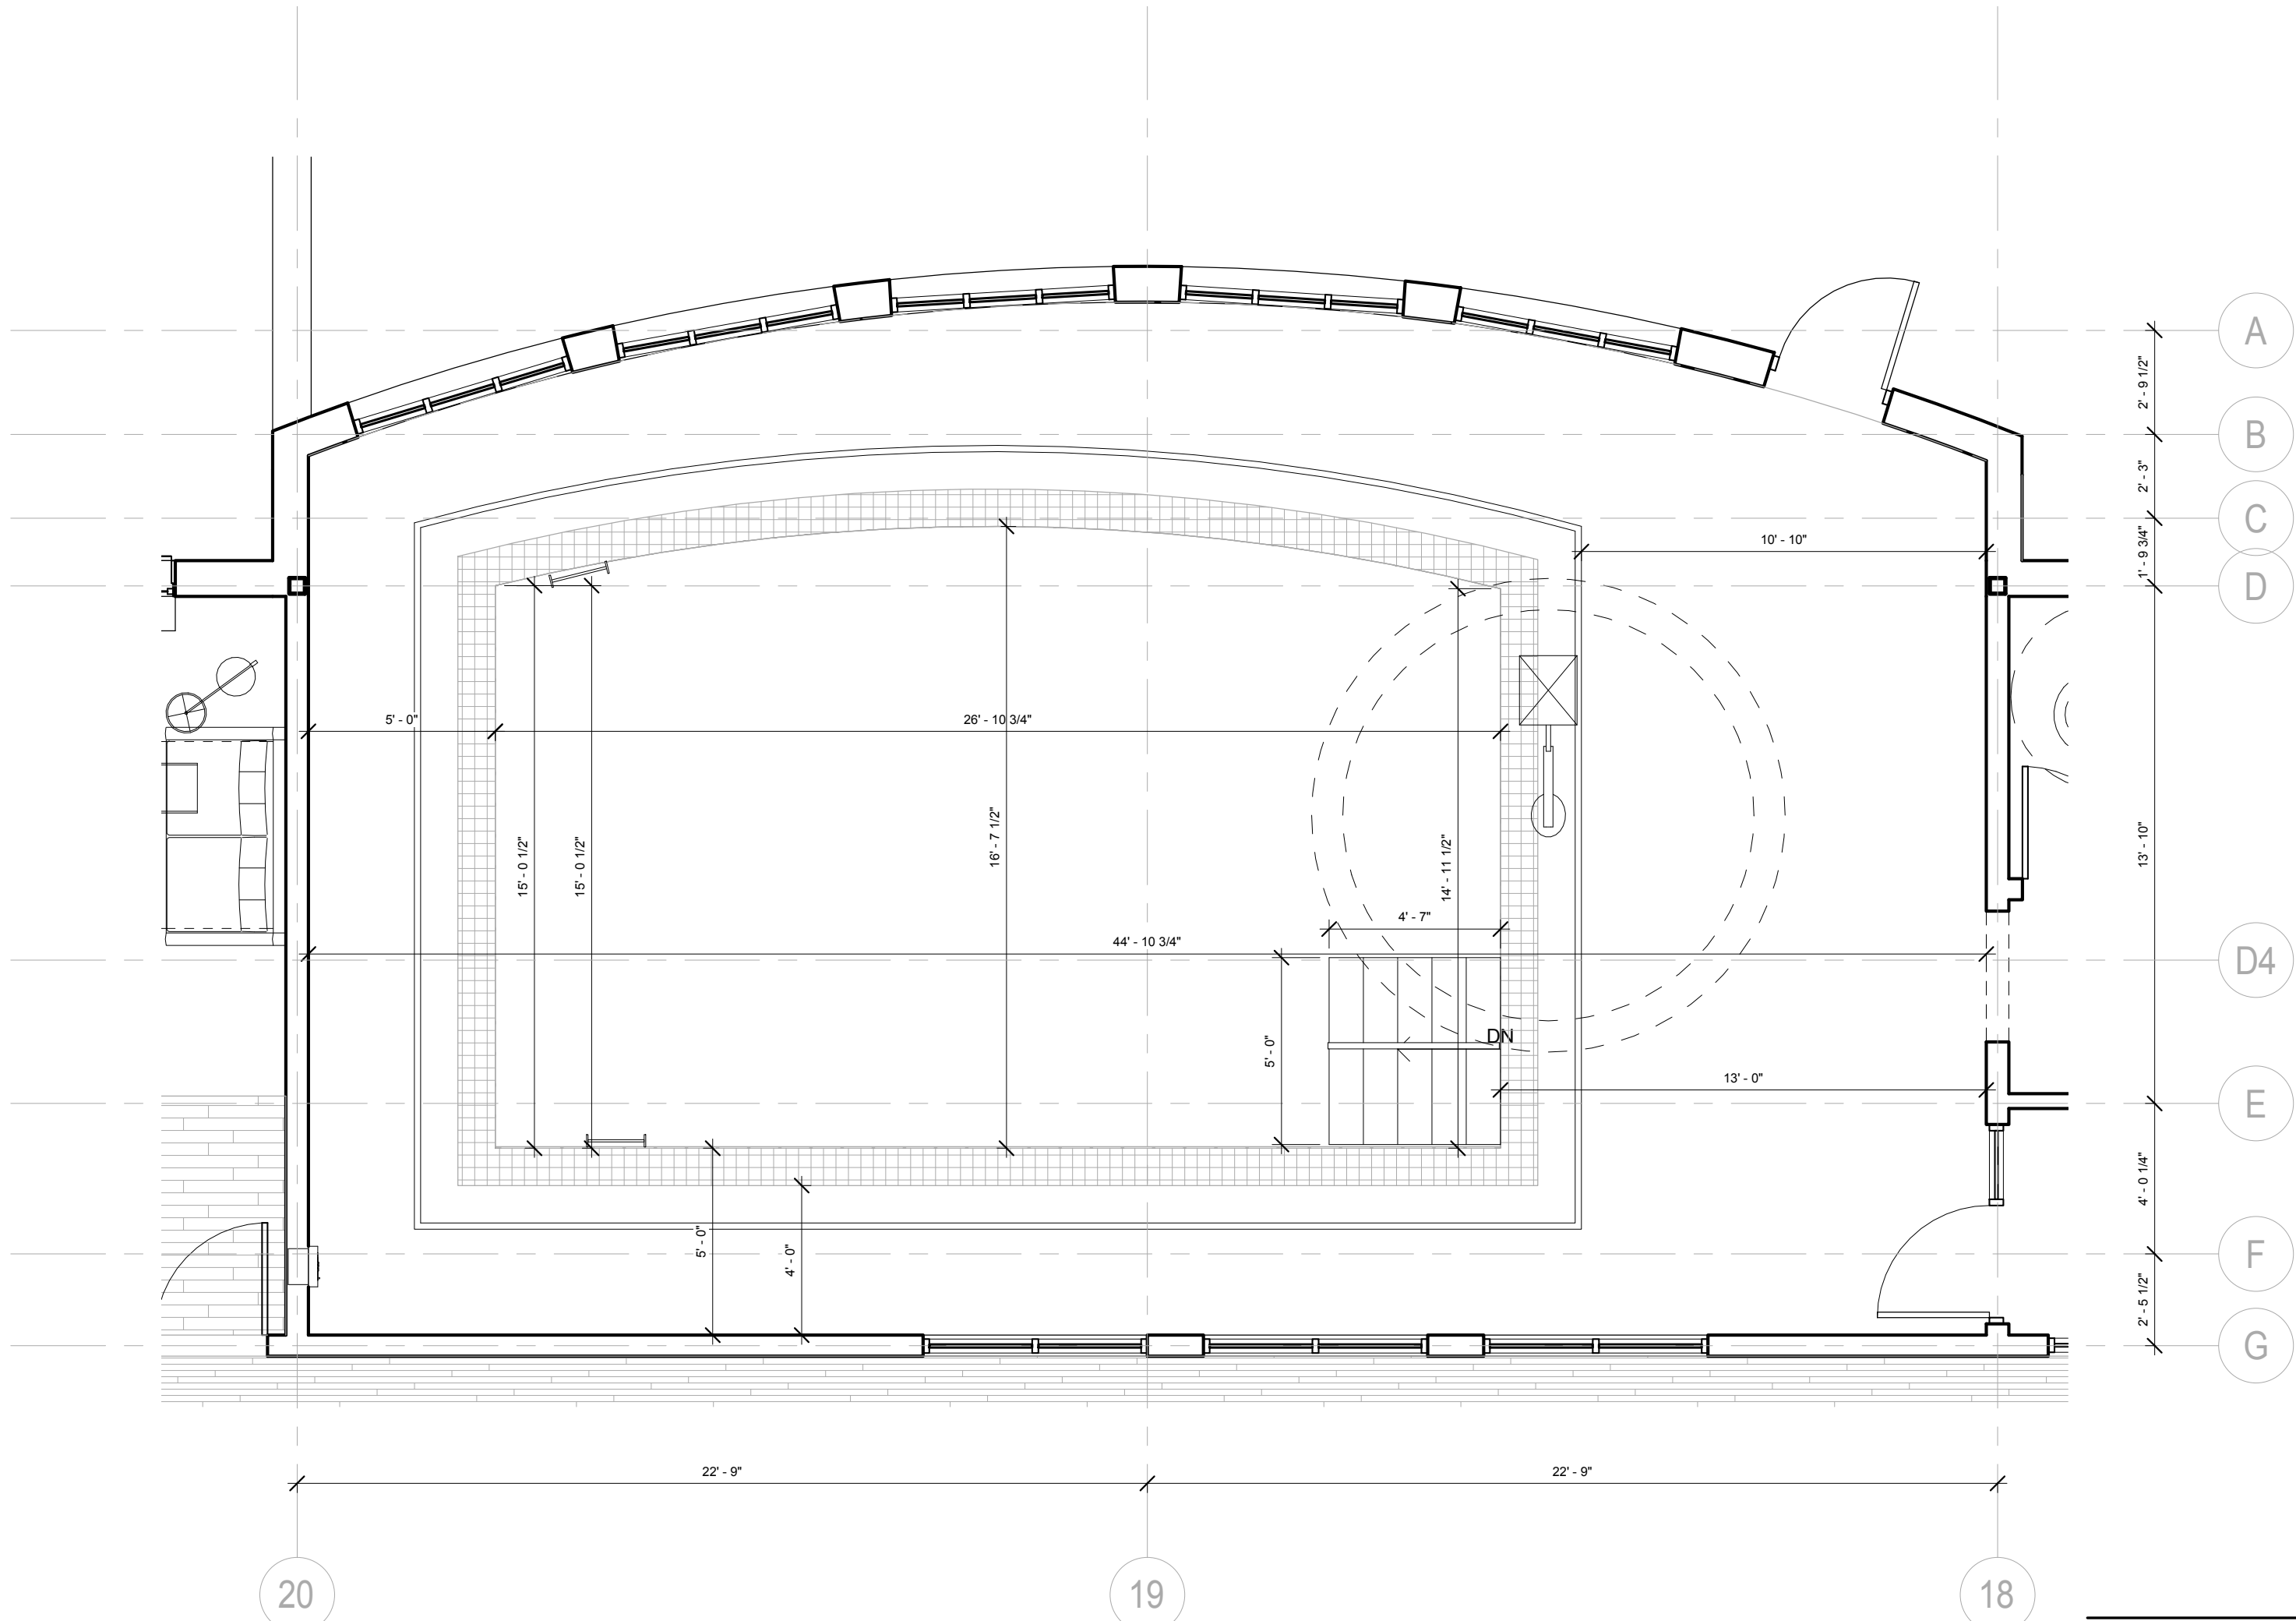


3 ELEVATION-SUITE DIVIDER
1/2" = 1'-0"

<u>ELECTRICAL OUTLET HEIGHTS (U.N.O.)</u>		
TYPICAL WALL OUTLET	-	18" A.F.F.
BATHROOM VANITY OUTLET	-	48" A.F.F.
ACC. BATHROOM VANITY OUTLET	-	44" A.F.F.

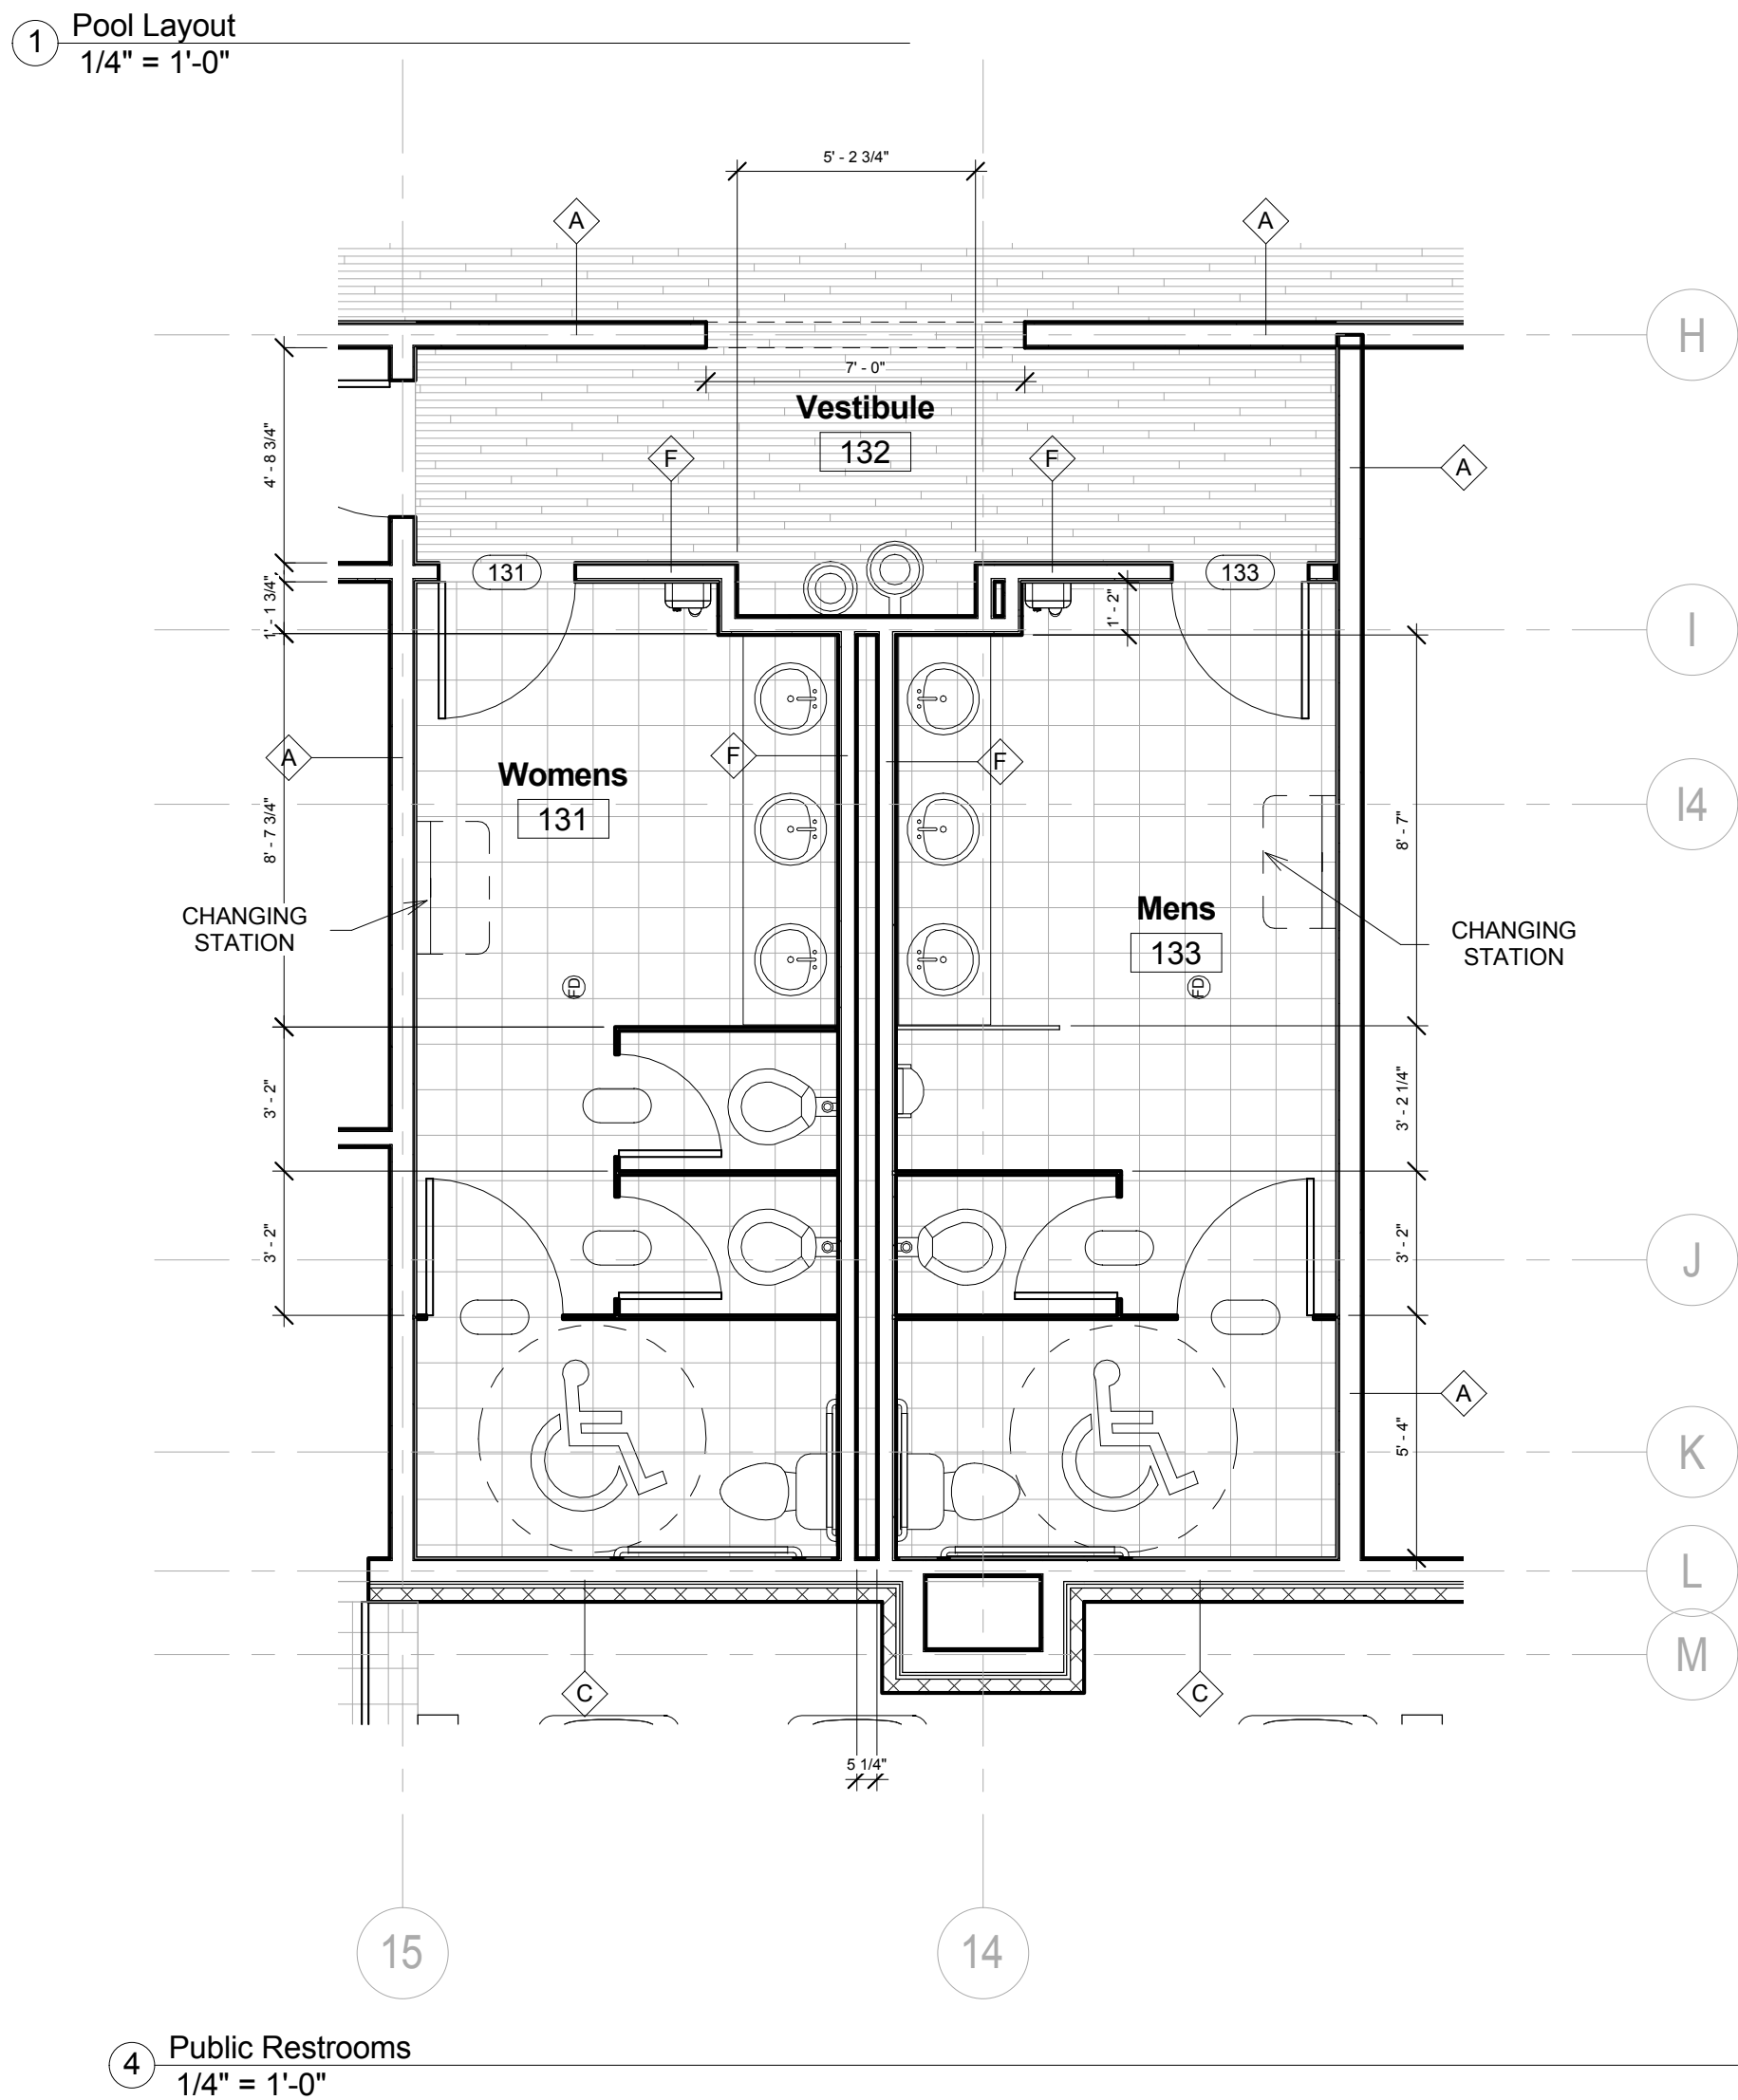

② FLOOR FINISH PLAN
1/2" = 1'-0"

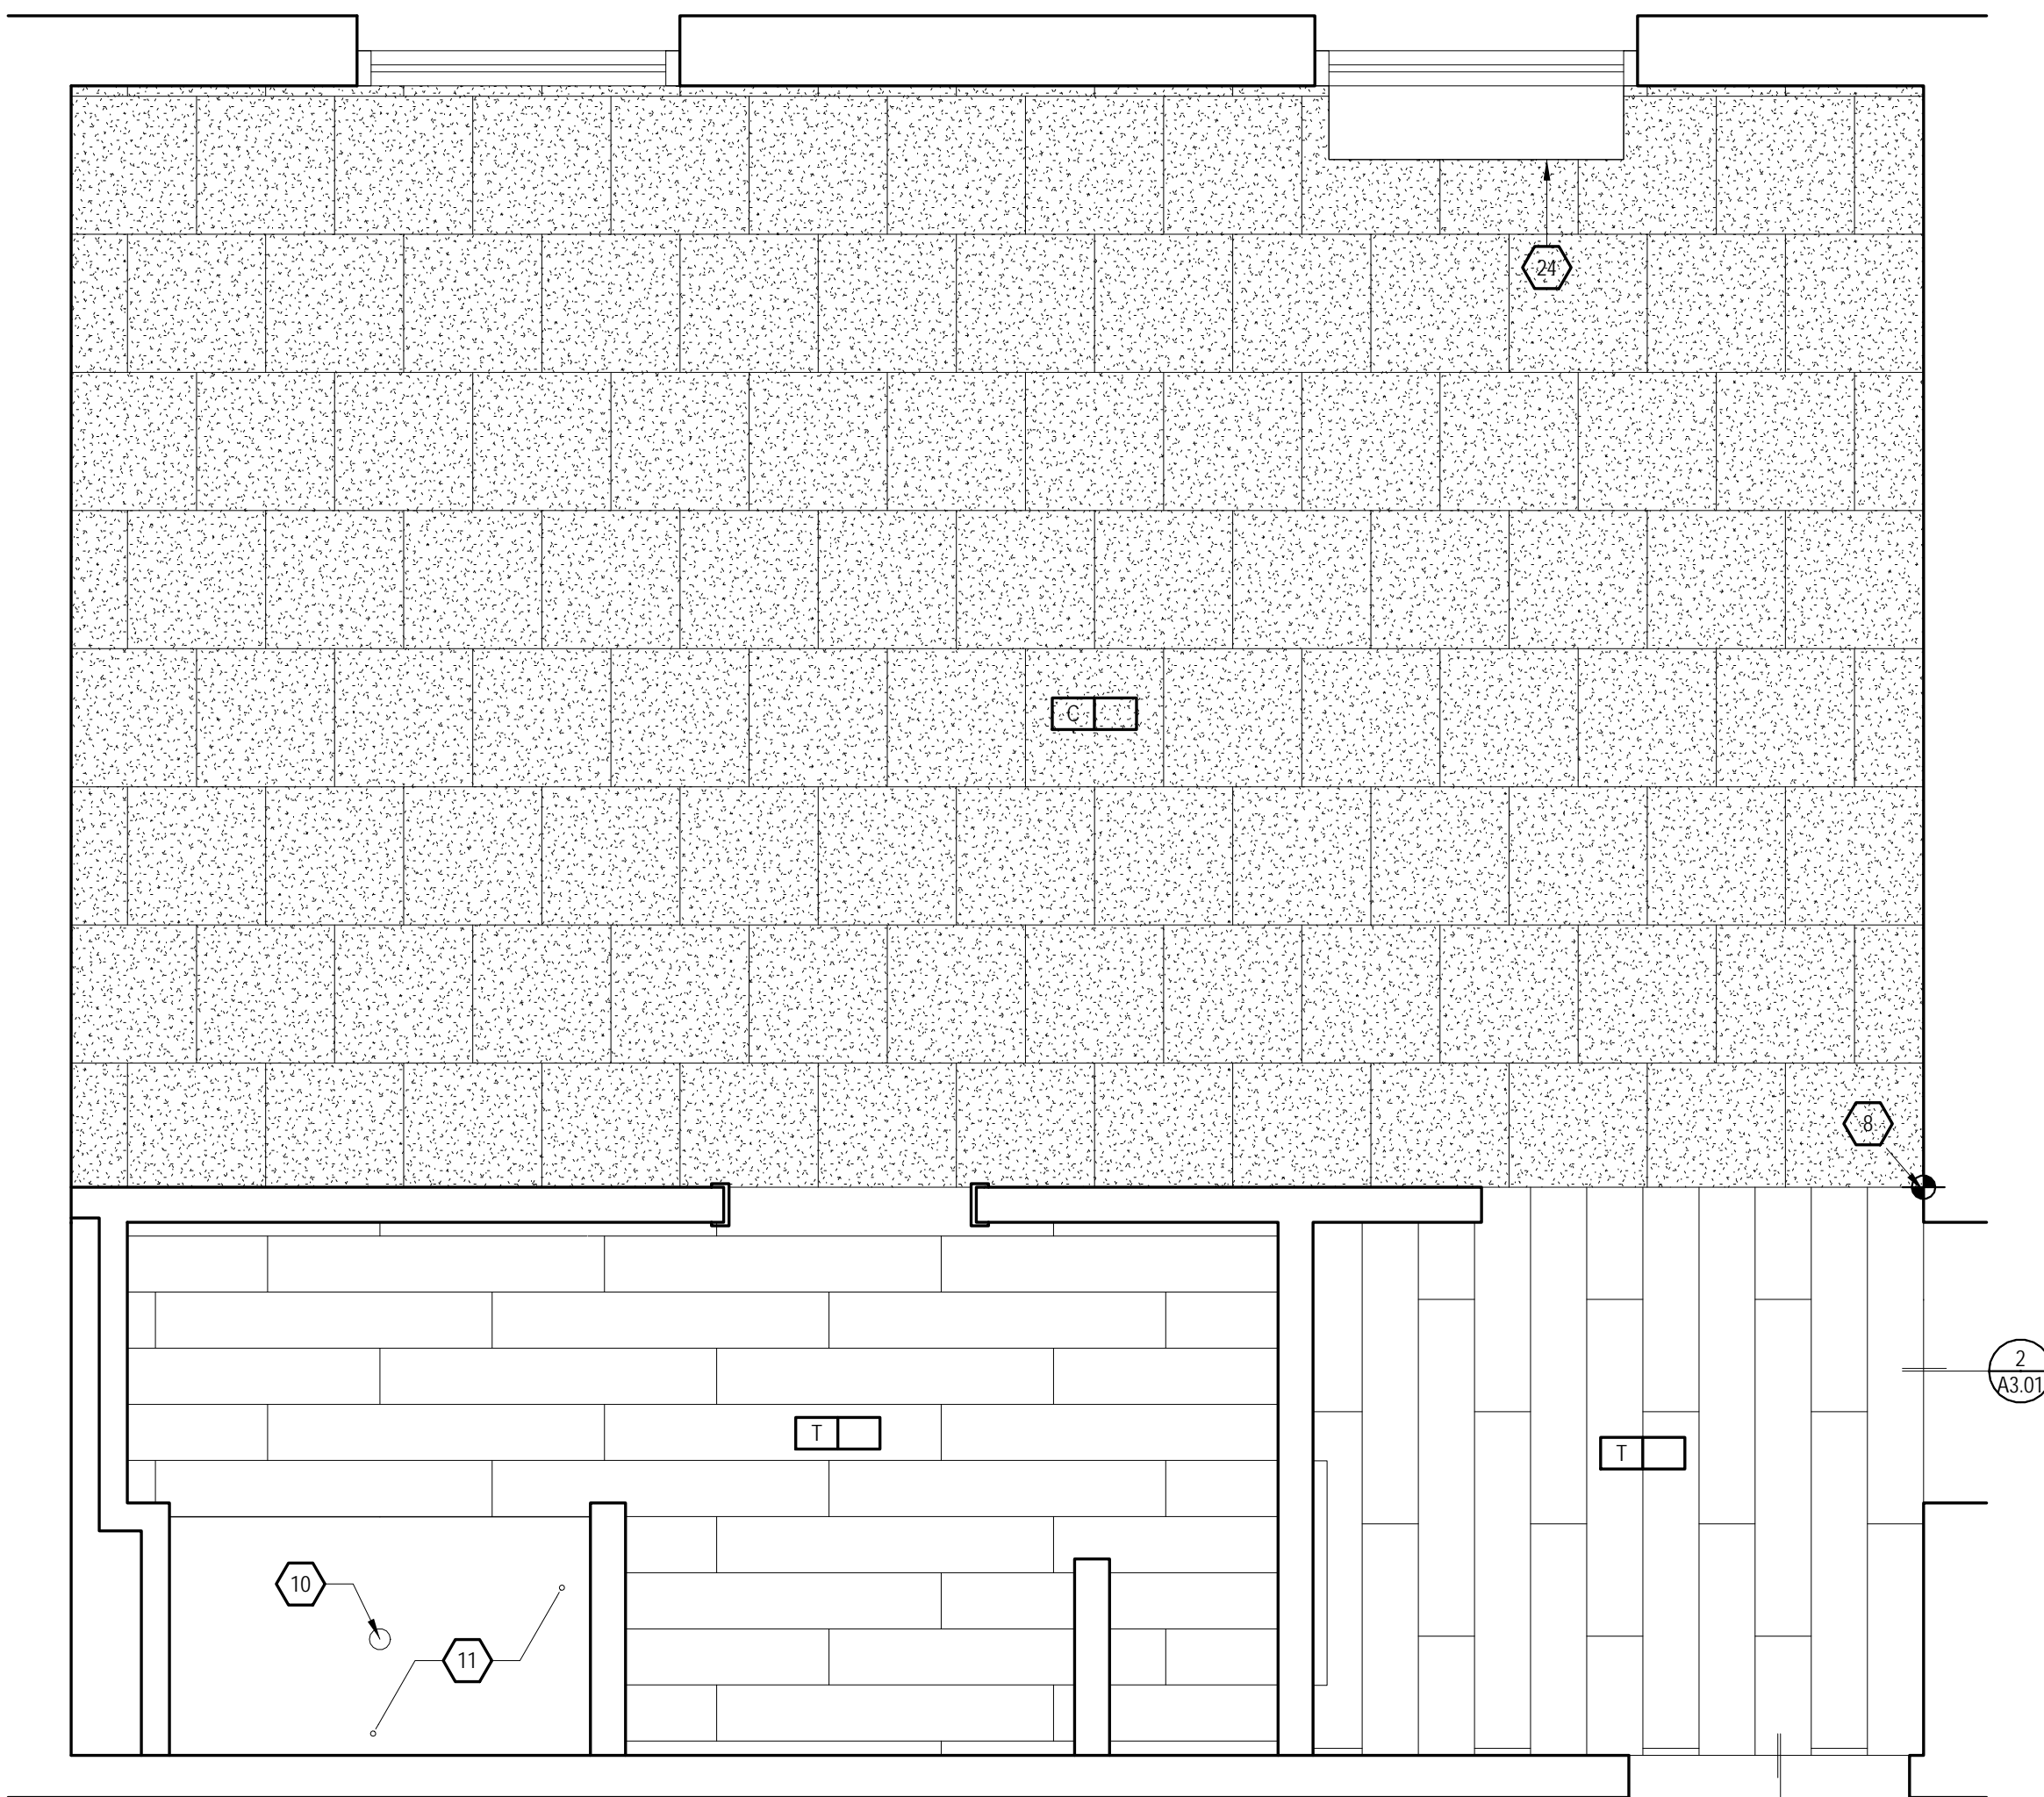

② FLOOR FINISH PLAN
1/2" = 1'-0"

[illegible]




 











 

















 


TURNING LEGEND:

000 ACTIVITY CHAIR
-001 OTTOMAN
-002 SLOA SLEEPER
-003 SINGLE ADINA SLEEPER
-004 ADINA ARM CHAIRSE
-005 LOUNGE CHAIR
-006 SUECROMA VANTY LIGHT
-202 BEDSIDE TABLE LAMP AT NIGHTSTAND
-203 ADINA NIGHTSTAND SLEEPER
-206 DOUBLE NIGHTSTAND SLEEPER
-205 DESK LAMP
-206 FLOOR LAMP
-300 STREAMLINE UNIT
-301 HEADBOARD
-302 QUEEN HEADBOARD
-303 DOUBLE HEADBOARD
-304 NIGHTSTAND
-305 DOUBLE NIGHTSTAND WITH POWER
-306 DOUBLE NIGHTSTAND WITH POWER
-307 C TABLE
-308 68" VANTY AT GUEST BATH
-309 68" VANTY AT GUEST BATH
-310 ADINA VANTY AT GUEST BATH
-311 STREAMLINE DIVIDER UNIT
-312 ADINA STREAMLINE UNIT
-313 ADINA STREAMLINE DIVIDER UNIT
-314 42" VANTY AT GUEST BATH
-315 ADINA LAMPE DESK UNIT
-316 WINDOW TREATMENT WITH P/AC
-401 WINDOW TREATMENT WITHOUT P/AC
-402 ROLLER CHAIR
-500 ARTWORK AT GUESTROOM
-501 ARTWORK AT GUEST BATH
-502 ARTWORK AT SOFA IN SUITE
-503 FRAME MIRROR AT VANITY
-504 FRAME MIRROR AT SOFA
-505 FRAME MIRROR AT ADINA VANTY
-600 BED MIRROR
-601 ADINA MATTRESS SET
-602 QUEEN BEDDING SET
-603 ADINA QUEEN BEDDING SET
-604 QUEEN BED BASE
-605 QUEEN MATTRESS SET
-606 ADINA QUEEN BEDDING SET
-607 ADINA QUEEN BED BASE

FINISH LEGEND:	
B	BASE
C	CARPET
MIR	MIRROR
PT	PAINT
ST	STONE
SF	SPECIAL FINISH
T	TILE
VCT	VINYL COMPOSITE TILE
WC	WALL COVERING
WD	WOOD FINISH

NOTE:
REFER TO FF&E SPECIFICATIONS MANUAL AND COLOR AND MATERIALS SPECIFICATIONS MANUAL FOR FURNITURE ITEMS NOT IDENTIFIED WITHIN THESE DRAWINGS

CEILING LEGEND: (X"X"Y)	
A.	PRIMED & PAINTED GYPSUM BOARD
B.	PRIMED & PAINTED GYPSUM BOARD - MOISTURE RESISTANT
C.	UNDERSIDE OF FLOOR/ROOF SYSTEM - PRIMED AND PAINTED - REFER TO STANDARDS

ELECTRICAL LEGEND	
PLAN	ELEV
	 DUPLICATION OUTLET
	 DUPLEX OUTLET
	 GFI OUTLET
	 TELEPHONE OUTLET
	 TV OUTLET
	 SWITCH
	 REMOTE THERMOSTAT
	 SMOKE DETECTOR
	 STORAGE (IN C.F. ROOMS ONLY)
	 FIRE HORN/STROKE (IN C.F. ROOMS ONLY ONLY FIRE HORNS WHEN THESE ARE USED)
	 FIRE HORN (NON-C.F. ROOMS)
	 SIDE WALL SPRINKLER HEAD
	 DOBBERELL LIGHT (C.F. ROOMS ONLY)
	 HSA (WHEREVER APPLICABLE)
	 JUNCTION BOX
	 EXHAUST FAN
	 LIGHT AT CEILING
	 DOBBERELL - MOUNT AT 46' AFF TO CENTER OF BUTTON (C.F. ROOMS ONLY)

CEILING LAYOUT LEGEND:

The diagram illustrates the symbols used in a ceiling layout. It includes a plan view of a room with a dashed line indicating a center fixture in space. Below this, there are three rows of symbols: a circle with a crosshair, a circle with a dot, and a circle with a crosshair. To the right of these symbols are their respective descriptions: 'CENTER FIXTURE IN SPACE', 'ALIGN FIXTURES', and 'CENTER OVER'.

CENTER FIXTURE IN SPACE
- CENTER THE FIXTURE IN SPACE IDENTIFIED BY DIAGONAL LINE.

ALIGN FIXTURES
- ALIGN FIXTURES ALONG CENTERLINE SHOWN

CENTER OVER
- CENTER FIXTURE OVER CENTERLINE OF ADJACENT CONSTRUCTION

GENERAL NOTES:	
1.	WALLS BETWEEN ADJACENT ROOMS - ELECTRICAL OUTLET LOCATIONS, INCLUDING TV AND TELEPHONE OUTLETS, SHALL BE OFFSET 6" MIN. HORIZONTALLY - BACK TO BACK OUTLETS ARE NOT ALLOWED.
2.	COMMUNICATION FEATURE ROOMS SHALL BE EQUIPPED WITH VISIBLE FIRE ALARMS AND NOTIFICATION DEVICES FOR DOOR KNOCKBELL AND TELEPHONE.
3.	COMMUNICATION FEATURE ROOM MUST HAVE A VISIBLE NOTIFICATION DEVICE FOR THE TELEPHONE.
4.	ACCESSIBLE ROOMS SHALL BE EQUIPPED WITH TOGGLE-TYPE SWITCHES.