

MISHRA
ARCHITECTURE PLLC

6800 S. Creek Rd., Charlotte, NC 28277
Ph: (704) 625-6554 Fax: (704) 919-5822
EMAIL: sashh@mishraarch.com
WEB: www.mishraarch.com

CML:
CML, Inc. and Bedford & Associates, Inc.
105 Commercial Parkway
West Monroe, LA 71294
Phone: (318) 386-3227
Email: gauberry@bedfordengineering.com

STRUCTURAL:


STRUP, INC.
11122 E. 11th Avenue, Suite 201
Charlotte, NC 28277
Phone: (704) 542-7199
Fax: (704) 542-7195
Email: mng@strupinc.com

ELECTRICAL:
R. Stine Riter, P.E.
11122 E. 11th Avenue, Suite 201
Charlotte, NC 28277
Phone: (704) 516-0385
Email: stine@ritering.com
Project Number: 13015

MECHANICAL:
W. Stine Riter Engineering Group, P.C.
212 North McDowell St., Suite 204
Charlotte, NC 28204
Phone: (704) 334-7963
Fax: (704) 334-4069
Email: dw@wstineeng.com

REVISIONS		
No.	Date	Description

Information contained on this drawing and in all detail files associated is authorized for use on the project named herein only and is the property of MISHRA ARCHITECTURE PLLC and may not be reproduced, stored in a retrieval system, or transmitted in any form or by any means, written or verbal permission from MISHRA ARCHITECTURE PLLC. Original drawing is 24x36 and scales are as indicated. 2011 MISHRA ARCHITECTURE PLLC

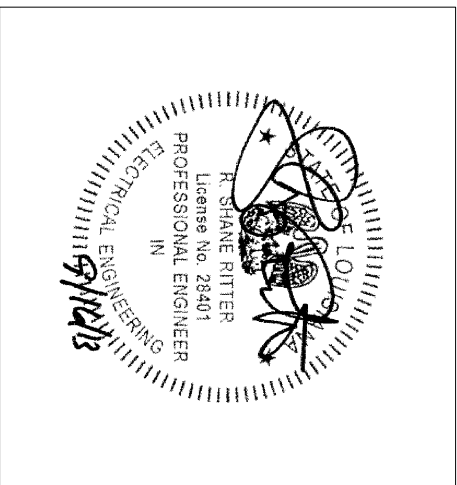

KEY PLAN

Southern Hospitality
Services

Hampton Inn and
Suites



5400 I-20 & Frontage Rd.
Monroe, LA 71201

Drawing Title
Third Floor Lighting Plan

Phase
Construction Documents

Project No.	12-111	Sheet No.
Prepared by	RSR	
Checked by	RSR	E1.3
Date	Sept. 16, 2013	

Released for
PERMIT ONLY

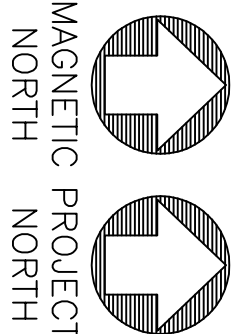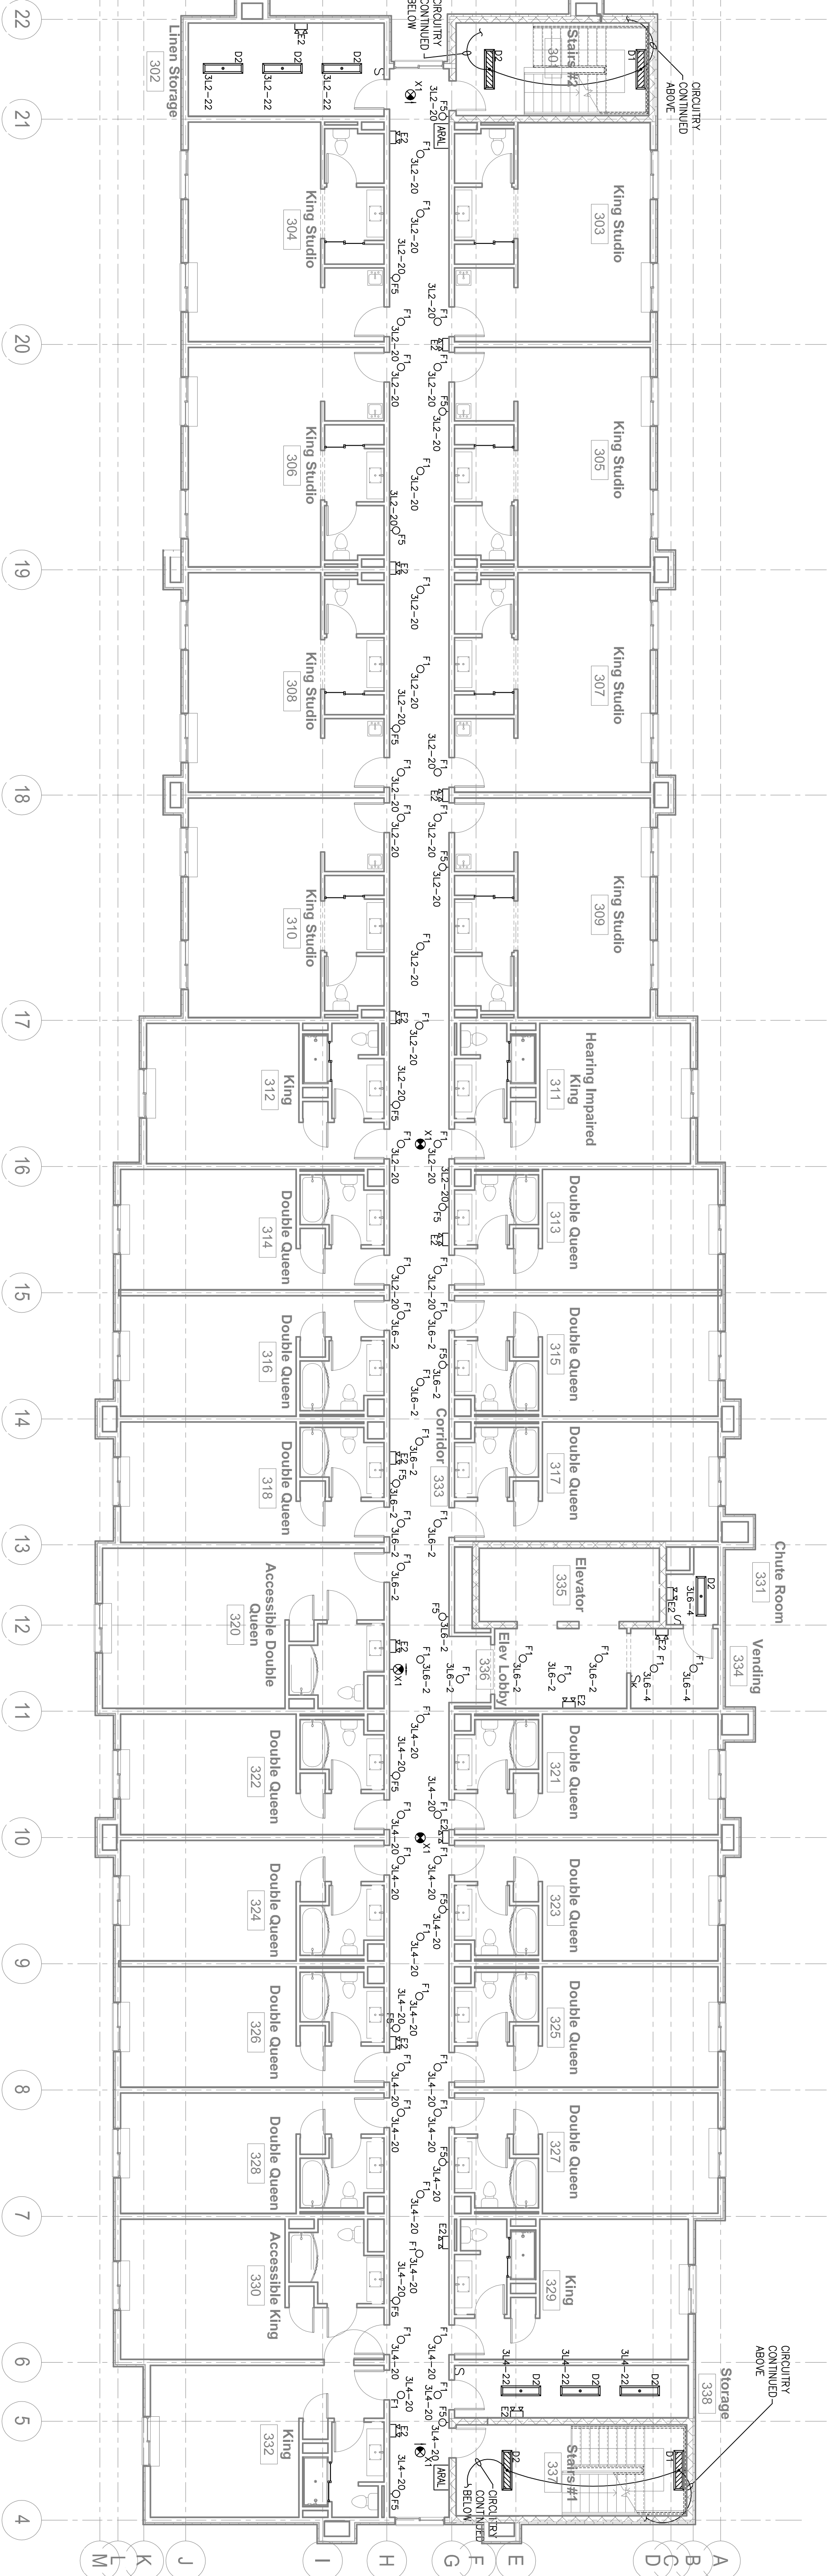

THIRD FLOOR LIGHTING PLAN

SCALE: 1/8" = 1'

GENERAL NOTES:

1. ELECTRICAL LAYOUT AND MATERIALS FOR ALL DEVICES AND FIXTURES TO BE IN COMPLIANCE WITH FRANCHISE STANDARDS AND GUIDELINES, WHICH TAKE PRECEDENT OVER THESE ENGINEERING DRAWINGS.
2. FRANCHISE DESIGN GUIDELINES, STANDARDS, SPECIFICATIONS, AND PROTOTYPICAL DOCUMENTS ARE AVAILABLE ON-LINE OR FROM THE ARCHITECT FOR THE CONTRACTORS USE.