

MISHRA
ARCHITECTURE PLLC

6800 S. Creek Rd., Charlotte, NC 28277
Ph: (704) 625-6554 Fax: (704) 919-5822
EMAIL: sashh@mishraarch.com
WEB: www.mishraarch.com

OWNER: Southern Cross Baptist & Associates, Inc.
105 Commercial Parkway
West Monroe, LA 71294
Phone: (318) 386-3227
Email: galberry@gbdesignengineering.com

STRUCTURAL:


WSP, INC.
11122 E. 11th Avenue, Suite 201
Charlotte, NC 28277
Phone: (704) 542-7199
Fax: (704) 542-7195
Email: mkg@wspinc.com

ELECTRICAL:
R. Stine Riser, P.E.
11122 E. 11th Avenue, Suite 201
Charlotte, NC 28277
Phone: (704) 516-0365
Email: stine@risereng.com
Project Number: 13015

MECHANICAL:
WSP Mechanical Engineering Group, P.C.
212 North McDowell St., Suite 204
Charlotte, NC 28204
Phone: (704) 334-7863
Fax: (704) 334-0869
Email: dm@wspinc.com

REVISIONS		
No.	Date	Description

Information contained on this drawing and in all digital files associated is authorized for use on the project named herein only and is the property of MISHRA ARCHITECTURE PLLC and may not be reproduced, stored in a retrieval system, or transmitted in any form or by any means, electronic or verbal, without the express written or verbal permission from MISHRA ARCHITECTURE PLLC.

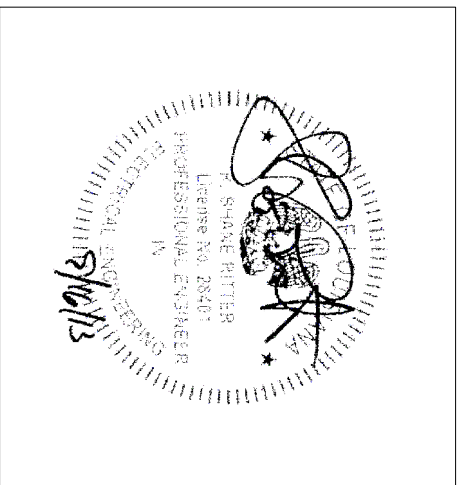

KEY PLAN

Southern Hospitality
Services

Hampton Inn and
Suites




5400 I-20 & Frontage Rd.
Monroe, LA 71201

Drawing Title
Fourth Floor Power &
Communication Plan

Please
Construction Documents

Project No.	12-111	Sheet No.
Prepared by	RSR	E2.4
Checked by	RSR	
Date	Sept. 16, 2013	

 Released for
PERMIT ONLY

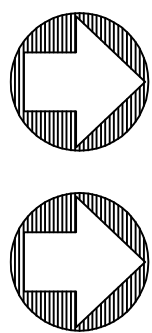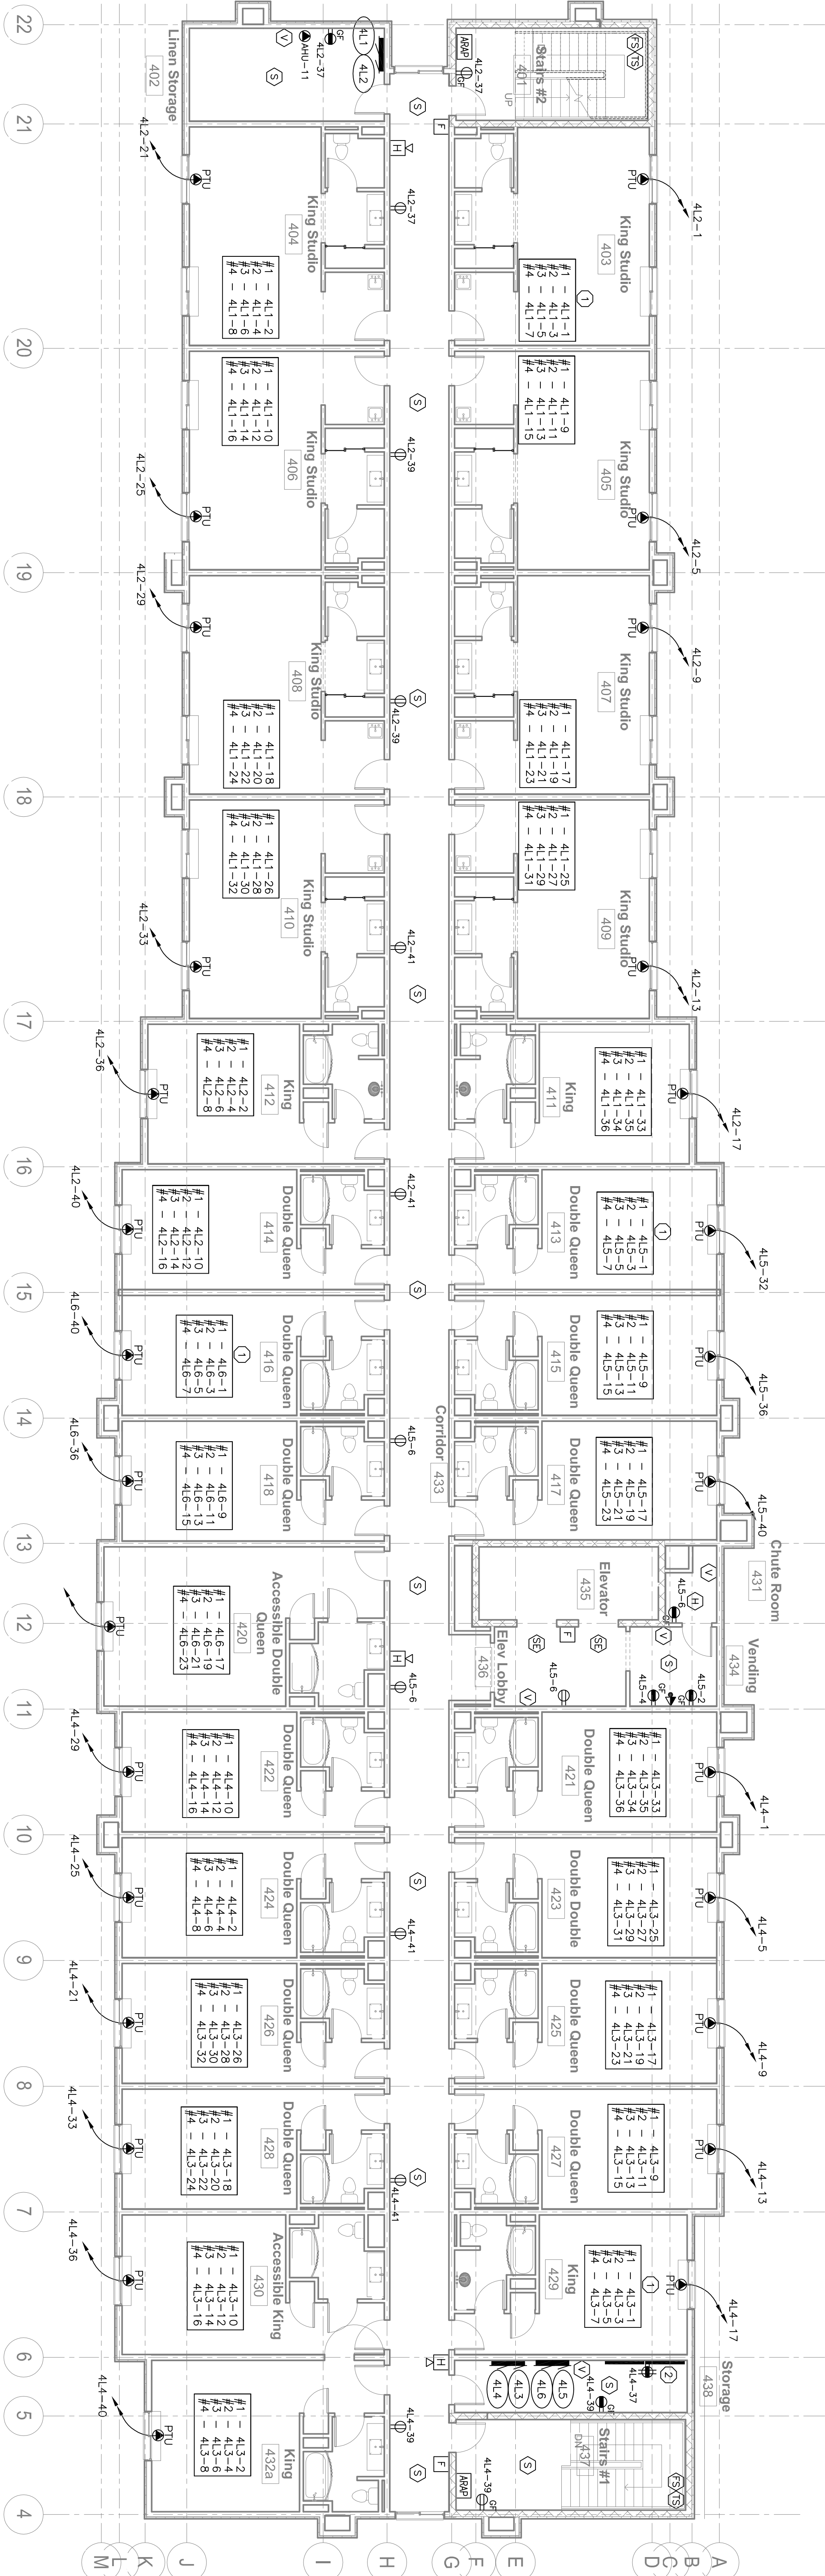

1
SCALE: 1/8" = 1'

PLAN KEY NOTES:

1. CIRCUITS SHOWN IN BLOCKS TO BE USED TO DEFINE CIRCUITS USED FOR EACH ROOM AS SHOWN IN TYPICAL ROOM LAYOUTS SHOWN ON E3.1 AND E3.2 (TYPICAL).
2. TWO (2) 4"x8"x3/4" PAINTED BACKBOARD FOR TELECOM AND CATV (SEE COMMUNICATION RISER DIAGRAM).

GENERAL NOTES:

1. ELECTRICAL LAYOUT AND MATERIALS FOR ALL DEVICES AND FIXTURES TO BE IN COMPLIANCE WITH FRANCHISE STANDARDS AND GUIDELINES, WHICH TAKE PRECEDENT OVER THESE ENGINEERING DRAWINGS.
2. FRANCHISE DESIGN GUIDELINES, STANDARDS, SPECIFICATIONS, AND PROTOTYPICAL DOCUMENTS ARE AVAILABLE ON-LINE OR FROM THE ARCHITECT FOR THE CONTRACTORS USE.
3. ALL BREAKERS FEEDING 120V 20A CIRCUITS IN ALL GUESTROOMS, DWELLING SPACES, AND APARTMENTS SHALL BE ARC FAULT TYPE BREAKERS.