



2 SECURITY / CCTV RISER DIAGRAM
E4.2 SCALE: NO SCALE

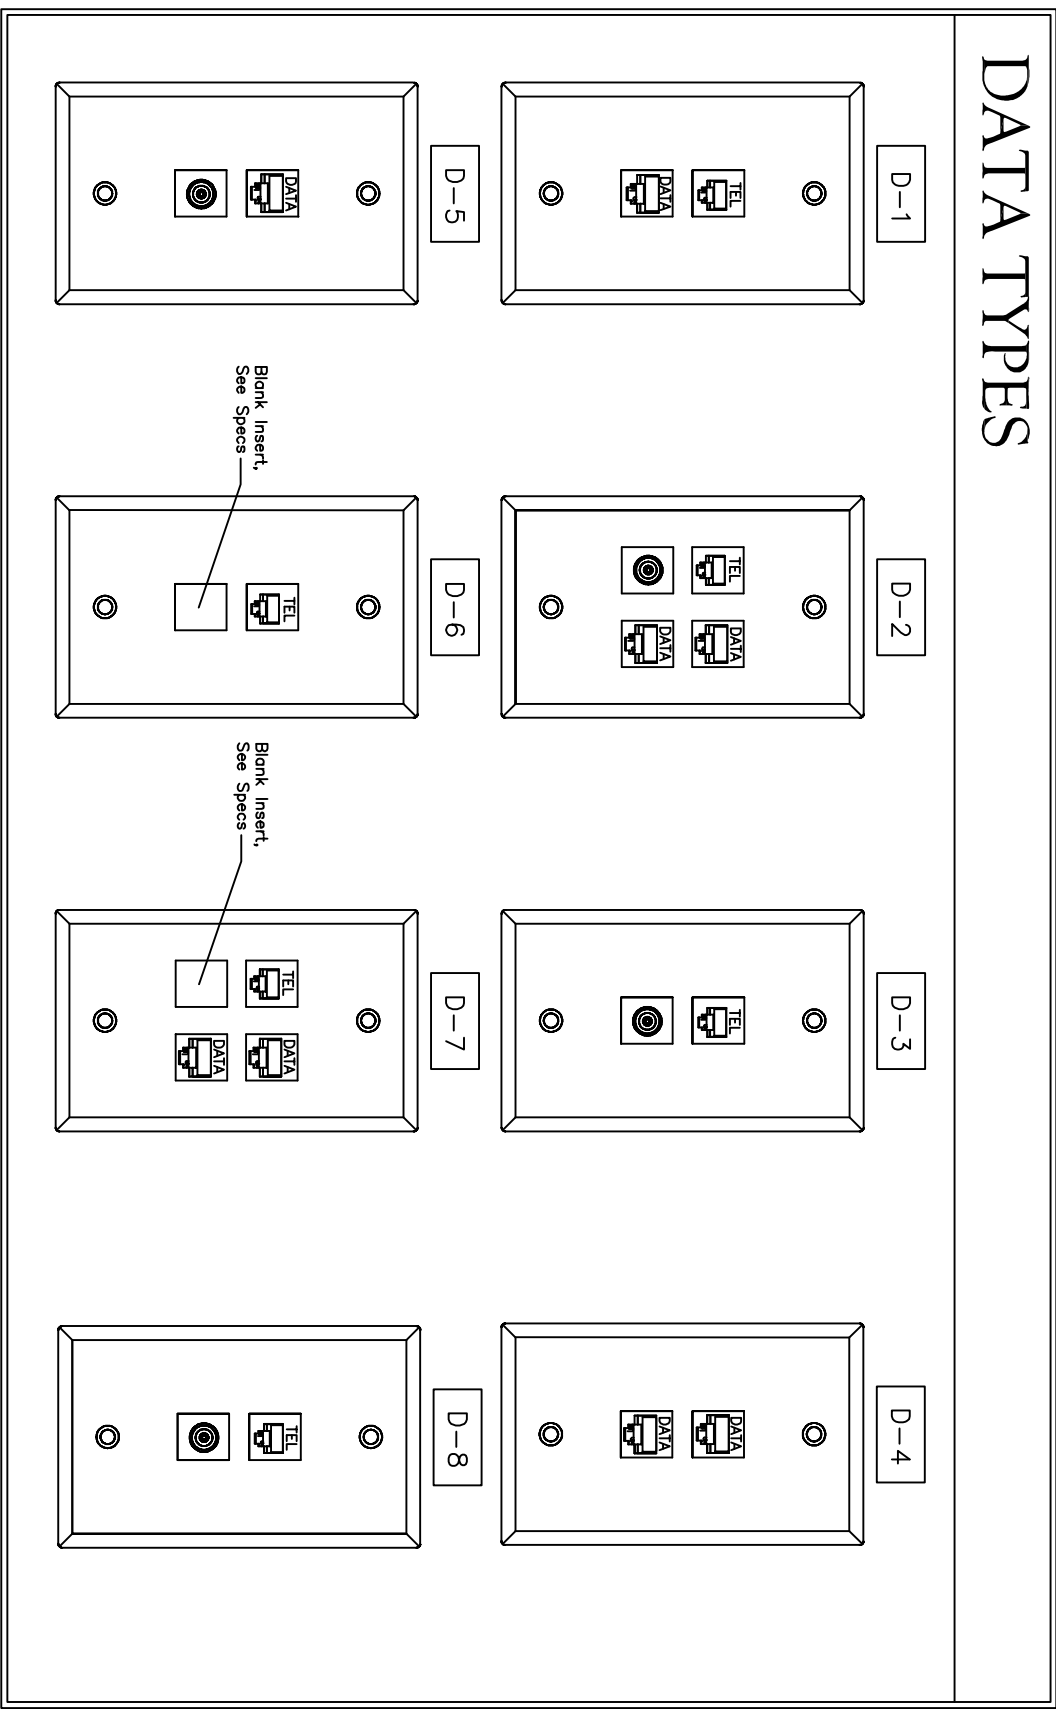

VOICE, DATA & VIDEO CABLE SCHEDULE	
SYMBOL	DESCRIPTION
	4 PAIR CAT 6 / 4 PAIR TELEPHONE CAT 3
	RG-6/U QUAD SHIELDED 75 Ω CABLE / 4 PAIR CAT 6 / 4 PAIR TELEPHONE CAT 3
	4 PAIR CAT 6 / 4 PAIR CAT 6
	RG-6/U QUAD SHIELDED 75 Ω CABLE / 4 PAIR CAT 6
	4 PAIR TELEPHONE CAT 3
	4 PAIR CAT 6 / 4 PAIR CAT 6
	RG-59 COAXIAL + 2-18 AWG
	4 PAIR CAT 6 / 4 PAIR TELEPHONE CAT 3
	RG-6/U QUAD SHIELDED 75 Ω CABLE / 4 PAIR CAT 6 (SPLITTERS AS REQUIRED)
	4 PAIR CAT 6 / 4 PAIR CAT 6 (SPLITTERS AS REQUIRED)
	RG-6/U QUAD SHIELDED 75 Ω CABLE / 4 PAIR CAT 6
	4 PAIR CAT 6 / 4 PAIR CAT 6 (SEE DETAIL 5/ES.5)

1 TELECOM RISER DIAGRAM
E4.3 SCALE: NO SCALE

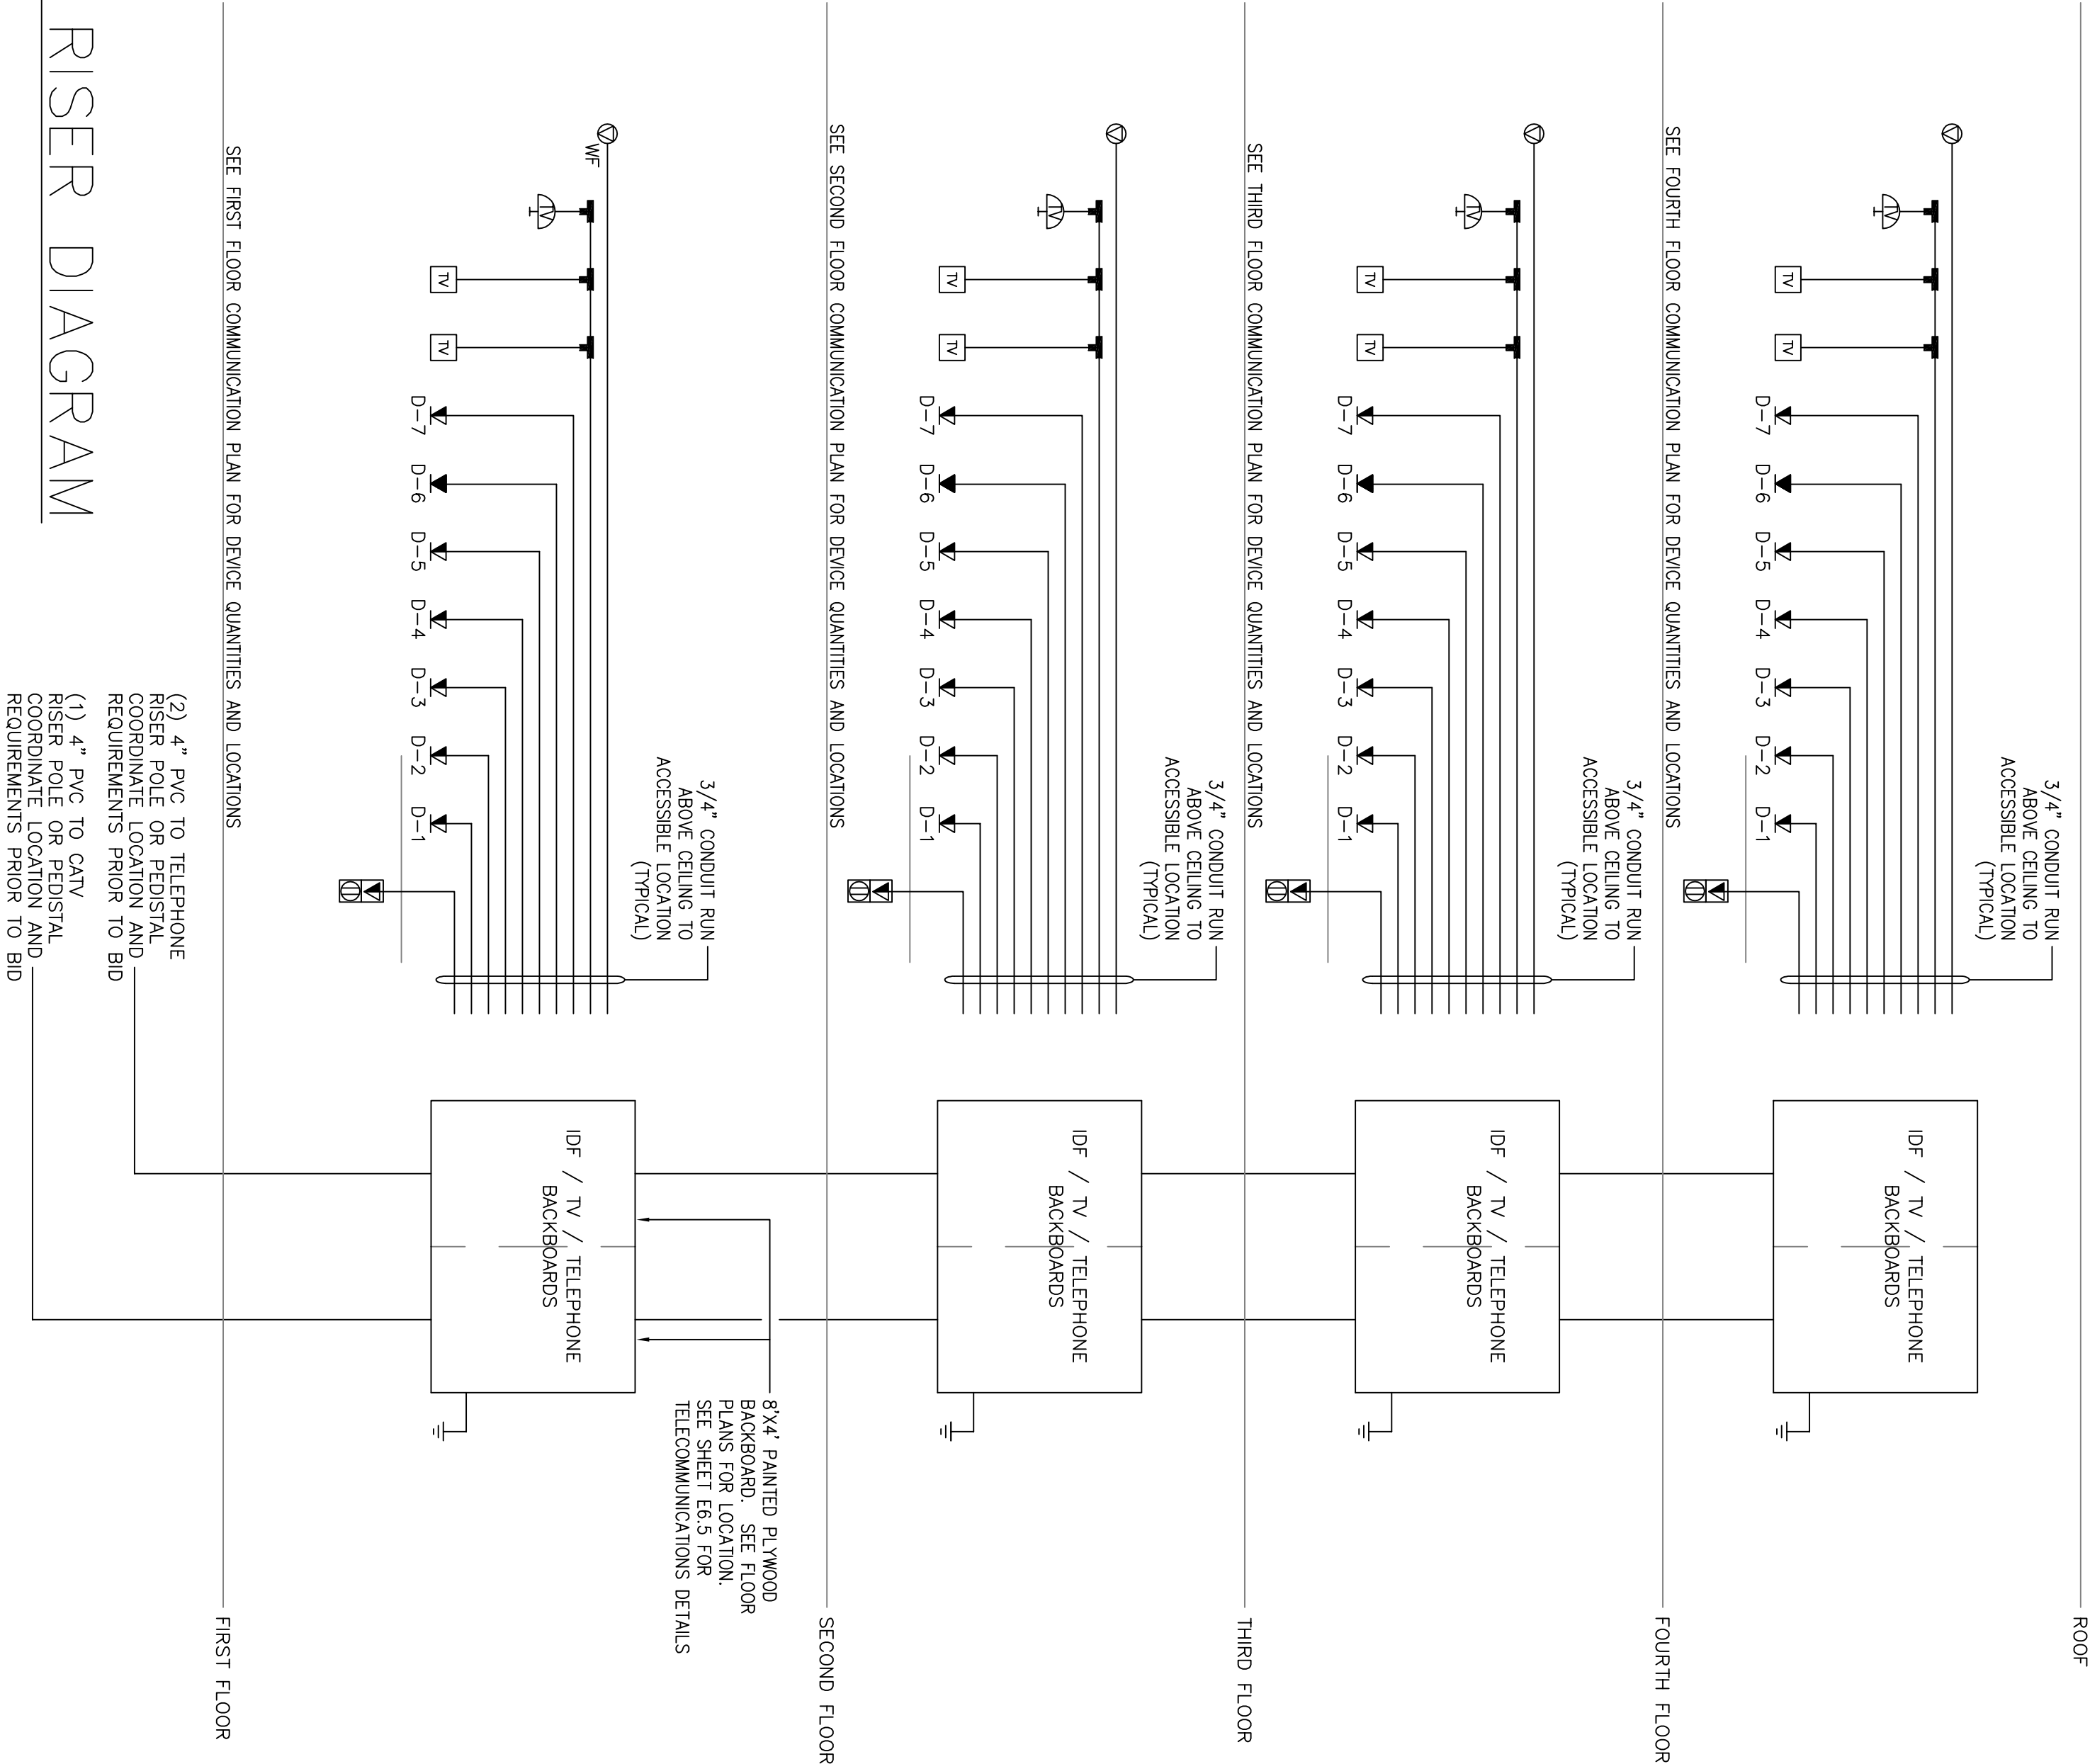

6800 S Creek Rd, Charlotte, NC 28277
Ph:(704) 625-6554 Fax:(704) 919-5922
EMAIL: sashh@misraarch.com
WEB: www.misraarch.com

CNLI:
D. S. S. and Associates, Inc.
105 Commercial Parkway
West Monroe, LA 71294
Phone: (318) 386-3227
Email: gsaberry@gsaberryengineering.com

STRUCTURAL:
3/4" CONDUIT RUN
ABOVE CEILING TO
ACCESSIBLE LOCATION
(TYPICAL)

ELECTRICAL:
R. S. S. and Associates, Inc.
105 Commercial Parkway
West Monroe, LA 71294
Phone: (318) 386-3227
Email: gsaberry@gsaberryengineering.com

MECHANICAL:
212 North McDowell St., Suite 204
Charlotte, NC 28204
Phone: (704) 334-7963
Fax: (704) 334-4089
Email: don@shlwg.com

REVISIONS	
No.	Date Description

Information contained on this drawing and in all digital files associated is authorized for use on the project named herein only and is the property of MISHRA ARCHITECTURE PLLC and may not be reproduced or transmitted in any form without written or verbal permission from authorized individuals. Original drawing is 24x36" and scales are as indicated. 2011 MISHRA ARCHITECTURE PLLC



KEY PLAN

Southern Hospitality
Services

Hampton Inn and
Suites

5400 I-20 & Frontage Rd.
Monroe, LA 71201

Drawing Title

Electrical Systems
Riser Diagram

Please
Construction Documents

Project No.	12-111	Sheet No.
Prepared by	RSR	
Checked by	RSR	E4.3
Date	Sept. 16, 2013	

Released for
PERMIT ONLY