




6800 S Creek Rd, Charlotte, NC 28277
Ph:(704) 625-6554 Fax:(704) 919-5822
EMAIL:ashish@mishraarch.com
WEB: www.mishraarch.com



212 N. McDowell St.
Suite 204
Charlotte, NC 28204
(P) 704.334.7363
(F) 704.347.0093
www.shultzeg.com
SEG - 13-039

[illegible]

Information contained on this drawing and in all digital files associated is authorized for use on the project named herein only and is the property of MISHRA ARCHITECTURE PLLC and may not be reproduced in any manner without express written or verbal permission from authorized individuals. Original drawing is 24"x36" and scales are as indicated. © 2011 MISHRA ARCHITECTURE PLLC

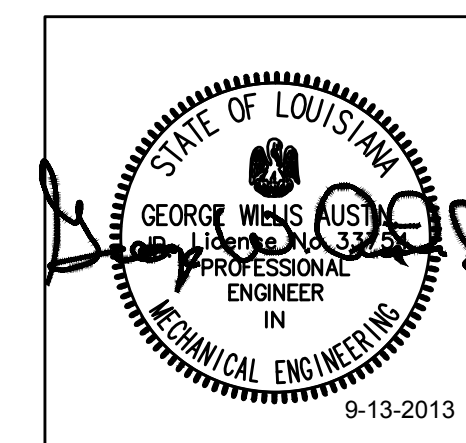

KEY PLAN

Southern Hospitality
Services

Hampton Inn and Suites

5400 I-20 & Frontage Rd.
Monroe, LA 71201

Drawing Title

First Floor Plan - Fire Protection

Phase
FOR CONSTRUCTION



Project No.	12-111
Prepared by	JCF
Checked by	WGA
Date	September 16, 2013

Released fo


Sheet No.

FP101

Hampton Inn and Suites

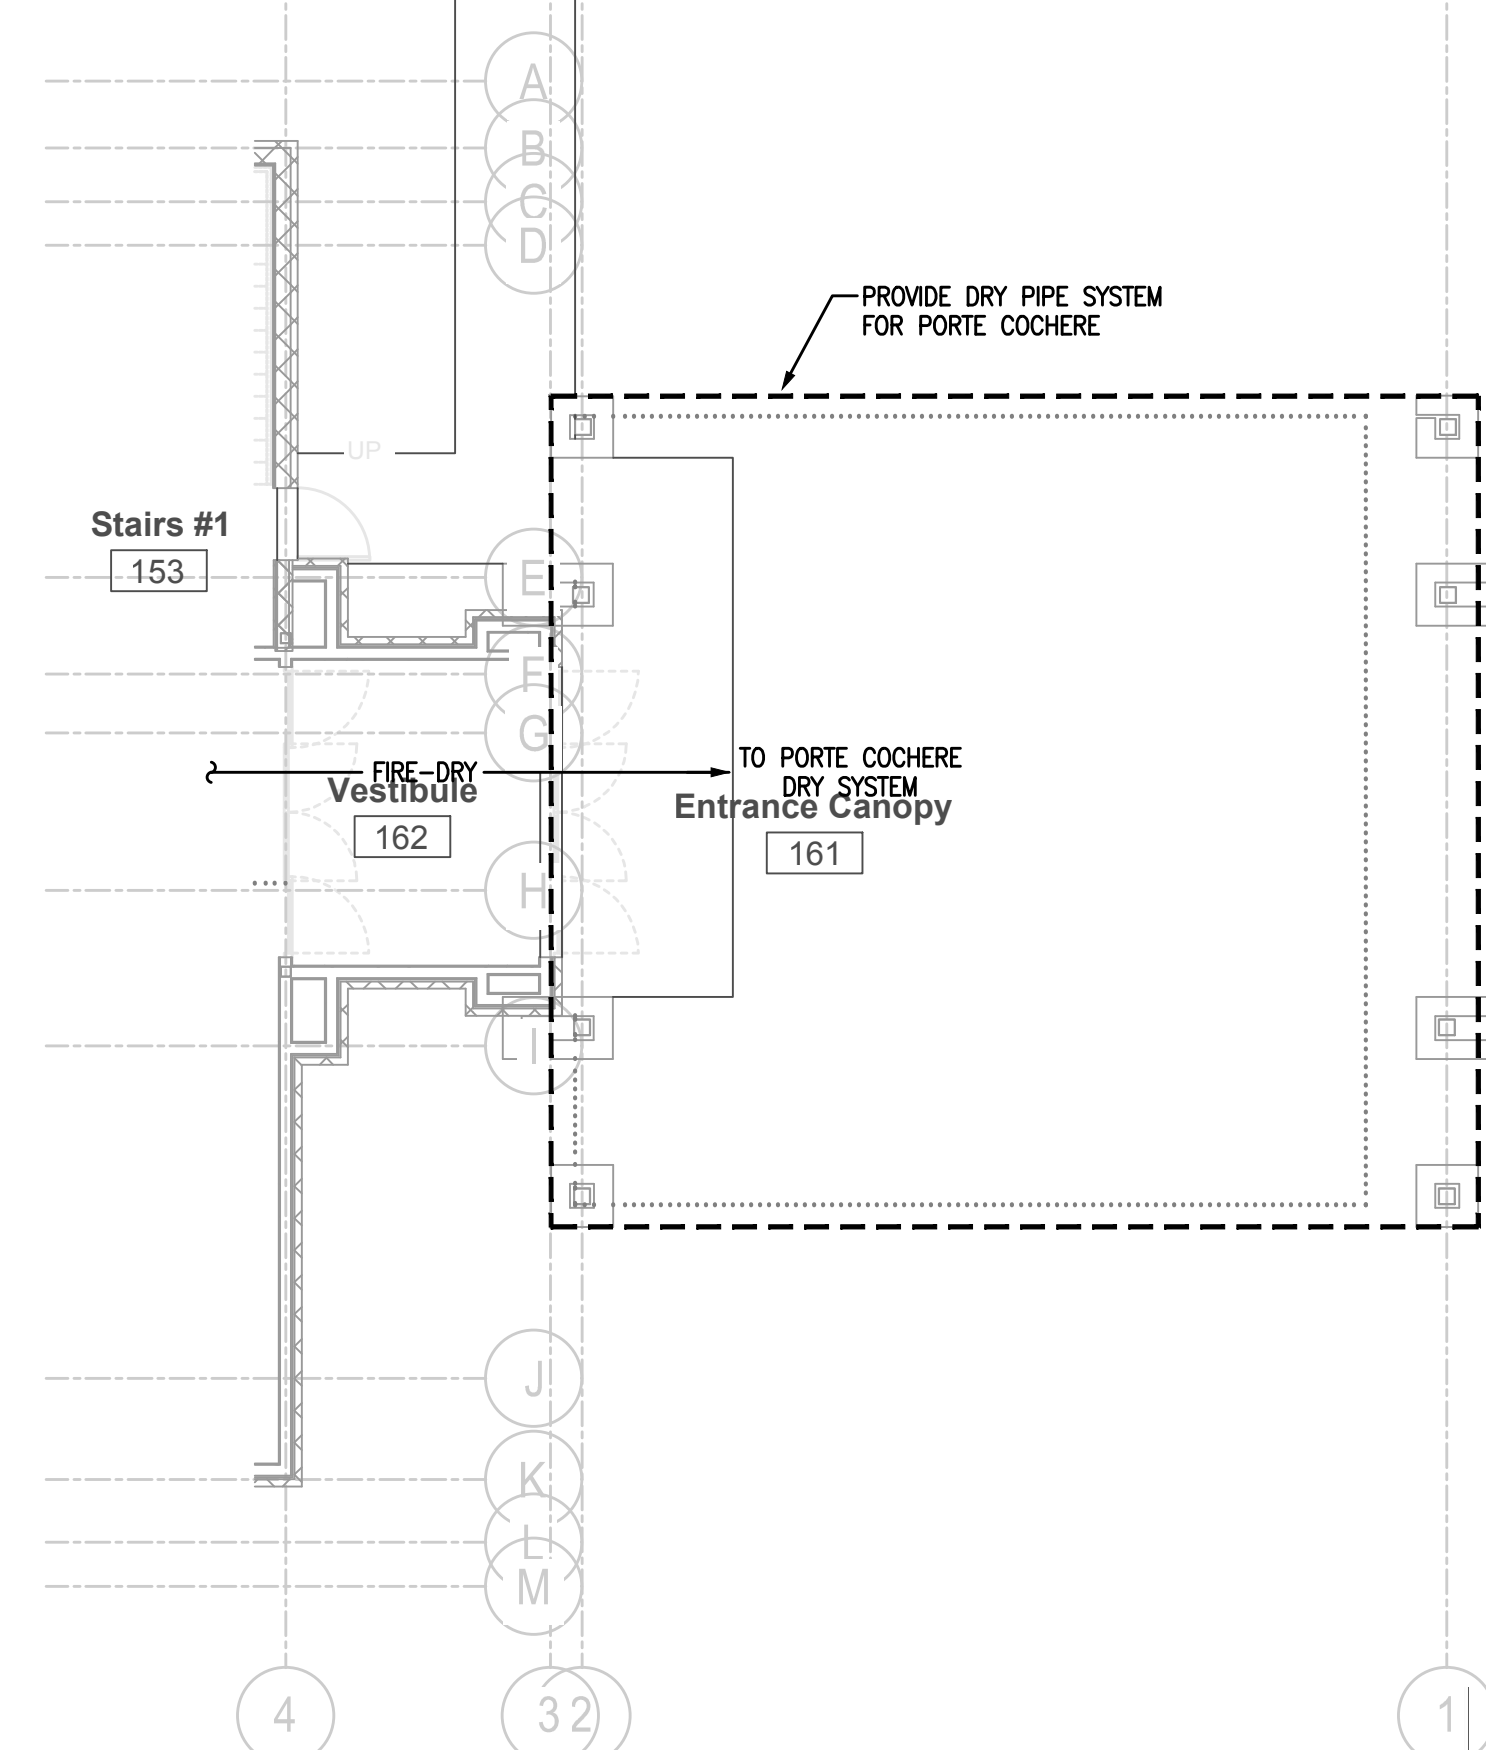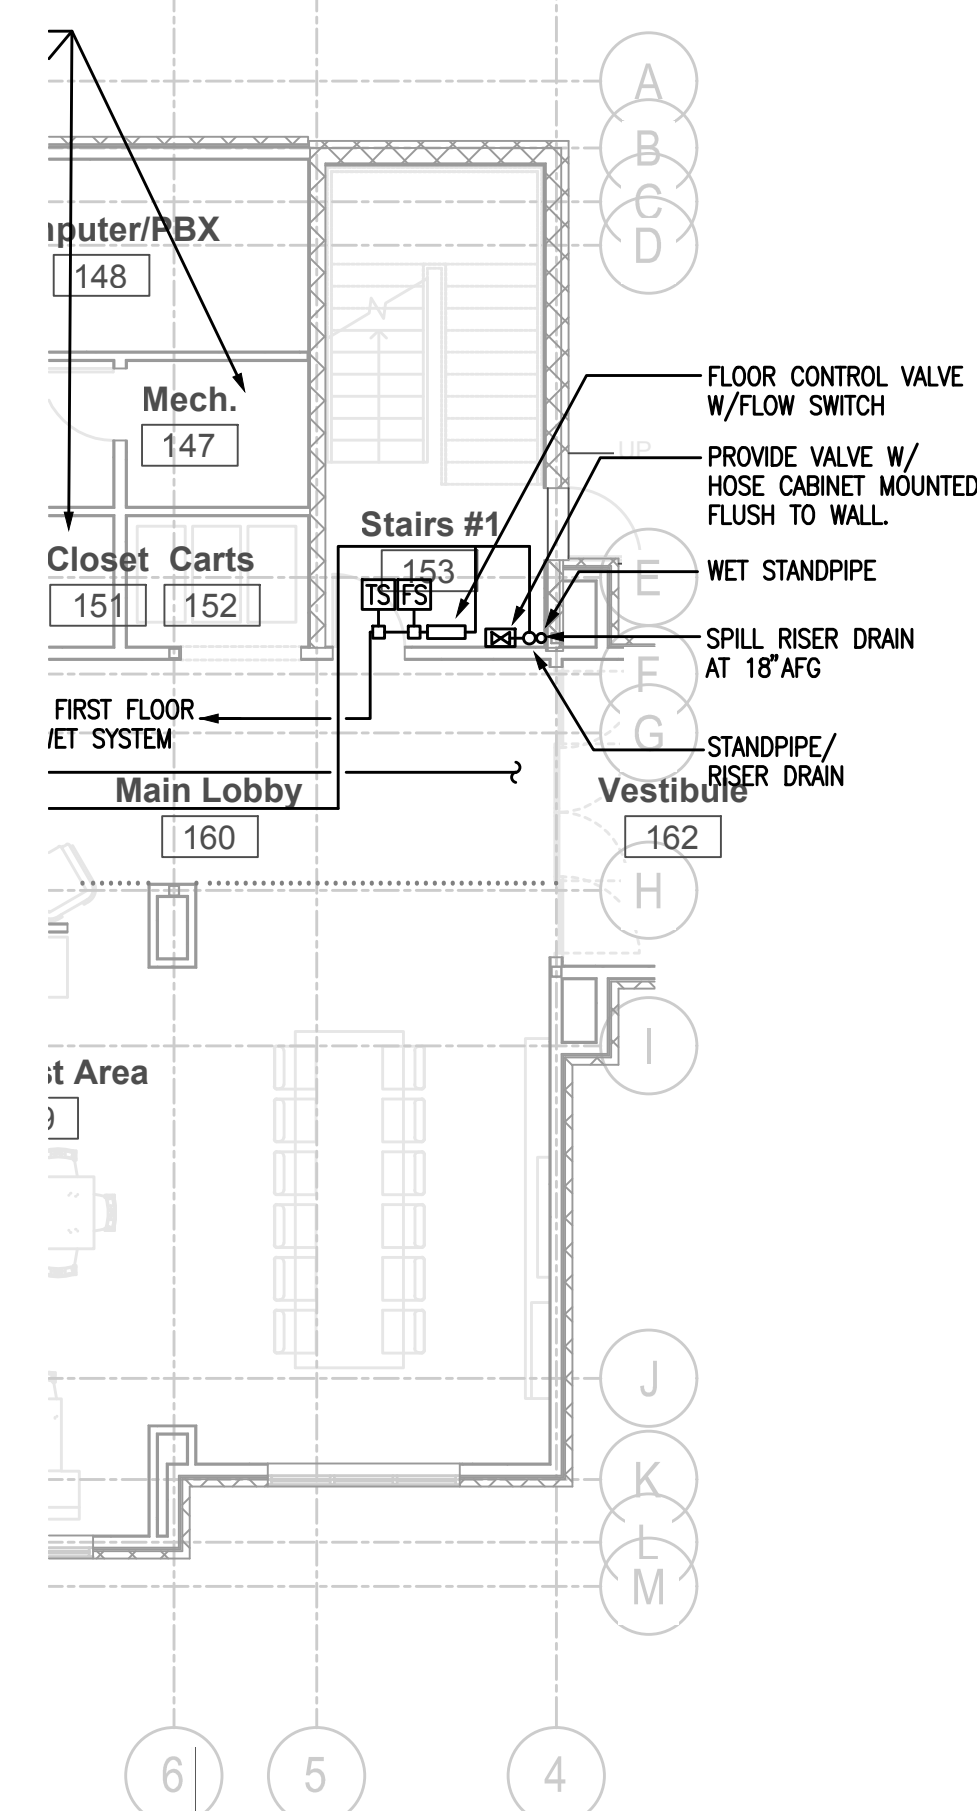

2 PARTIAL FIRST FLOOR PLAN - FIRE PROTECTION
FP101 SCALE: 1/8" = 1'-0" 2 1/2" FEMALE CONNECTIONS WITH CAP AND CHAIN(S).

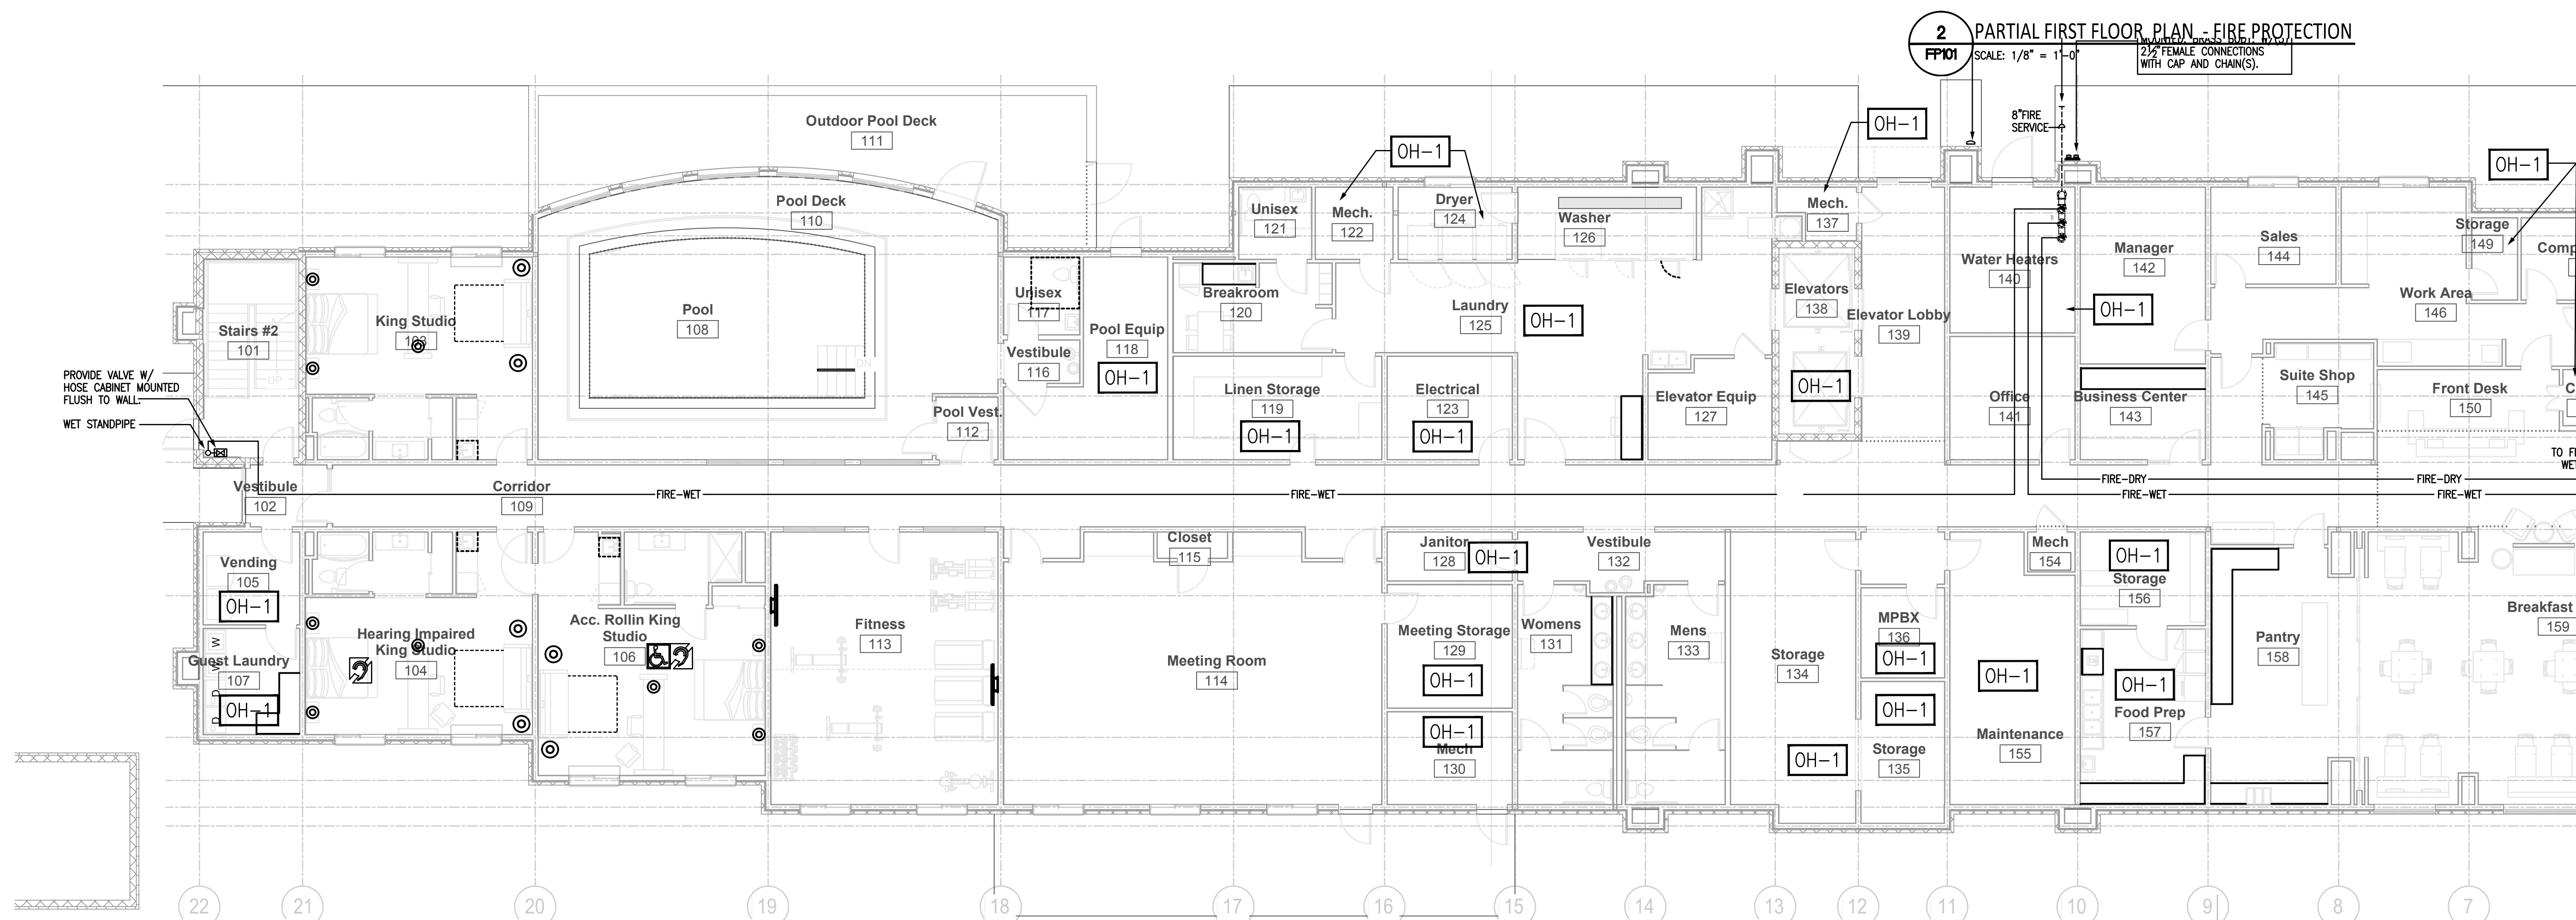

1 PARTIAL FIRST FLOOR PLAN - FIRE PROTECTION
FP101 SCALE: 1/8" = 1'-0"