


880 S Cowe Rd, Charlotte, NC 28277
Pty(704) 925-6554 Fax(704) 919-5822
EMAIL: info@mishraarch.com
WEB: www.mishraarch.com



217 N. McDowell St.
Suite 204
Charlotte, NC 28204
(770) 347-0093
www.shultzeng.com
SEC - 13-039

REVISIONS	
No.	Description

Information contained on this drawing and the work shown hereon are the property of SHULTZ ENGINEERING GROUP, PC and may not be used for any other project without the express written or verbal permission from SHULTZ ENGINEERING GROUP, PC.

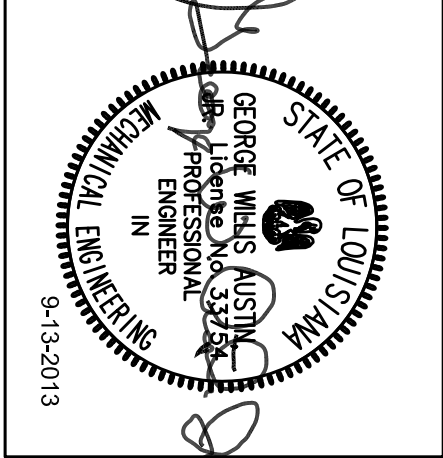

KEY PLAN


Southern Hospitality
Services
Hampton Inn and Suites

5400 I-20 & Frontage Rd.
Monroe, LA 71201

Drawings Title
Fourth Floor, Waste and Vent
Piping Plan - Plumbing

FOR CONSTRUCTION

Project No.	Sheet No.
12-111	P 104
Prepared by JCF	
Checked by WGA	
Date September 16, 2013	
Released for	

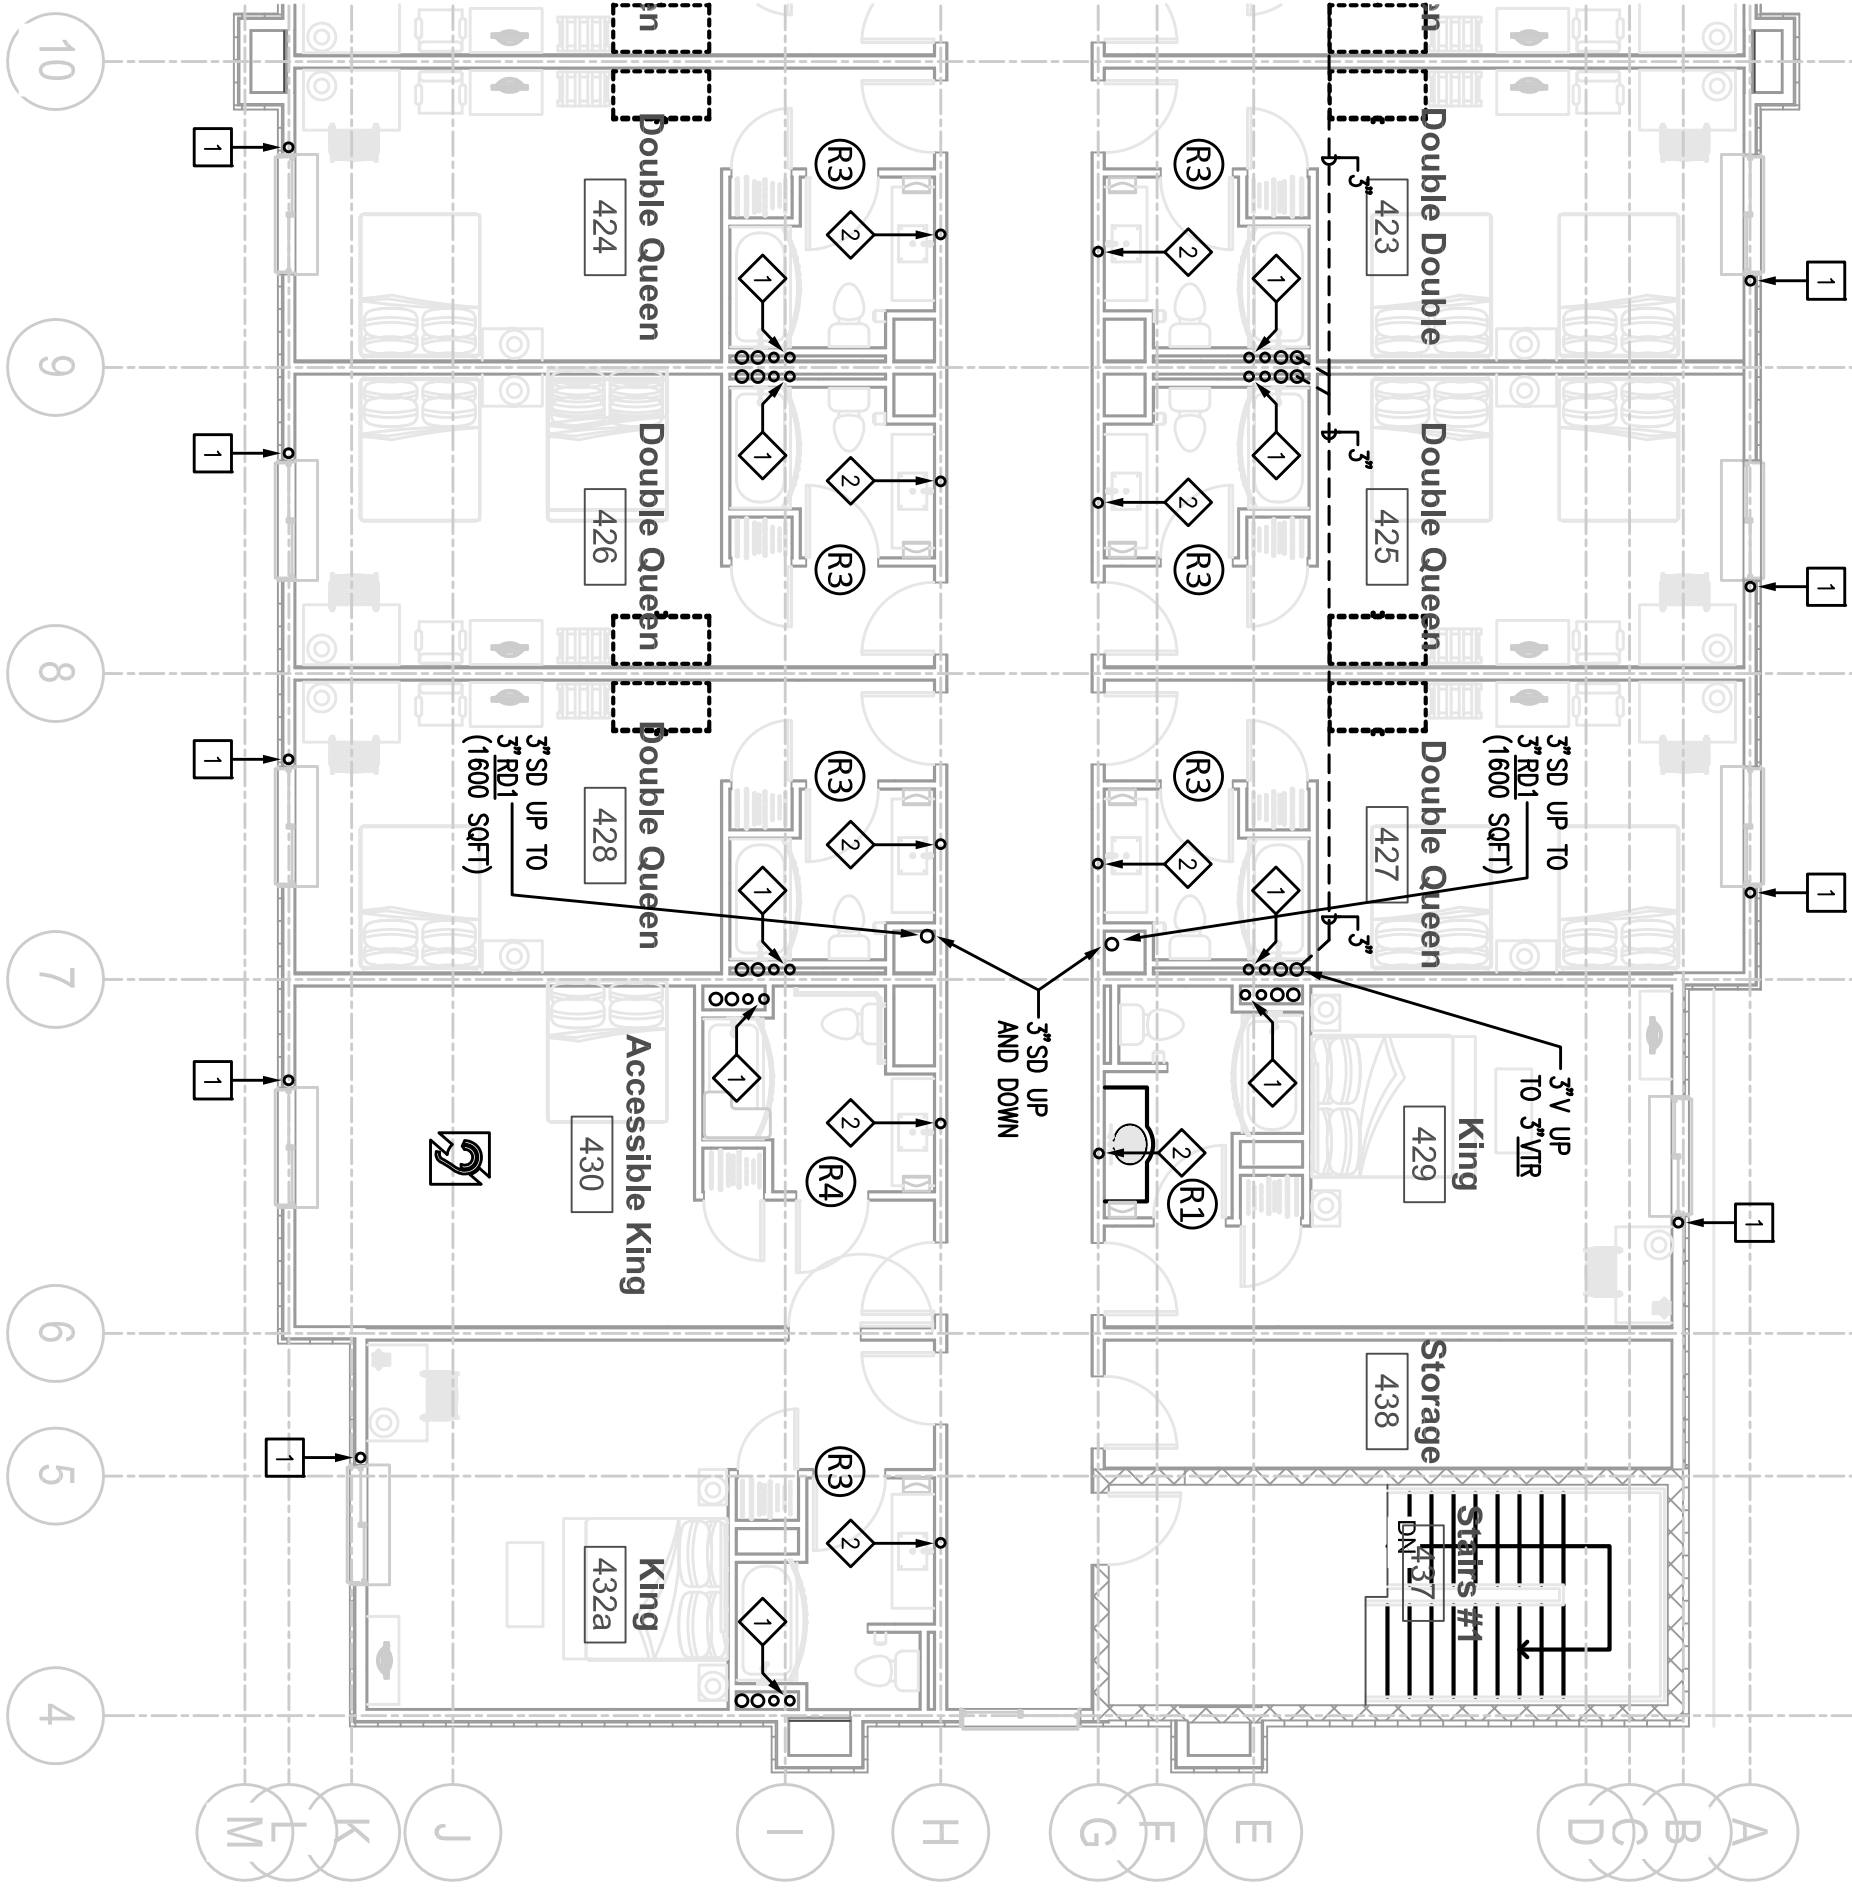


2 PARTIAL FOURTH FLOOR PLAN - PLUMBING
P104 SCALE: 1/8" = 1'-0"

- ◊ CW AND HW RISER FOR TOILET GROUP. SEE RISER SCHEMATICS ON SHEET P401
- ◊ HW RISER FOR TOILET GROUP. SEE RISER SCHEMATICS ON SHEET P401
- ◊ CW RISER FOR VENDING AREA. SEE RISER SCHEMATICS ON SHEET P401
- ◊ CW AND HW RISER FOR IN ROOM SINKS. SEE RISER SCHEMATICS ON SHEET P401

- 1 CONDENSATE RISER FOR IN ROOM P.V.C. UNITS. PROVIDE 1 1/2" TEE AT EACH FLOOR FOR MECHANICAL CONDENSATE DISCHARGE CONNECTION. CONDENSATE RISER 1 1/2" UNLESS OTHERWISE NOTED.

- (R9) SEE WASTE AND VENT RISER SCHEMATICS ON SHEET P401

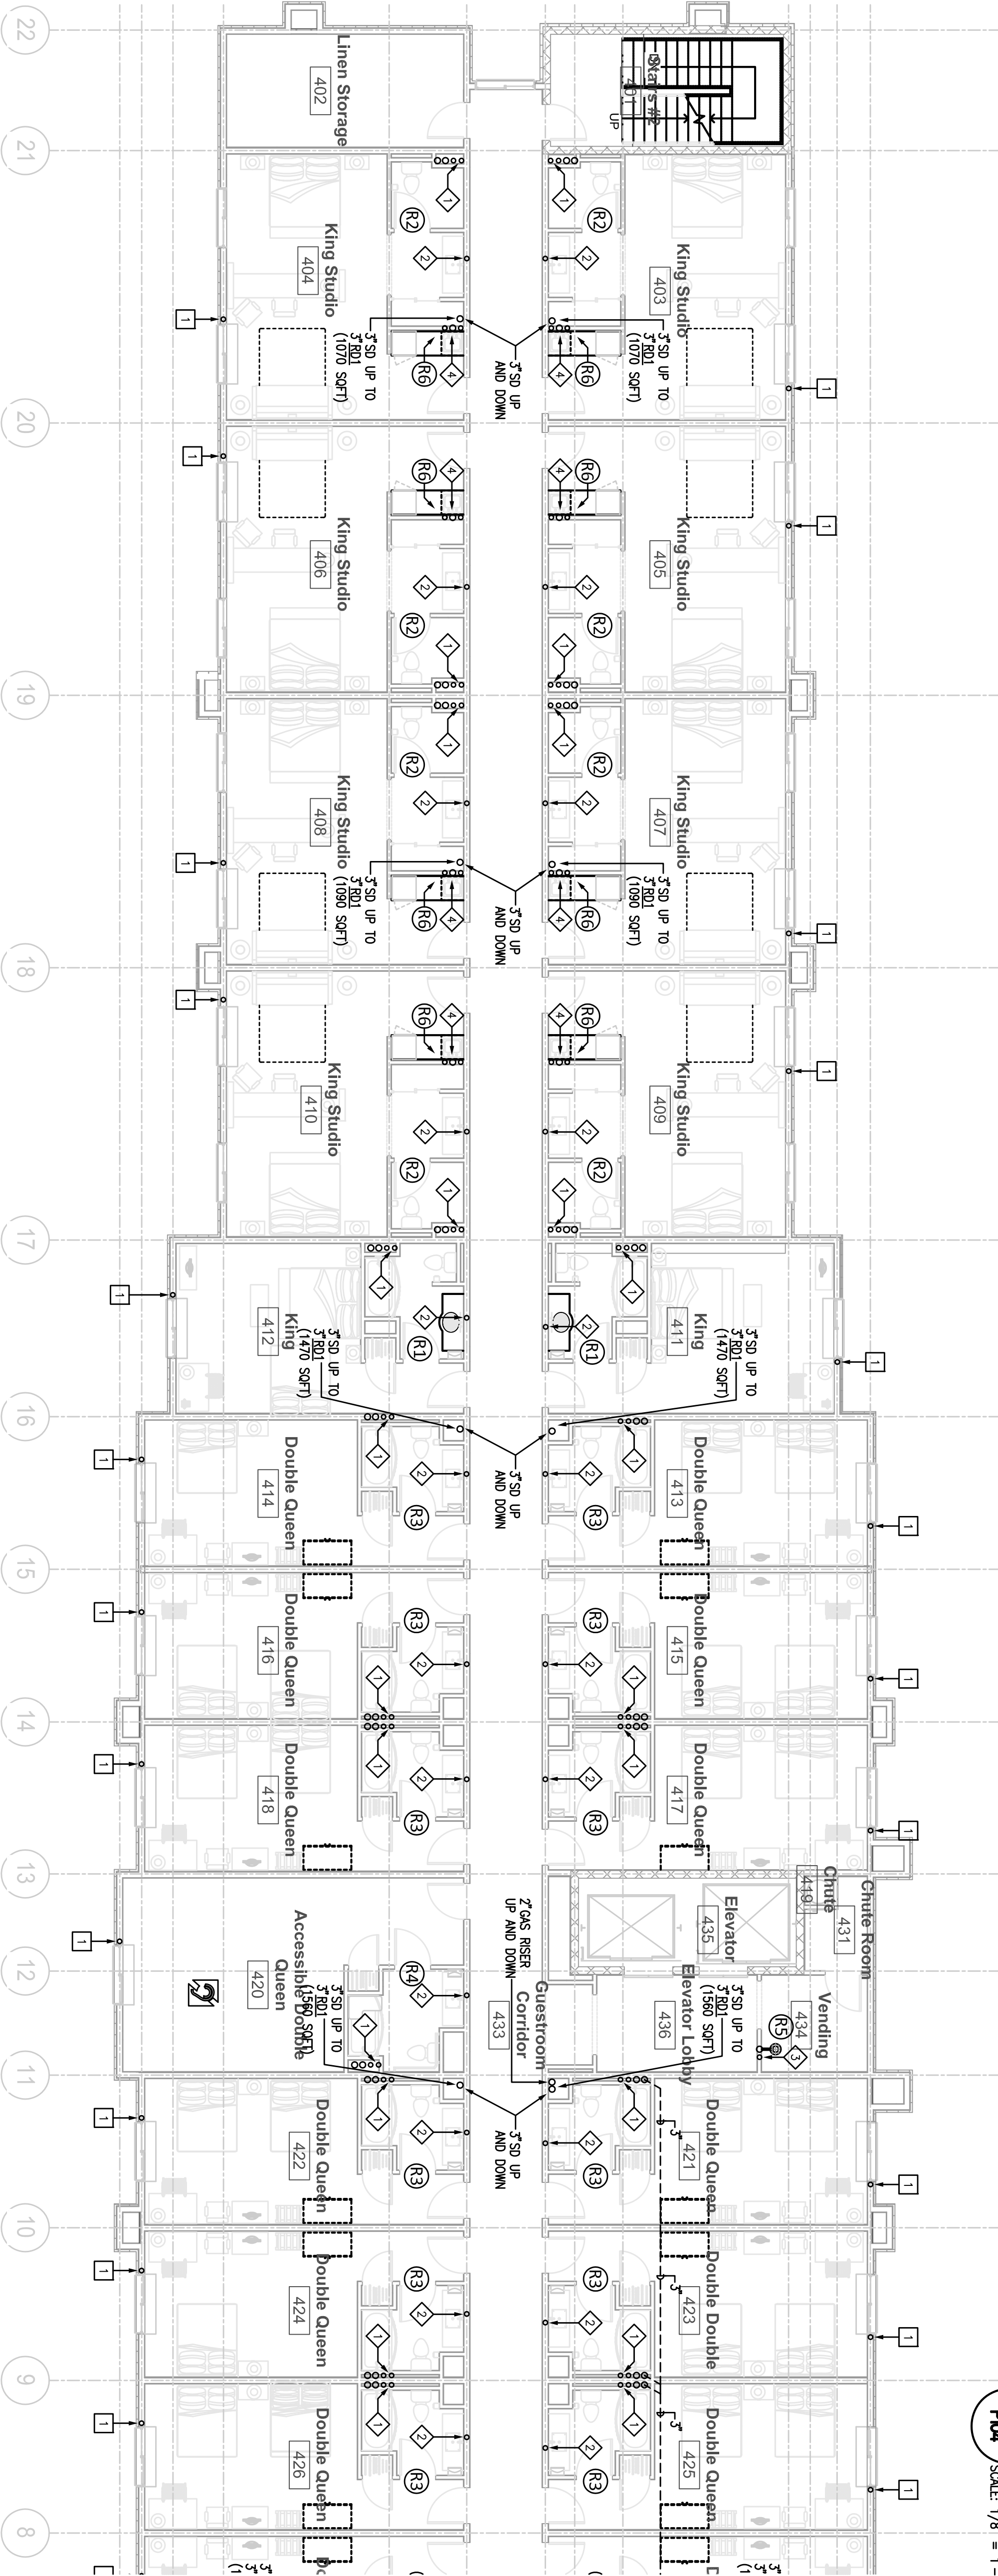

1 PARTIAL FOURTH FLOOR PLAN - PLUMBING
P104 SCALE: 1/8" = 1'-0"