


MISHRA
ARCHITECTURE PLLC

6800 S. Court Rd. Charlotte, NC 28277
Ph: (704) 925-6554 Fax: (704) 919-5822
EMAIL: mishra@mishraarch.com
WEB: www.mishraarch.com




SHULTZ
ENGINEERING
GROUP, PC

211 N. McDowell St.
Suite 204
Charlotte, NC 28204
(770) 347-0093
www.shultzeng.com
SEC - 13-0393

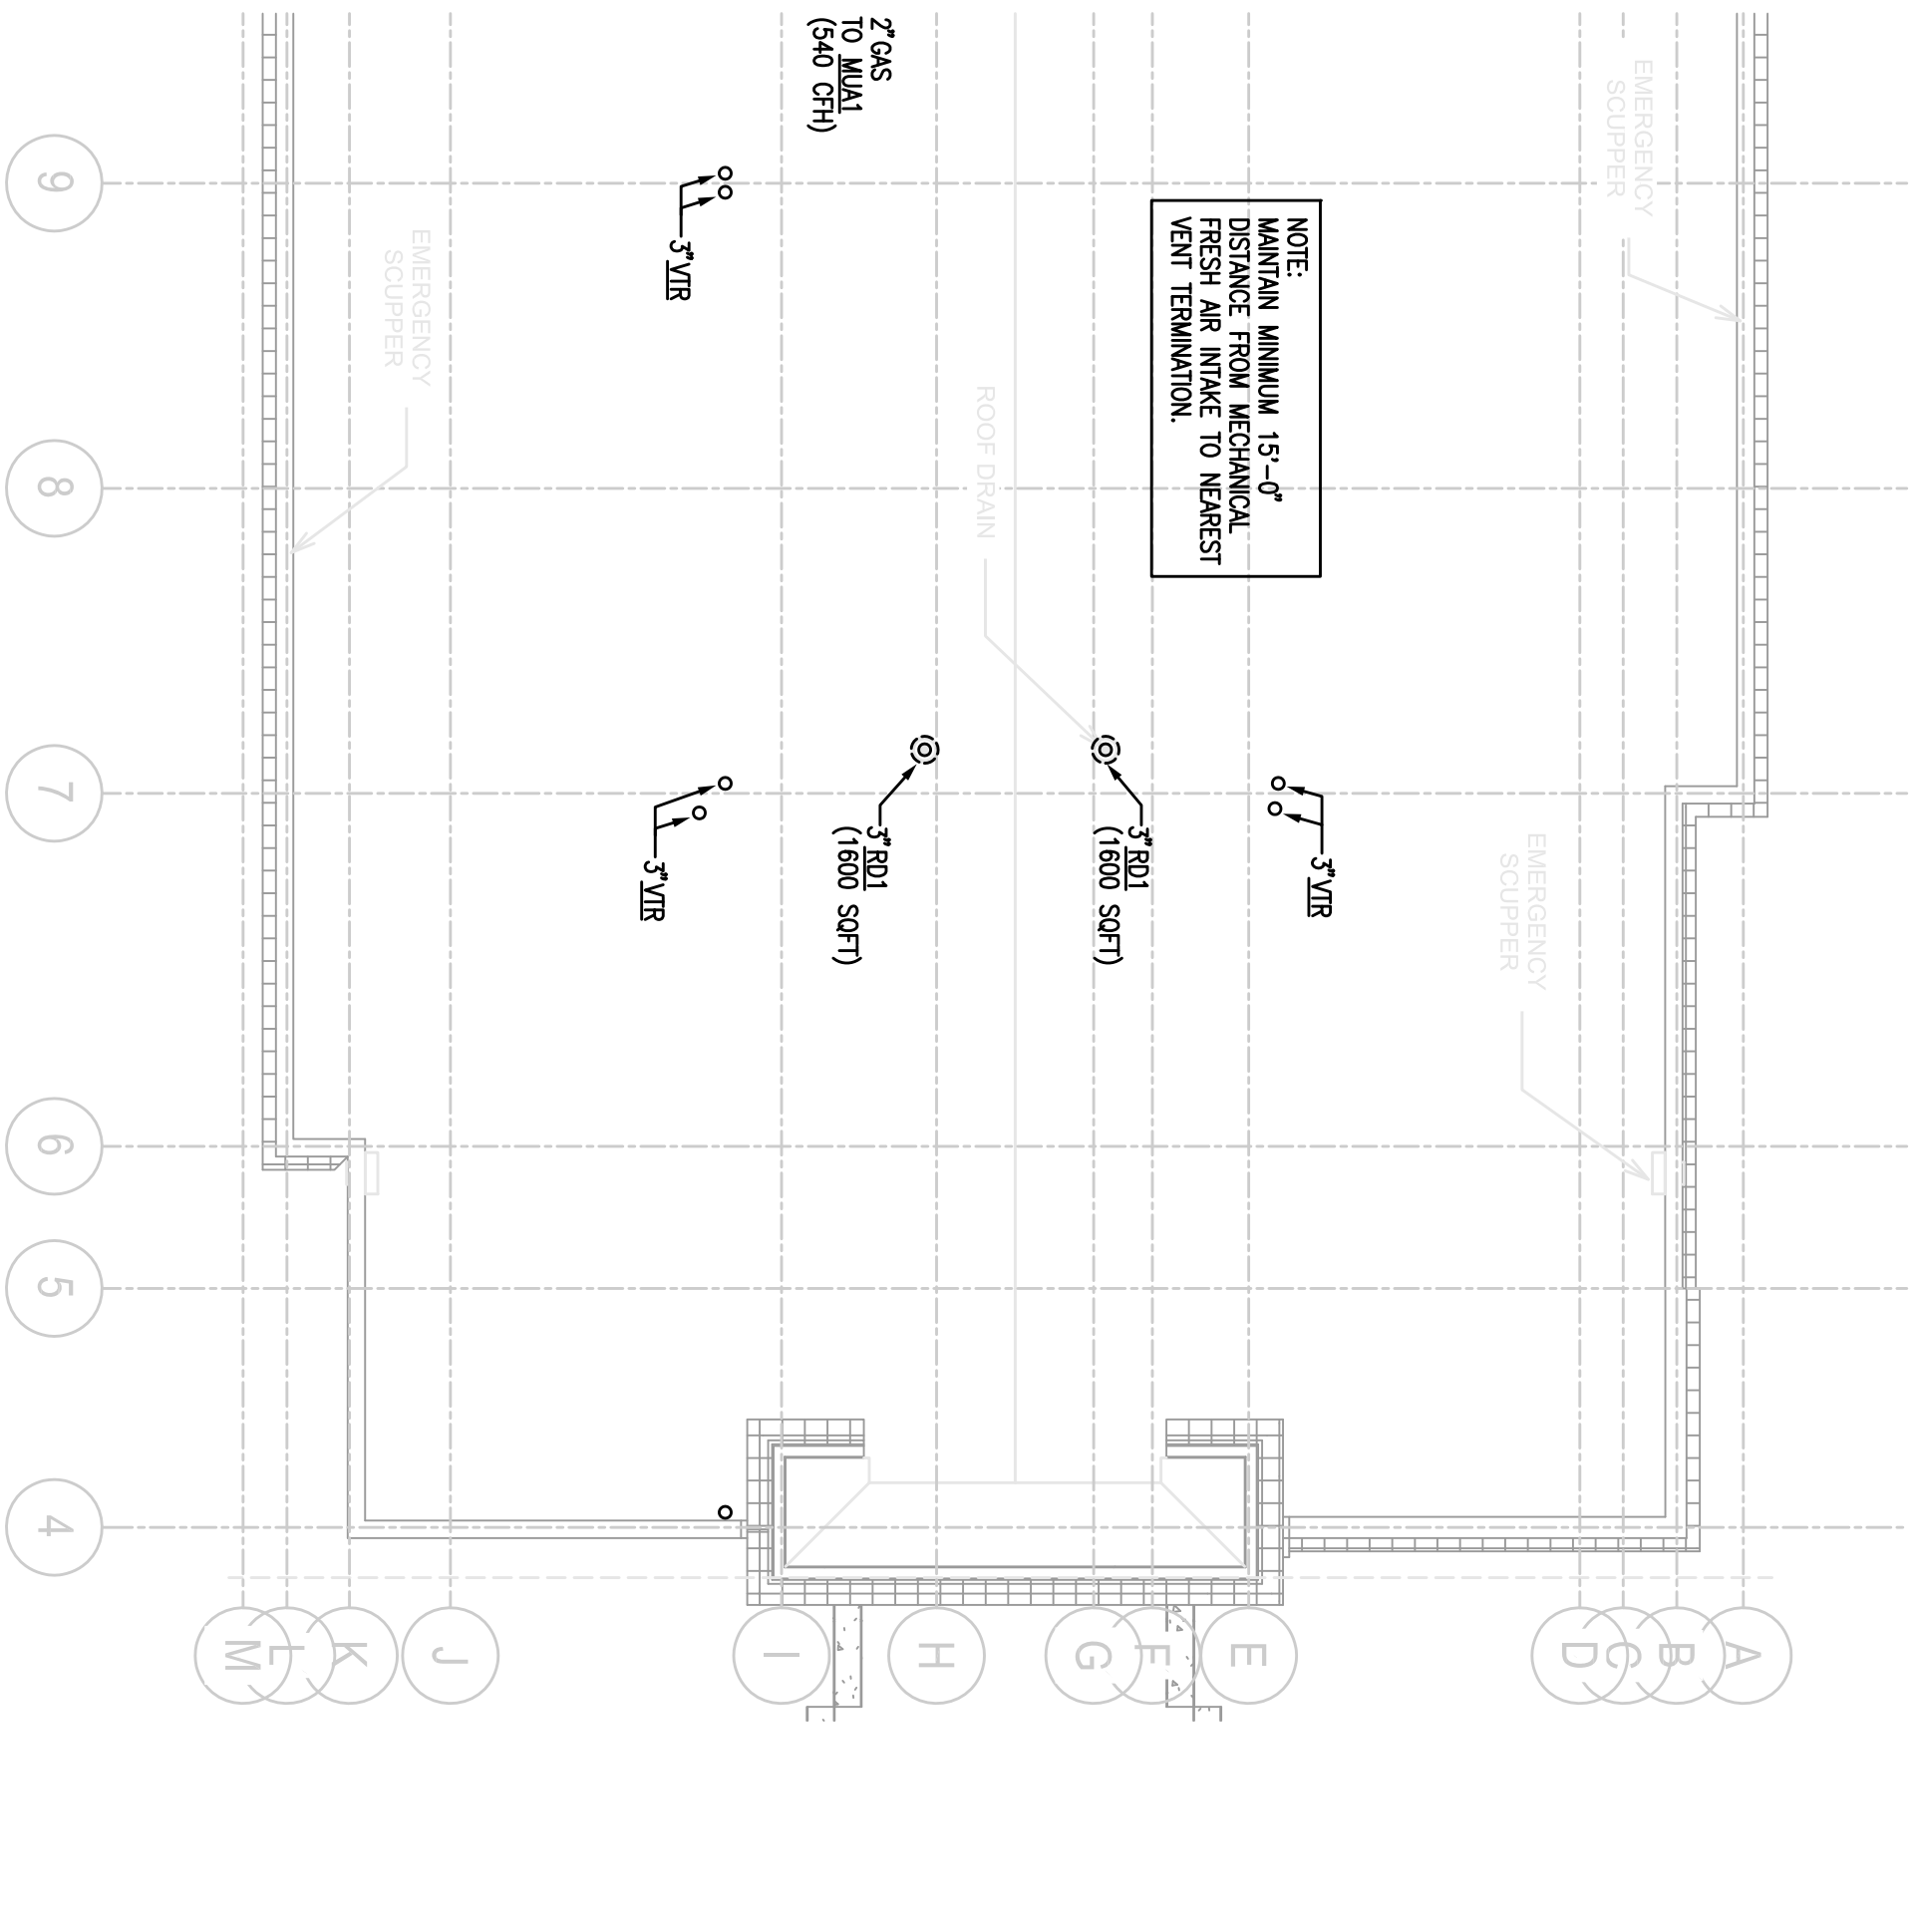

REVISIONS		
No.	Date	Description

Information contained on this drawing and the design is the property of MISHRA ARCHITECTURE PLLC and may not be used for any other project without the written or verbal permission from MISHRA ARCHITECTURE PLLC. Original drawing is MISHRA ARCHITECTURE PLLC.

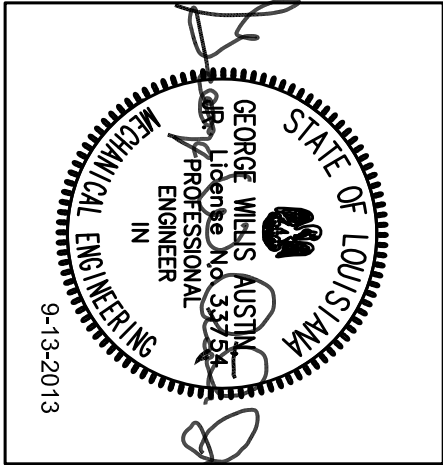

KEY PLAN

Southern Hospitality
Services

Hampton Inn and
Suites

5400 I-20 & Frontage Rd.
Monroe, LA 71201

Drawn: TMS
Roof Plan - Plumbing

Title: FOR CONSTRUCTION

Project No.	Sheet No.
12-111	P 105
Prepared By: JCF	
Checked By: WGA	
Date: September 16, 2013	
Released for:	

1 ROOF PLAN - PLUMBING

Scale: 1/8" = 1'-0"

