


6800 S. Cove Rd., Charlotte, NC 28277
Ph: (704) 925-6554 Fax: (704) 919-5822
EMAIL: info@mishraarch.com
WEB: www.mishraarch.com



217 N. McDowell St.
Suite 2004
Charlotte, NC 28204
(770) 347-0093
www.shultzeng.com
SEC - 13-039

REVISIONS	
No.	Description
1	11/21/13 Permit Comments
2	11/25/13 Fanchise Comments

Information contained on this drawing and the work shown hereon are the property of SHULTZ ENGINEERING GROUP, PC and may not be reproduced, stored in a retrieval system, or used in any form or by any means, electronic, mechanical, photocopying, recording, or by any information storage and retrieval system, without the prior written permission from SHULTZ ENGINEERING GROUP, PC.

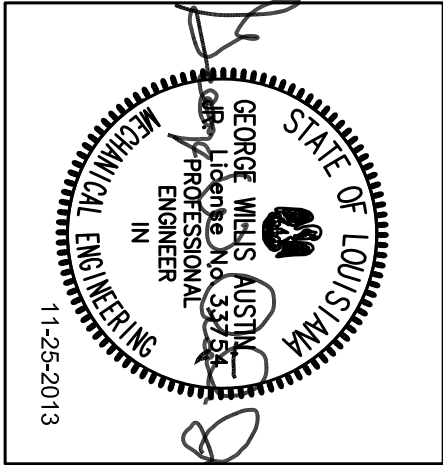

Southern Hospitality
Services
Hampton Inn and
Suites

5400 I-20 & Frontage Rd.
Monroe, LA 71201

Drawings Title
First Floor, Water Supply Piping
Plan - Plumbing

Drawn By
FOR CONSTRUCTION

Project No.	Sheet No.
12-111	P201
Prepared By JCF	
Checked By WGA	
Date September 16, 2013	
Released For	

1 FIRST FLOOR WATER SUPPLY PIPING PLAN - PLUMBING

SCALE: 1/8" = 1'-0"

P201

2 PARTIAL FIRST FLOOR DOMESTIC WATER PIPING PLAN - PLUMBING


SCALE: 1/8" = 1'-0"

P201

3 PARTIAL FIRST FLOOR DOMESTIC WATER PIPING PLAN - PLUMBING

SCALE: 1/8" = 1'-0"

P201

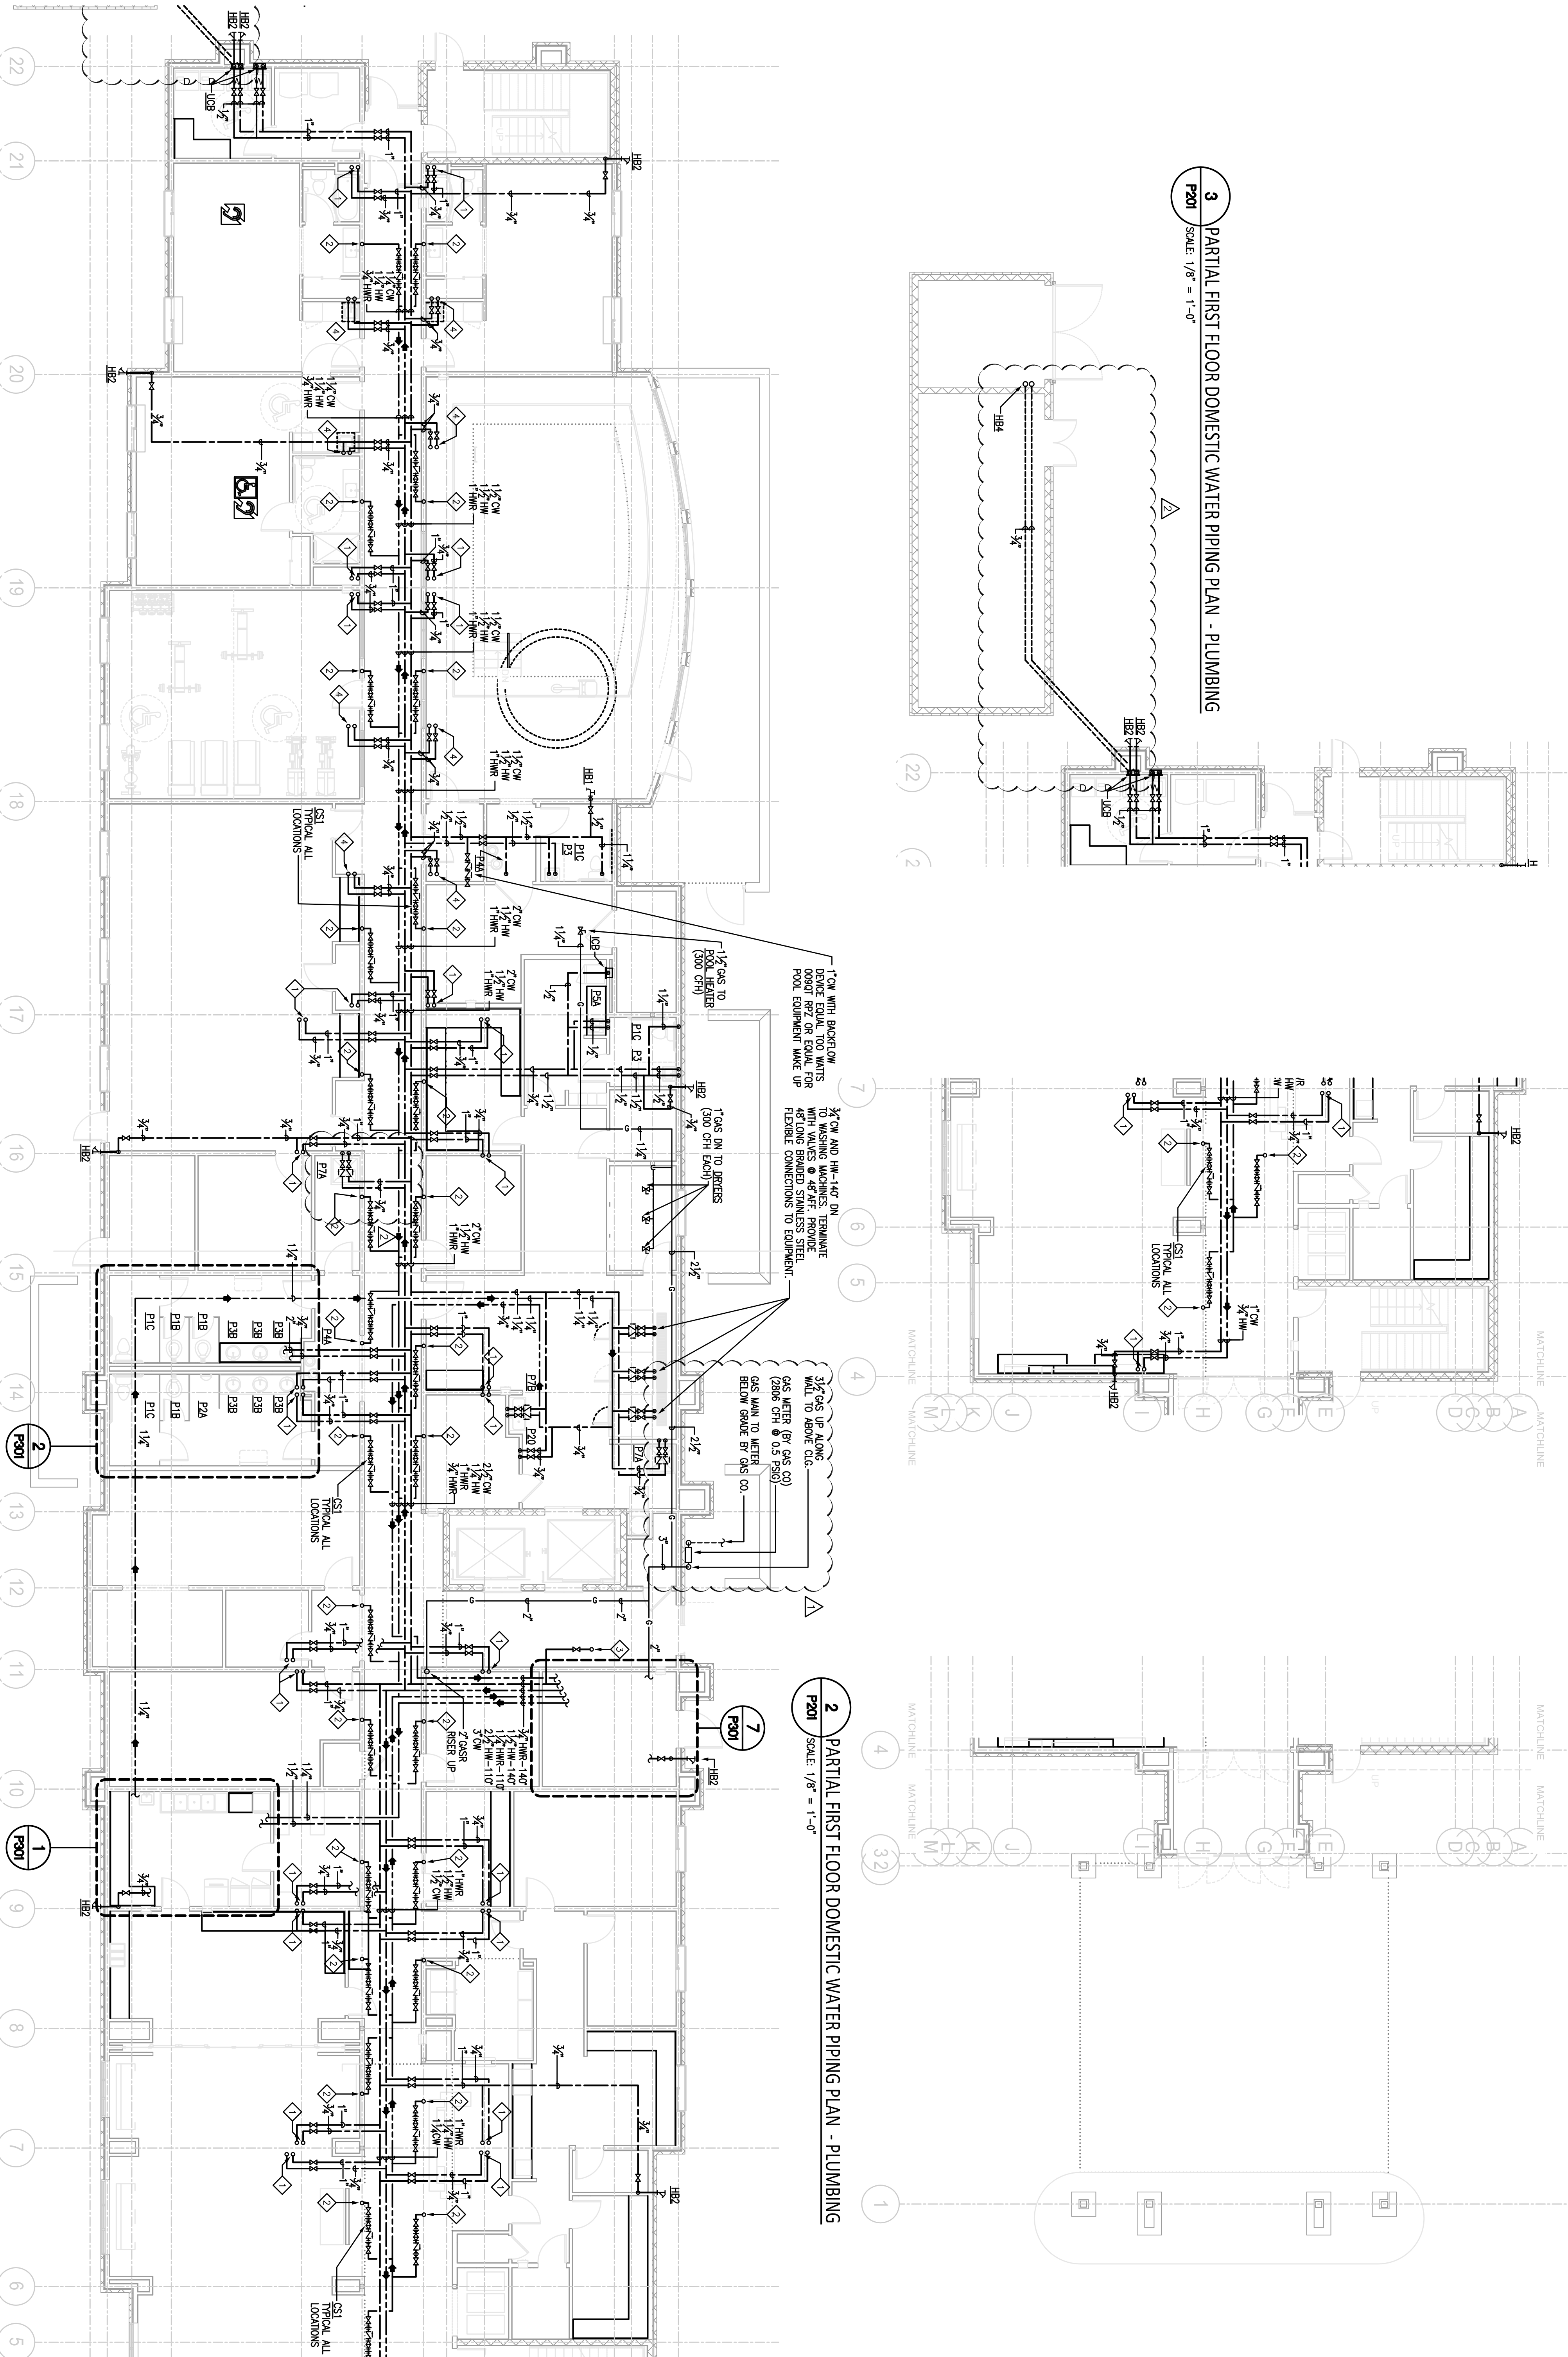

- ◇ CW AND HW RISER FOR TOILET GROUP. SEE RISER SCHEMATICS ON SHEET P401
- ◇ HW RISER FOR TOILET GROUP. SEE RISER SCHEMATICS ON SHEET P401
- ◇ CW RISER FOR VENDING AREA. SEE RISER SCHEMATICS ON SHEET P401
- ◇ CW AND HW RISER FOR IN ROOM SINKS. SEE RISER SCHEMATICS ON SHEET P401