


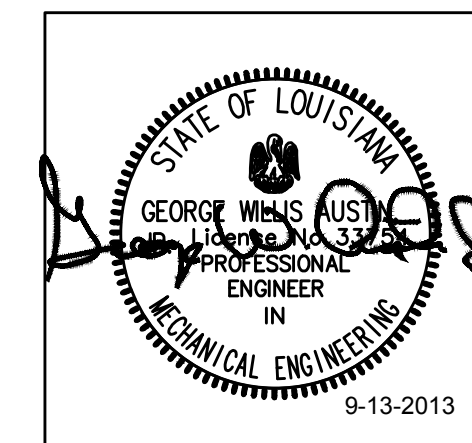

REVISIONS		
No.	Date	Description

Information contained on this drawing and in all digital files associated is authorized for use on the project named herein only and is the property of MISHRA ARCHITECTURE PLLC and may not be reproduced in any manner without express written or verbal permission from authorized individuals. Original drawing is 24"x36" and scales are as indicated. © 2011 MISHRA ARCHITECTURE PLLC



KEY PLAN

Southern Hospitality
Services

Hampton Inn and
Suites

5400 I-20 & Frontage Rd.
Monroe, LA 71201

Drawing Title
Second Floor, Waste and Vent
Piping Plan - Plumbing

Phase
FOR CONSTRUCTION


Project No. 12-111
Prepared by JCF
Checked by WGA

Date
September 16, 2013

Released for


Sheet No.
P102

Hampton Inn and Suites

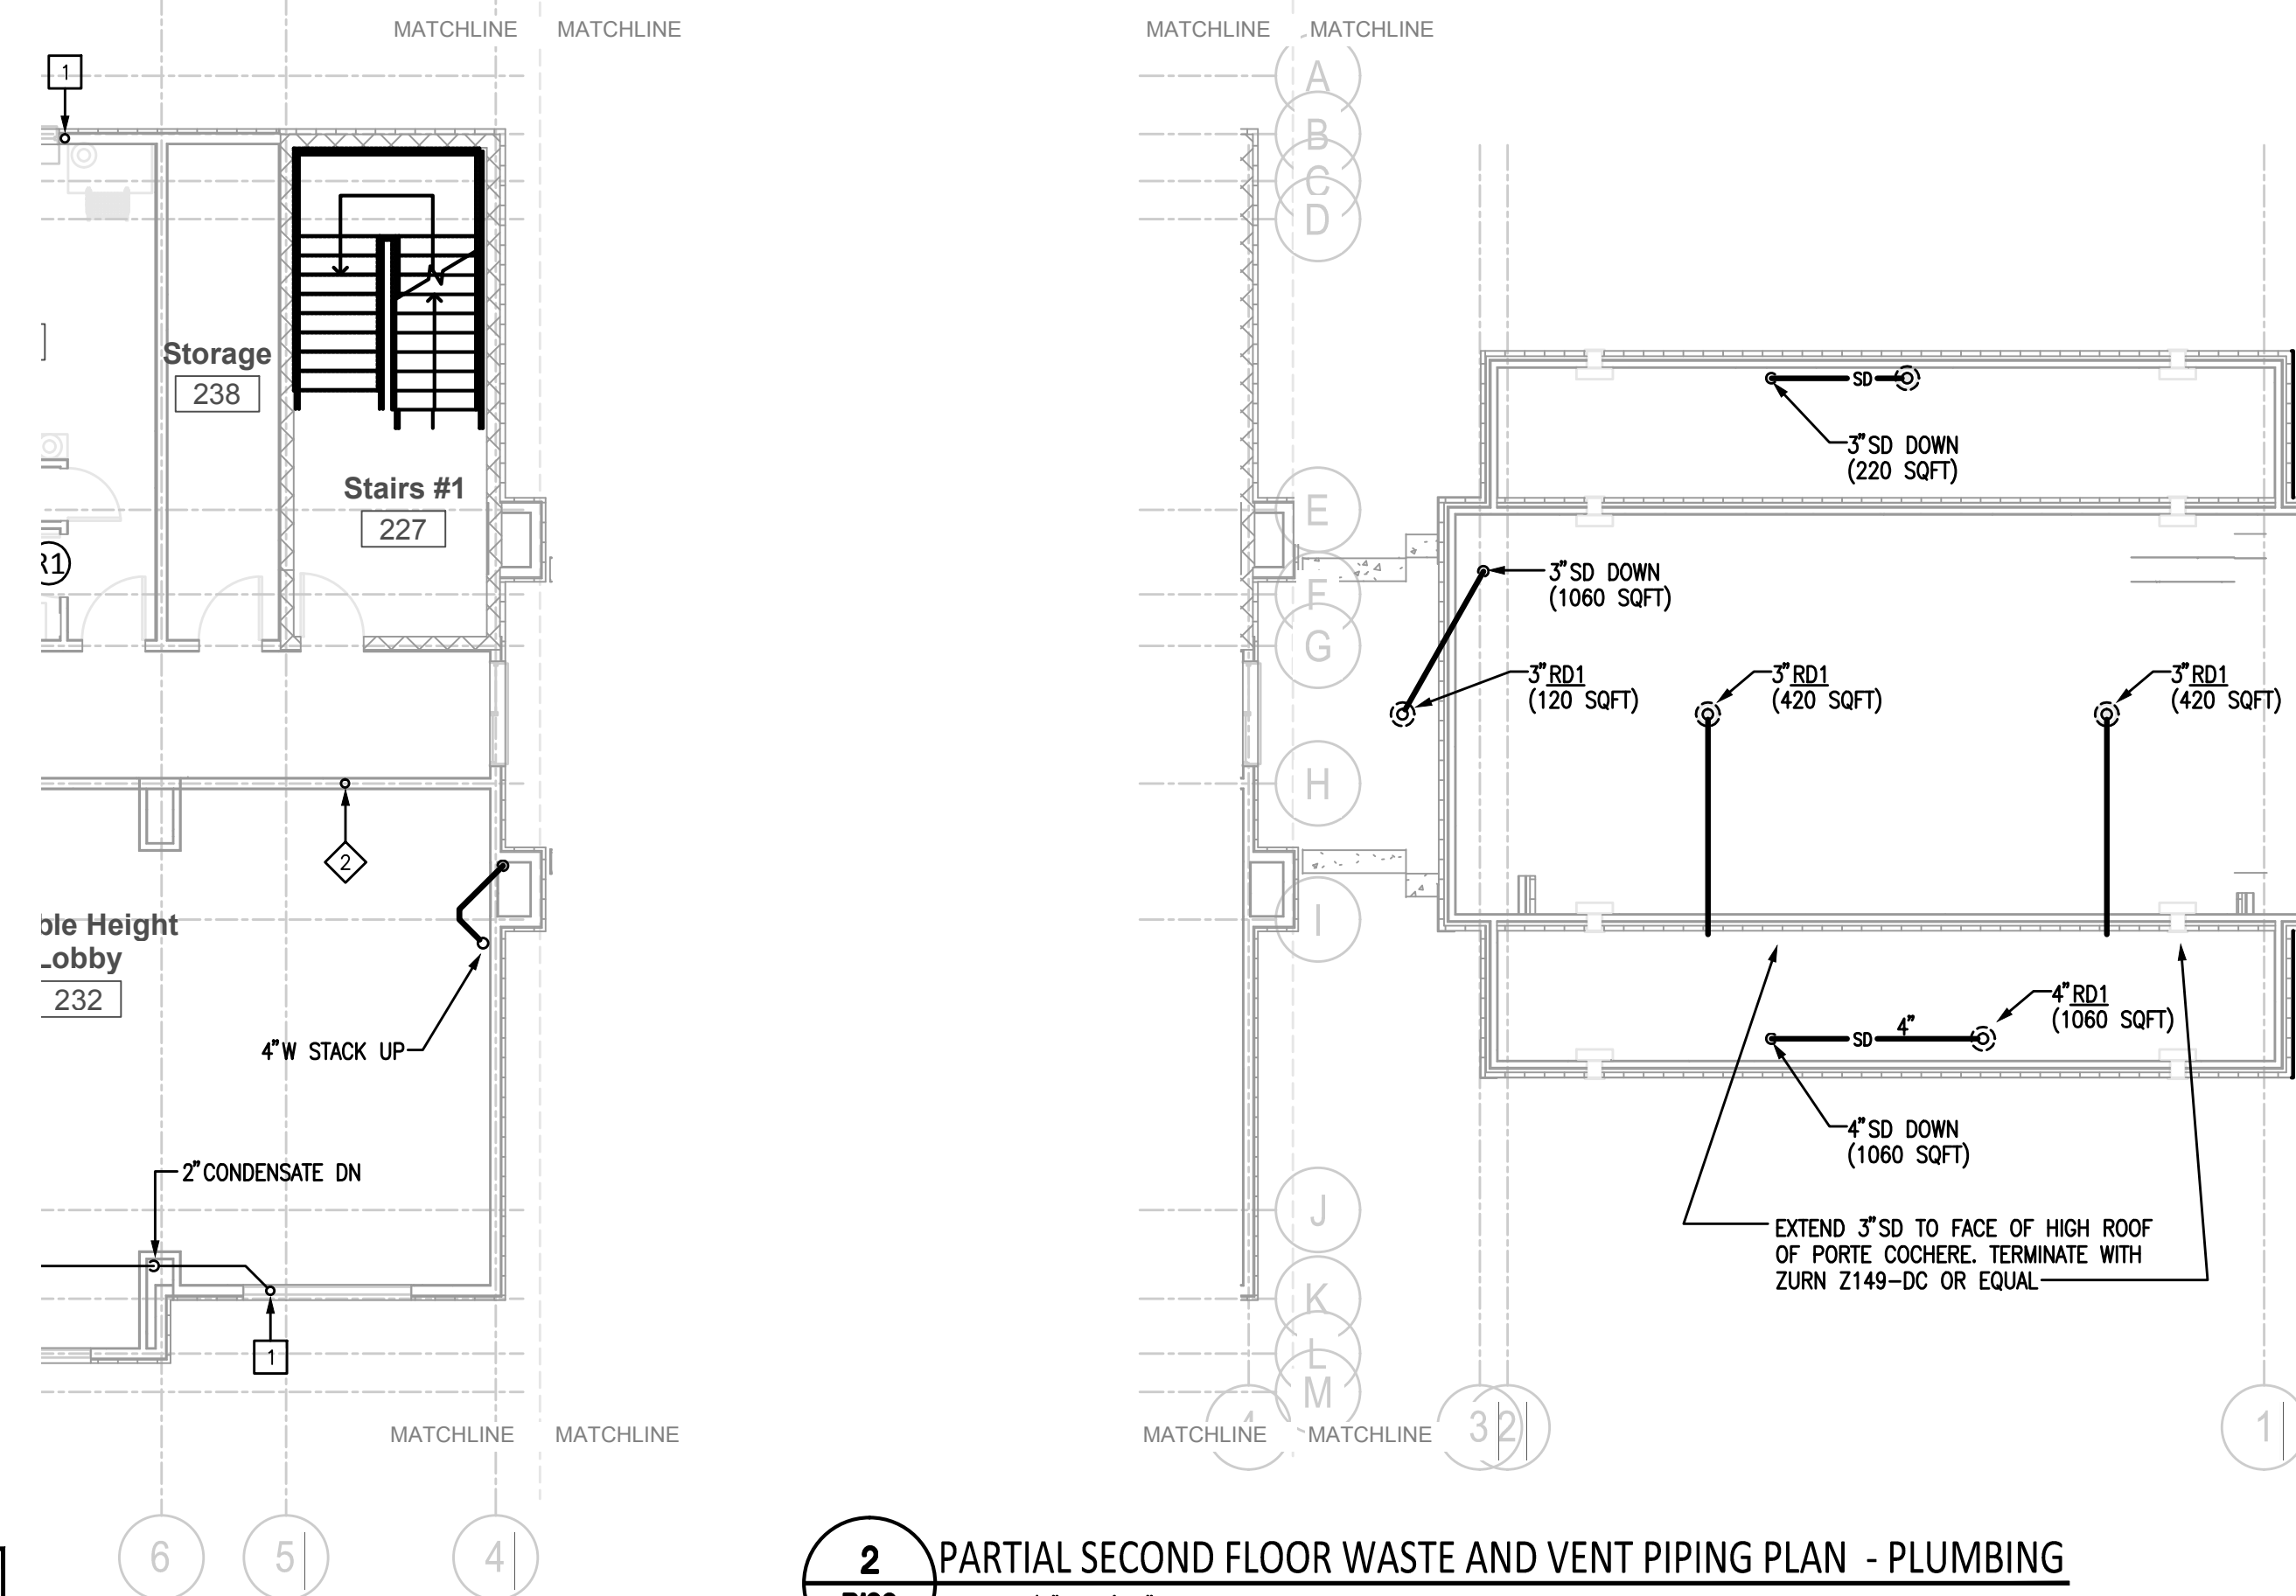

2 PARTIAL SECOND FLOOR WASTE AND VENT PIPING PLAN - PLUMBING
SCALE: 1/8" = 1'-0"

- 1 CONDENSATE RISER FOR IN ROOM PTAC UNITS. PROVIDE 1 1/4" TEE AT EACH FLOOR FOR MECHANICAL CONDENSATE DISCHARGE CONNECTION. CONDENSATE RISER 1 1/2" UNLESS OTHERWISE NOTED.
- 2 CW AND HW RISER FOR TOILET GROUP. SEE RISER SCHEMATICS ON SHEET P401
- 3 HWR RISER FOR TOILET GROUP. SEE RISER SCHEMATICS ON SHEET P401
- 4 CW RISER FOR VENDING AREA. SEE RISER SCHEMATICS ON SHEET P401
- 5 CW AND HW RISER FOR IN ROOM SINKS. SEE RISER SCHEMATICS ON SHEET P401
- 6 SEE WASTE AND VENT RISER SCHEMATICS ON SHEET P401

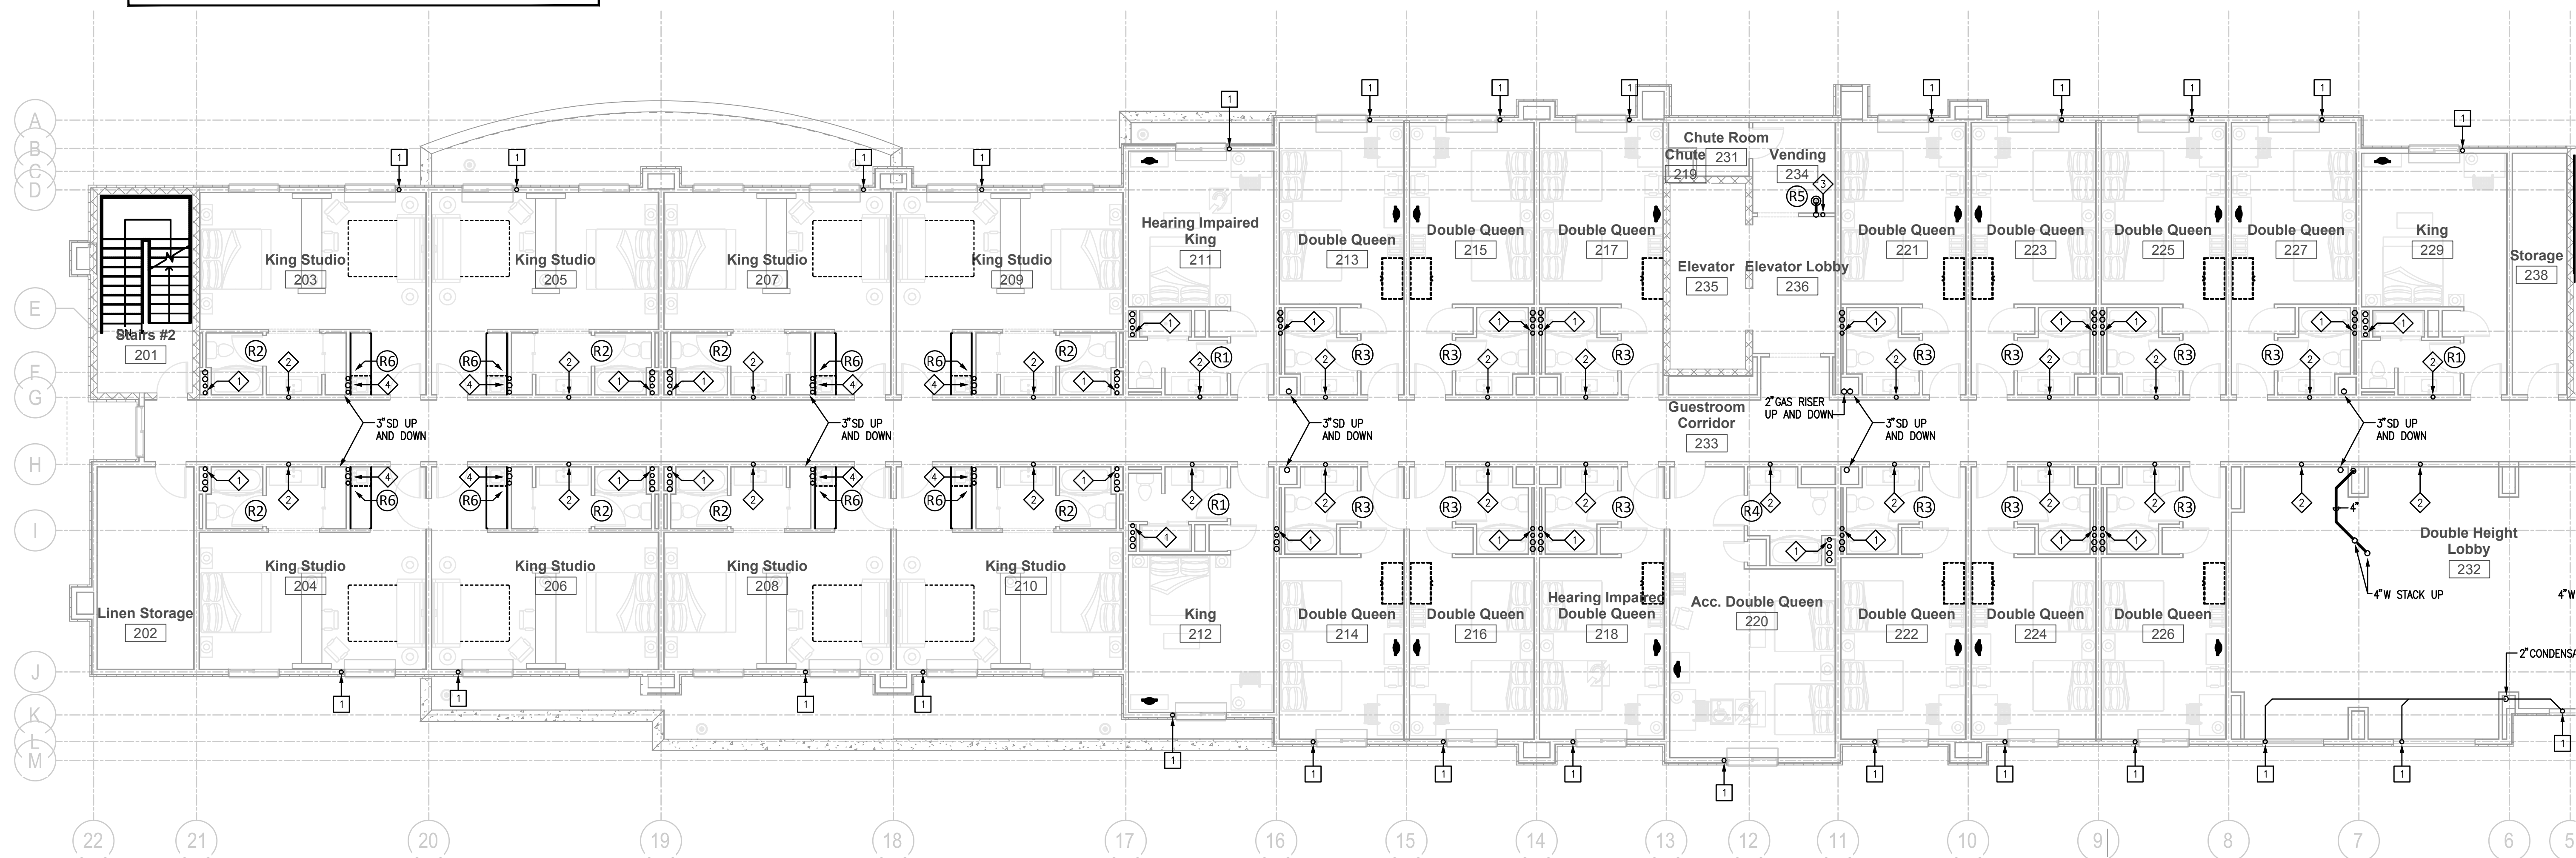

1 SECOND FLOOR PLAN - PLUMBING
SCALE: 1/8" = 1'-0"