


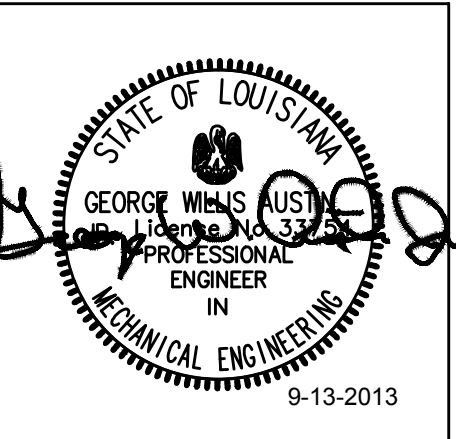

REVISIONS		
No.	Date	Description

Information contained on this drawing and in all digital files associated is authorized for use on the project named herein only and is the property of MISHRA ARCHITECTURE PLLC and may not be reproduced in any manner without express written or verbal permission from authorized individuals. Original drawing is 24"x36" and scales are as indicated. © 2011 MISHRA ARCHITECTURE PLLC



KEY PLAN

Southern Hospitality  
Services

Hampton Inn and  
Suites

5400 I-20 & Frontage Rd.  
Monroe, LA 71201

Drawing Title  
Third Floor, Waste and Vent  
Piping Plan - Plumbing


Phase  
FOR CONSTRUCTION

Project No. 12-111  
Prepared by JCF  
Checked by WGA  
Date September 16, 2013

Sheet No.  
P103

Released for

Hampton Inn and Suites

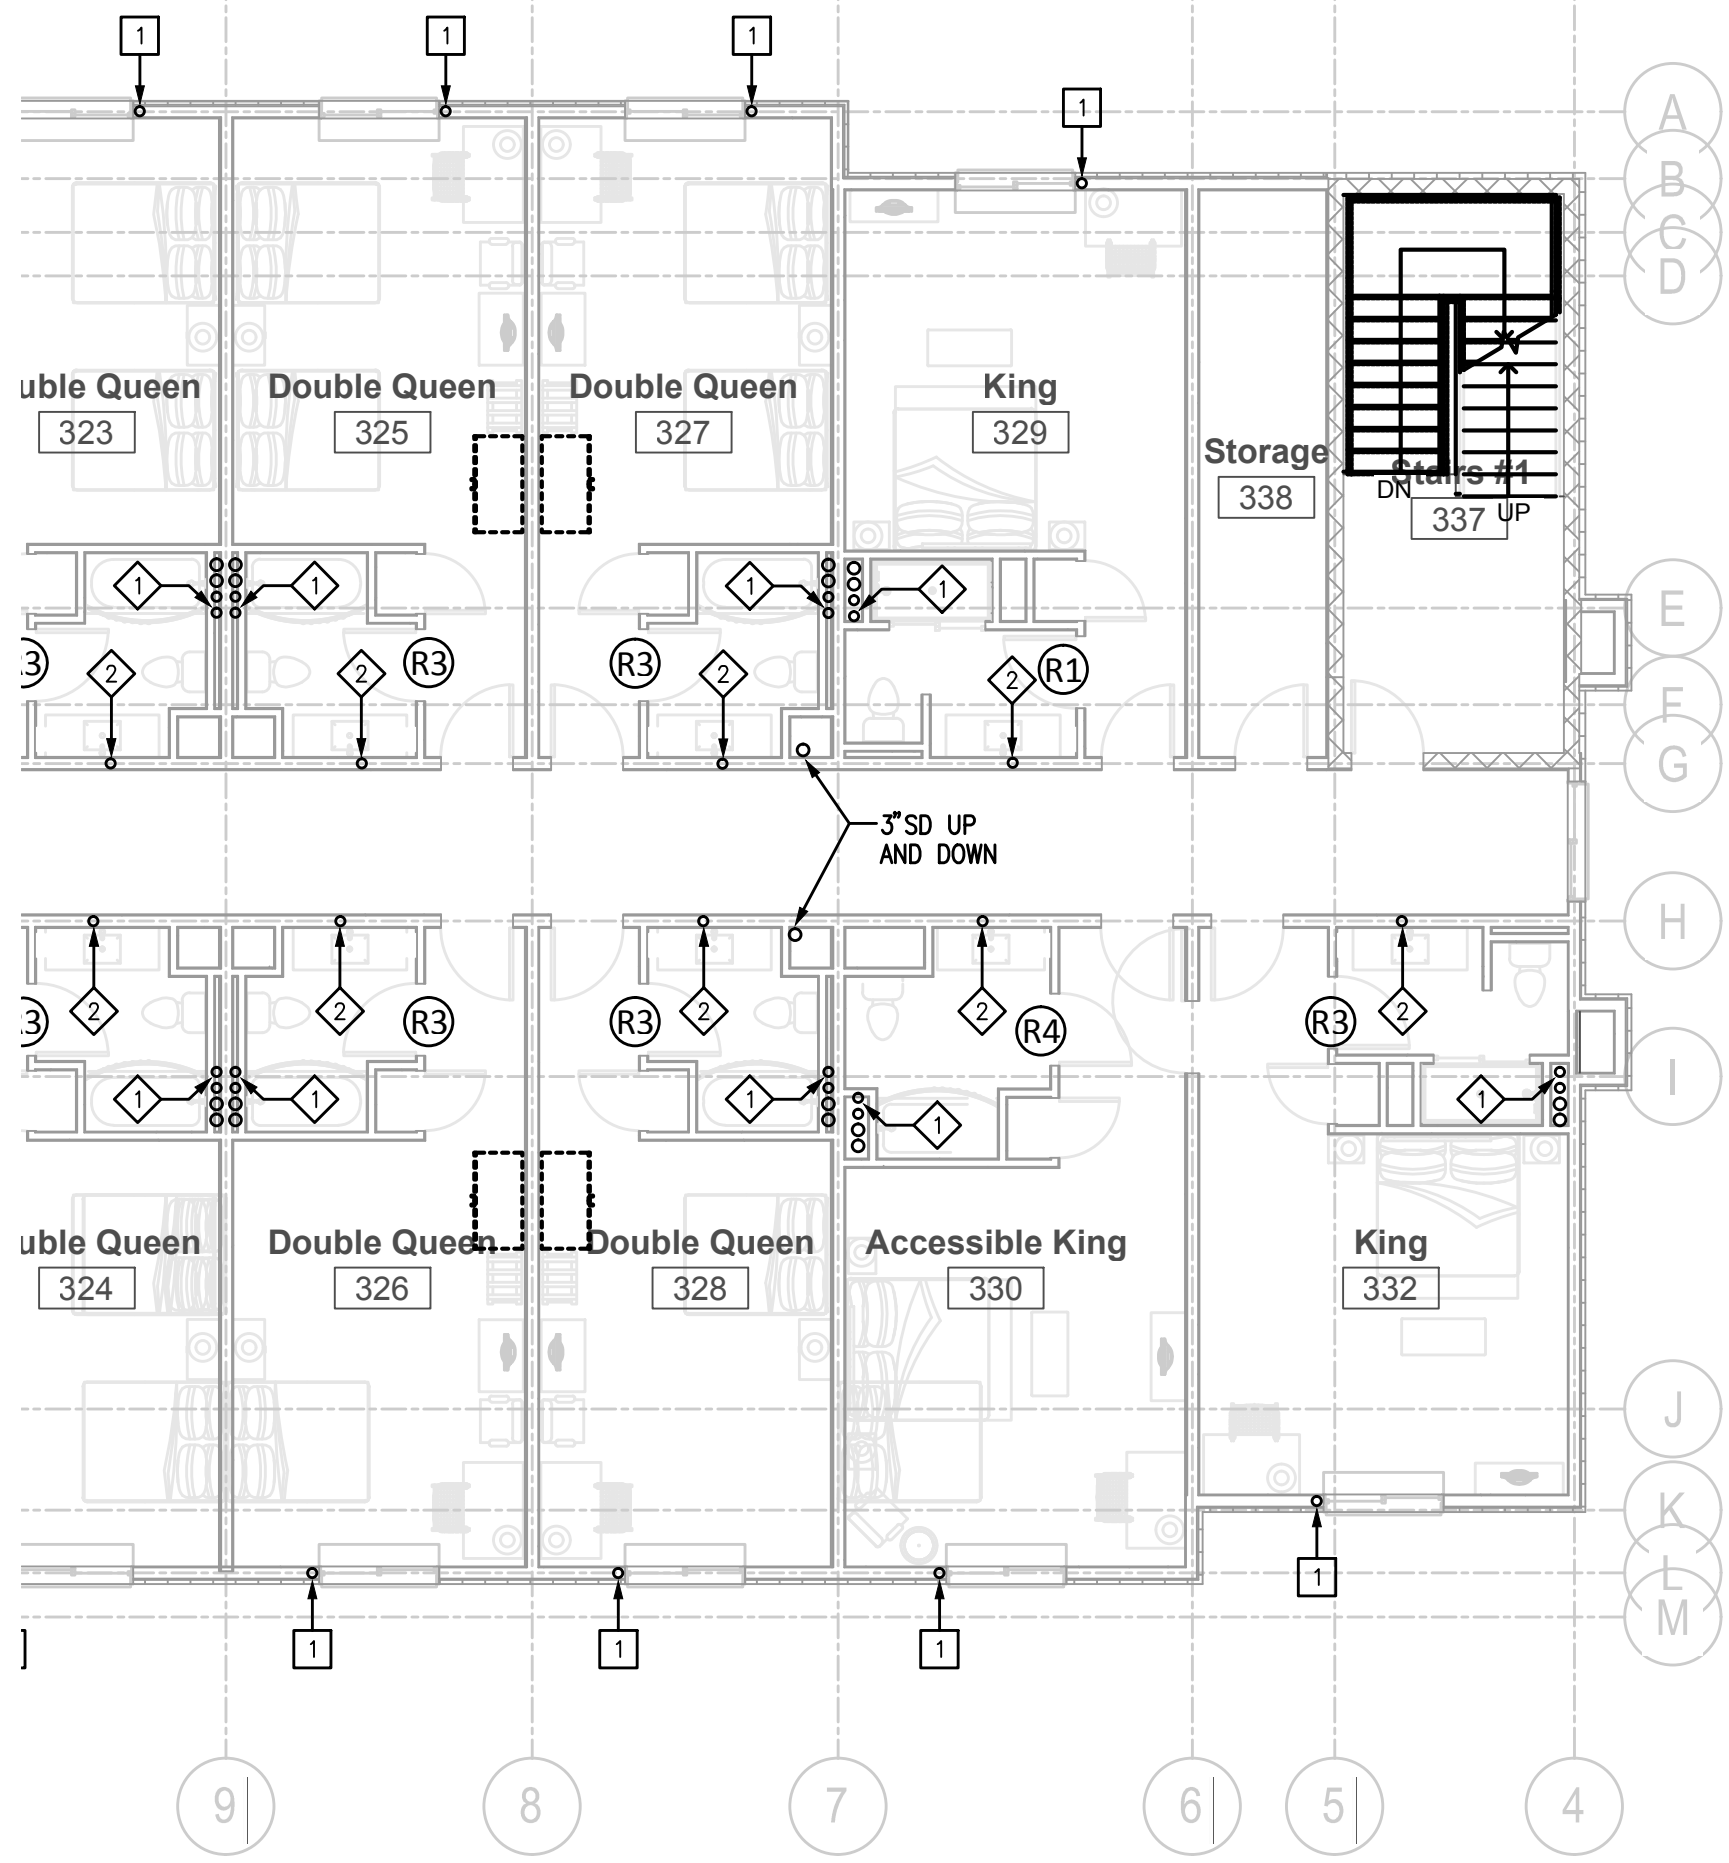


2 PARTIAL THIRD FLOOR PLAN - PLUMBING  
P103 SCALE: 1/8" = 1'-0"

- 1 CW AND HW RISER FOR TOILET GROUP. SEE RISER SCHEMATICS ON SHEET P401
- 2 HWR RISER FOR TOILET GROUP. SEE RISER SCHEMATICS ON SHEET P401
- 3 CW RISER FOR VENDING AREA. SEE RISER SCHEMATICS ON SHEET P401
- 4 CW AND HW RISER FOR IN ROOM SINKS. SEE RISER SCHEMATICS ON SHEET P401

- 1 CONDENSATE RISER FOR IN ROOM PTAC UNITS. PROVIDE 1 1/4" TEE AT EACH FLOOR FOR MECHANICAL CONDENSATE DISCHARGE CONNECTION. CONDENSATE RISER 1 1/2" UNLESS OTHERWISE NOTED.

- (R#) SEE WASTE AND VENT RISER SCHEMATICS ON SHEET P401

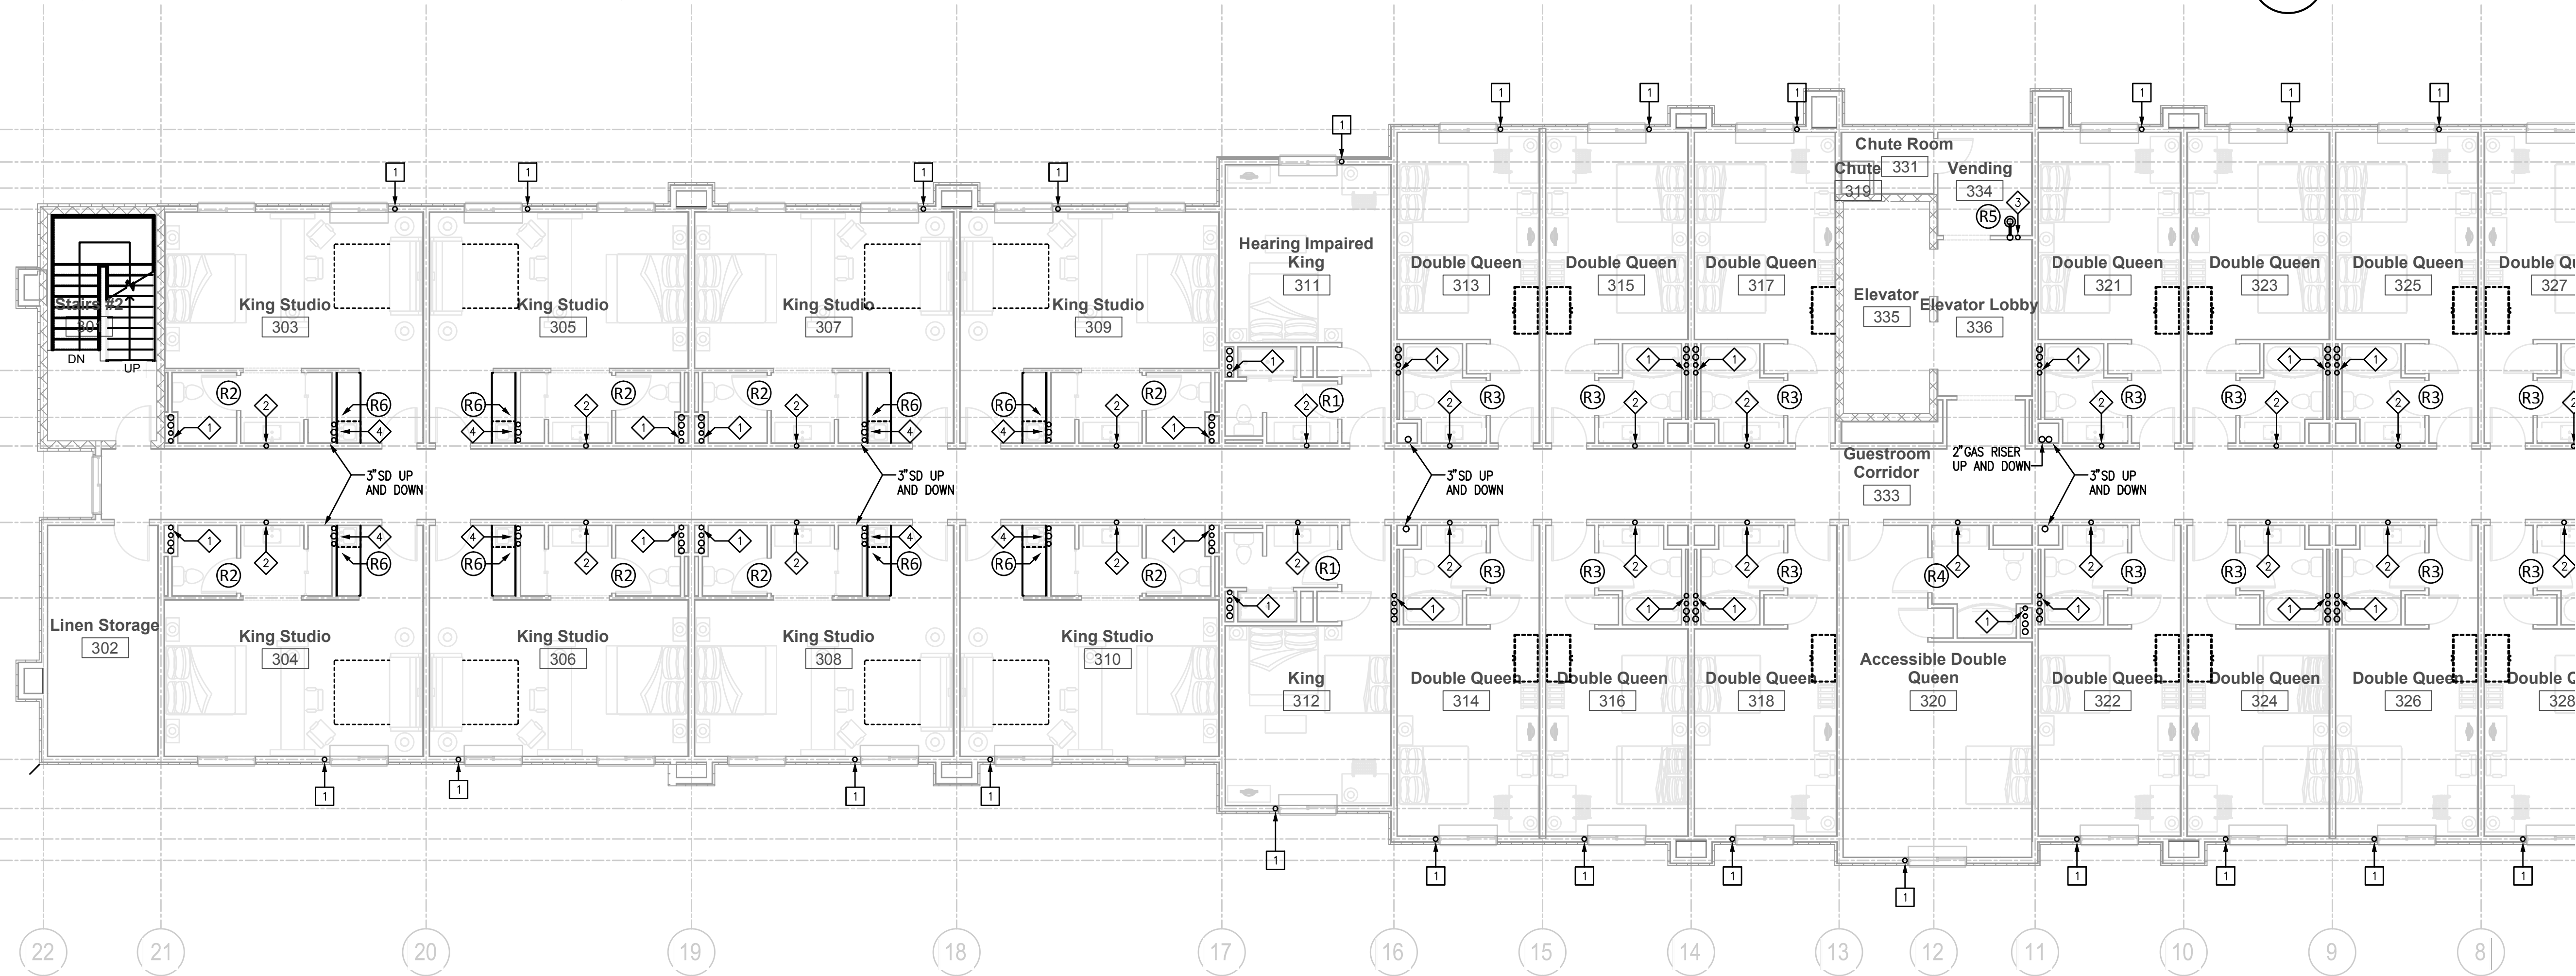

1 PARTIAL THIRD FLOOR PLAN - PLUMBING  
P103 SCALE: 1/8" = 1'-0"