




1 CONDENSATE TRAP DETAIL
M200 NO SCALE

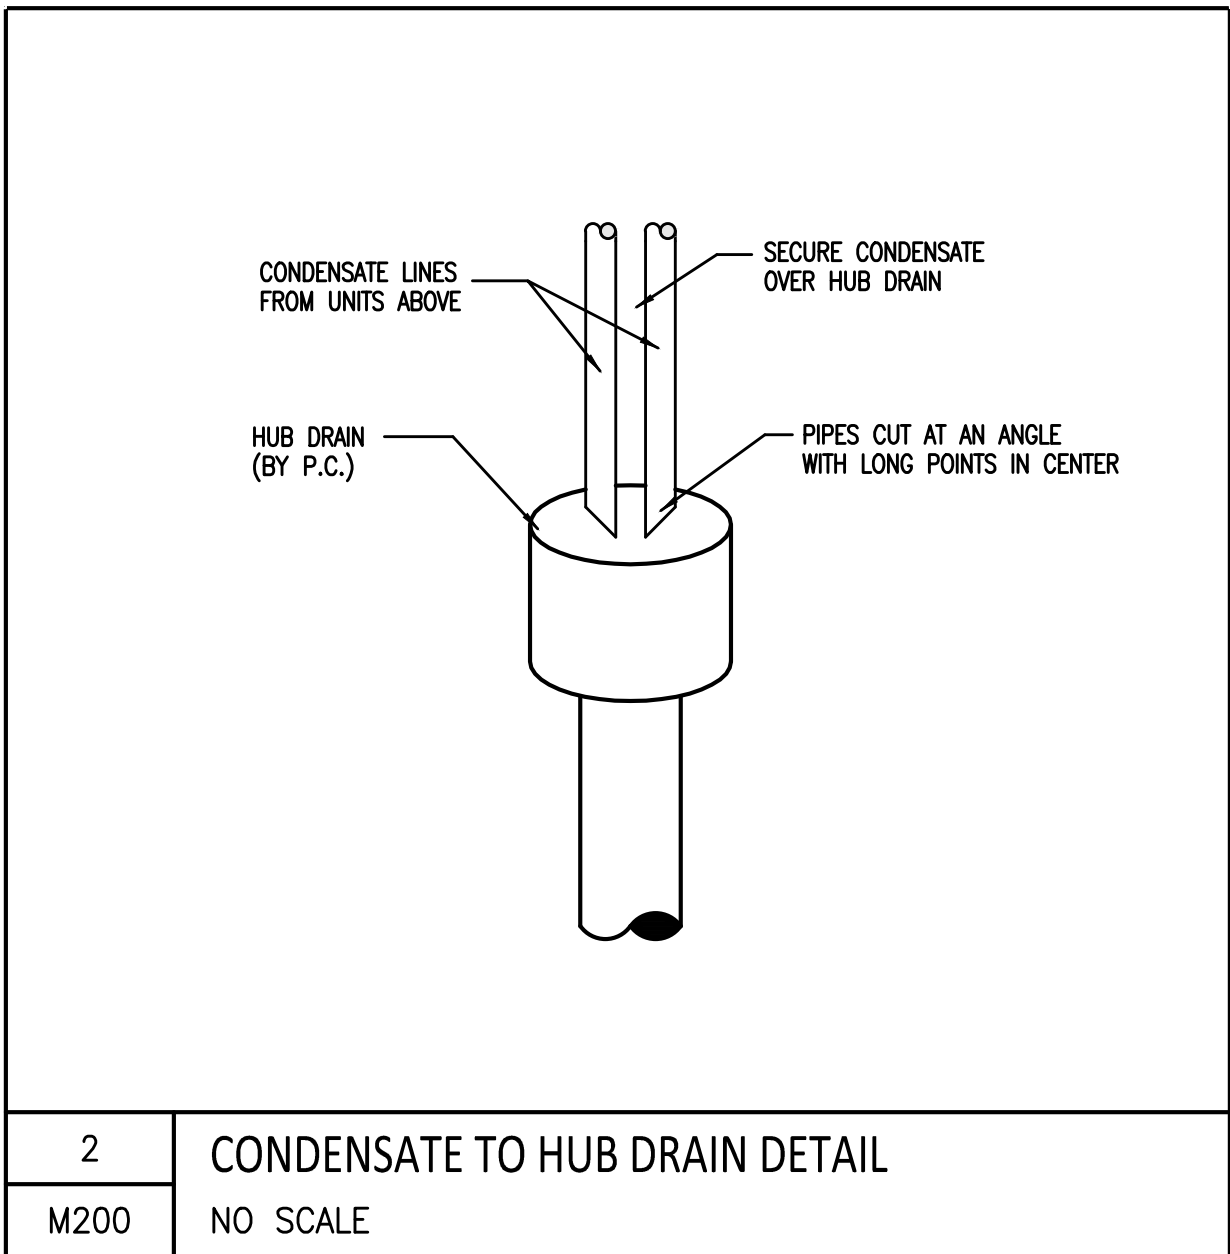


2 CONDENSATE TO HUB DRAIN DETAIL
M200 NO SCALE

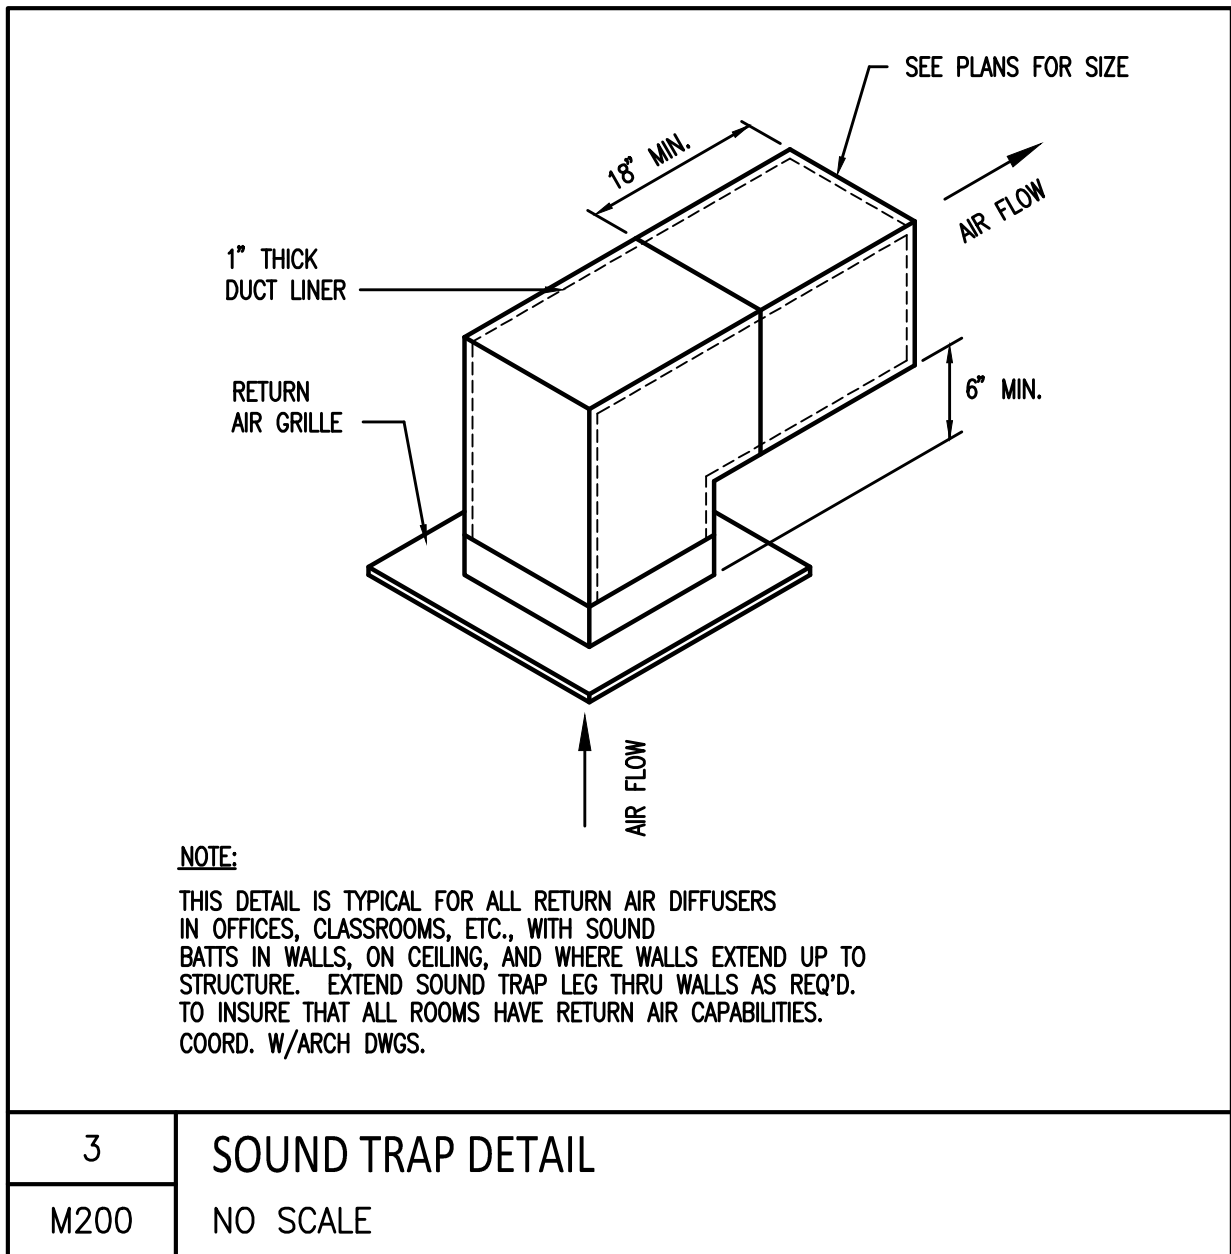


3 SOUND TRAP DETAIL
M200 NO SCALE

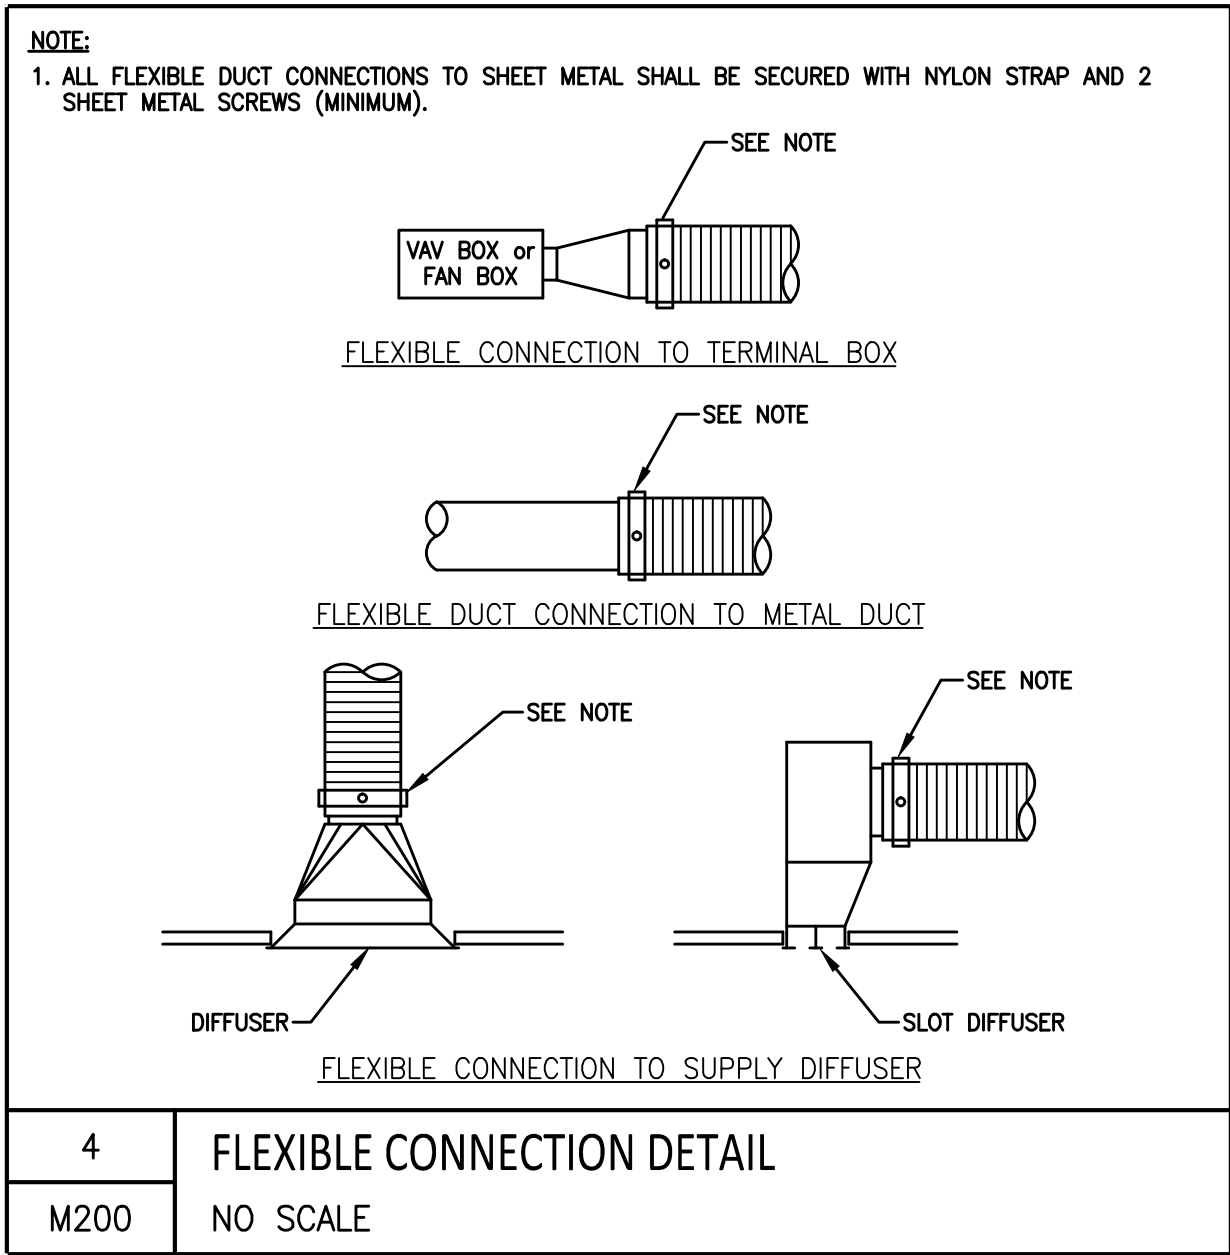


4 FLEXIBLE CONNECTION DETAIL
M200 NO SCALE

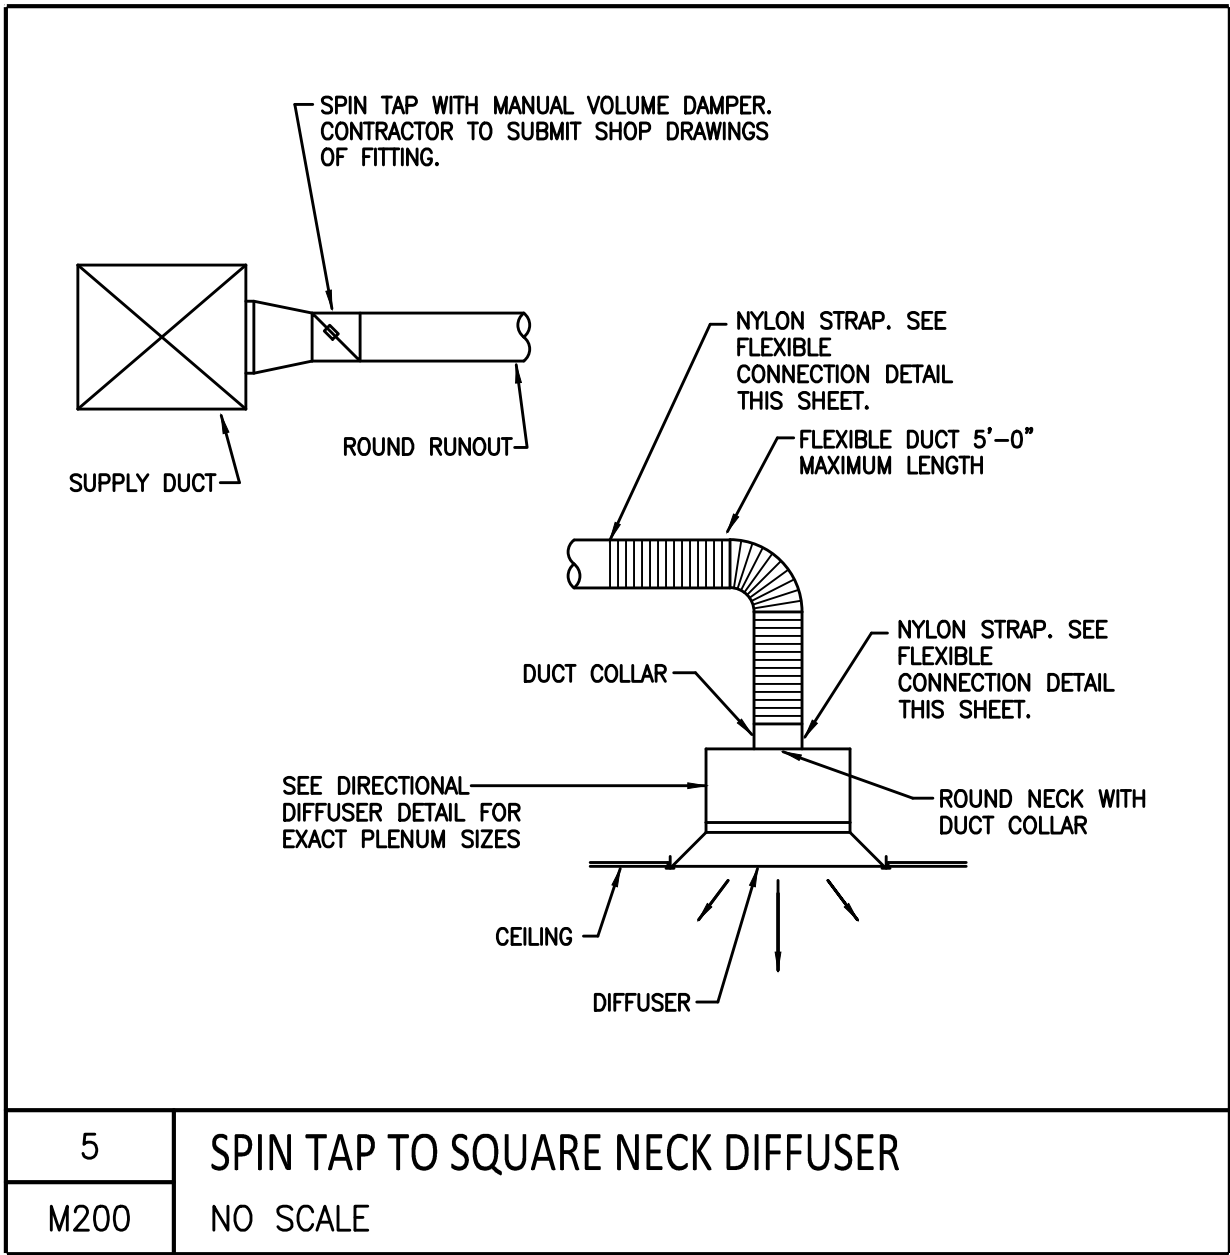


5 SPIN TAP TO SQUARE NECK DIFFUSER
M200 NO SCALE

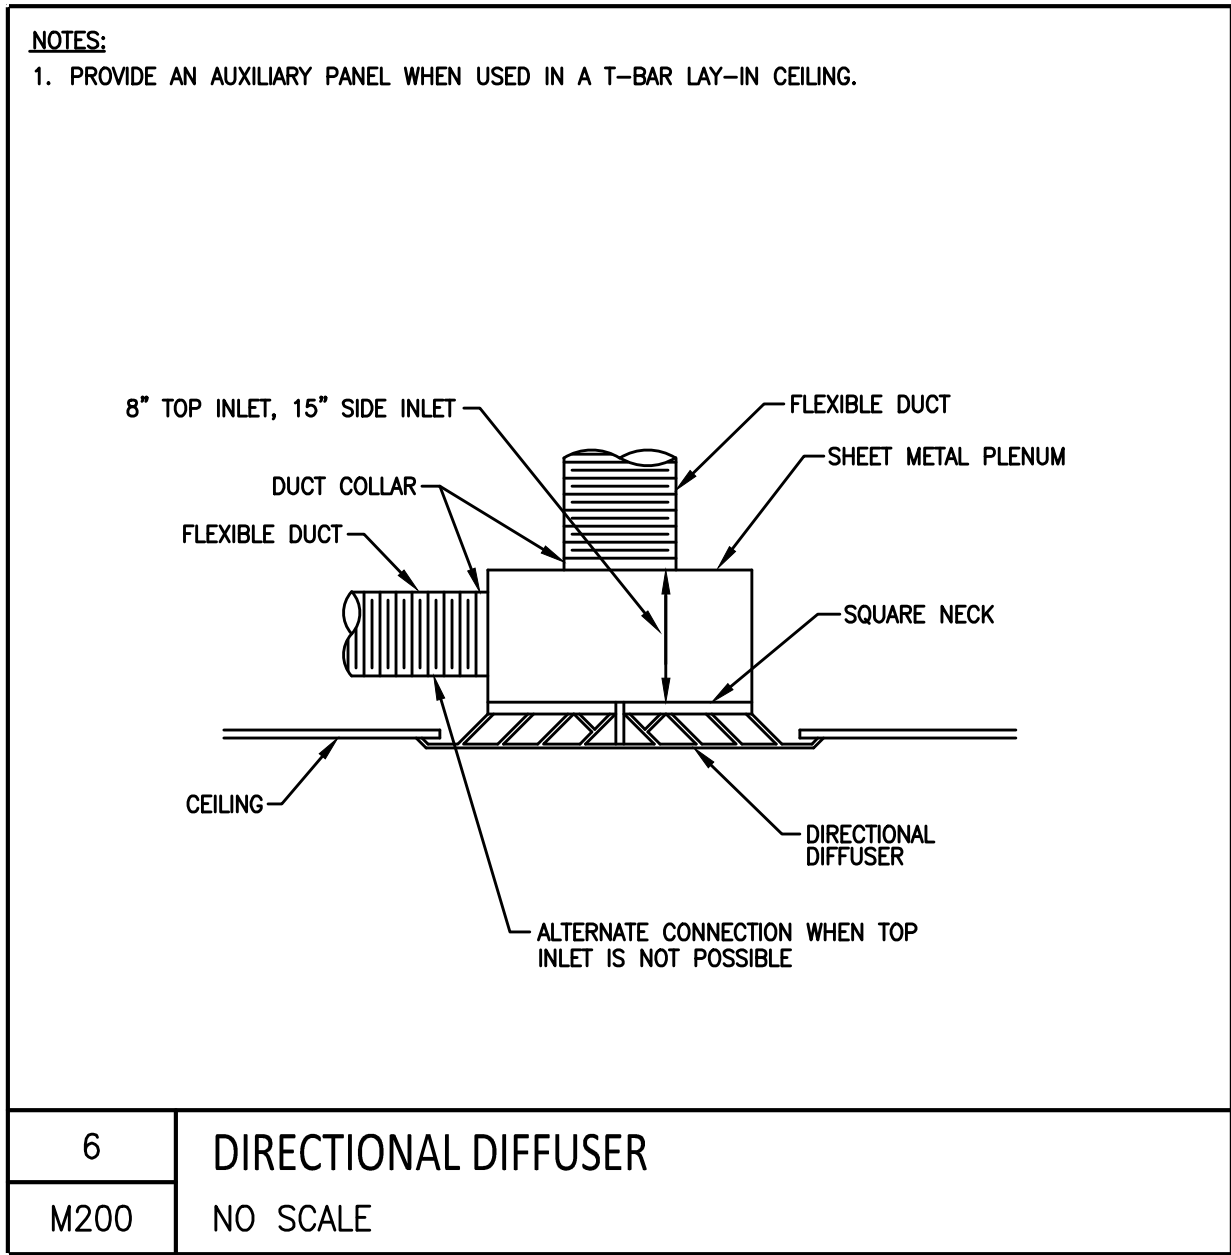


6 DIRECTIONAL DIFFUSER
M200 NO SCALE

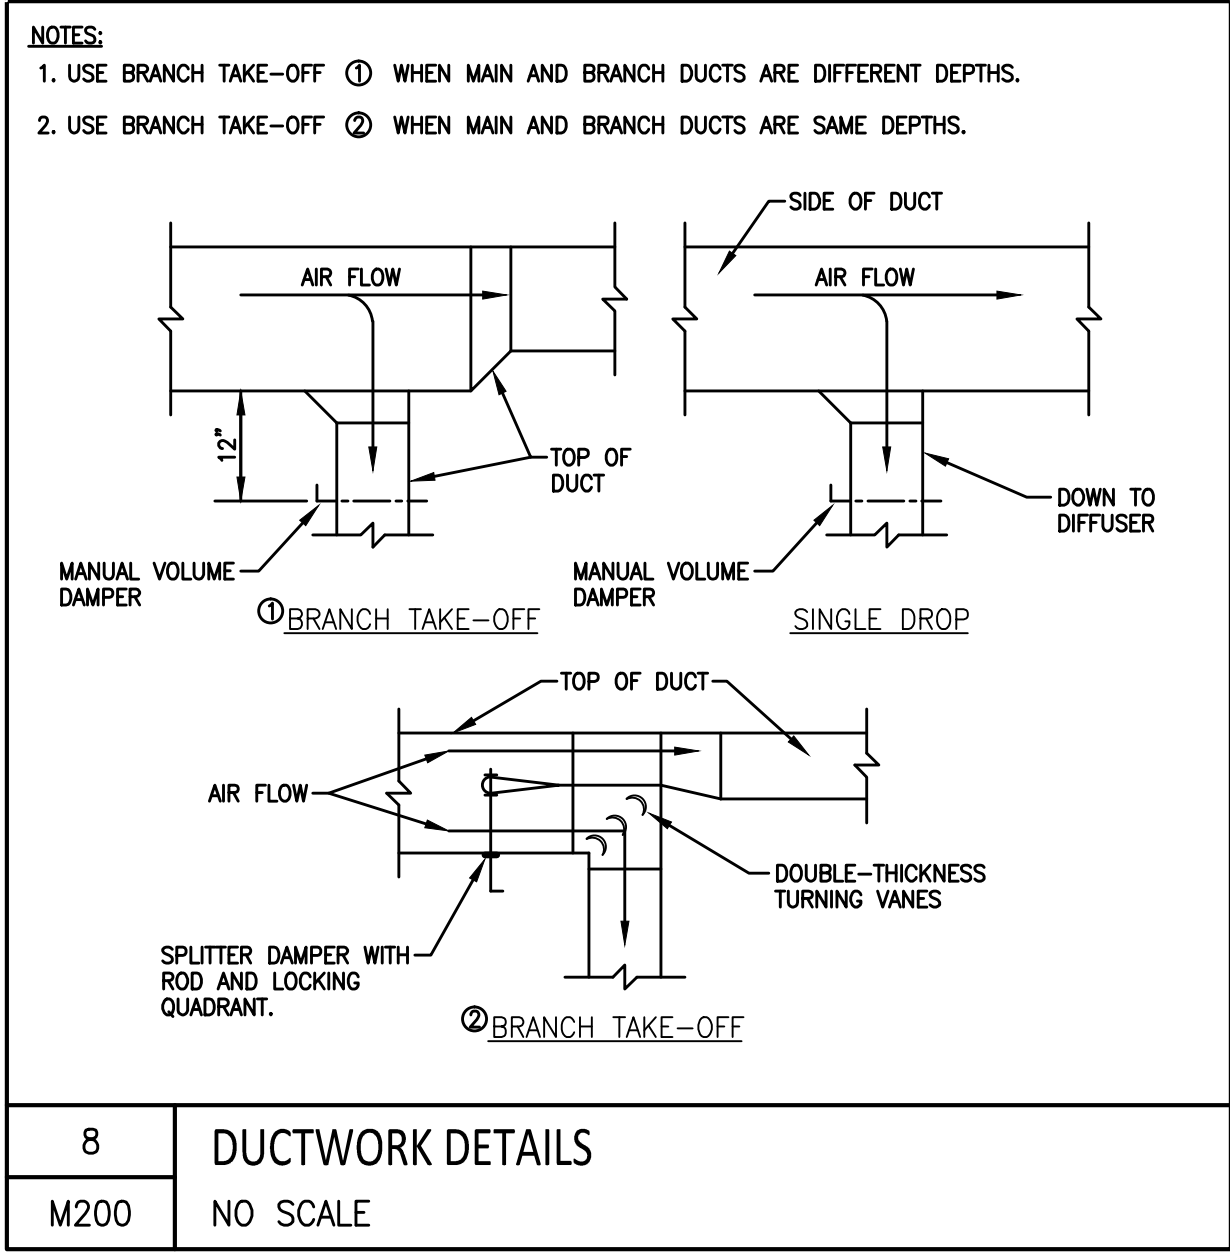


8 DUCTWORK DETAILS
M200 NO SCALE

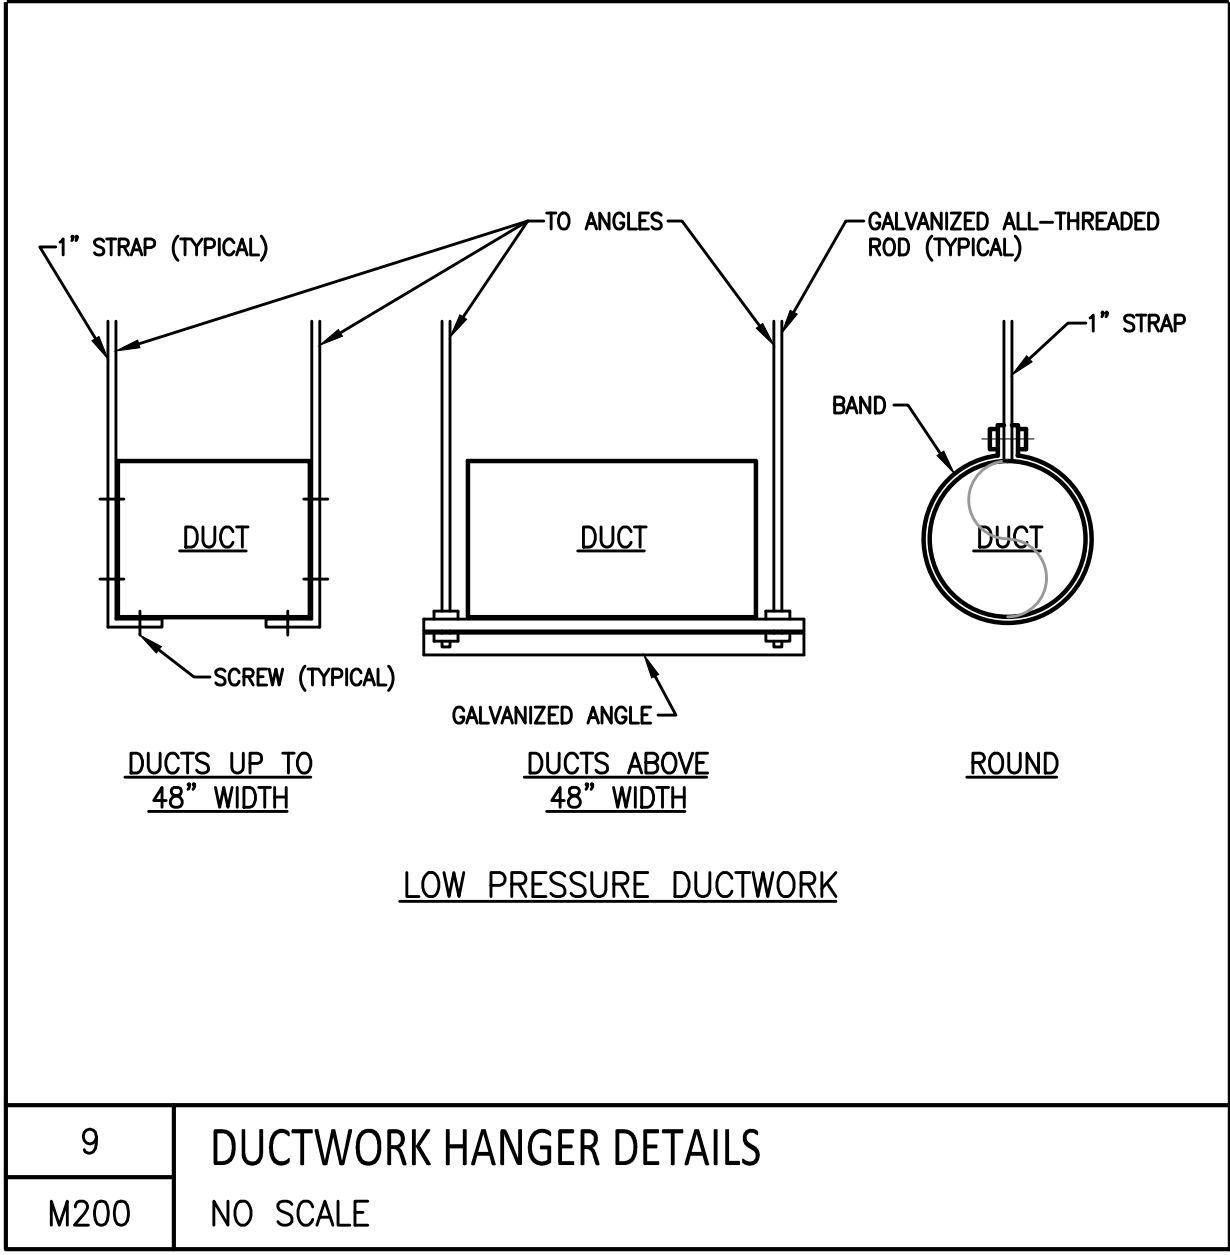


9 DUCTWORK HANGER DETAILS
M200 NO SCALE

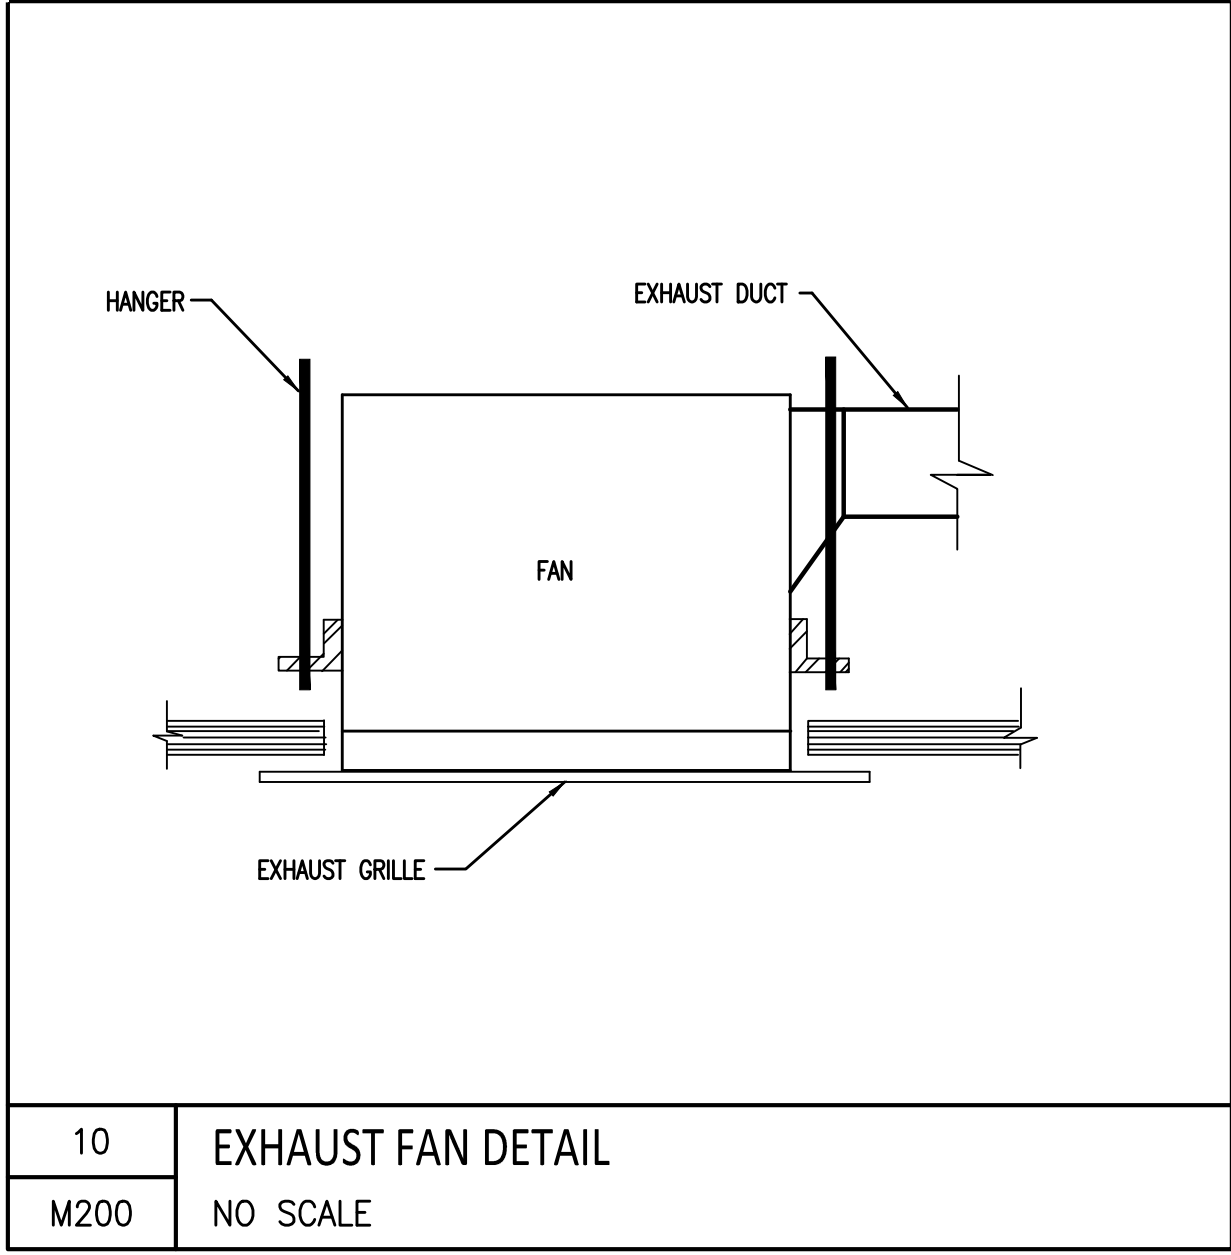

10 EXHAUST FAN DETAIL
M200 NO SCALE

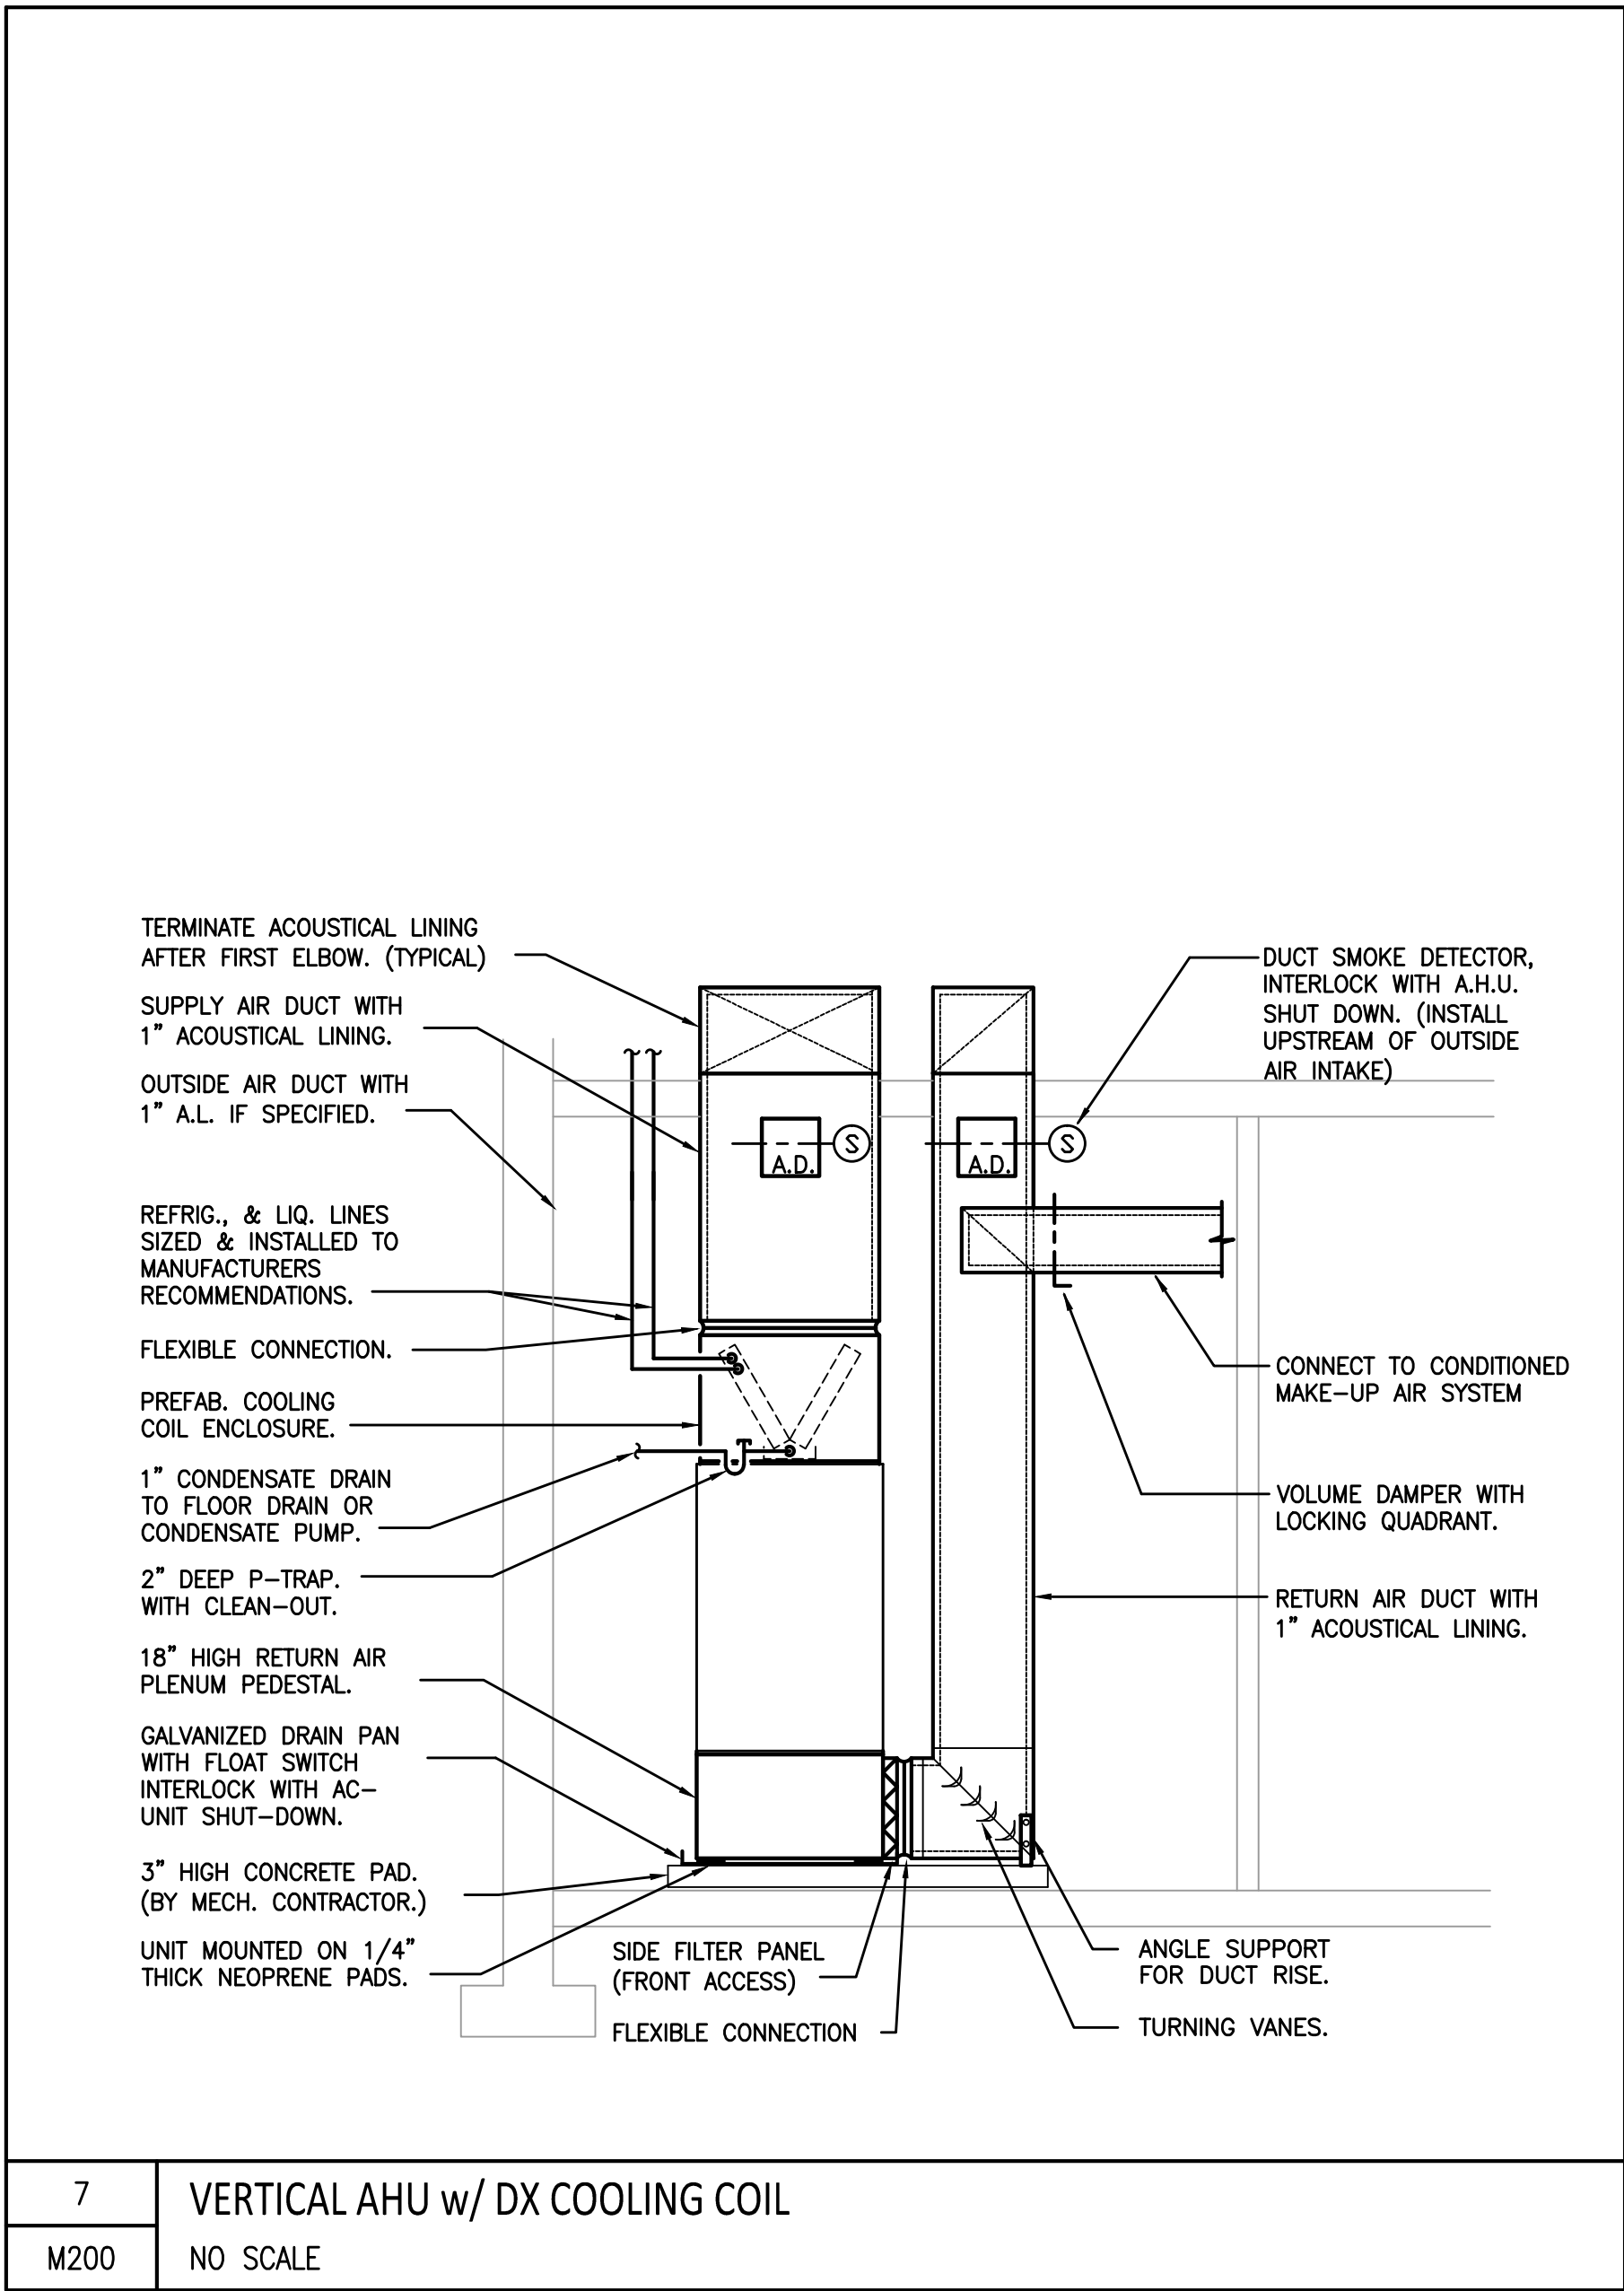


7 VERTICAL AHU w/ DX COOLING COIL
M200 NO SCALE

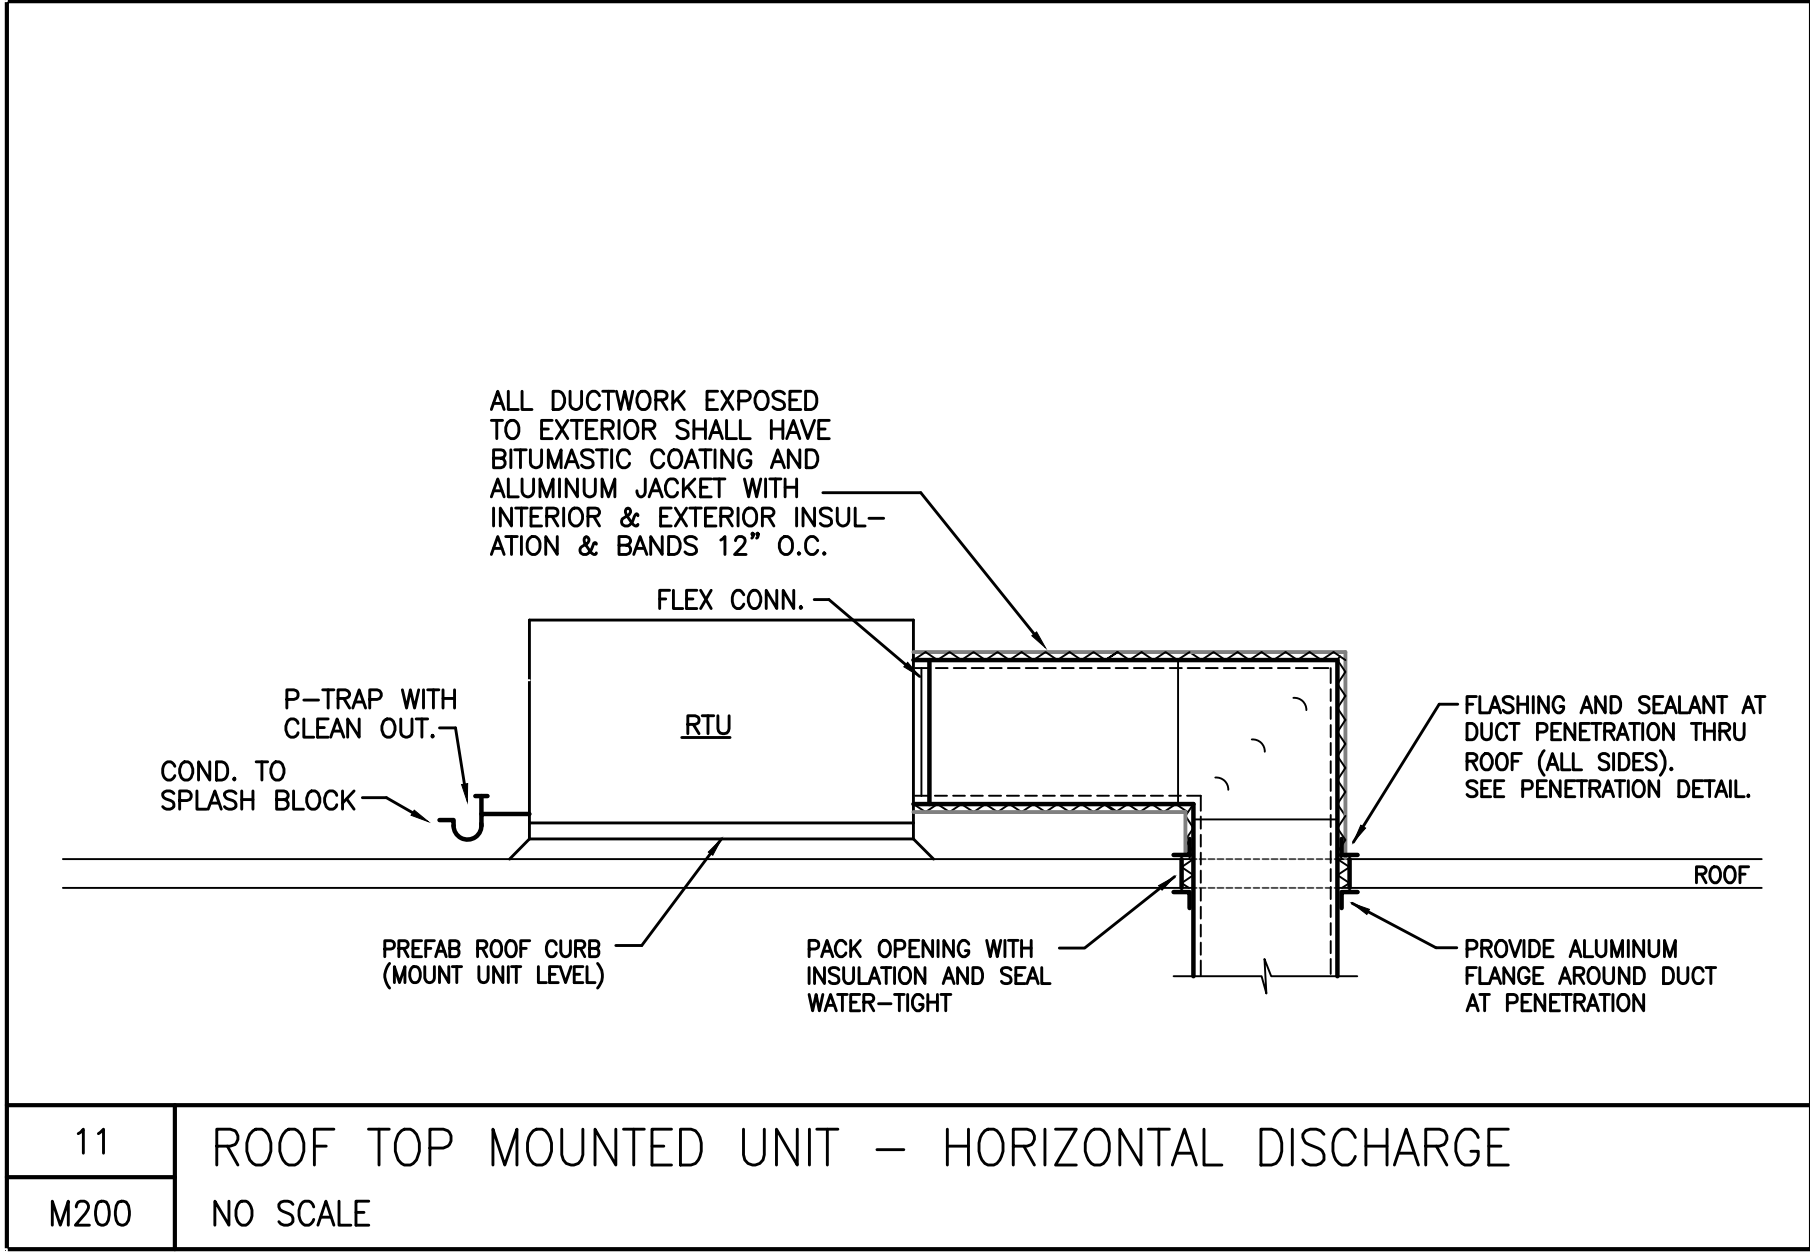

11 ROOF TOP MOUNTED UNIT - HORIZONTAL DISCHARGE
M200 NO SCALE

REVISIONS		
No.	Date	Description

Information contained on this drawing and in all digital files associated is authorized for use on the project named herein only and is the property of MISHRA ARCHITECTURE PLLC and may not be reproduced in any manner without express written or verbal permission from authorized individuals. Original drawing is 24"x36" and scales are as indicated. © 2011 MISHRA ARCHITECTURE PLLC

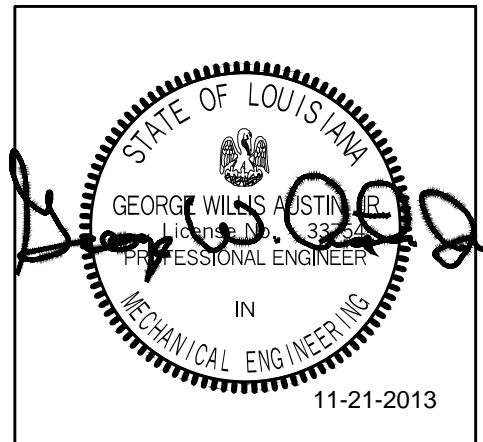

KEY PLAN

Southern Hospitality
Services

Hampton Inn and
Suites

5400 I-20 & Frontage Rd.
Monroe, LA 71201

Drawing Title
Mechanical HVAC
Details

Phase
FOR CONSTRUCTION

Project No.	12-111	Sheet No.	M200
Prepared by	CDC		
Checked by	GWA		
Date	September 16, 2013		

Released for

Hampton Inn and Suites