



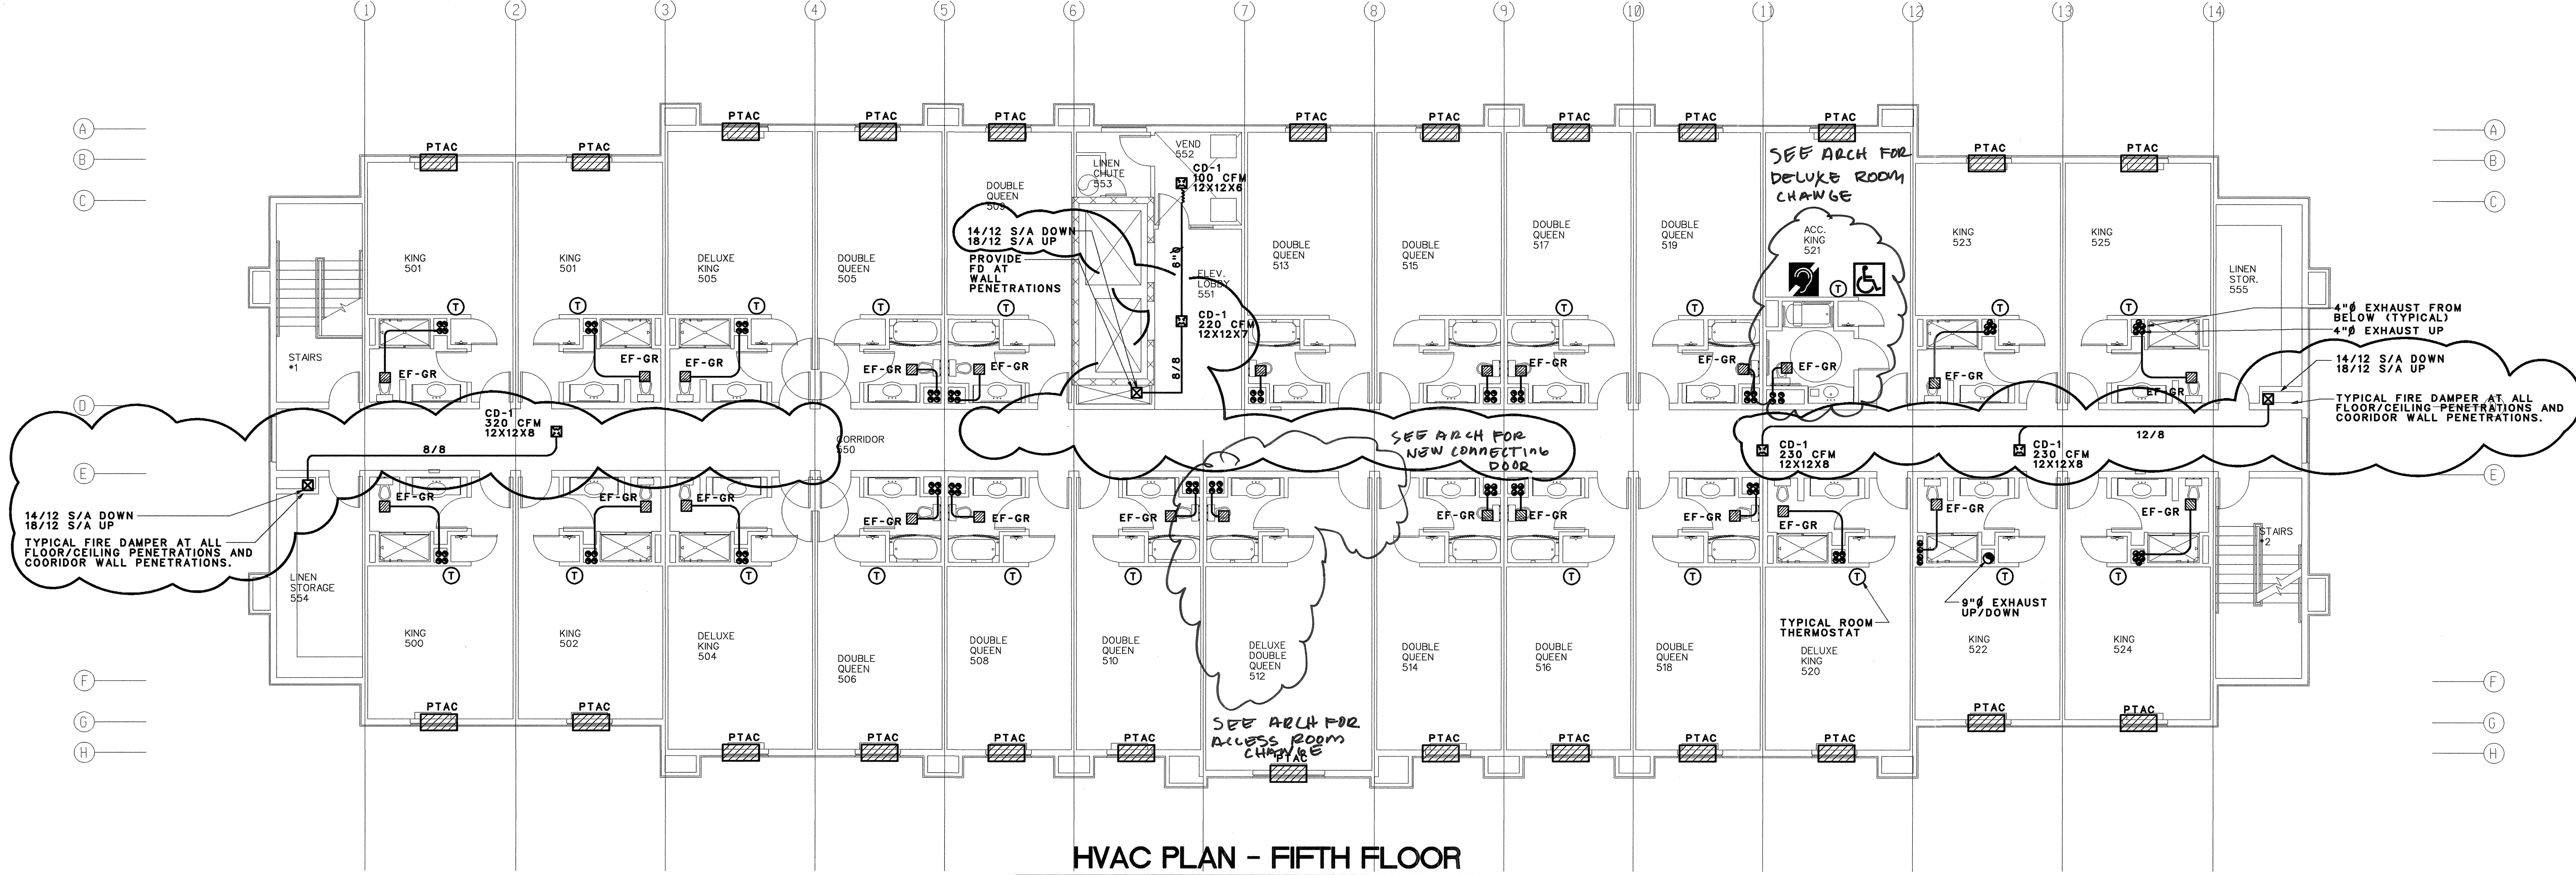


HVAC PLAN - FIFTH FLOOR

SCALE: 1/4" = 1'-0"

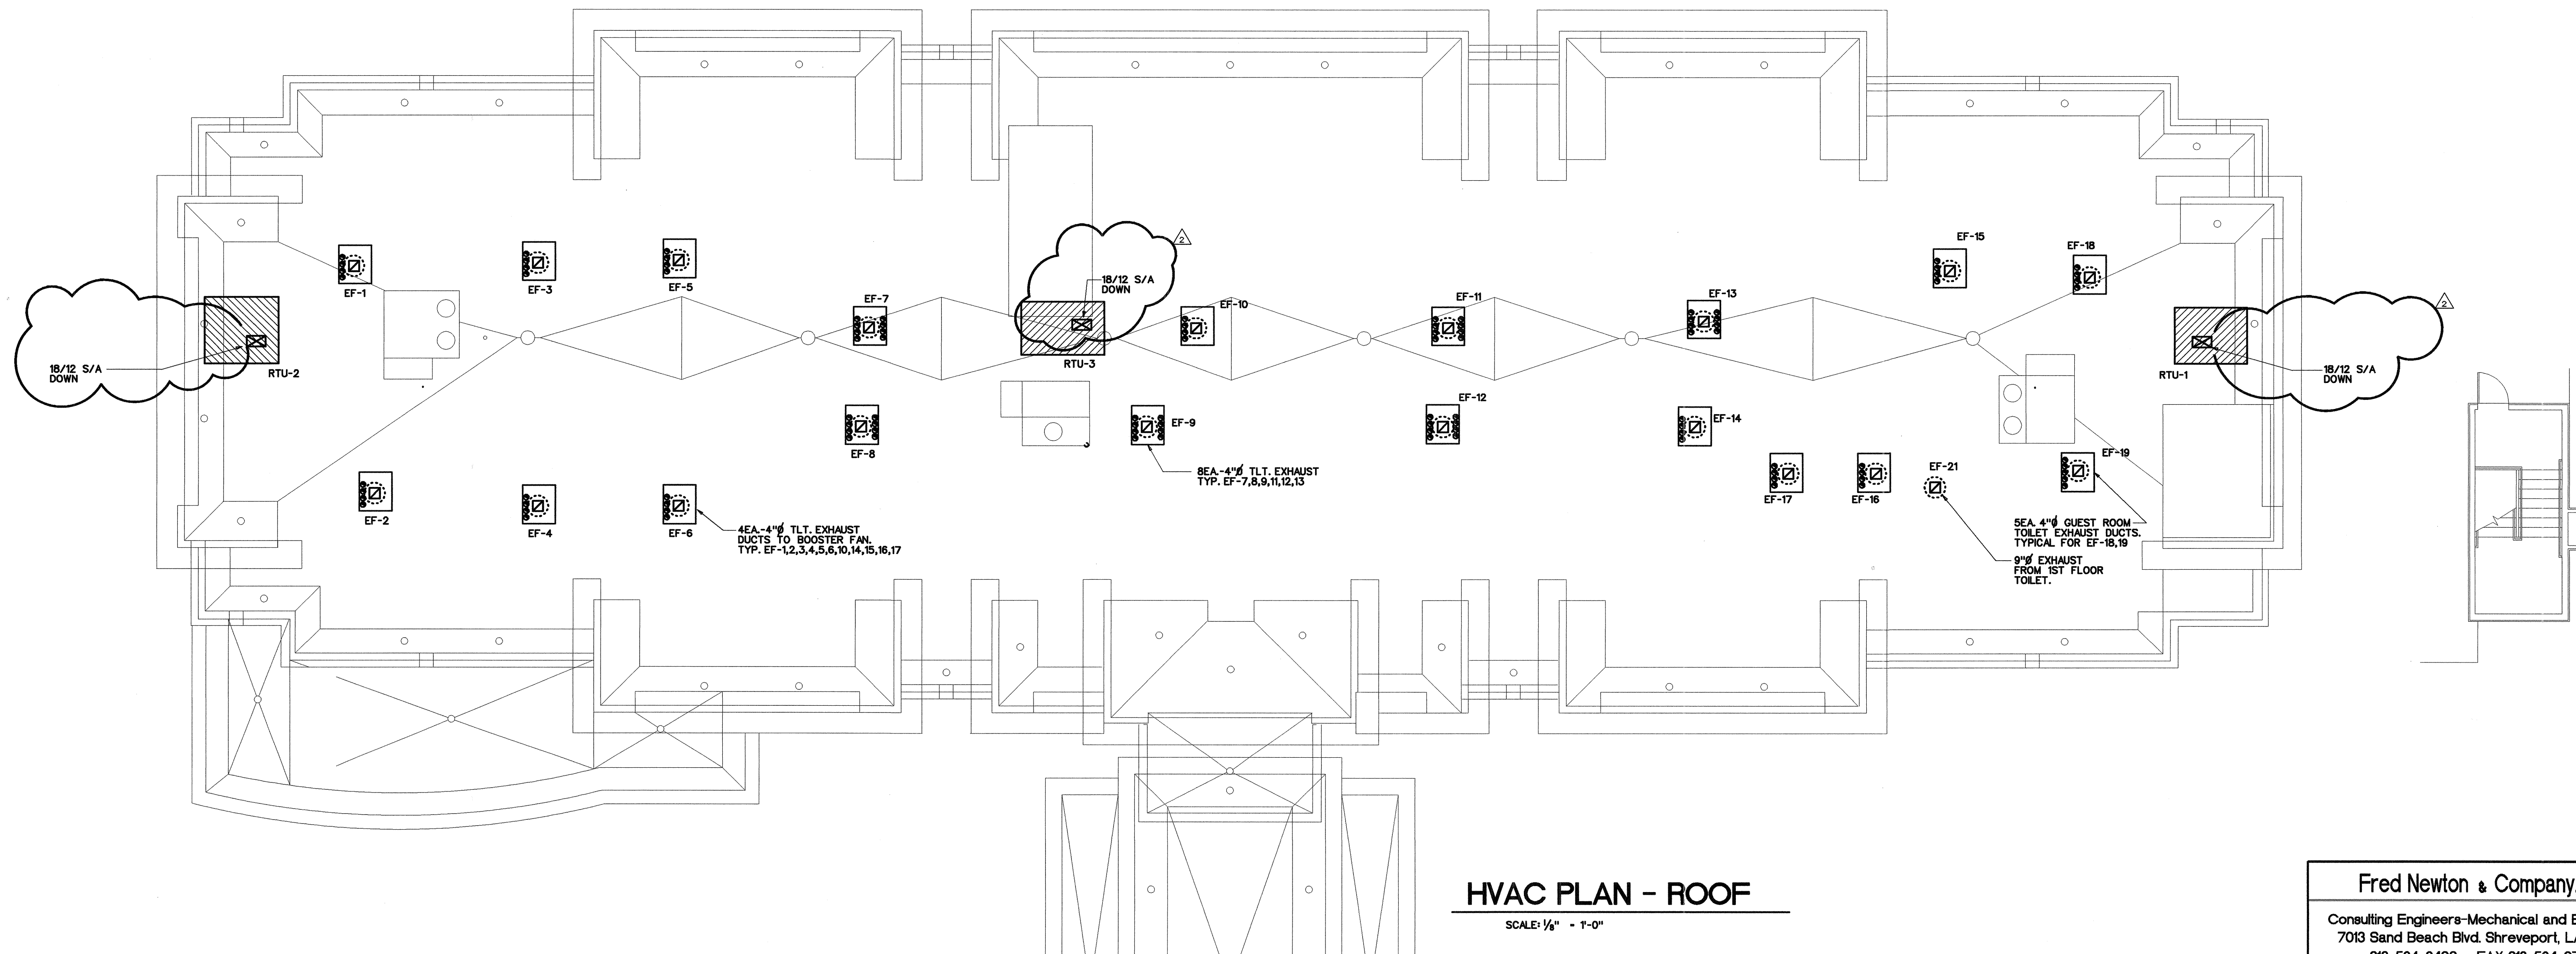

HVAC PLAN - ROOF

SCALE: 1/4" = 1'-0"

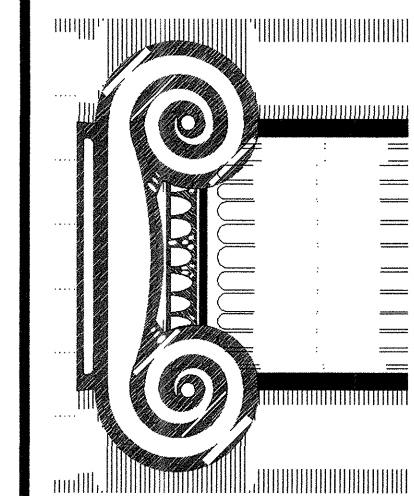

DRAWN:
APPROVED:

DATE COMMENTS
REVISIONS

JOB:
DATE:

Hampton Inn
98 UNITS
FLOWOOD, MS

Fred Newton & Company, Inc.
Consulting Engineers-Mechanical and Electrical
7013 Sand Beach Blvd. Shreveport, LA 71105
318-524-2400 FAX 318-524-0700

SHEET
M4.0