



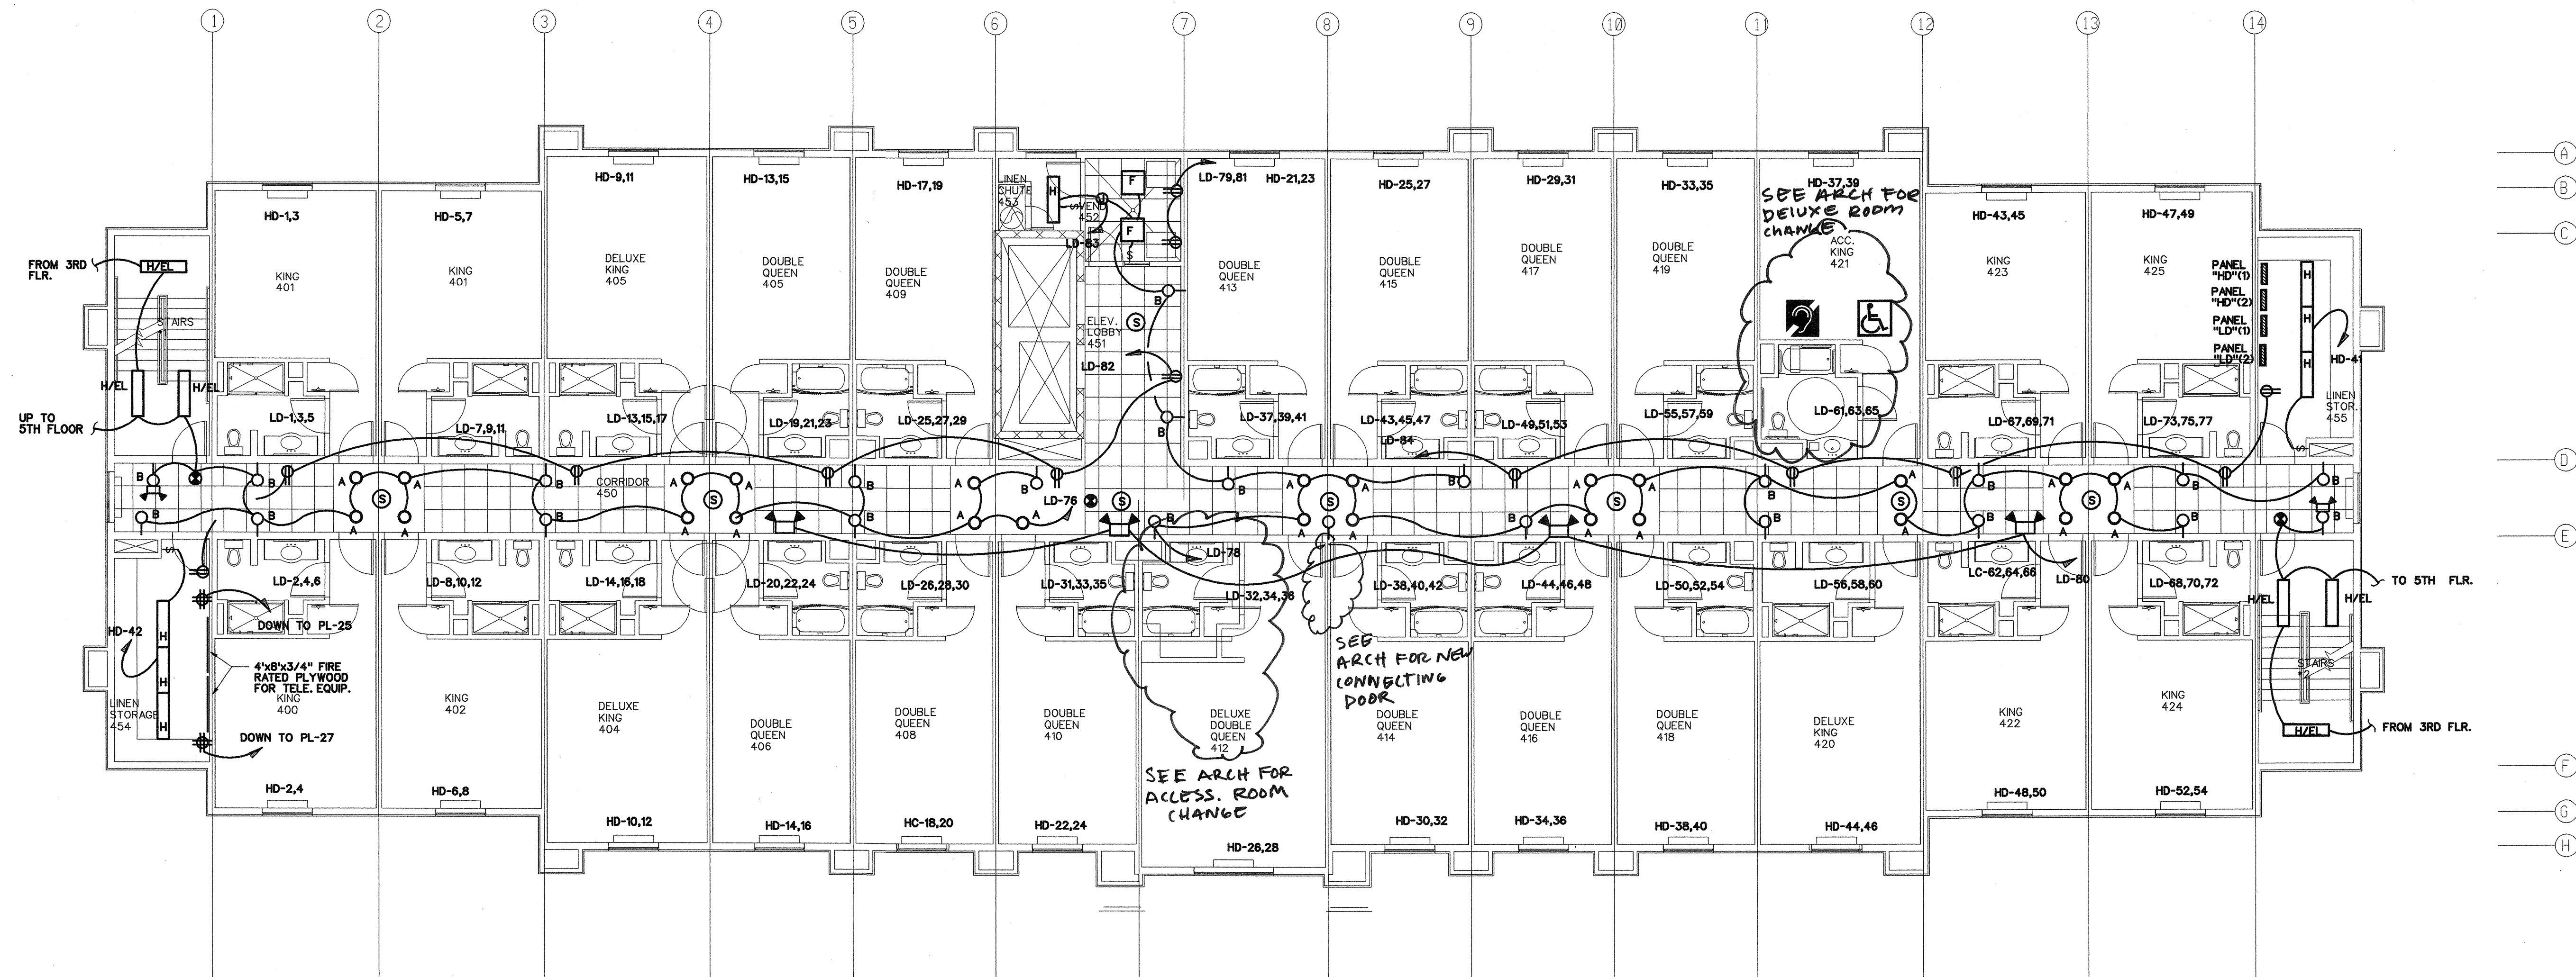

ELECTRICAL PLAN - FOURTH FLOOR


SCALE: 1/8" = 1'-0"

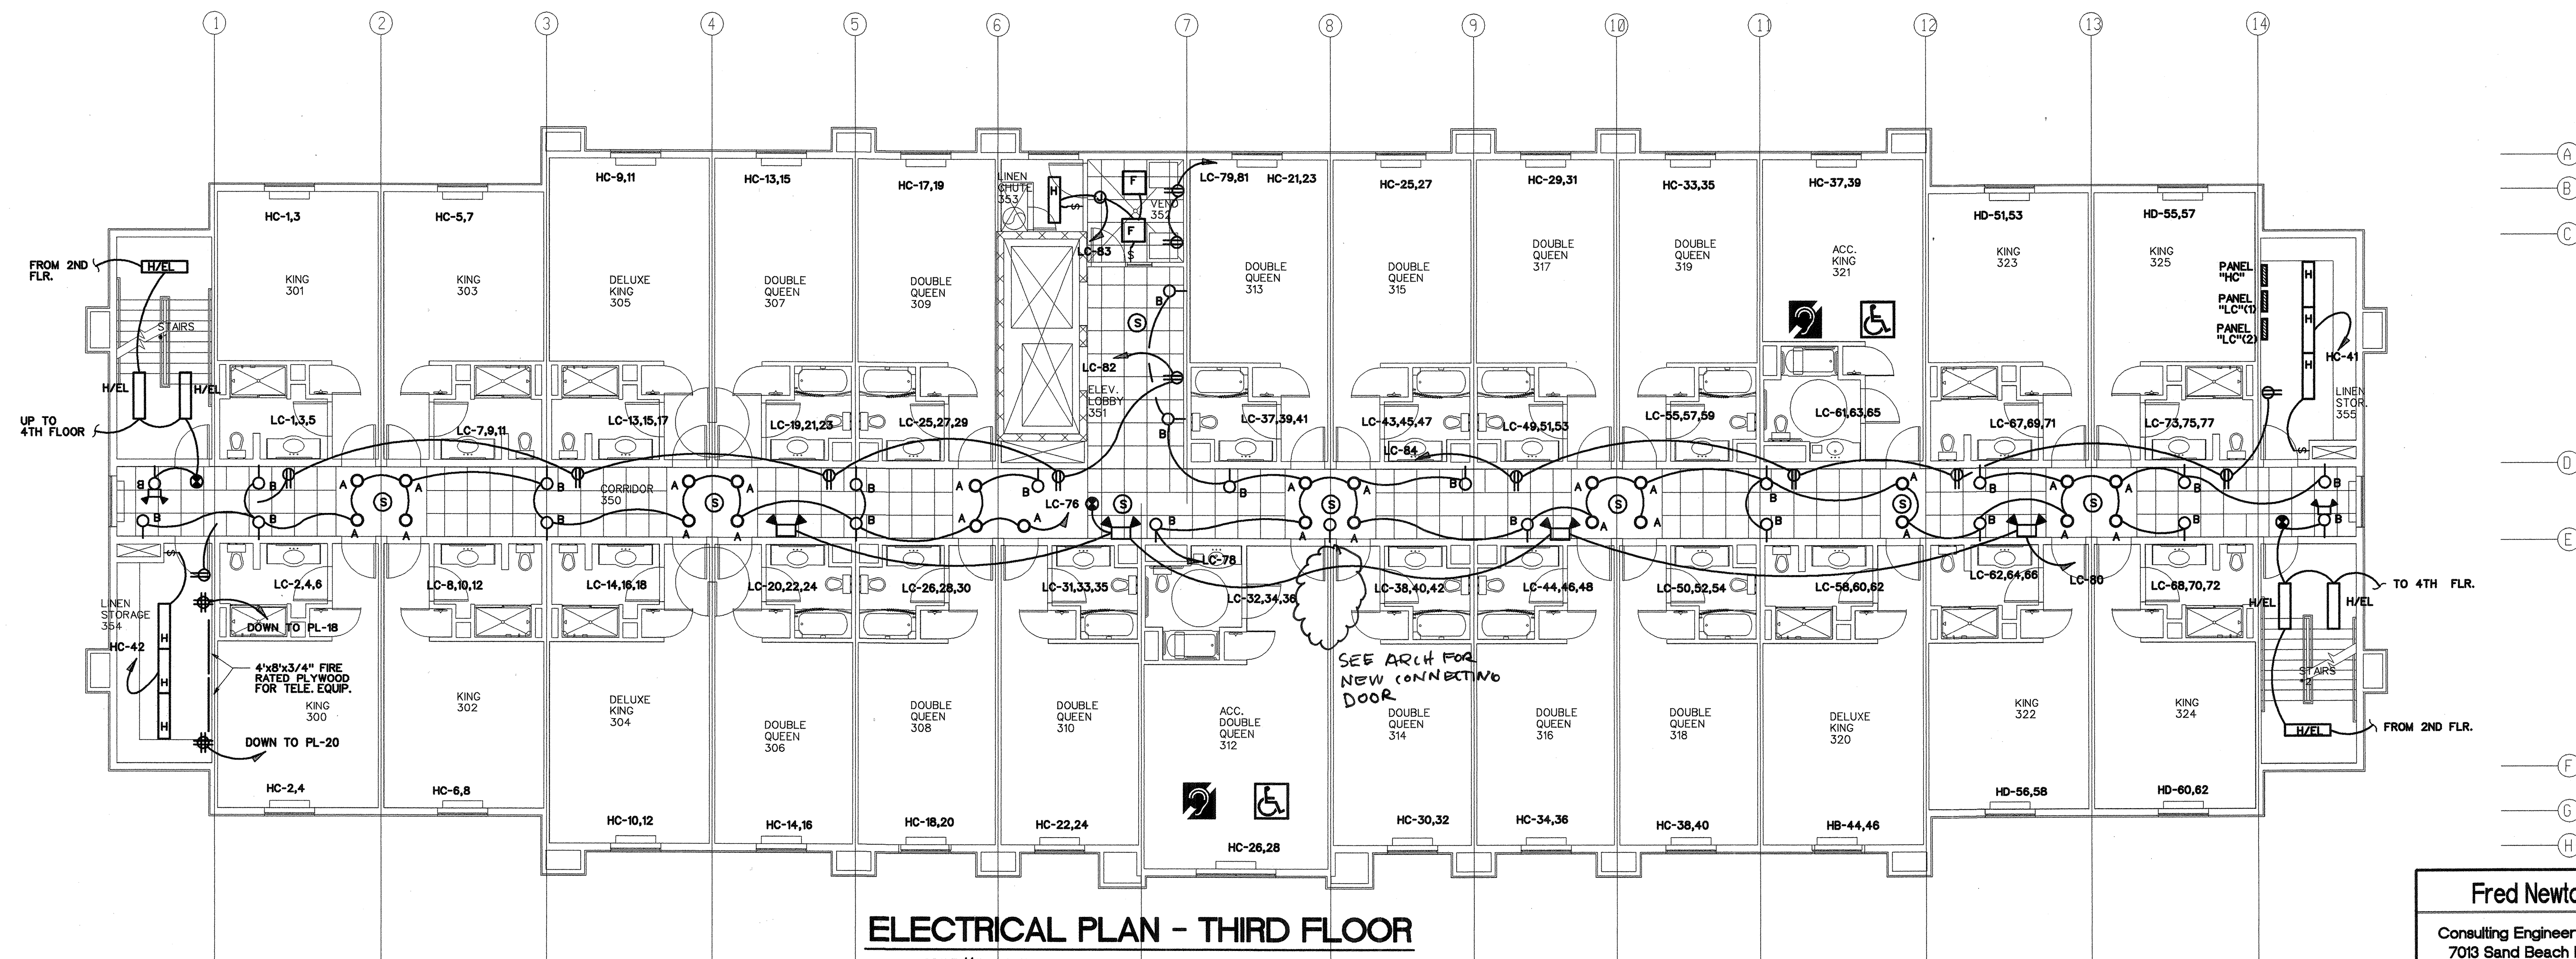

ELECTRICAL PLAN - THIRD FLOOR

SCALE: 1/8" = 1'-0"

RICHARD F. STELL
ARCHITECT
(262) 502-4500
N85 W16058 APPLETON AVE., MENOMONEE FALLS, WI 53051

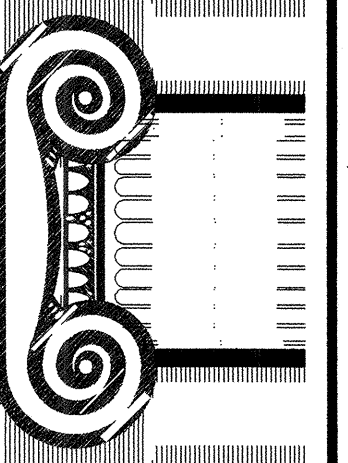

DRAWN:

APPROVED:

2-29-08 No CHANGE

DATE COMMENTS

REVISIONS

JOB:

DATE: 12-07-07

Hampton Inn.
98 UNITS
FLOWOOD, MS

Fred Newton & Company, Inc.

Consulting Engineers-Mechanical and Electrical
7013 Sand Beach Blvd. Shreveport, LA 71105
318-524-2400 FAX 318-524-0700

SHEET

E4.0