




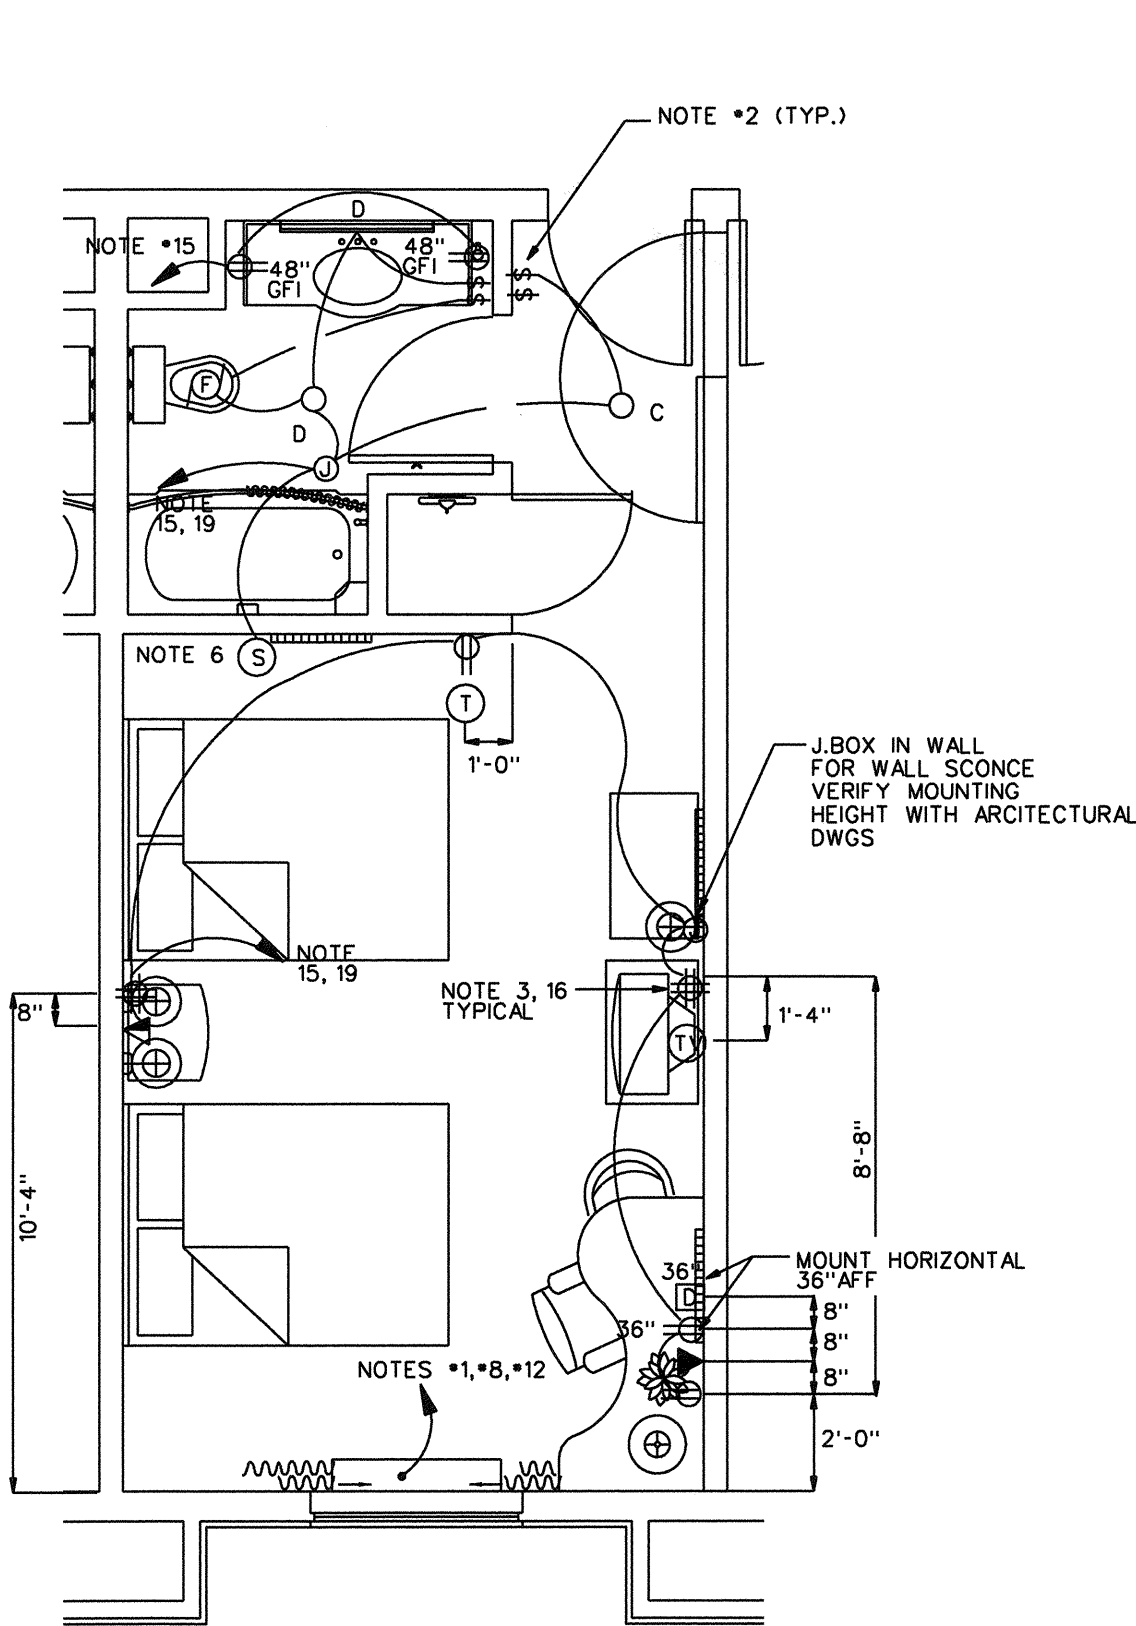


TYP. DOUBLE QUEEN
SCALE: 1/4" = 1'-0"

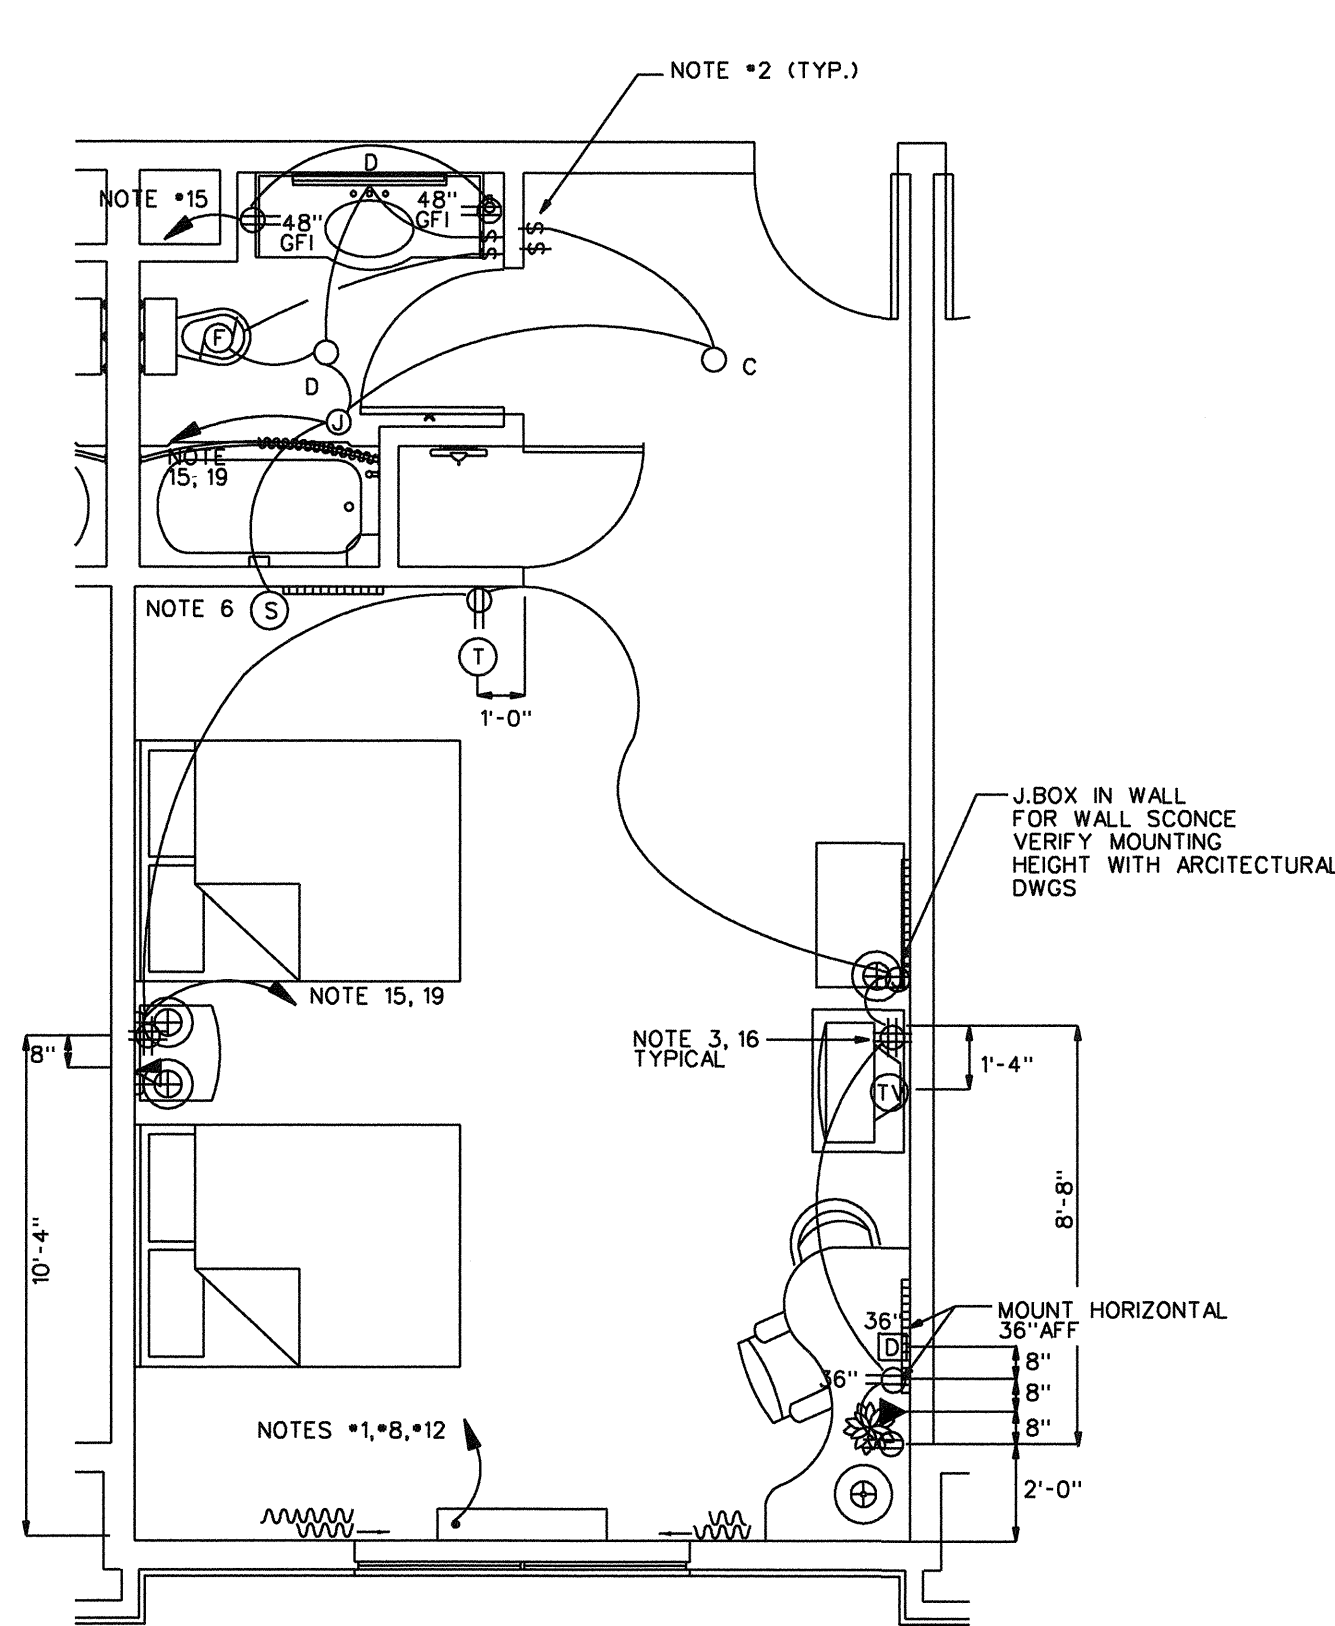


DELUXE DOUBLE QUEEN
SCALE: 1/4" = 1'-0"

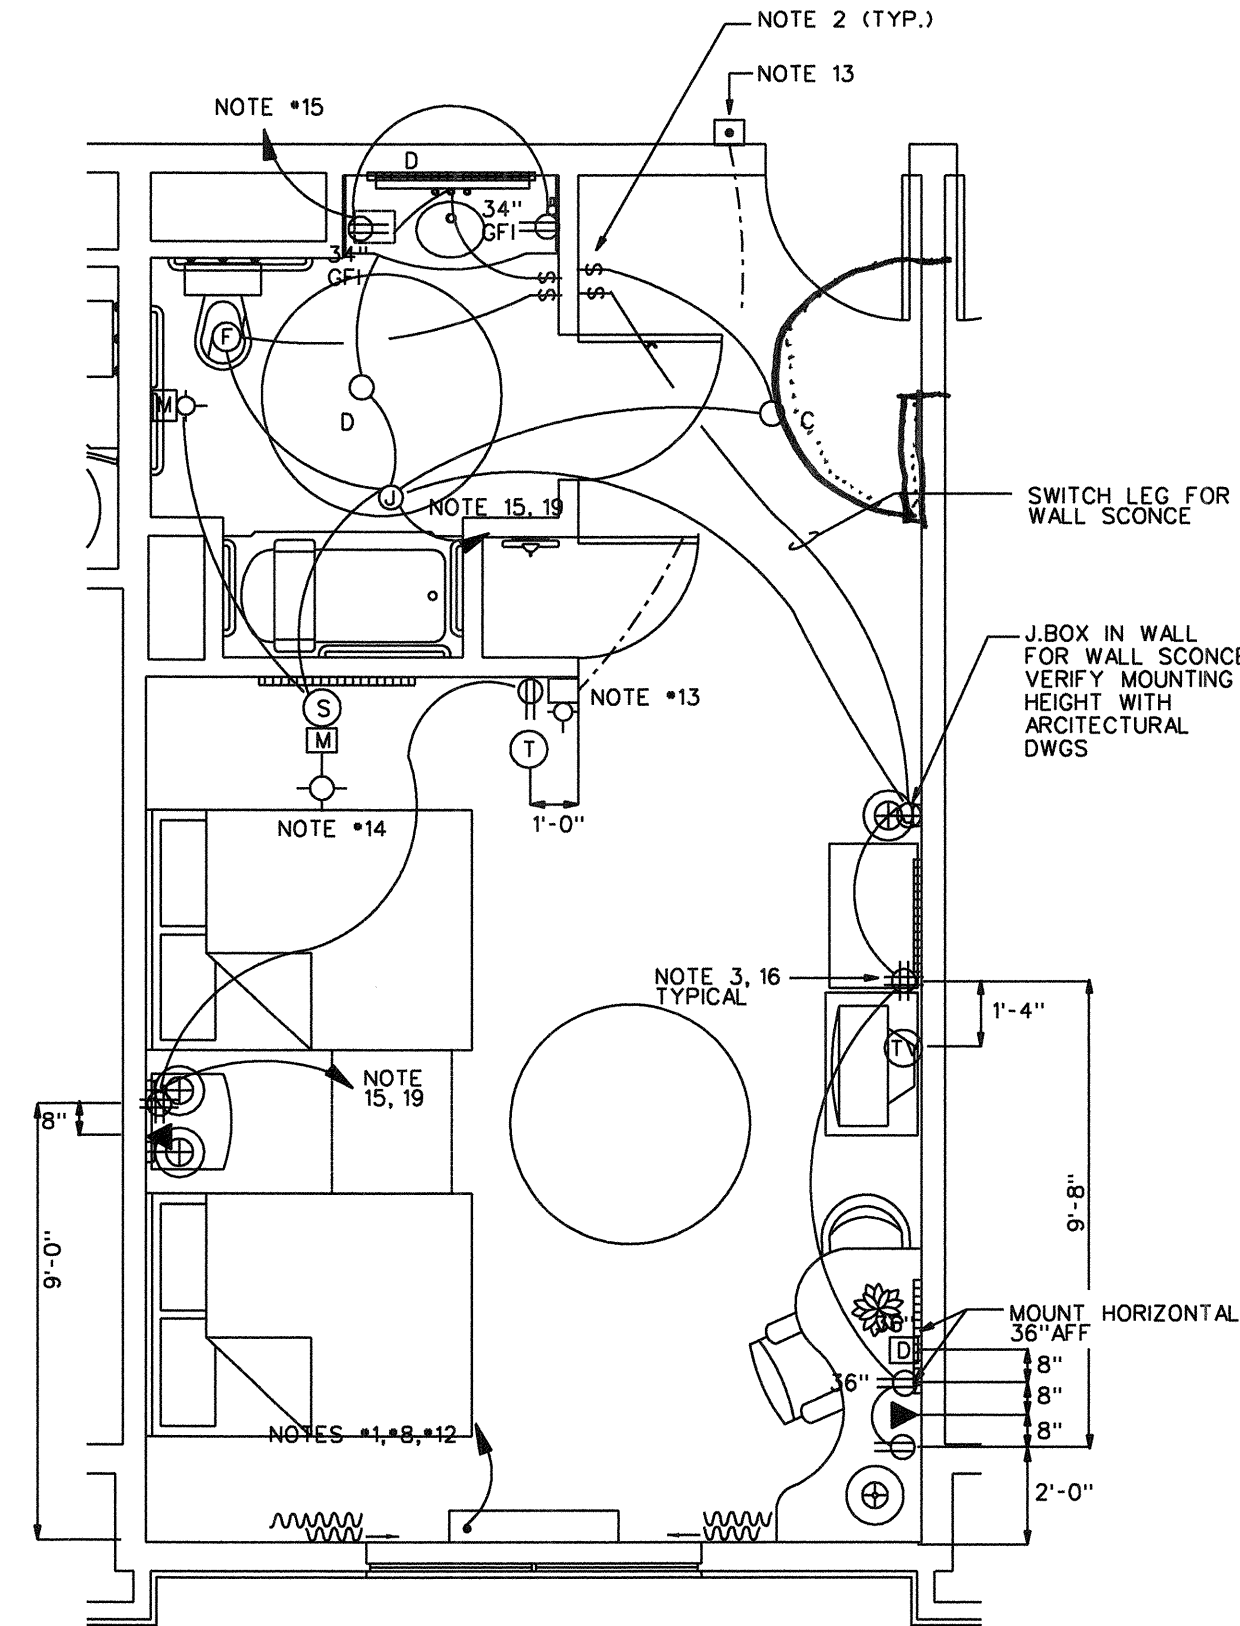


ACCESSIBLE DOUBLE QUEEN
SCALE: 1/4" = 1'-0"

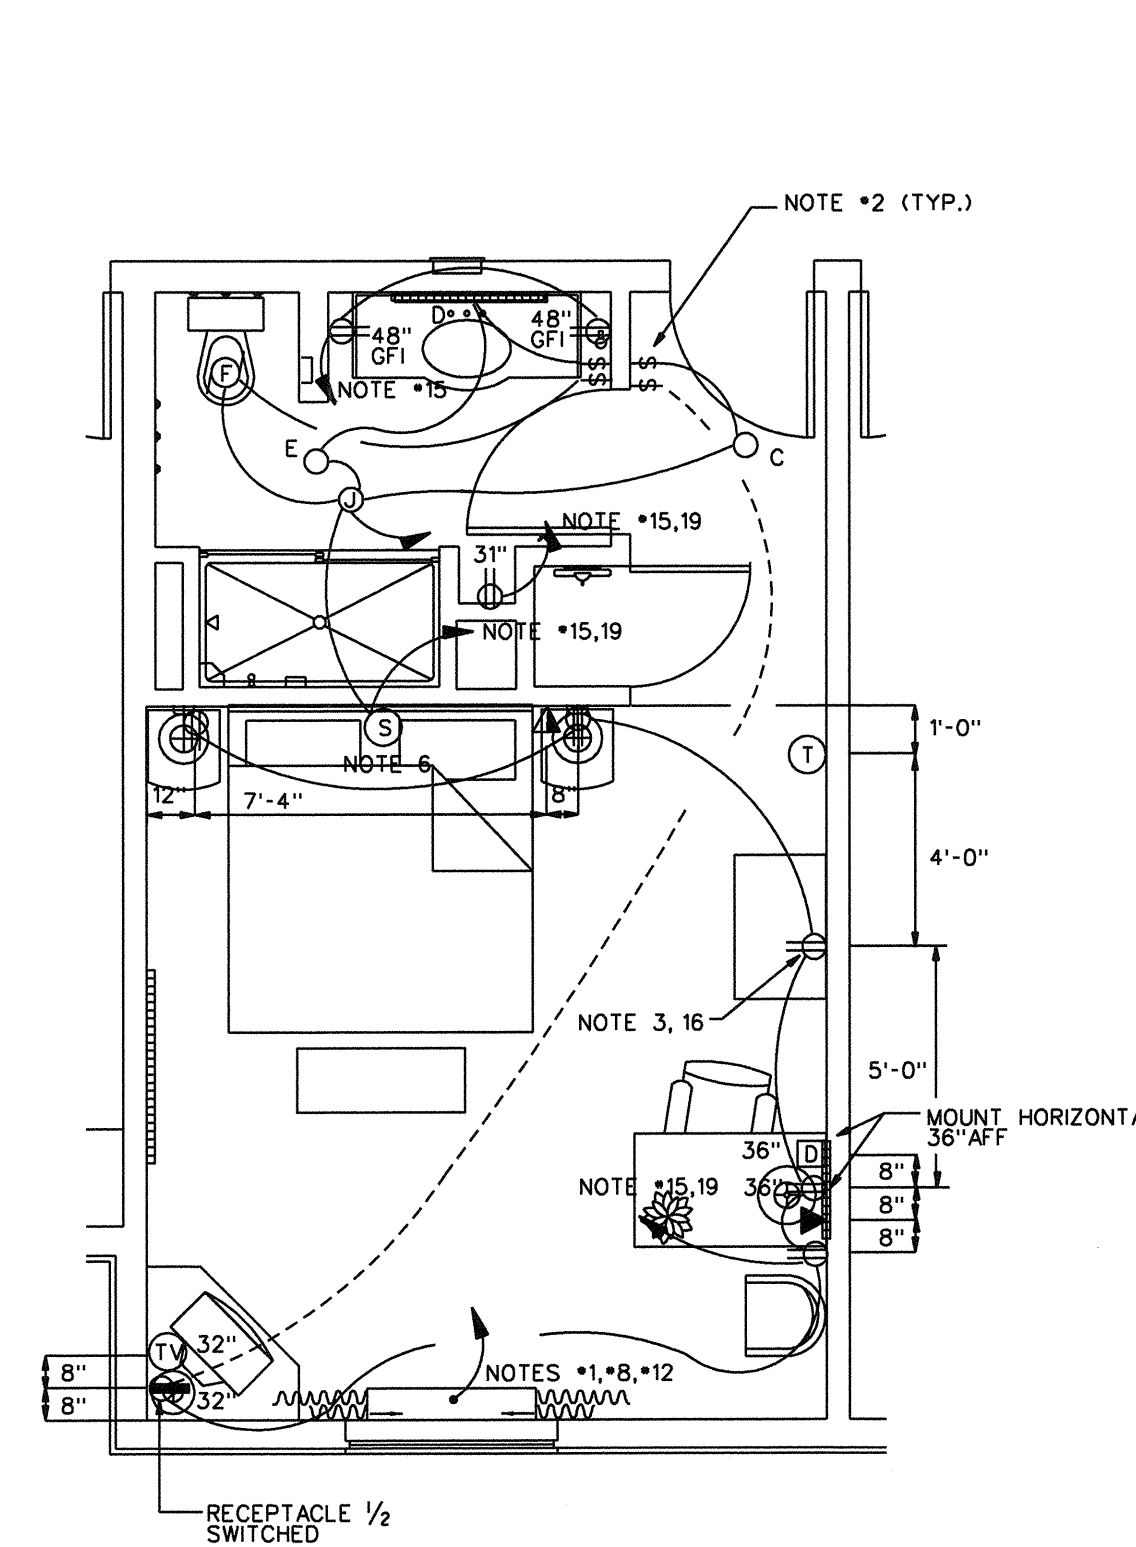

TYP. KING
SCALE: 1/4" = 1'-0"

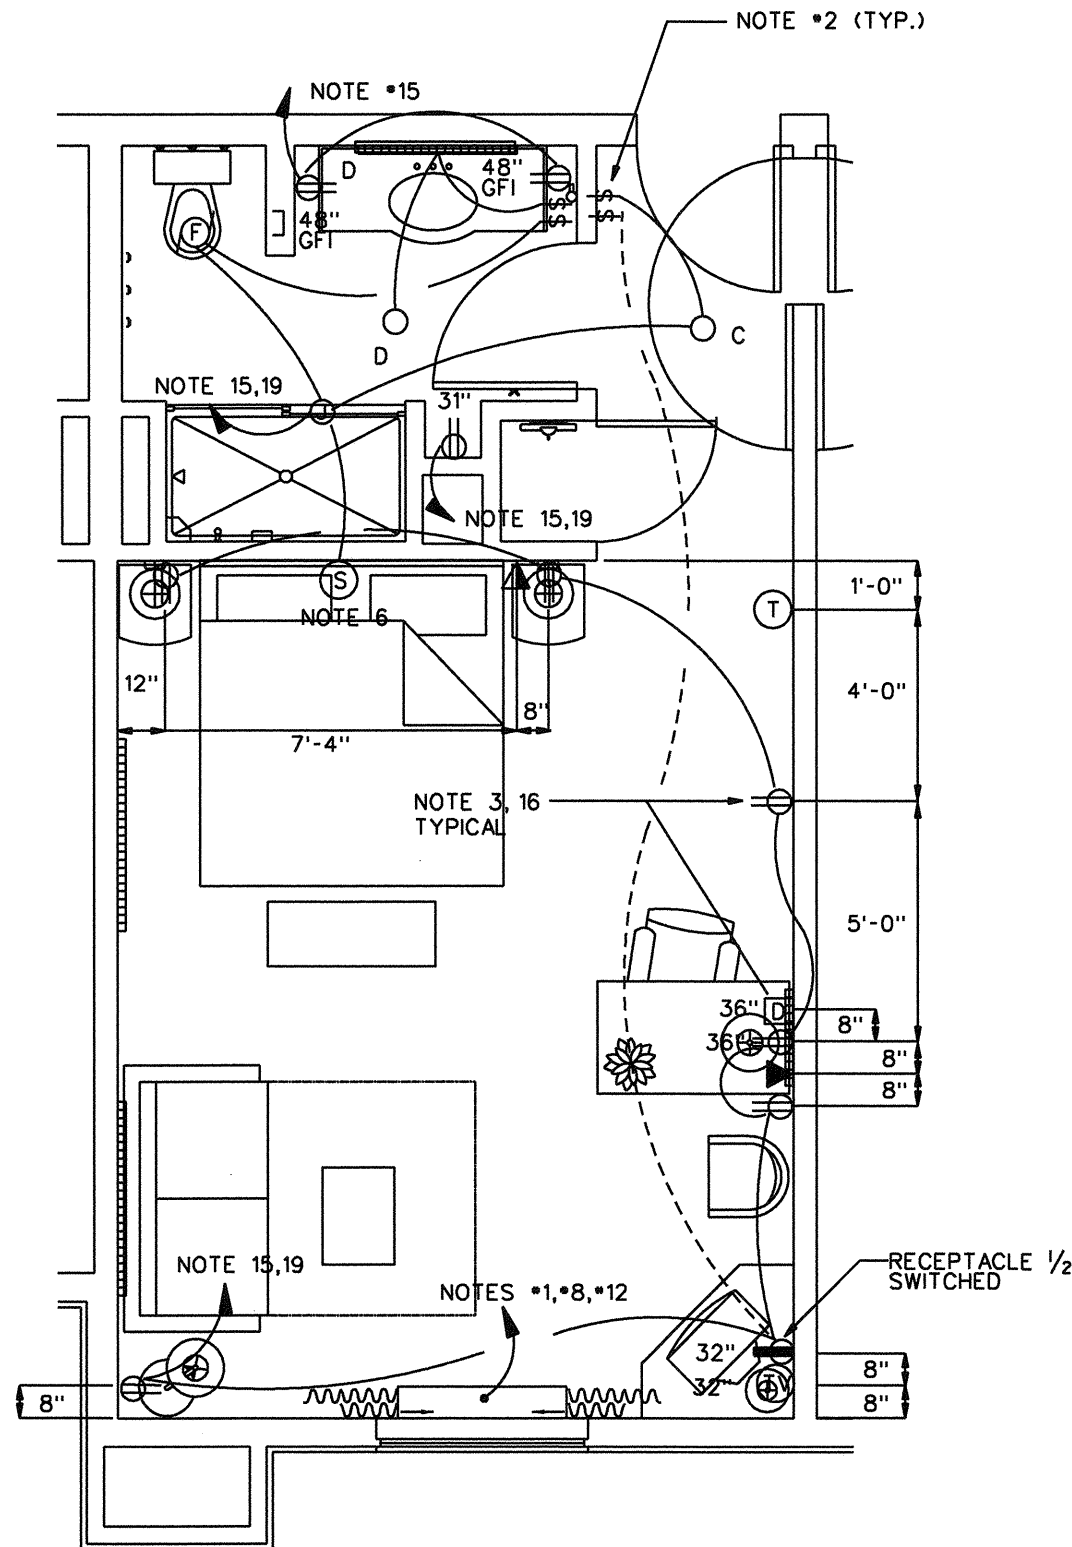

DELUXE KING
SCALE: 1/4" = 1'-0"

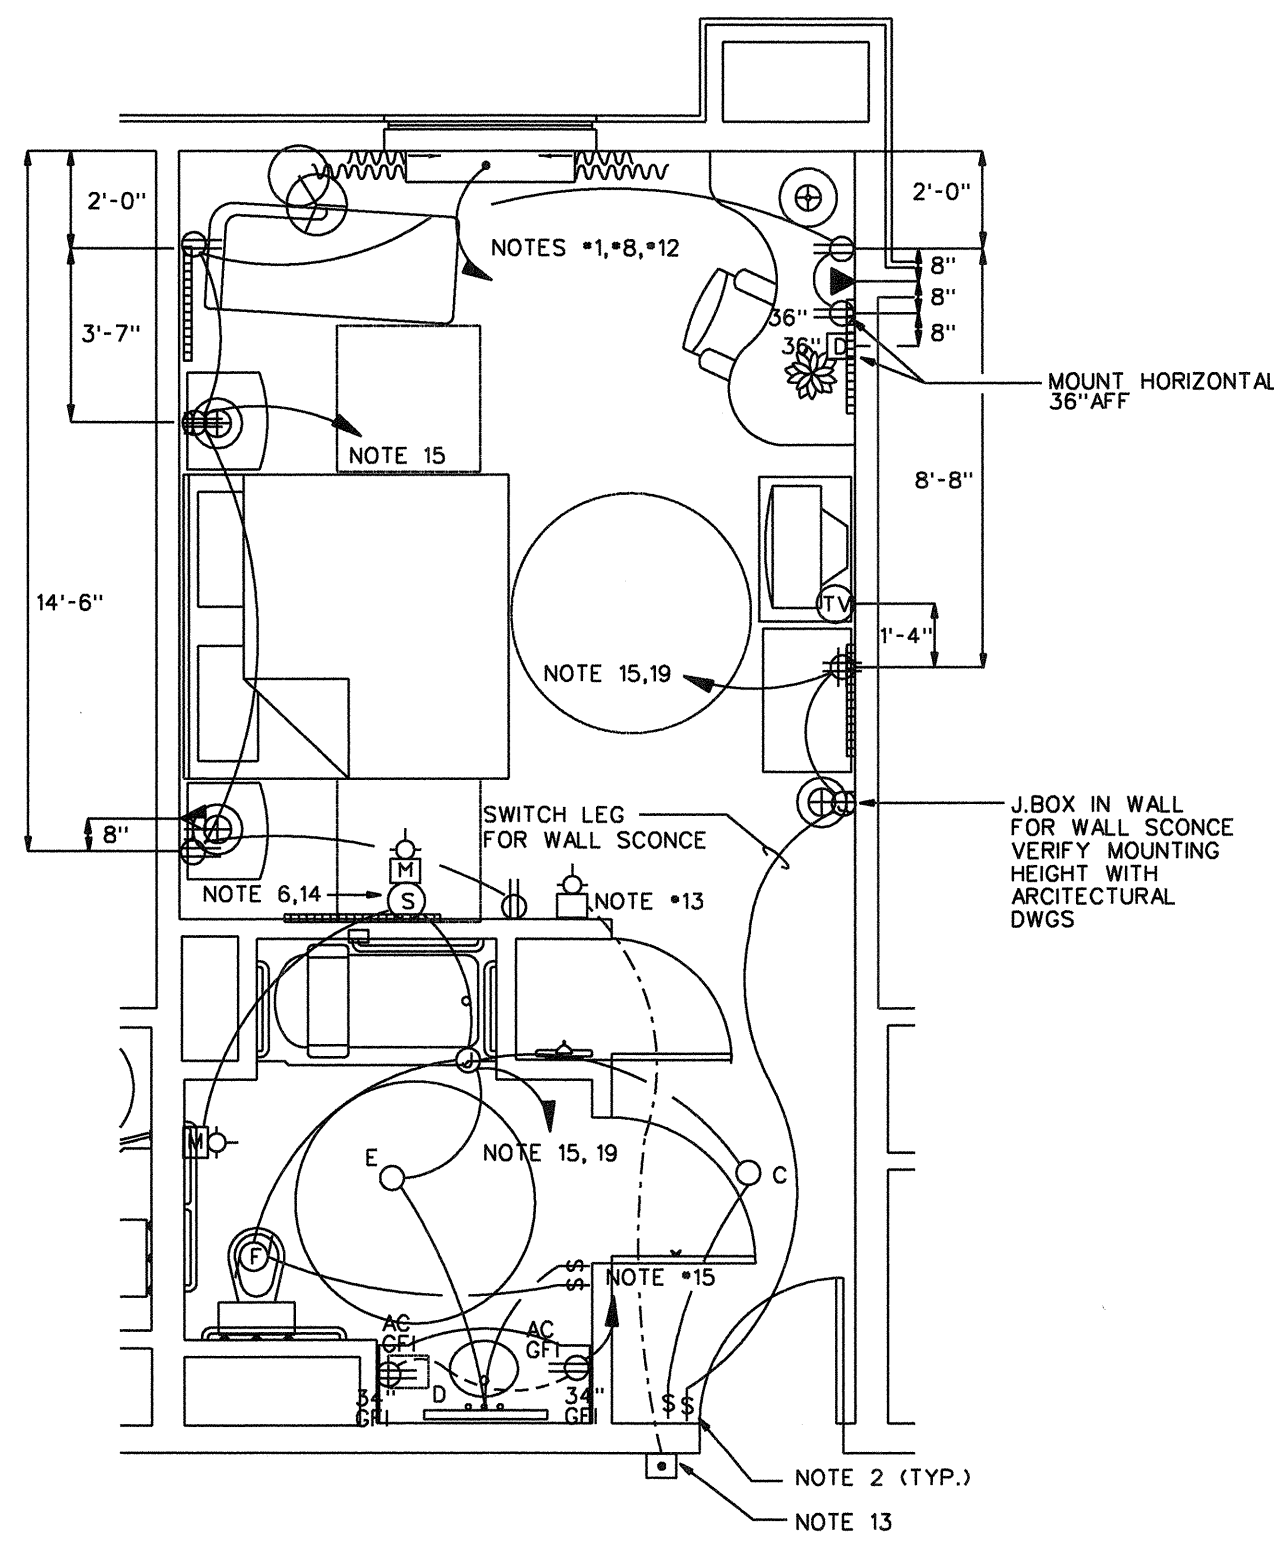


ACCESSIBLE KING
SCALE: 1/4" = 1'-0"

LIGHTING FIXTURE SCHEDULE								
TYPE	NOTES	MFG'R	CATALOG NUMBER	LAMPS		VOLTS	MOUNTING	REMARKS
				QTY.	W & TYPE			
A		LITHONIA	LF62/130TT 120 GEB10	2	13W TT	120V	RECESS	FLUORESCENT DOWNLIGHT IN GUESTRM CORRIDOR
B		LITHONIA	11908	2	13W TT	120V	WALL	DECORATIVE WALL MTD FLUORESCENT FIX. IN COR.
C		LITHONIA	LF8F802 2/180TT 120 GEB10	2	26W DTT	120V	RECESS	FLUORESCENT DOWNLIGHT IN GUESTRM ENTRY
D		LITHONIA	11936	2	32W T8	120V	WALL MT ABV MIRROR	48" WALL MTD FLUOR. FIXTURE MOUNTED ON WALL ABV GUEST BATHRM MIRROR
D1		LITHONIA	11934	2	17W T8	120V	WALL MT ABV MIRROR	24" WALL MTD FLUORESCENT FIXTURE MOUNTED ON WALL ABOVE GUESTRM MIRROR
E		LITHONIA	LF6 F6LD1 PF GEB10	2	26W DTT	120V	RECESS	FLUORESCENT DOWNLIGHT IN GUESTRM BATH
F		LITHONIA	2SP G 2 U31 FW A12 120 GEB10IS	3	32W T8	120V	RECESS	2X2 LAY-IN FLUORESCENT TROFFER
G		PROGRESS	P7116-60EB	2	34W T12	120V	SURFACE	WALL MOUNTED IN STAIRWELL
H		LITHONIA	SB 232 120 GEB10RS	2	32W T8	120V	SURFACE	WRAP AROUND SURFACE MOUNTED FLUORESCENT
K		LITHONIA	2SP G 2 U31 FW A12 120 GEB10IS	2	U31 T8	120V	RECESS	2X2 LAY-IN FLUORESCENT TROFFER
L		LITHONIA	LC6 6E1	1	75W PAR 30	120V	RECESS	DIRECTIONAL EYEBALL
M		LITHONIA	L133B1	1	50W R20	120V	RECESS	DOWNLIGHT-REGISTRATION DESK
N		STONCO	VWXLGC	1	100W R19	120V	WALL	INCANDESCENT VAPORTITE IN ELEVATOR PIT
P		BY OWNER	BY OWNER	N/A	200W MAX	120V	WALL ABOVE MIRROR	PUBLIC BATHROOM-SELECTED BY OWNER ALLOW \$75.00
R		LITHONIA	LP6 6LD1 PF	1	60W A19	120V	RECESS	GESTROOM BATH-SHOWER LIGHT
S		BY OWNER	BY OWNER	N/A	300W MAX	120V	PENDANT	DECORATIVE CEILING FAN- SELECTED BY OWNER ALLOW \$250.00
T		LITHONIA	LAH 175M 125W 173 120	1	175W MH	120V	RECESS	ENCLOSED POOL AREA
U		FIXTURE BY OWNER	BY OWNER	N/A	N/A	N/A	N/A	PENDANT DOWNLIGHT
V		LITHONIA	UC 42 OP 120 LPWW	2	13W T5	120V	SURFACE	UNDERCABINET LIGHT
W		LITHONIA	FM4711 GL 10 WH	2	13W DTT	120V	WALL	WALL MTD FLUORESCENT FIX. MTD ABOVE DOOR ON HEADER IN EQUIP. & STORAGE RMS.
W		LSI	EM-W-120	2	5W	120V	WALL	DUAL HEAD EMERGENCY LIGHT WITH BATTERY BACKUP-MOUNT HIGH AS POSSIBLE
X		LITHONIA	LED-S-W-R-120-UM-ELU	1	5W LED	120V	CLG./WALL	EXIT SIGN
OA		PROGRESS	P5426-60	1	100W A19	120V	POST MTD	POOL AREA LIGHT MOUNT ON METAL POST 8FT. ABOVE FINISHED FLOOR
OB		LITHONIA	KAD400M-R2-TB	1	400W MH	208V	POLE	SINGLE HEAD PARKING AREA LIGHT POLE *SSA 306GDM9
OC		LITHONIA	LAH150M 12FW DOL 120	1	175W MH	120V	RECESS	ENTRANCE CANOPY RECESSED H.I.D.
OD		LITHONIA	TFW 150M R2 TB CRT LPI C22 TFWWG TFWFV TFWTS	1	150W MH	120V	GRD MTD TENON SUPPITER	DRAX BRONZE FINISH H.I.D. FLOODLIGHT-AM TO ILLUMINATE FLAGS
OE		LITHONIA	TFW 400M R8 TB CRT LPI C22 TFWWG TFWFV TFWTS	1	400W MH	120V	GRD MTD TENON SUPPITER	H.I.D. FLOODLIGHT-AM TO ILLUMINATE BUILDING COLUMNS MOUNT ON 1/2" RIGID CONDUIT IN CONCRETE BASE
OF		LITHONIA	WSR 50M MD, 120 WLU TP LPI DDBT	1	50W MH	120V	WALL MTD	EXTERIOR WALL MTD. FIXTURE AT SIDE EXITS MOUNT UP 78"
OG		LITHONIA	VG05 50M GL 120 DDBT LPI	1	50W MH	120V	WALL MTD	FLOOD LIGHT ON ROOF CONTROL WITH MARK-TIME 60 MIN. TIME SWITCH
OH		LITHONIA	2*KAD400M-R2-TB	2	400W MH	208V	POLE	DARK BRONZE FINISH DOUBLE HEAD PARKING AREA LIGHT POLE *SSA 306GDM9
OJ		LITHONIA	AFIN BIN EXT	1	400W MH	120V	WALL MTD	BRUSHED NICKLE FINISH MTD ON EXTERIOR WALL ABOVE DOOR EMERG. EGRESS LIGHT FIXTURE

TYPICAL GUESTROOM ELECTRICAL NOTES:

- THRU-WALL-UNIT - SEE MECHANICAL DWGS. FOR MFG'R & SPECIFICATIONS.
- ALL SWITCHES SHALL BE MOUNTED 48" A.F.F. UNLESS NOTED OTHERWISE.
- PROVIDE FIRE CAULKING, FIRE PUTTY PADS, AS NECESSARY TO COMPLY WITH ALL LOCAL, STATE, AND NATIONAL FIRE CODES.
- ALL TELEPHONE OUTLETS & DUPLEX RECEPTACLES HEIGHTS SHALL BE MOUNTED AT 18" AFF UNLESS OTHERWISE NOTED.
- ALL DUPLEX RECEPTACLES, TELEPHONE OUTLETS, DATA OUTLETS LOCATED INSIDE THE GUESTROOM SHALL BE MTD. UP 18", UNLESS NOTED OTHERWISE.
- 120 V GUESTROOM SMOKE DETECTOR SHALL BE CENTERED ON THE EXTERIOR OF THE BATHROOM WALL AND MTD. DOWN FROM THE CEILING 12" TO THE TOP OF THE DETECTOR.
- ALL GUEST ROOM SMOKE DETECTORS WITH AUDIBLE/VISUAL NOTIFICATION SHALL BE CENTERED ON THE EXTERIOR BATHROOM WALL MOUNTED DOWN FROM THE CEILING 12" TO THE TOP OF THE DETECTOR.
- STUB-UP 208V CIRCUIT BELOW EACH T.W.U. AND MAKE CONNECTION TO OUTLET IN SUB-BASE AS PER MANUFACTURER'S RECOMMENDATIONS.
- 3/4" CONDUIT BETWEEN TELEPHONE/DATA OUTLETS IN WALL AND/OR FLOOR (TYPICAL)
- ALL TELEPHONE CABLE SHALL BE CAT 5E CABLE.
- ALL GFI RECEPTACLES IN THE BATHROOM SHALL BE MTD HORIZONTAL AND AT MOUNTED HEIGHT LISTED.
- CONNECTION TO HVAC UNIT- PROVIDE NECESSARY DISCONNECT MEANS- MAKE CONNECTION PER MANUFACTURER'S RECOMMENDATIONS.
- ACCESSIBLE & HEARING IMPAIRED GUESTROOMS SHALL COMPLY WITH REQUIREMENTS OF THE A.D.A. GUIDELINES MANUAL NAMELY 9.2.2, 9.3, & 4.31.5-- TELEPHONES SHALL HAVE ADJUSTABLE VOLUME CONTROLLER & THE ROOM NOTIFICATION ALARM DEVICE SYSTEM FOR DOOR KNOCK OR BELL EDWARDS *7004 GUESTROOM DOOR ANNUNCIATOR, & FOR INCOMING TELEPHONE CALLS, PROVIDE CUT-OFF SWITCH IN CLOSET FOR GUESTROOM DOOR ANNUNCIATOR.
- PROVIDE VISUAL STROBE ALARMS 120V SMOKE DETECTORS IN ALL HANDICAPPED AND HEARING IMPAIRED ROOMS 120V SMOKE DETECTORS WITH STROBES SHALL SOUND LOCAL ALARM PER LOCAL GUESTROOM ACTIVATION AND GENERAL ALARM NOTIFICATION OF FIRE ALARM SYSTEM.
- 120V HOME-RUN FOR GUESTROOM LIGHTS AND RECEPTACLES, FOR CIRCUITS 100 FT. OR MORE USE #10 COPPER CONDUCTORS.
- THRU-THE-WALL OR BACK TO BACK ELECTRICAL BOXES NOT ALLOWED, STAGGER RECEPTACLE AND TELEPHONE/DATA BOXES 24" APART BETWEEN PARTITIONS WALL STUDS.
- COORDINATE TV, THERMOSTAT, RECEPTACLES AND TELEPHONE OUTLETS WITH FURNITURE LAYOUT.
- ALL GUEST ROOM BRANCH CIRCUITS SHALL BE PROTECTED BY A LISTED ARC-FAULT CIRCUIT INTERRUPTER.

RICHARD F. STELDT
ARCHITECT
(262) 502-4500
N85 W1605B APPLETON AVE., MENOMONEE FALLS, WI 53051

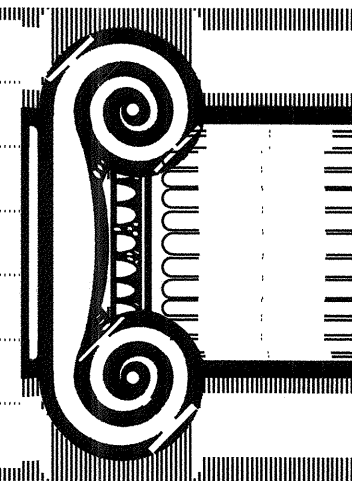

DRAWN:

APPROVED:

2/29/08 REVISED FOR ADDENDUM #1

2/22/08 REVISED PER HAMPTON REVIEW

DATE COMMENTS

REVISIONS

JOB:

DATE:

Hampton Inn®
98 UNITS
FLOWOOD, MS

Fred Newton & Company, Inc.

Consulting Engineers-Mechanical and Electrical
7013 Sand Beach Blvd. Shreveport, LA 71105
318-524-2400 FAX 318-524-0700

SHEET

E6.0