


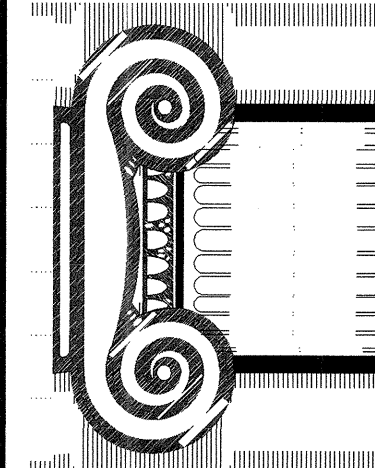

DRAWN:
APPROVED:

5/22/08
REVISED PER HAMPTON REVIEW
DATE COMMENTS
REVISIONS

JOB:
DATE:


Hampton Inn
98 UNITS FLOWOOD, MS

SHEET


P1.0

Fred Newton & Company, Inc.


Consulting Engineers-Mechanical and Electrical
7013 Sand Beach Blvd. Shreveport, LA 71105
318-524-2400 FAX 318-524-0700

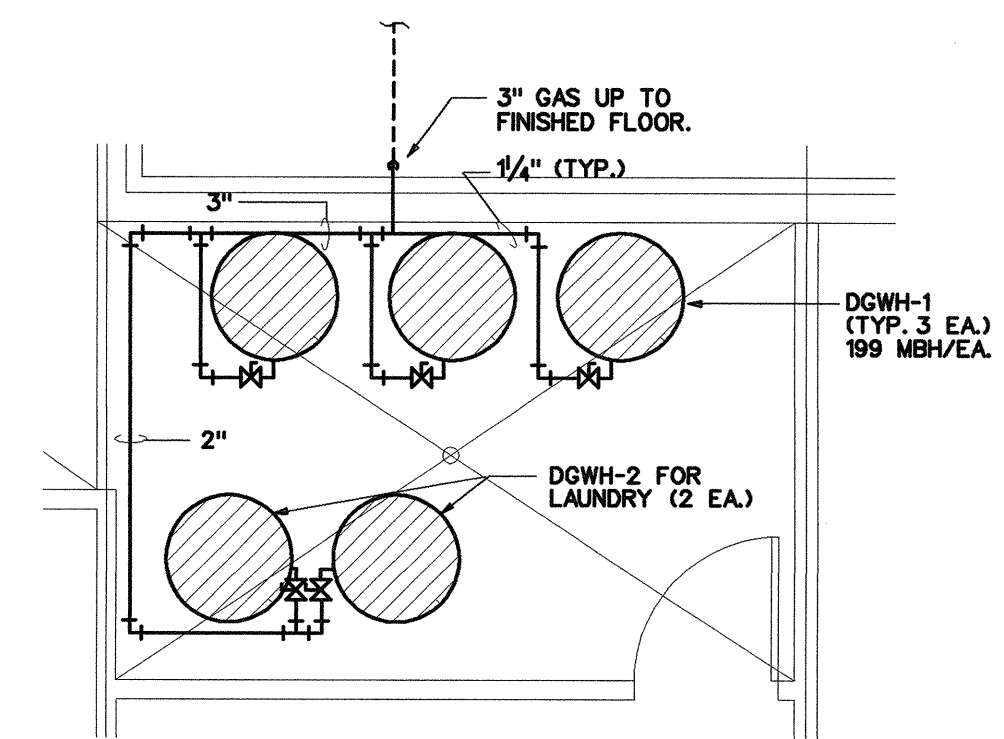

ENLARGED WATER HEATER RM.
SCALE: 1/4"=1'-0"

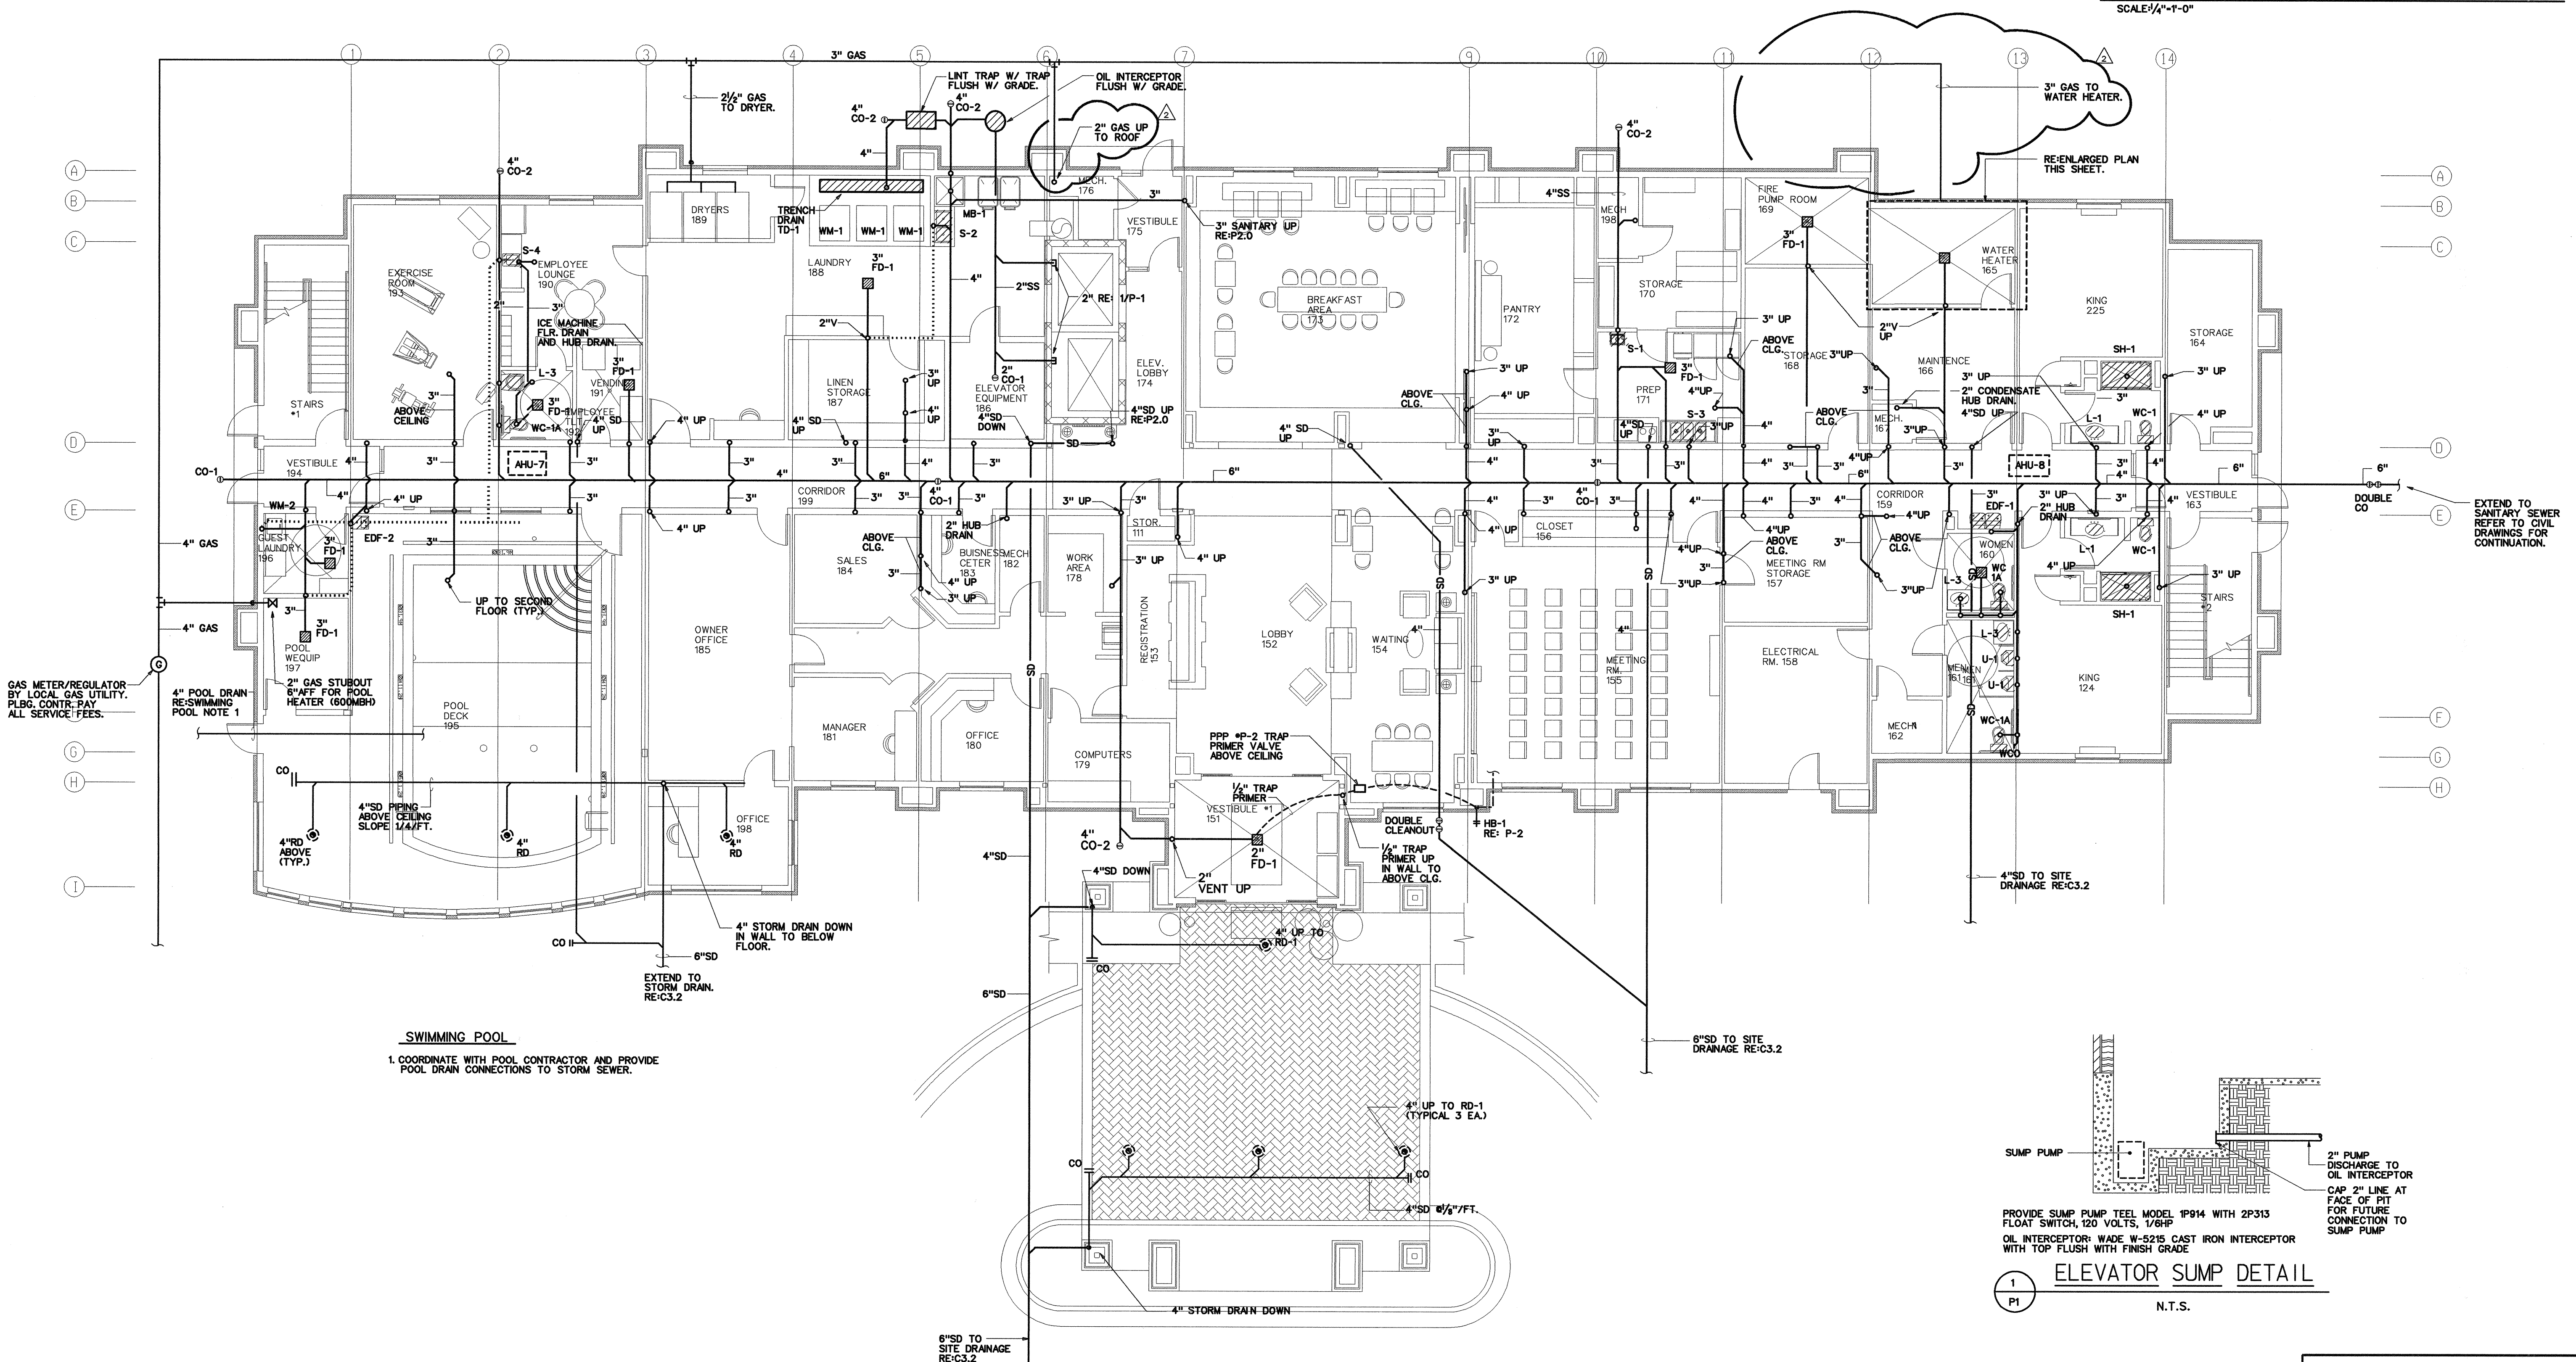

SWIMMING POOL
1. COORDINATE WITH POOL CONTRACTOR AND PROVIDE
POOL DRAIN CONNECTIONS TO STORM SEWER.

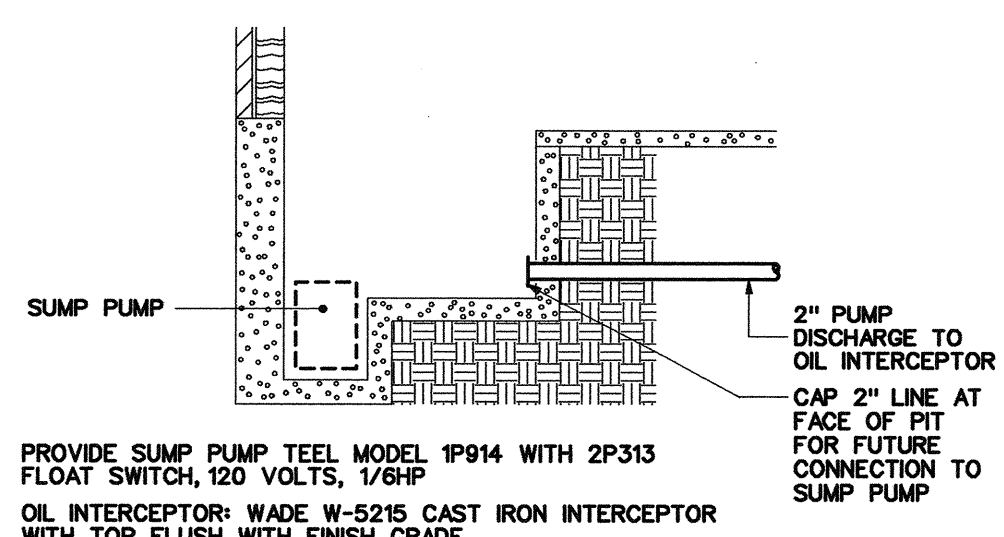

ELEVATOR SUMP DETAIL
N.T.S.

PLUMBING PLAN - FIRST FLOOR

SCALE: 1/8" = 1'-0"