



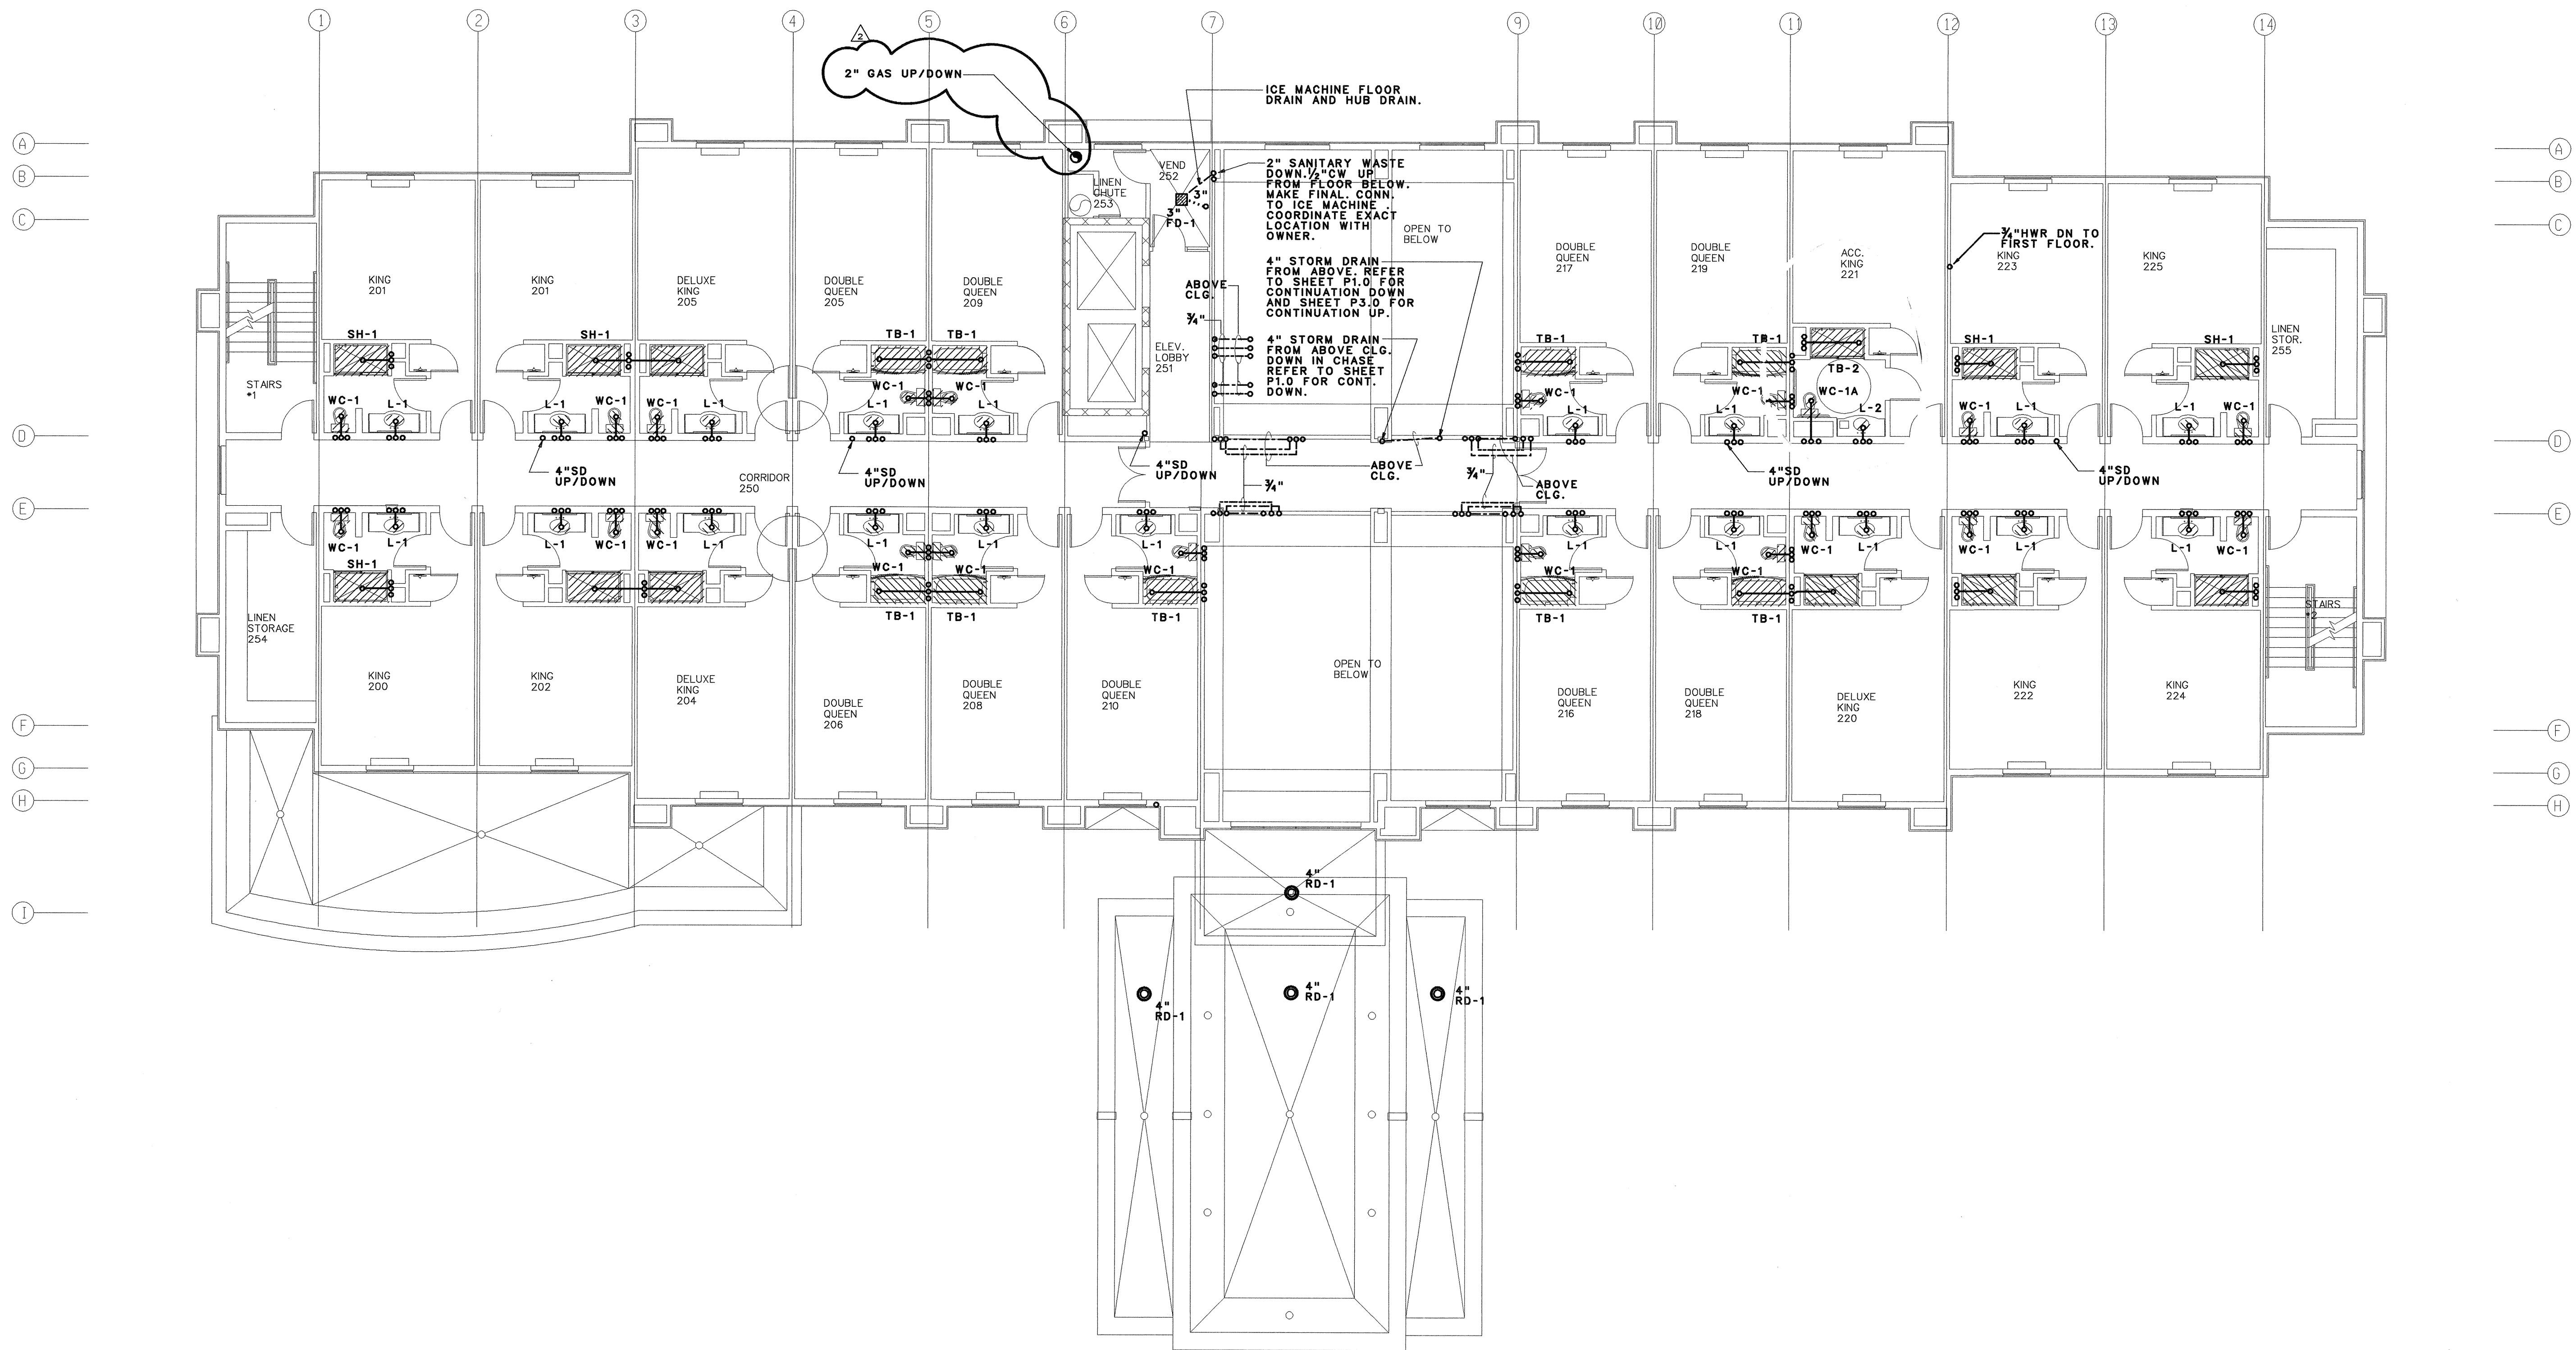

PLUMBING PLAN - SECOND FLOOR
SCALE: 1/4" = 1'-0"

RICHARD F. STELDT
ARCHITECT
(262) 502-4500
N85 W16058 APPLETON AVE., MENOMONEE FALLS, WI 53051

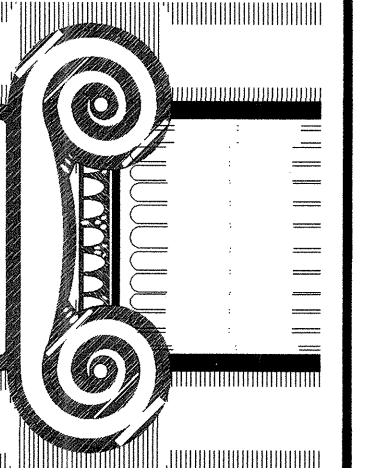

DRAWN:
APPROVED:

DATE: 5/22/08
COMMENTS:
REVISIONS:

JOB:
DATE:

Hampton Inn
98 UNITS FLOWOOD, MS

Fred Newton & Company, Inc.
Consulting Engineers-Mechanical and Electrical
7013 Sand Beach Blvd. Shreveport, LA 71105
318-524-2400 FAX 318-524-0700

SHEET

P2.0