

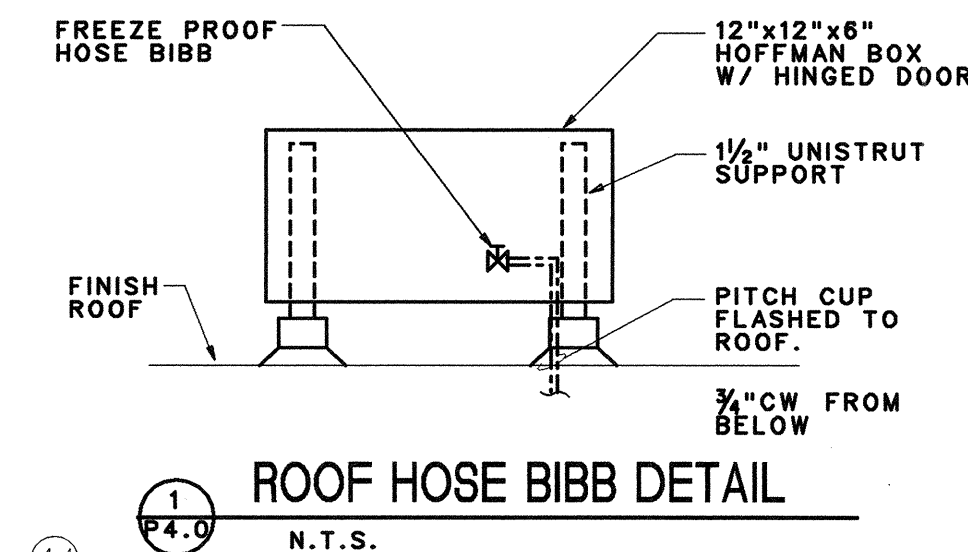
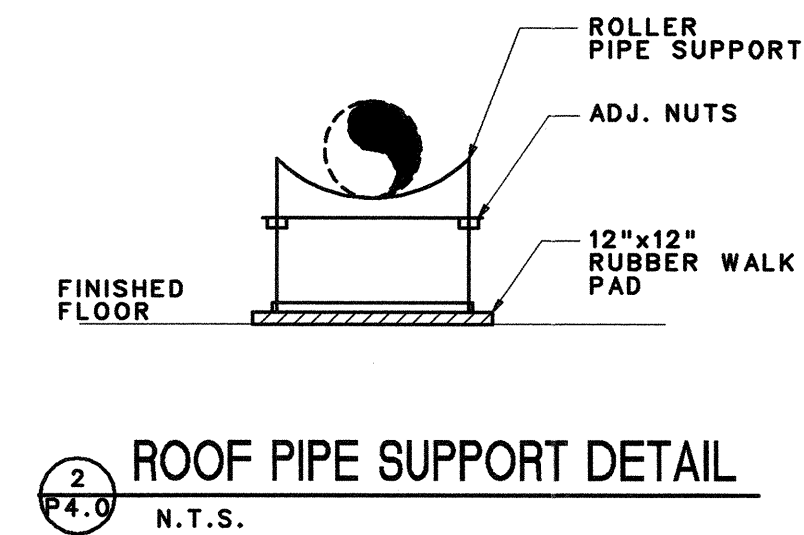


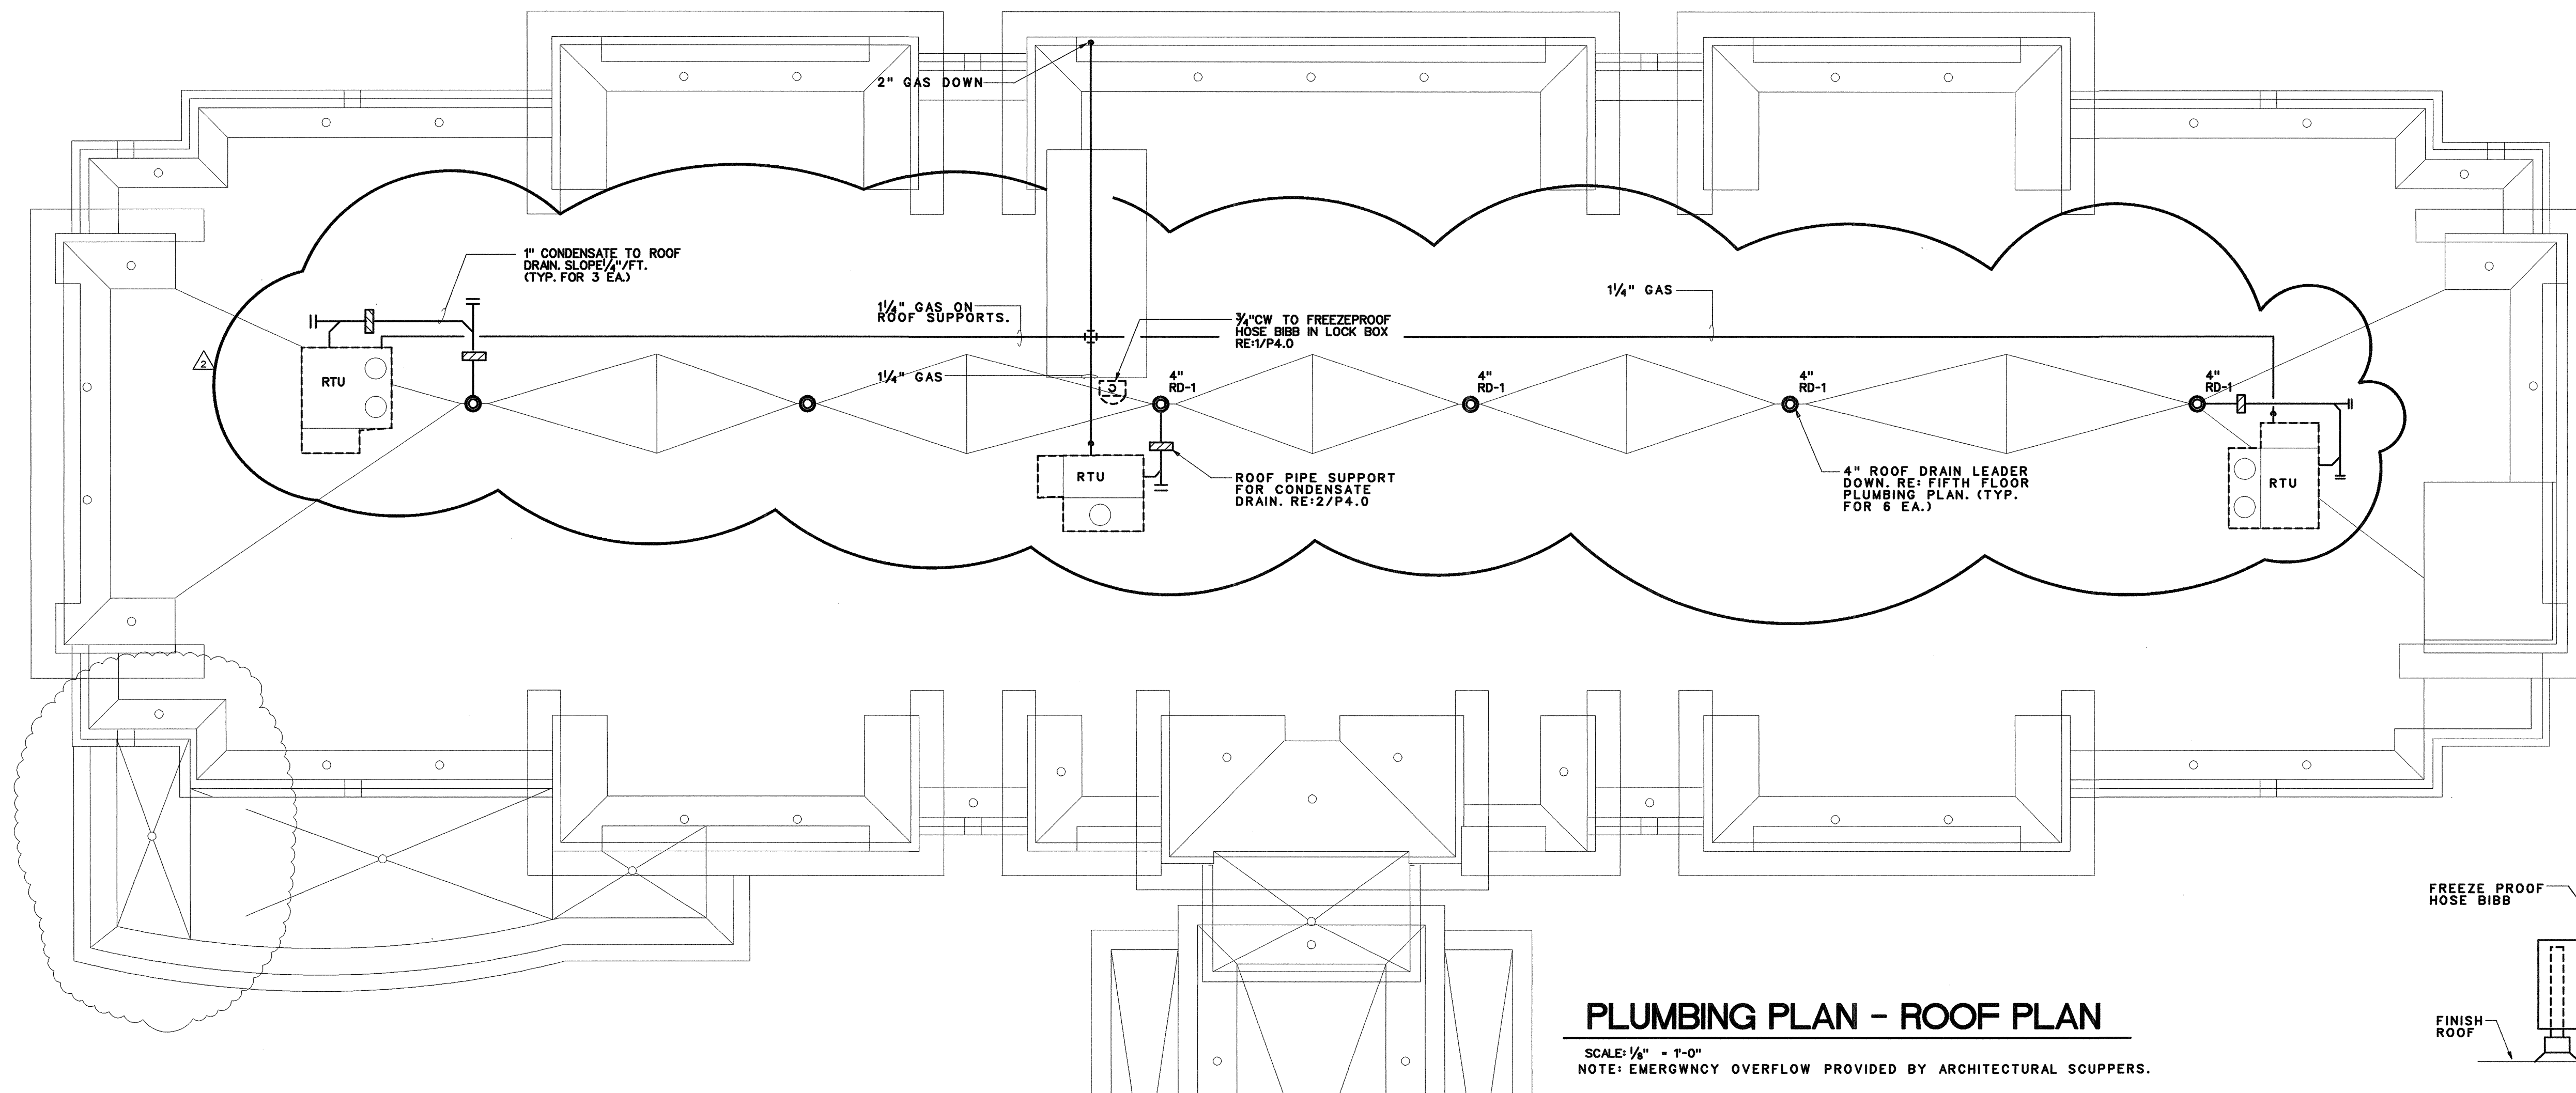

PLUMBING PLAN - ROOF PLAN


SCALE: 1/4" = 1'-0"
NOTE: EMERGENCY OVERFLOW PROVIDED BY ARCHITECTURAL SCUPPERS.

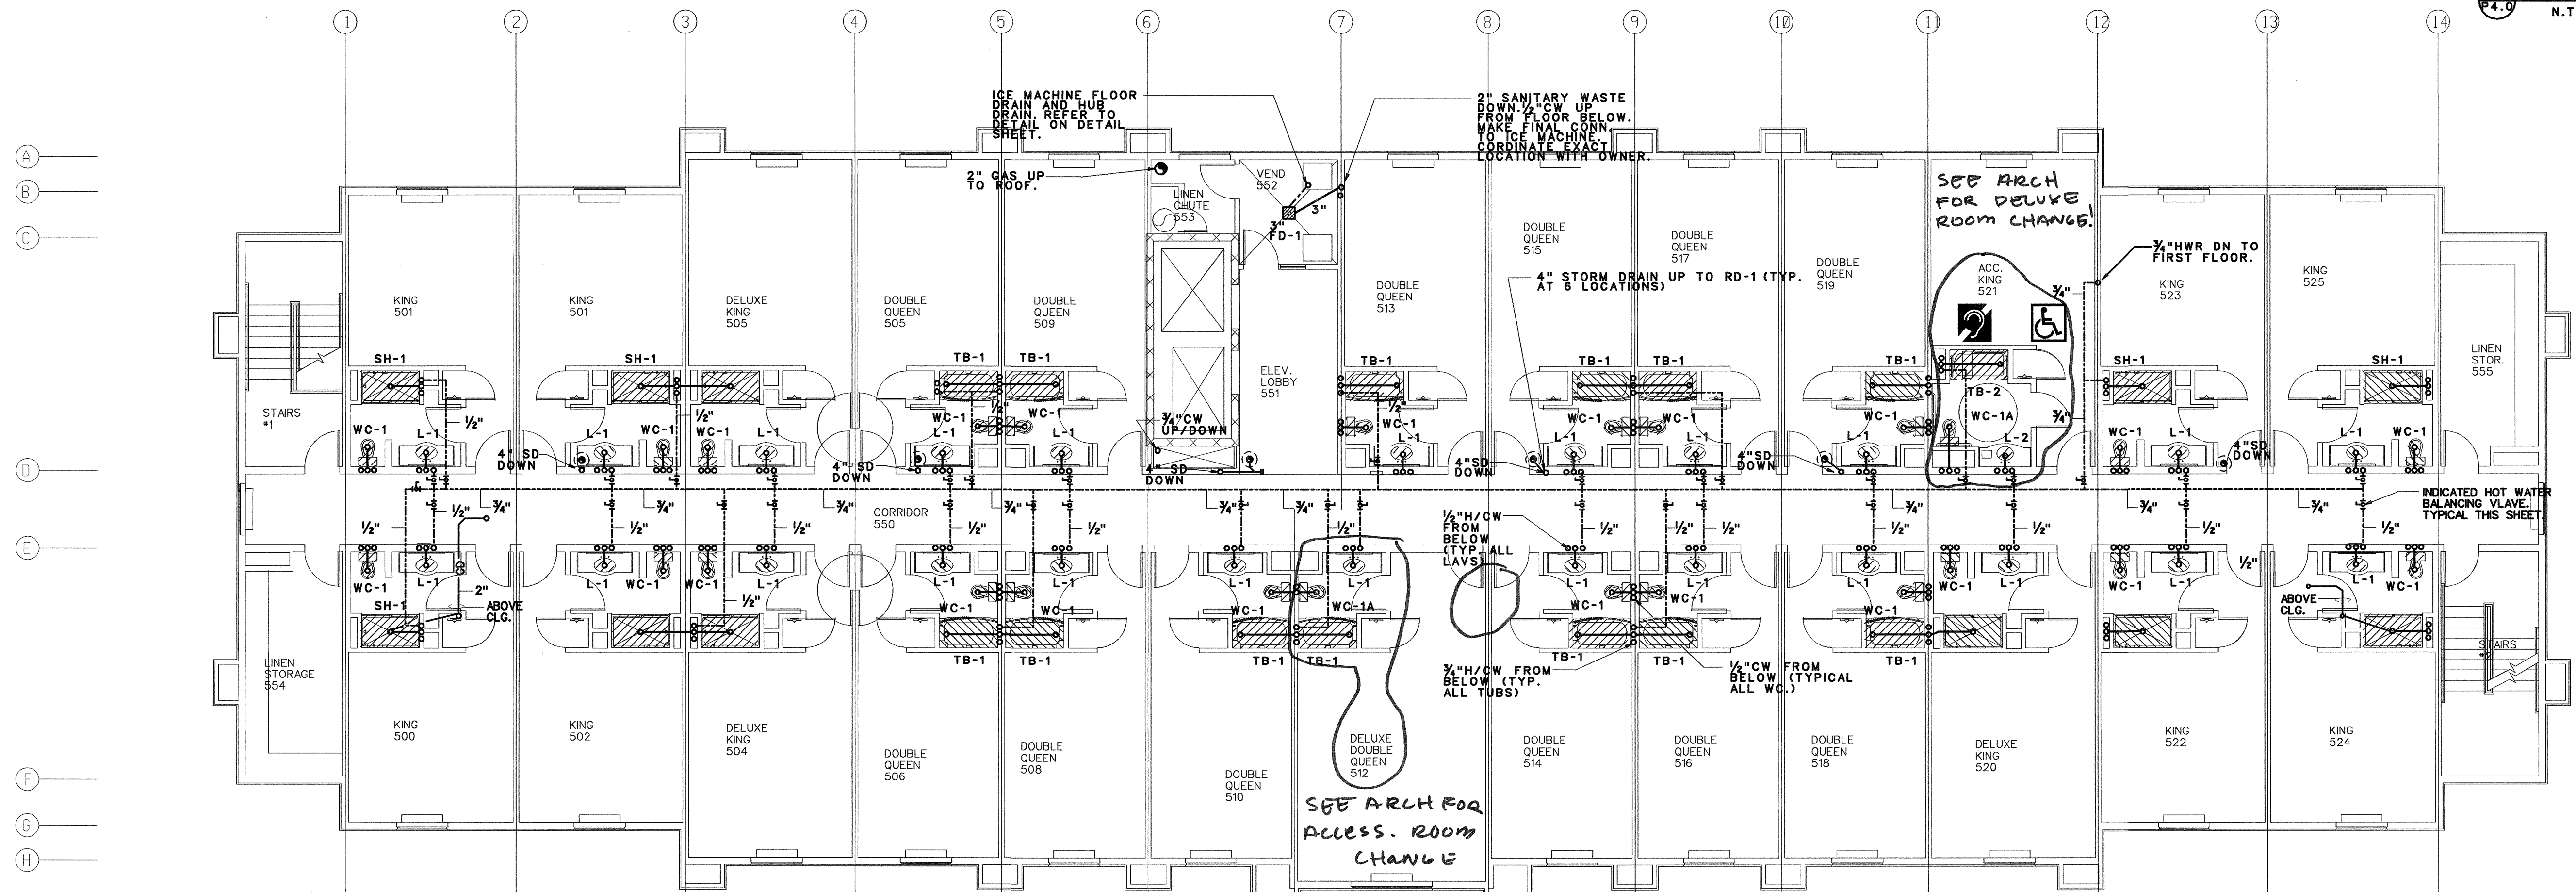

PLUMBING PLAN - FIFTH FLOOR

SCALE: 1/4" = 1'-0"

RICHARD F. STELDT
ARCHITECT
(262) 502-4500
NBS W16058 APPLETON AVE., MENOMONEE FALLS, WI 53051

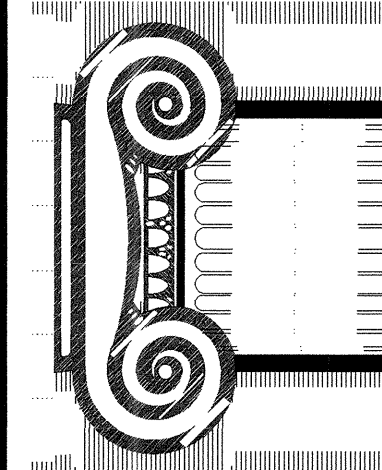

DRAWN:

APPROVED:

DATE: 5/22/08

COMMENTS:

REVISIONS:

JOB:

DATE:

Hampton Inn
98 UNITS
FLOWOOD, MS

Fred Newton & Company, Inc.

Consulting Engineers-Mechanical and Electrical
7013 Sand Beach Blvd. Shreveport, LA 71105
318-524-2400 FAX 318-524-0700

SHEET

P4.0