



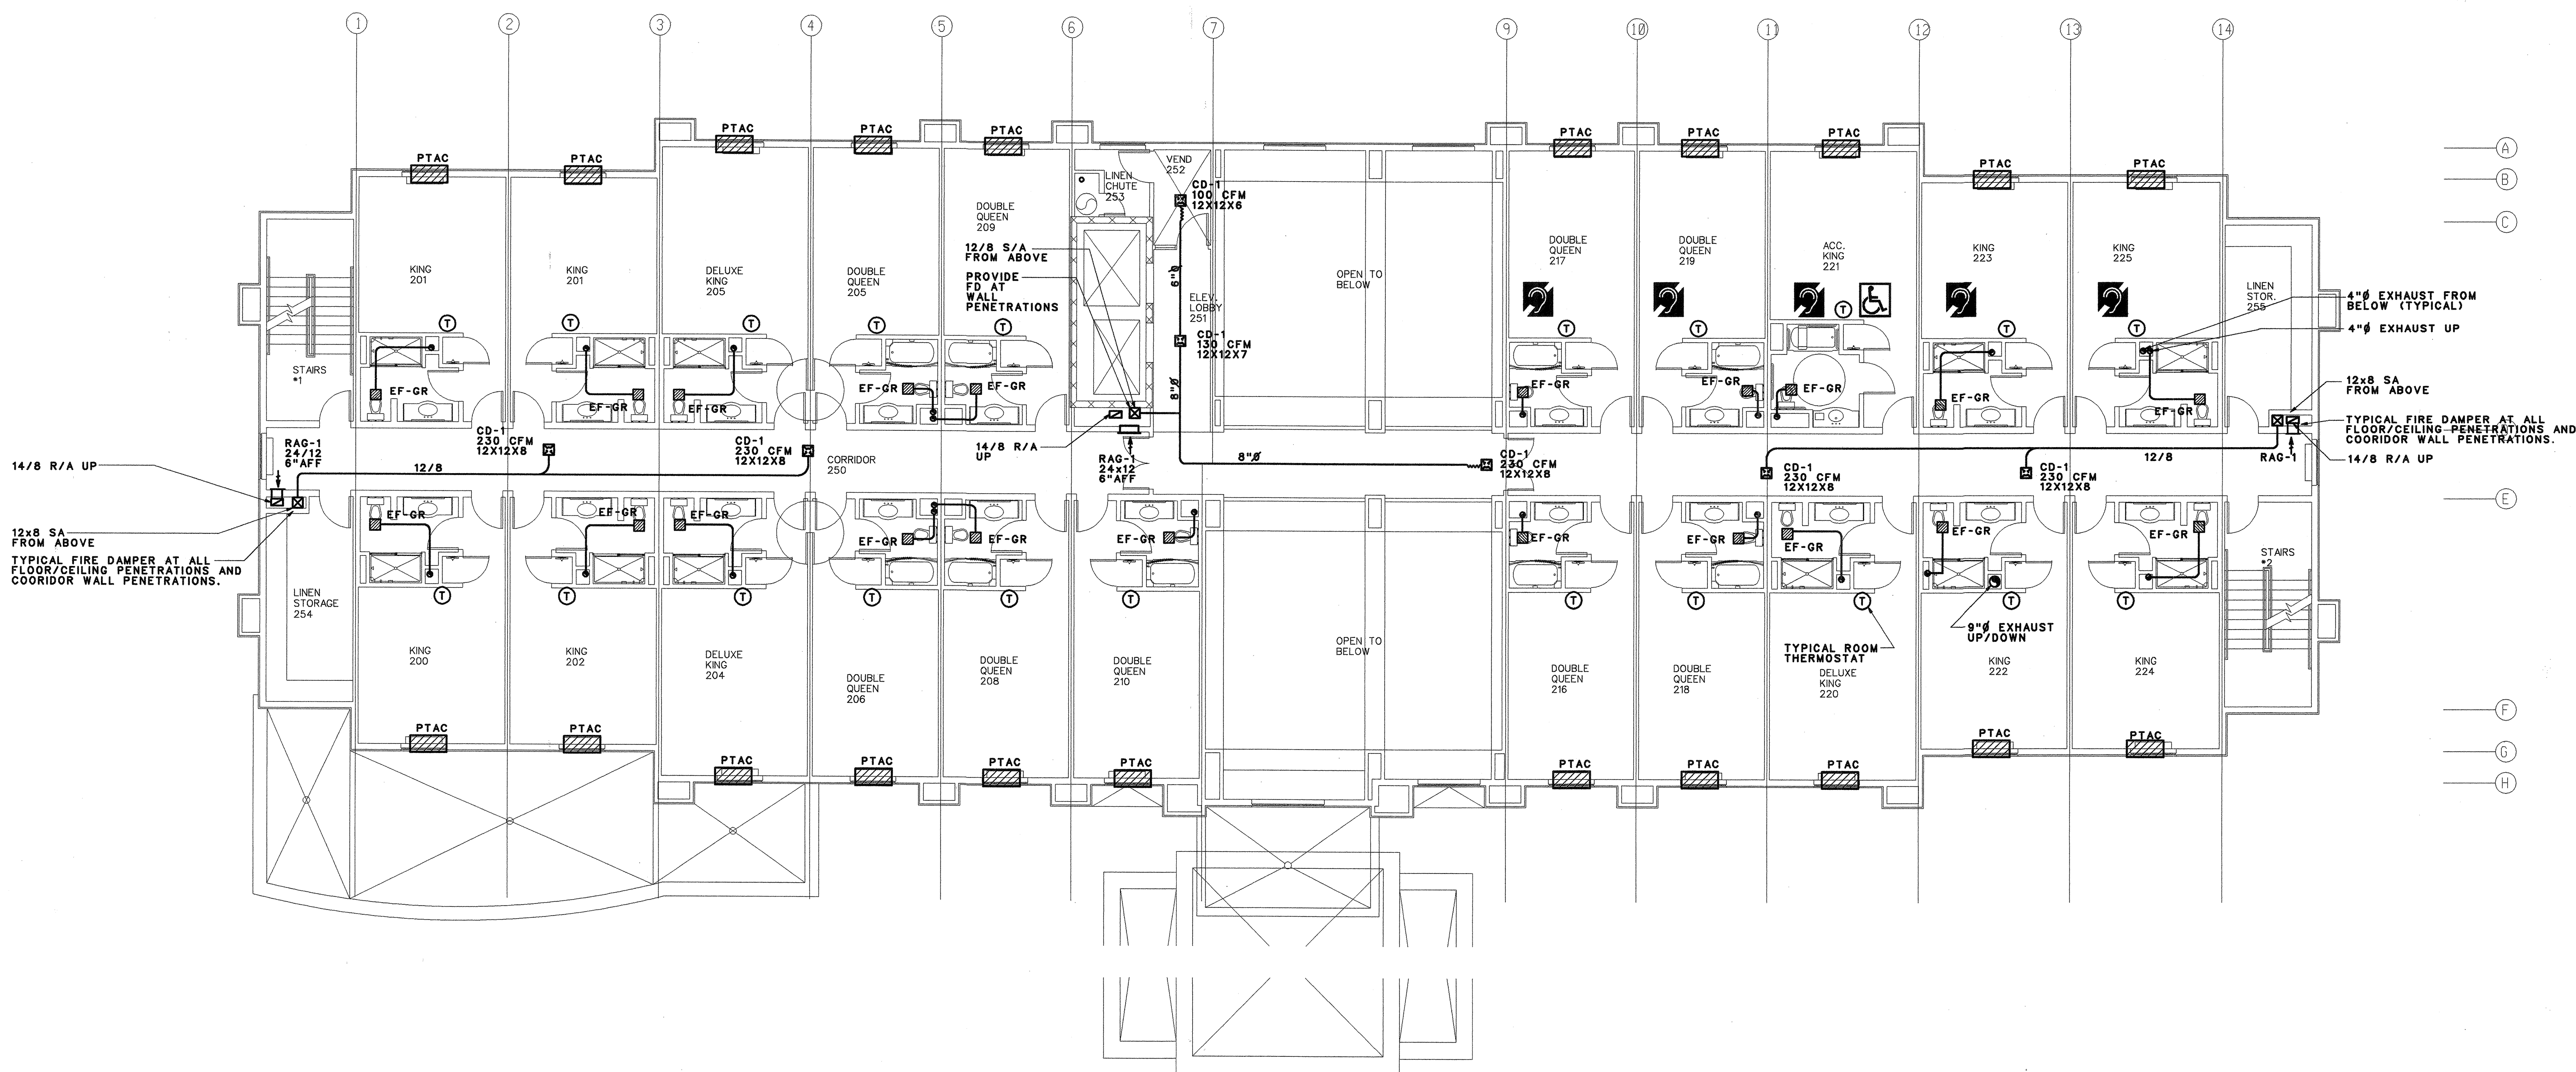

HVAC PLAN - SECOND FLOOR

SCALE: 1/4" = 1'-0"

RICHARD F. STELL
ARCHITECT
(262) 502-4500
N85 W16058 APPLETON AVE., MENOMONEE FALLS, WI 53051

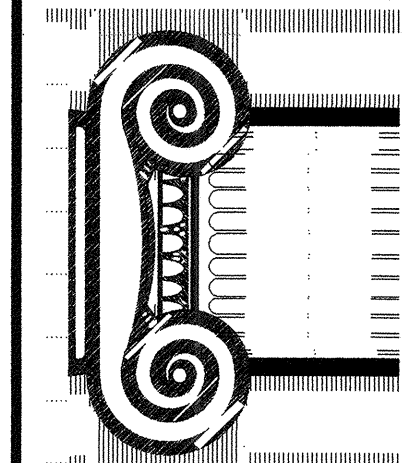

DRAWN:
APPROVED:

12-29-08 NO CHANGE
DATE COMMENTS
REVISIONS

JOB:
DATE: 12-07-07

98 UNITS
Hampton Inn.
FLOWOOD, MS

Fred Newton & Company, Inc.
Consulting Engineers-Mechanical and Electrical
7013 Sand Beach Blvd. Shreveport, LA 71105
318-524-2400 FAX 318-524-0700

SHEET

M2.0