



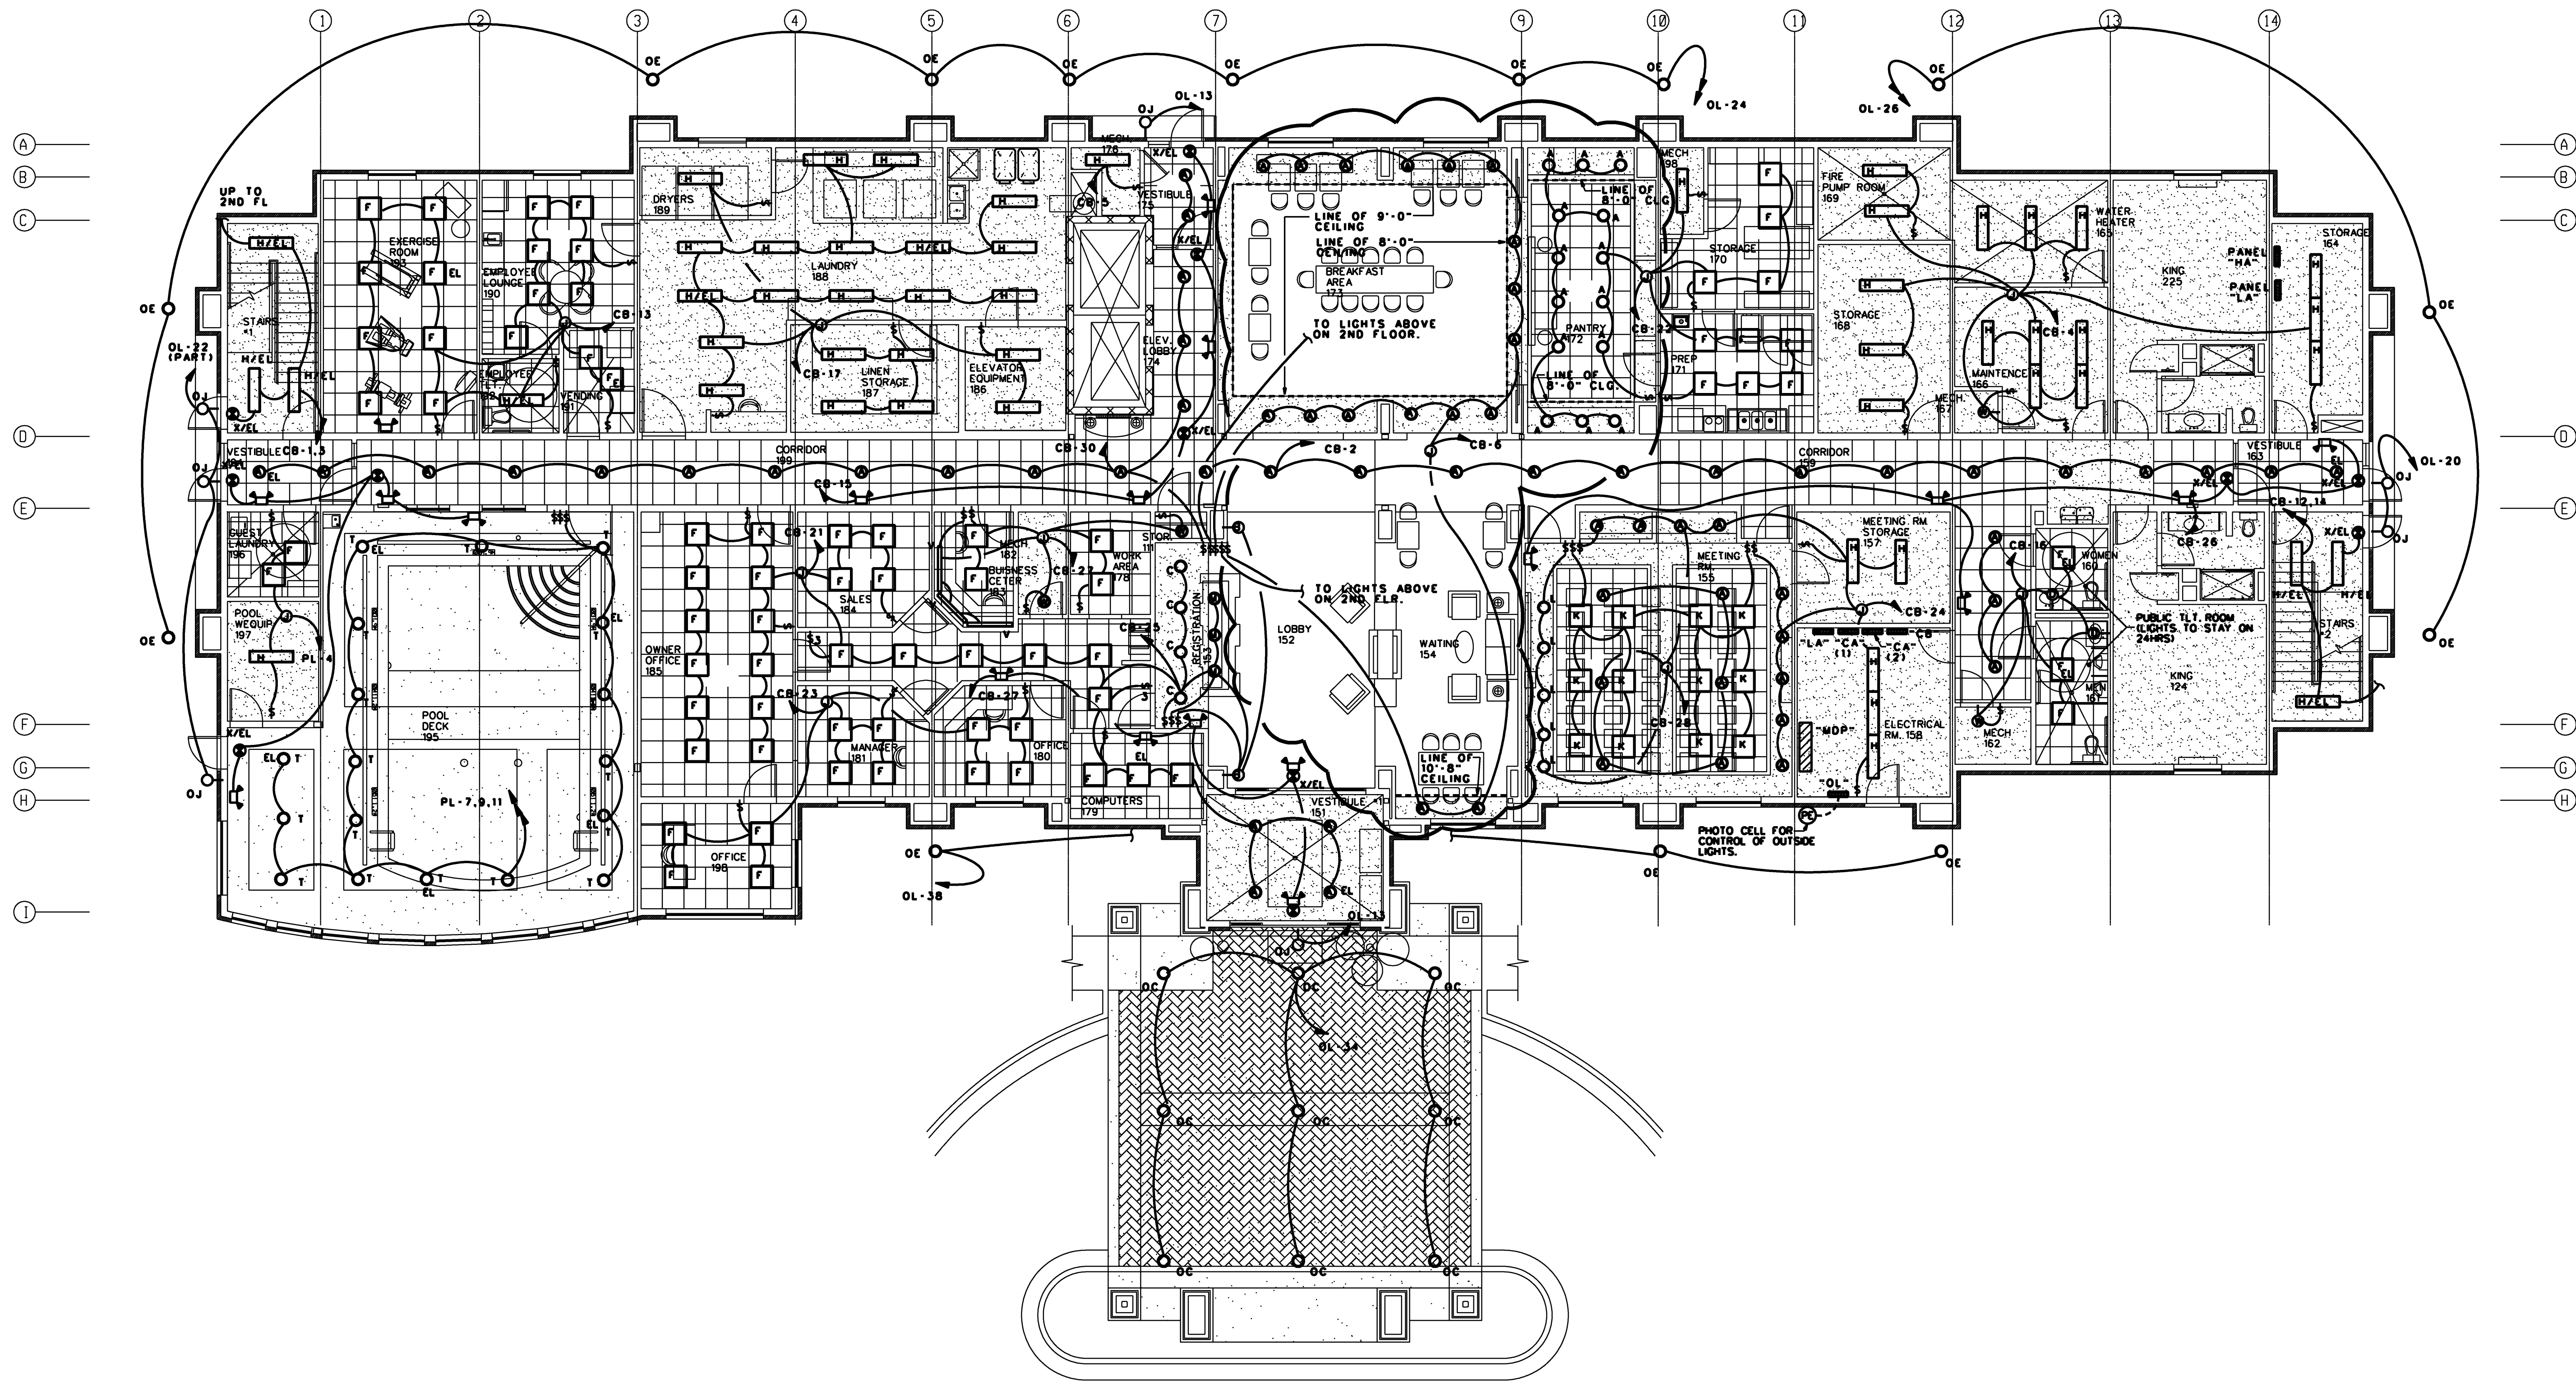

LIGHTING PLAN - FIRST FLOOR
SCALE: 1/8" = 1'-0"

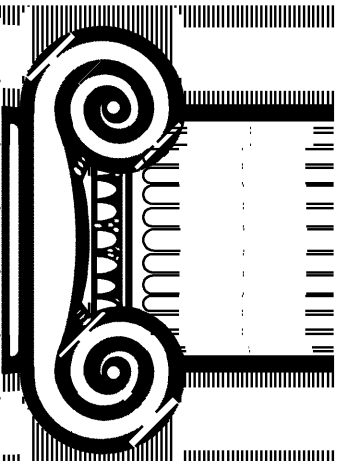

DRAWN:

APPROVED:

2/29/08 REVISED FOR ADDITION #1

2/22/08 REVISED PER HAMPTON REVIEW

DATE COMMENTS

REVISIONS

JOB:

DATE:

Hampton Inn.
98 UNITS FLOWOOD, MS

Fred Newton & Company, Inc.

Consulting Engineers-Mechanical and Electrical
7013 Sand Beach Blvd. Shreveport, LA 71105
318-524-2400 FAX 318-524-0700

SHEET

E2.0