



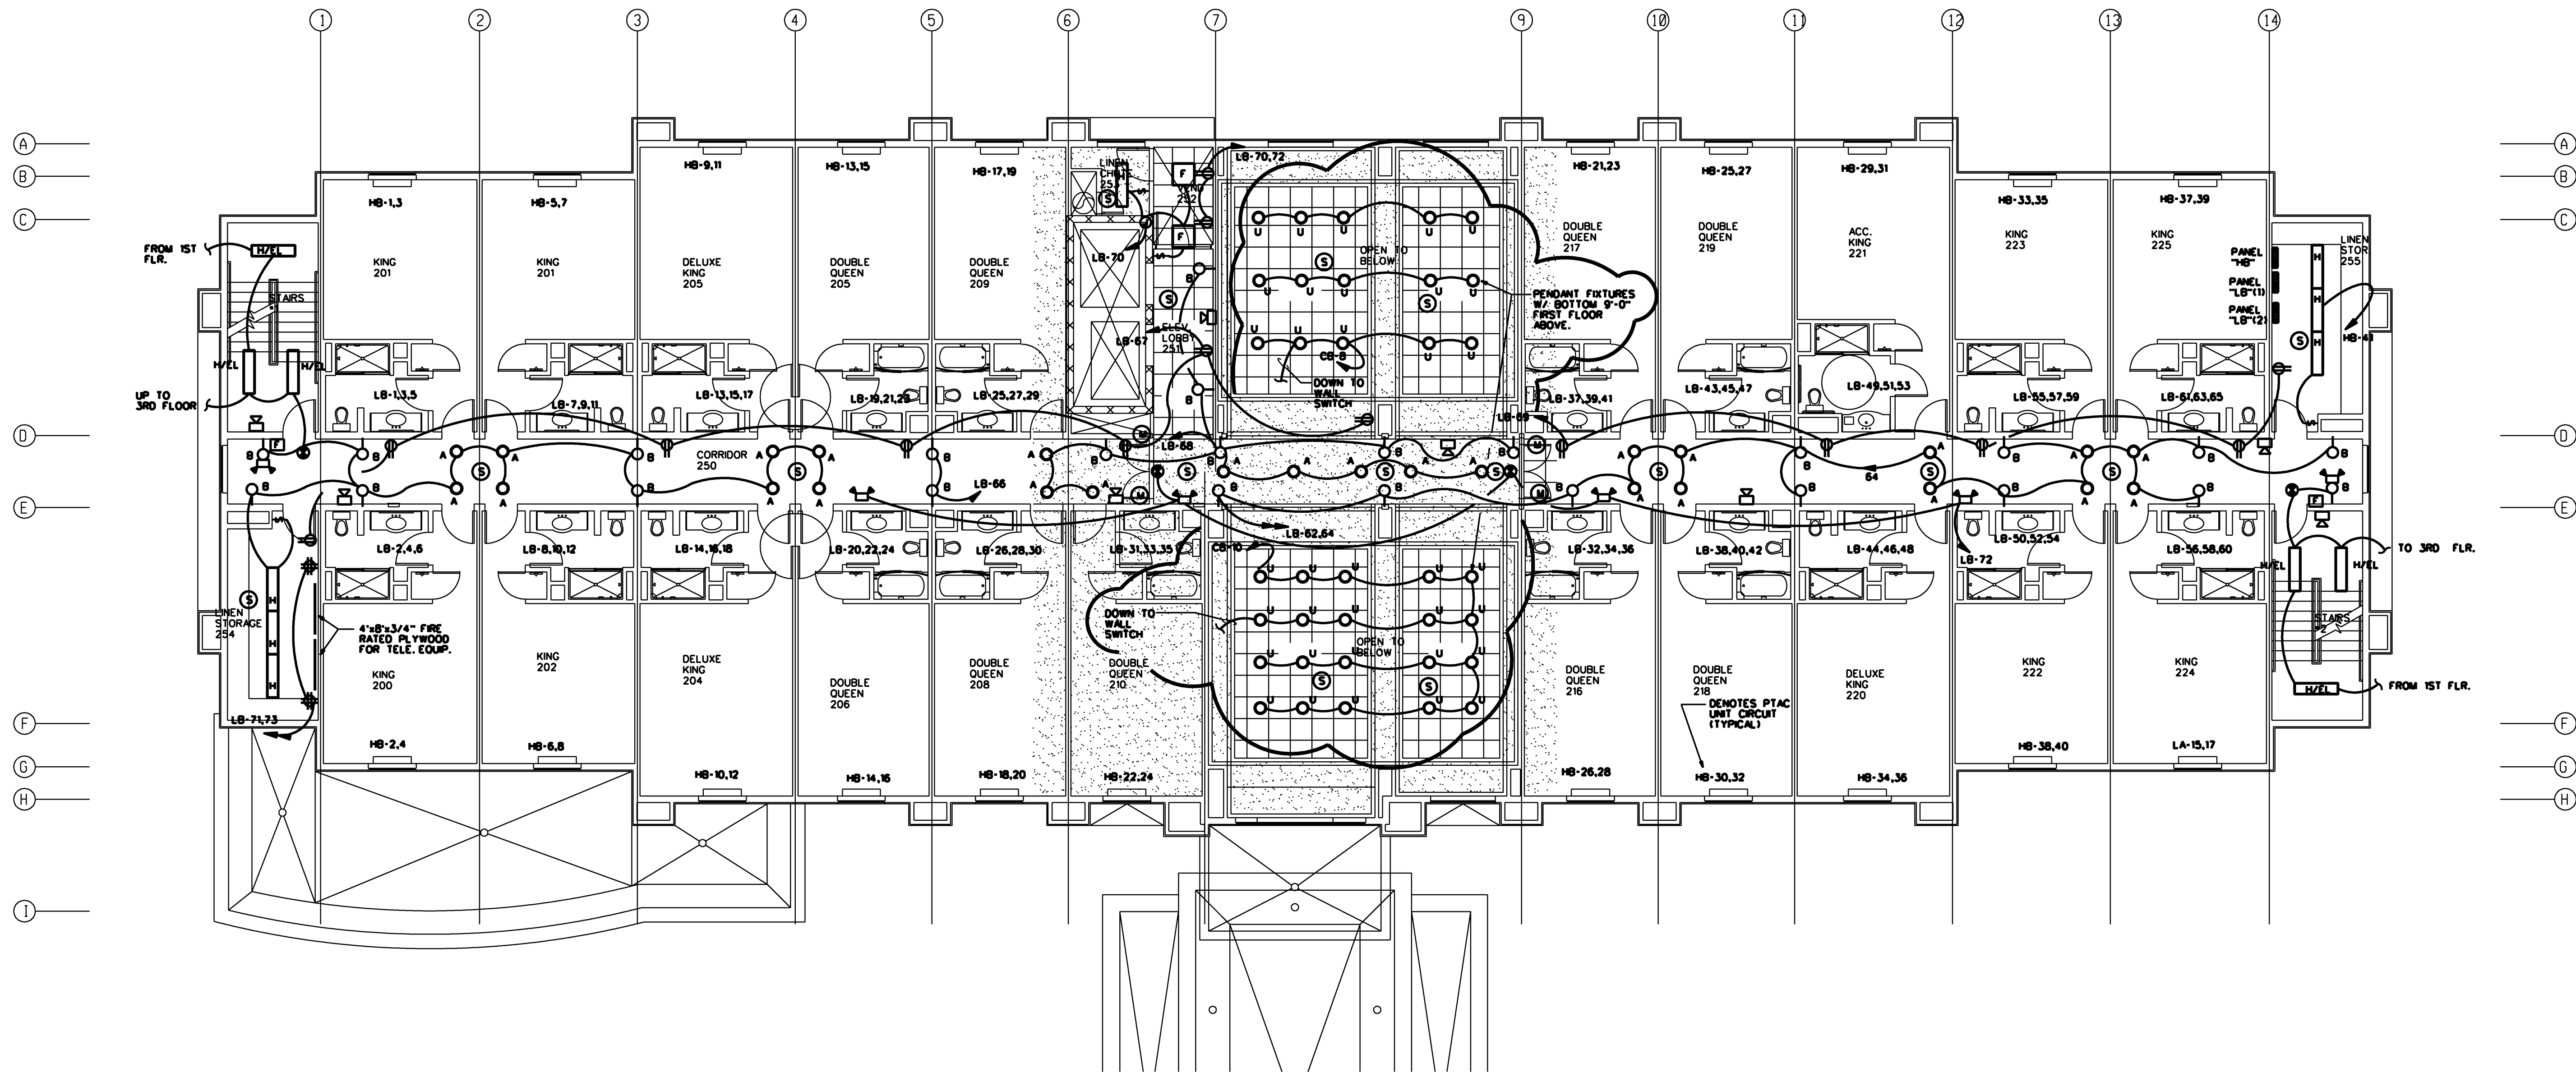

ELECTRICAL PLAN - SECOND FLOOR

SCALE: 1/8" = 1'-0"

RICHARD F. STELDT
ARCHITECT
(262) 502-4500
N85 W18058 APPLETON AVE., MENOMONEE FALLS, WI 53051

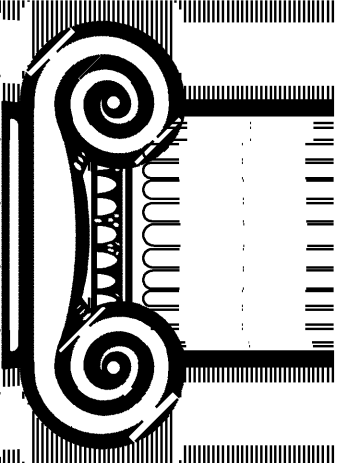

DRAWN:

APPROVED:

2/25/08 REVISED FOR ADDITION #1

DATE COMMENTS

REVISIONS

JOB:

DATE:

Hampton Inn.
98 UNITS FLOWOOD, MS

Fred Newton & Company, Inc.

Consulting Engineers-Mechanical and Electrical
7013 Sand Beach Blvd. Shreveport, LA 71105
318-524-2400 FAX 318-524-0700

SHEET

E3.0