
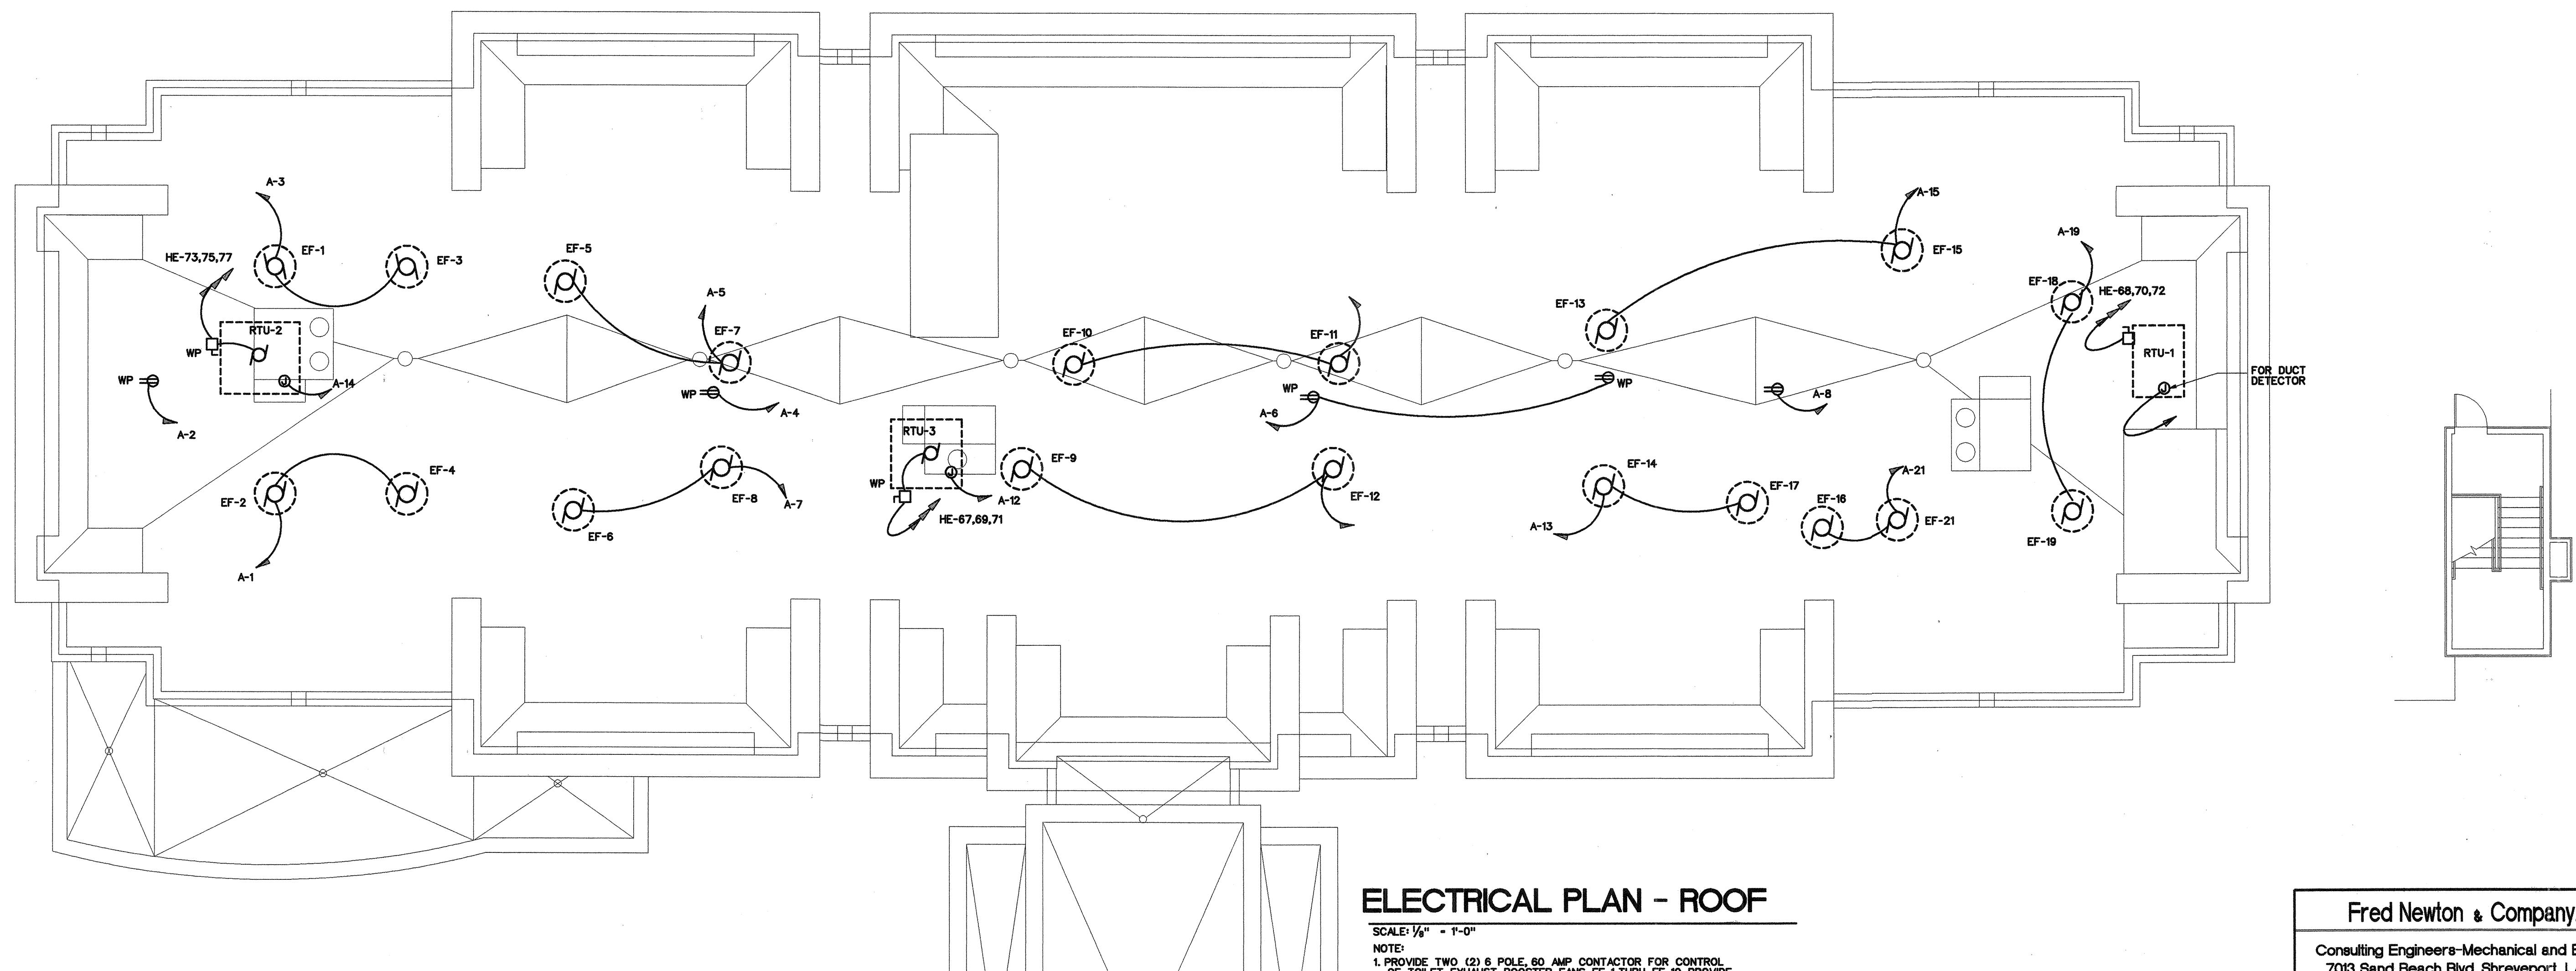


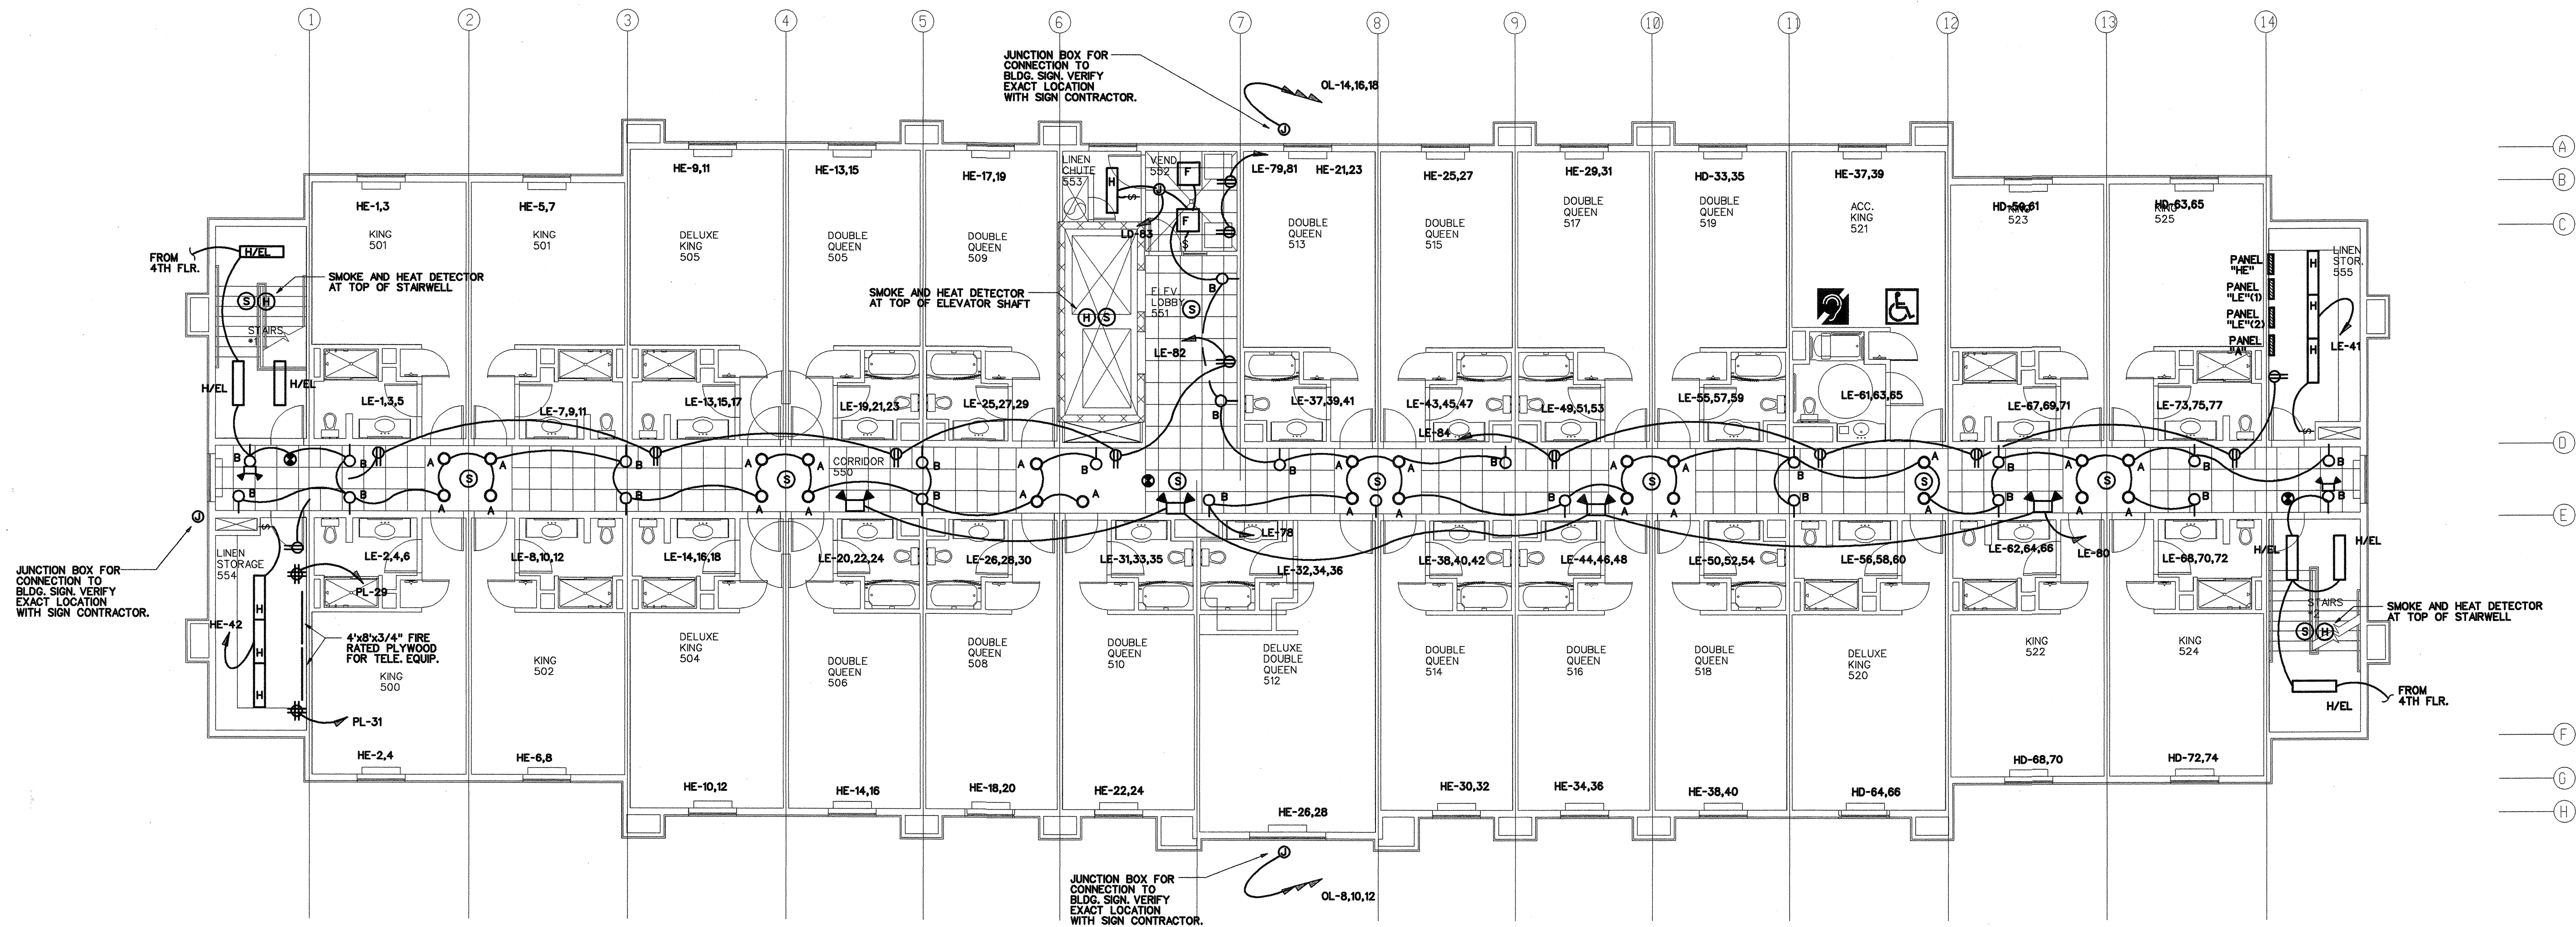

ELECTRICAL PLAN - ROOF


SCALE: 1/8" = 1'-0"

NOTE:
1. PROVIDE TWO (2) 6 POLE, 60 AMP CONTACTOR FOR CONTROL OF TOILET EXHAUST BOOSTER FANS EF-1 THRU EF-19. PROVIDE SWITCH CONTROL AT FRONT DESK.

Fred Newton & Company, Inc.

Consulting Engineers-Mechanical and Electrical
7013 Sand Beach Blvd. Shreveport, LA 71105
318-524-2400 FAX 318-524-0700

RICHARD F. STELLI
ARCHITECT
(262) 502-4500
N85 W16058 APPLETON AVE., MENOMONEE FALLS, WI 53051

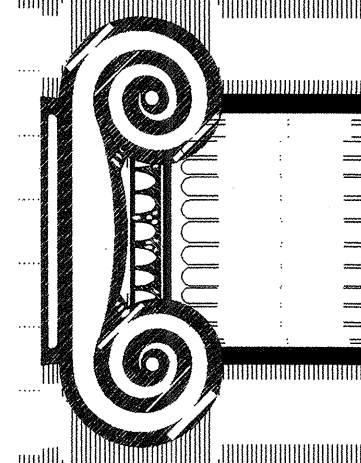

DRAWN:

APPROVED:

2-29-08 NO CHANGE

DATE COMMENTS

REVISIONS

JOB:

DATE: 12-07-07

98 UNITS
Hampton Inn.
FLOWOOD, MS

SHEET

E5.0