


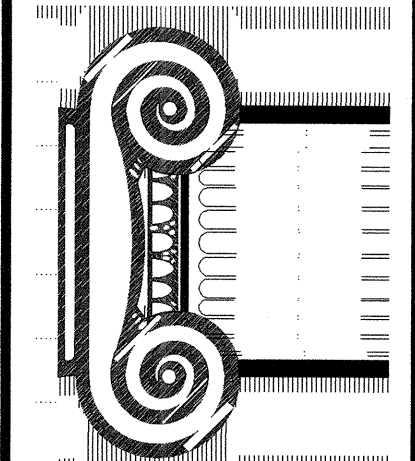

Drawn:
Approved:


2/22/08 REVISED PER HAMPTON REVIEW
date comments
REVISIONS

Job:
Date: 12-07-07


Hampton Inn
98 UNITS
FLOWOOD, MS

Sheet


P1.0

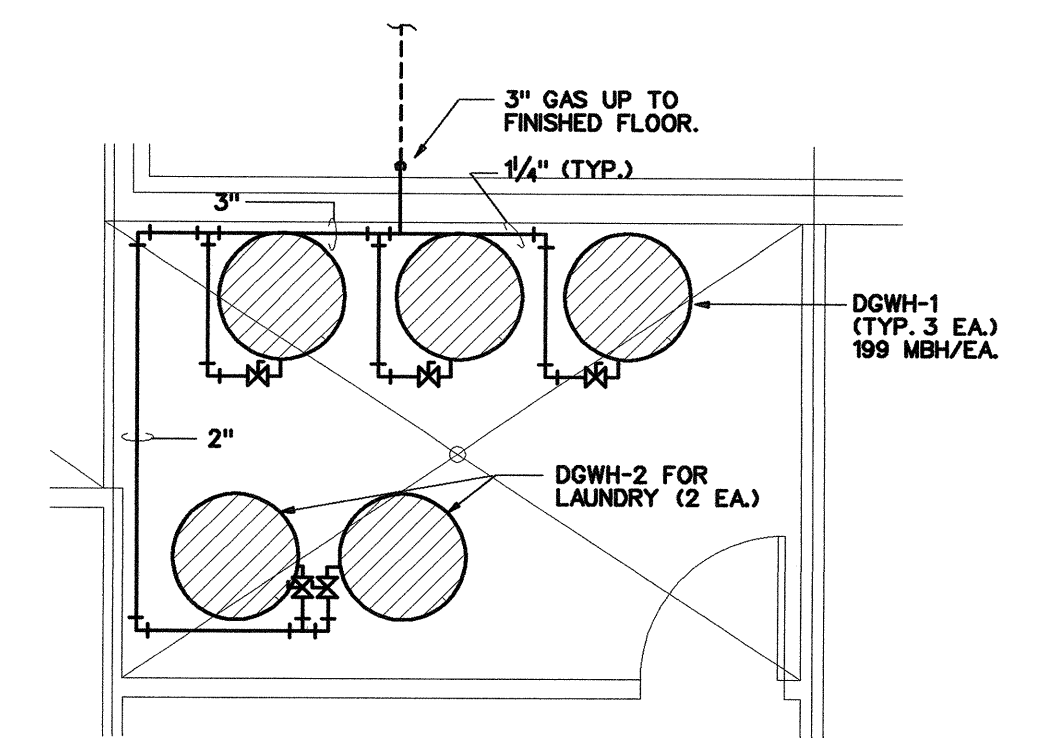

ENLARGED WATER HEATER RM.
SCALE: 1/4" = 1'-0"

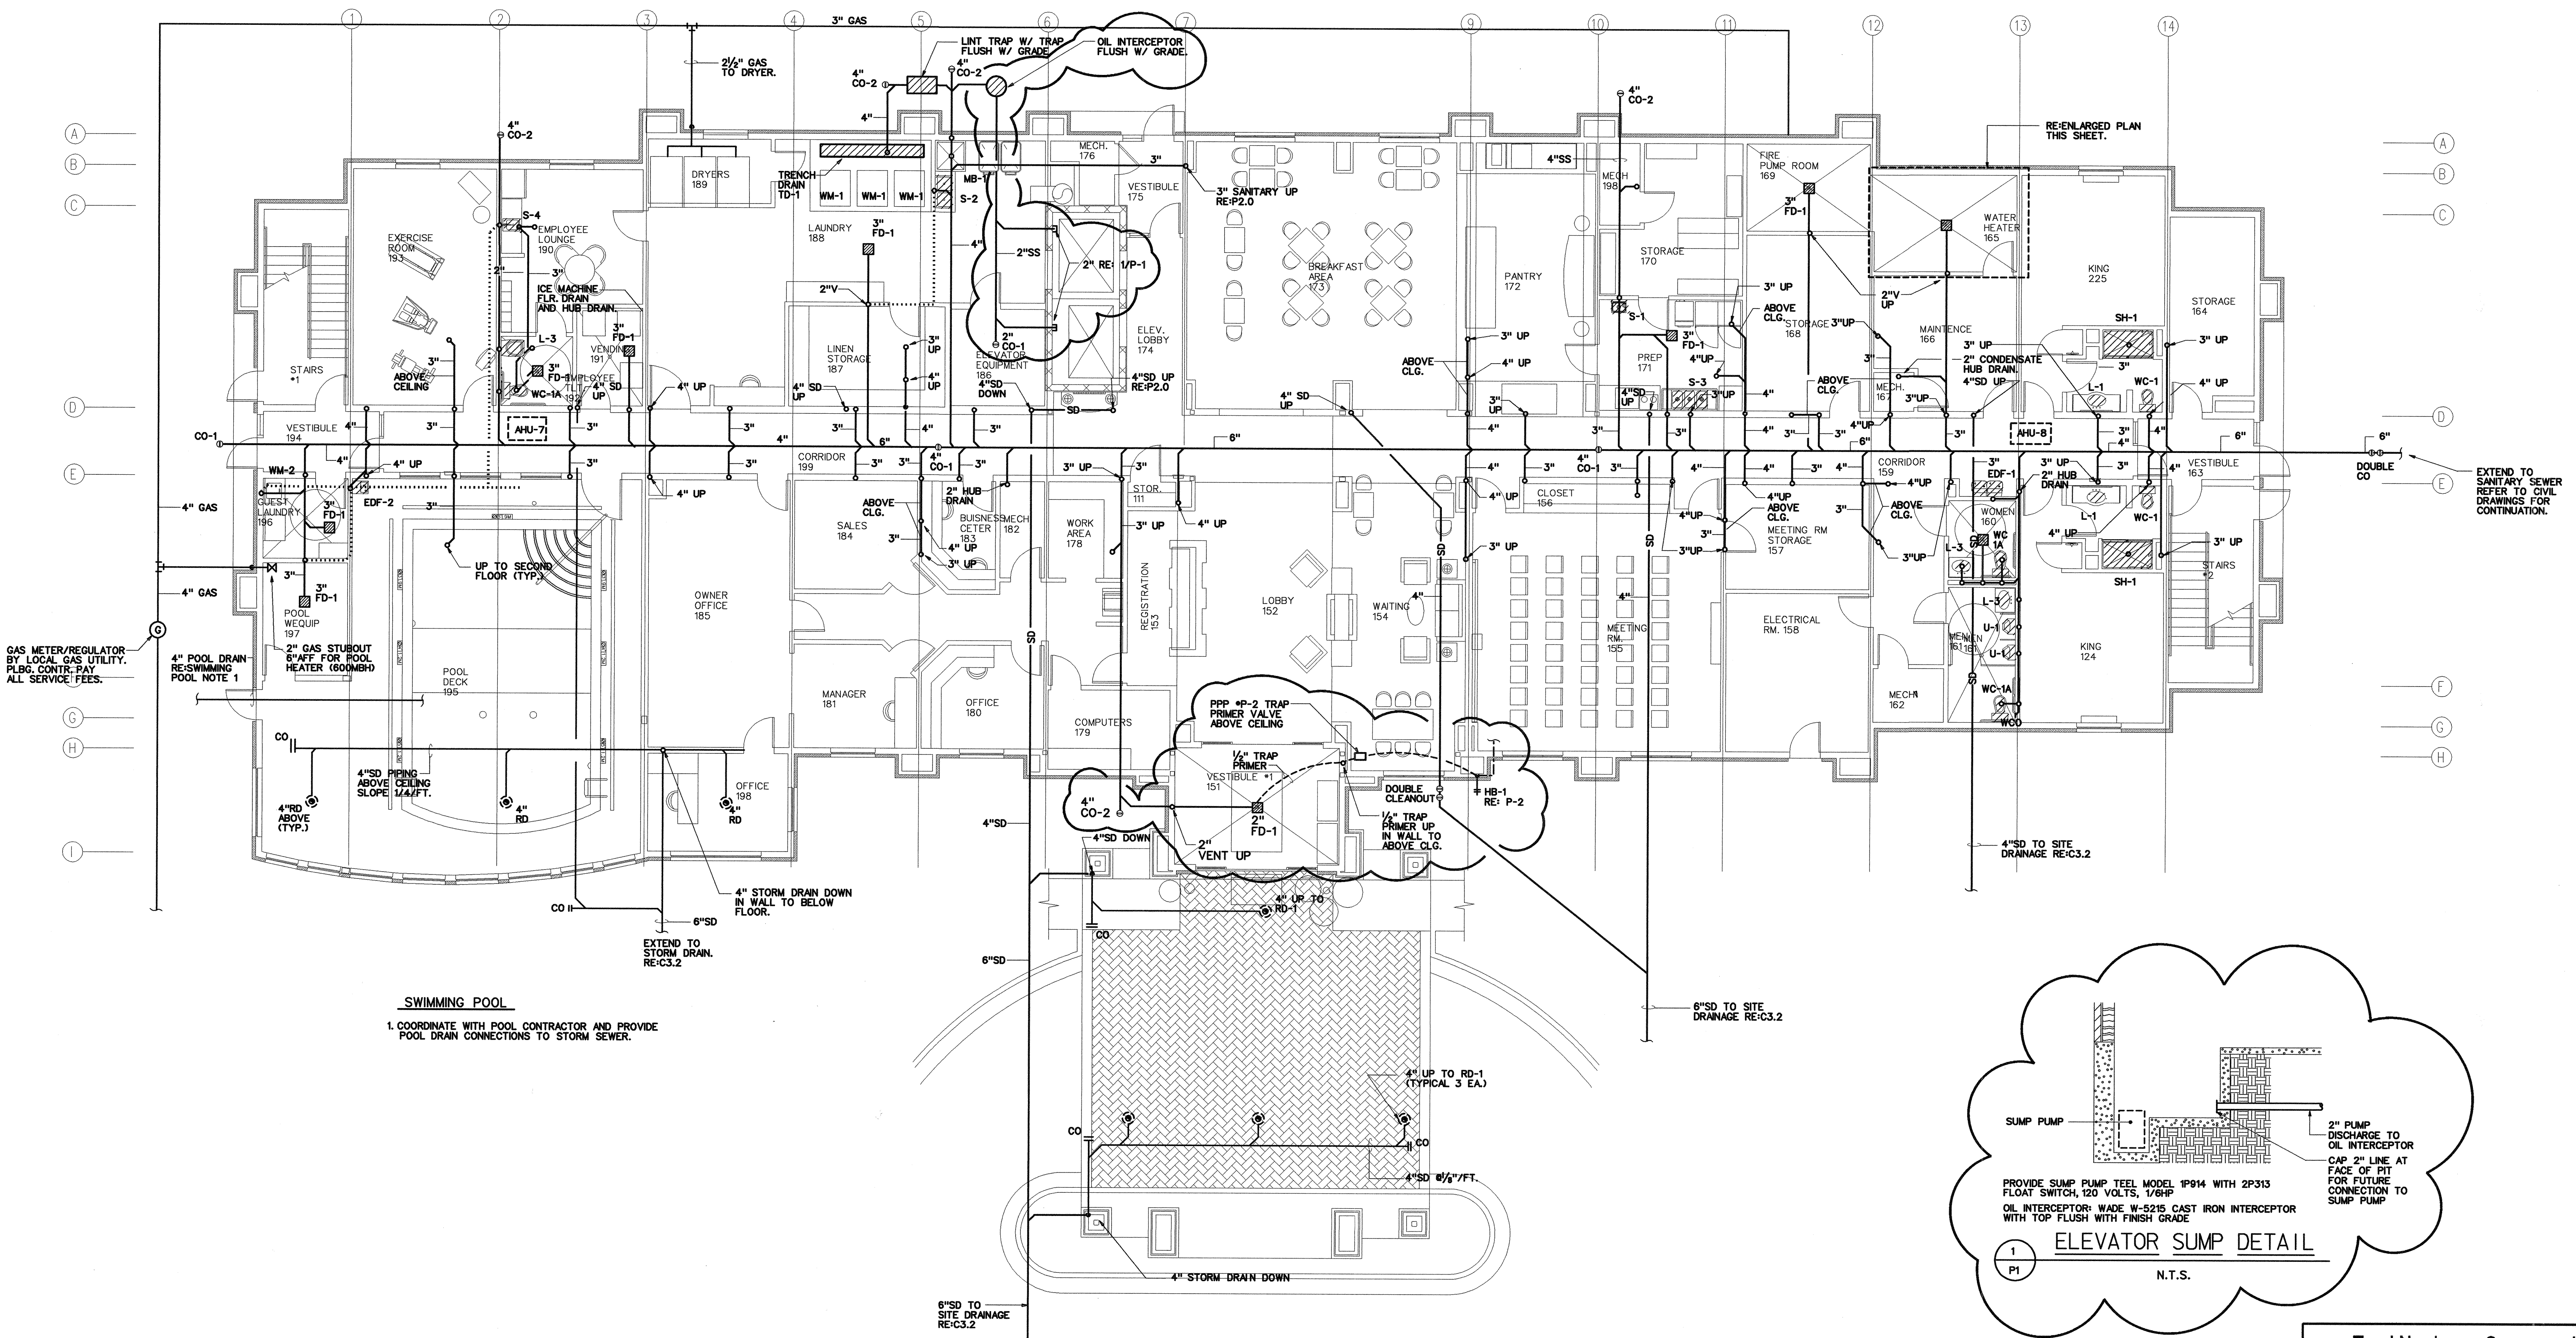

PLUMBING PLAN - FIRST FLOOR
SCALE: 1/4" = 1'-0"

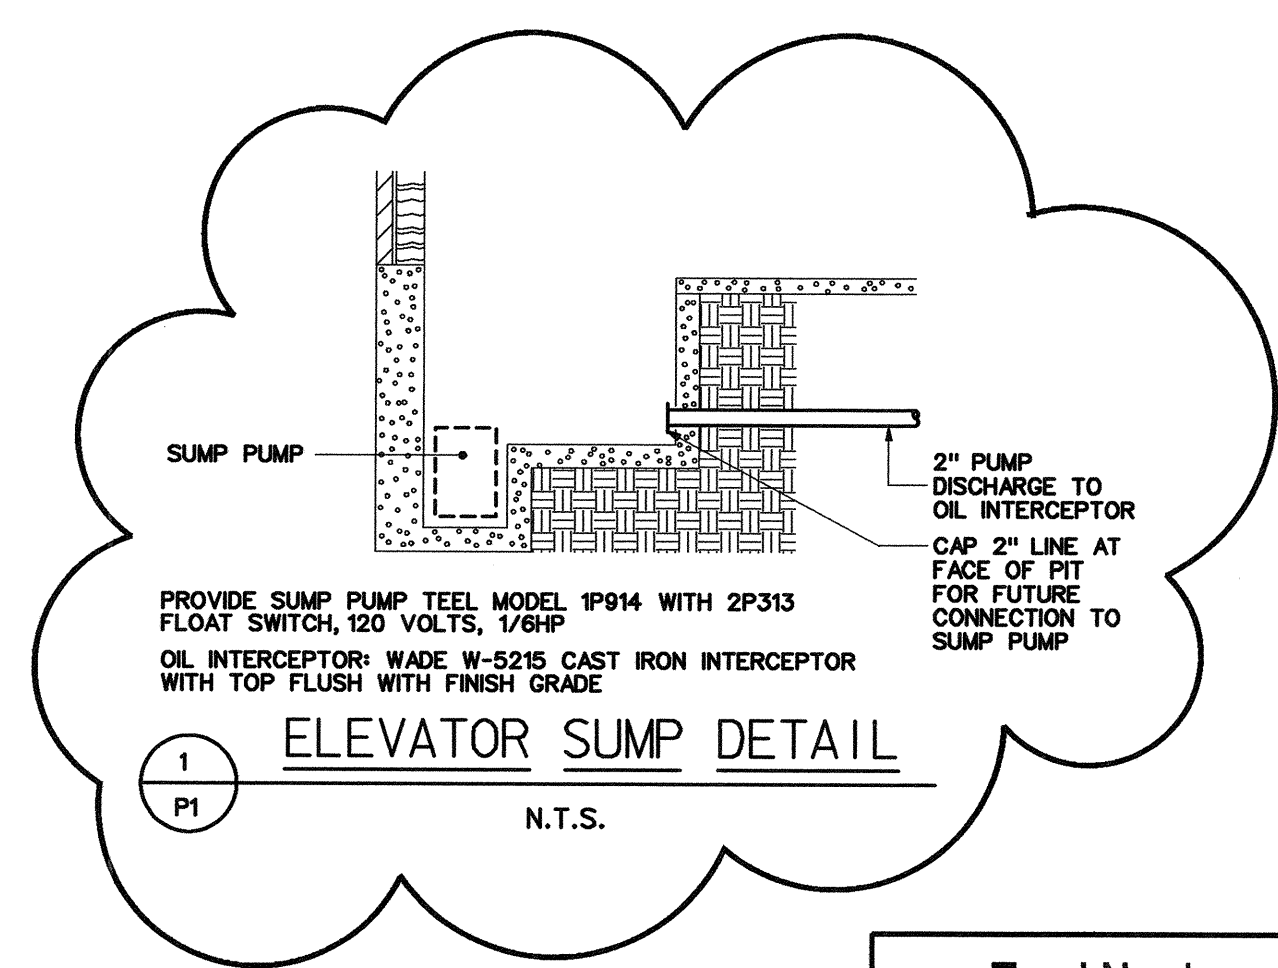

Fred Newton & Company, Inc.
Consulting Engineers-Mechanical and Electrical
7013 Sand Beach Blvd. Shreveport, LA 71105
318-524-2400 FAX 318-524-0700