



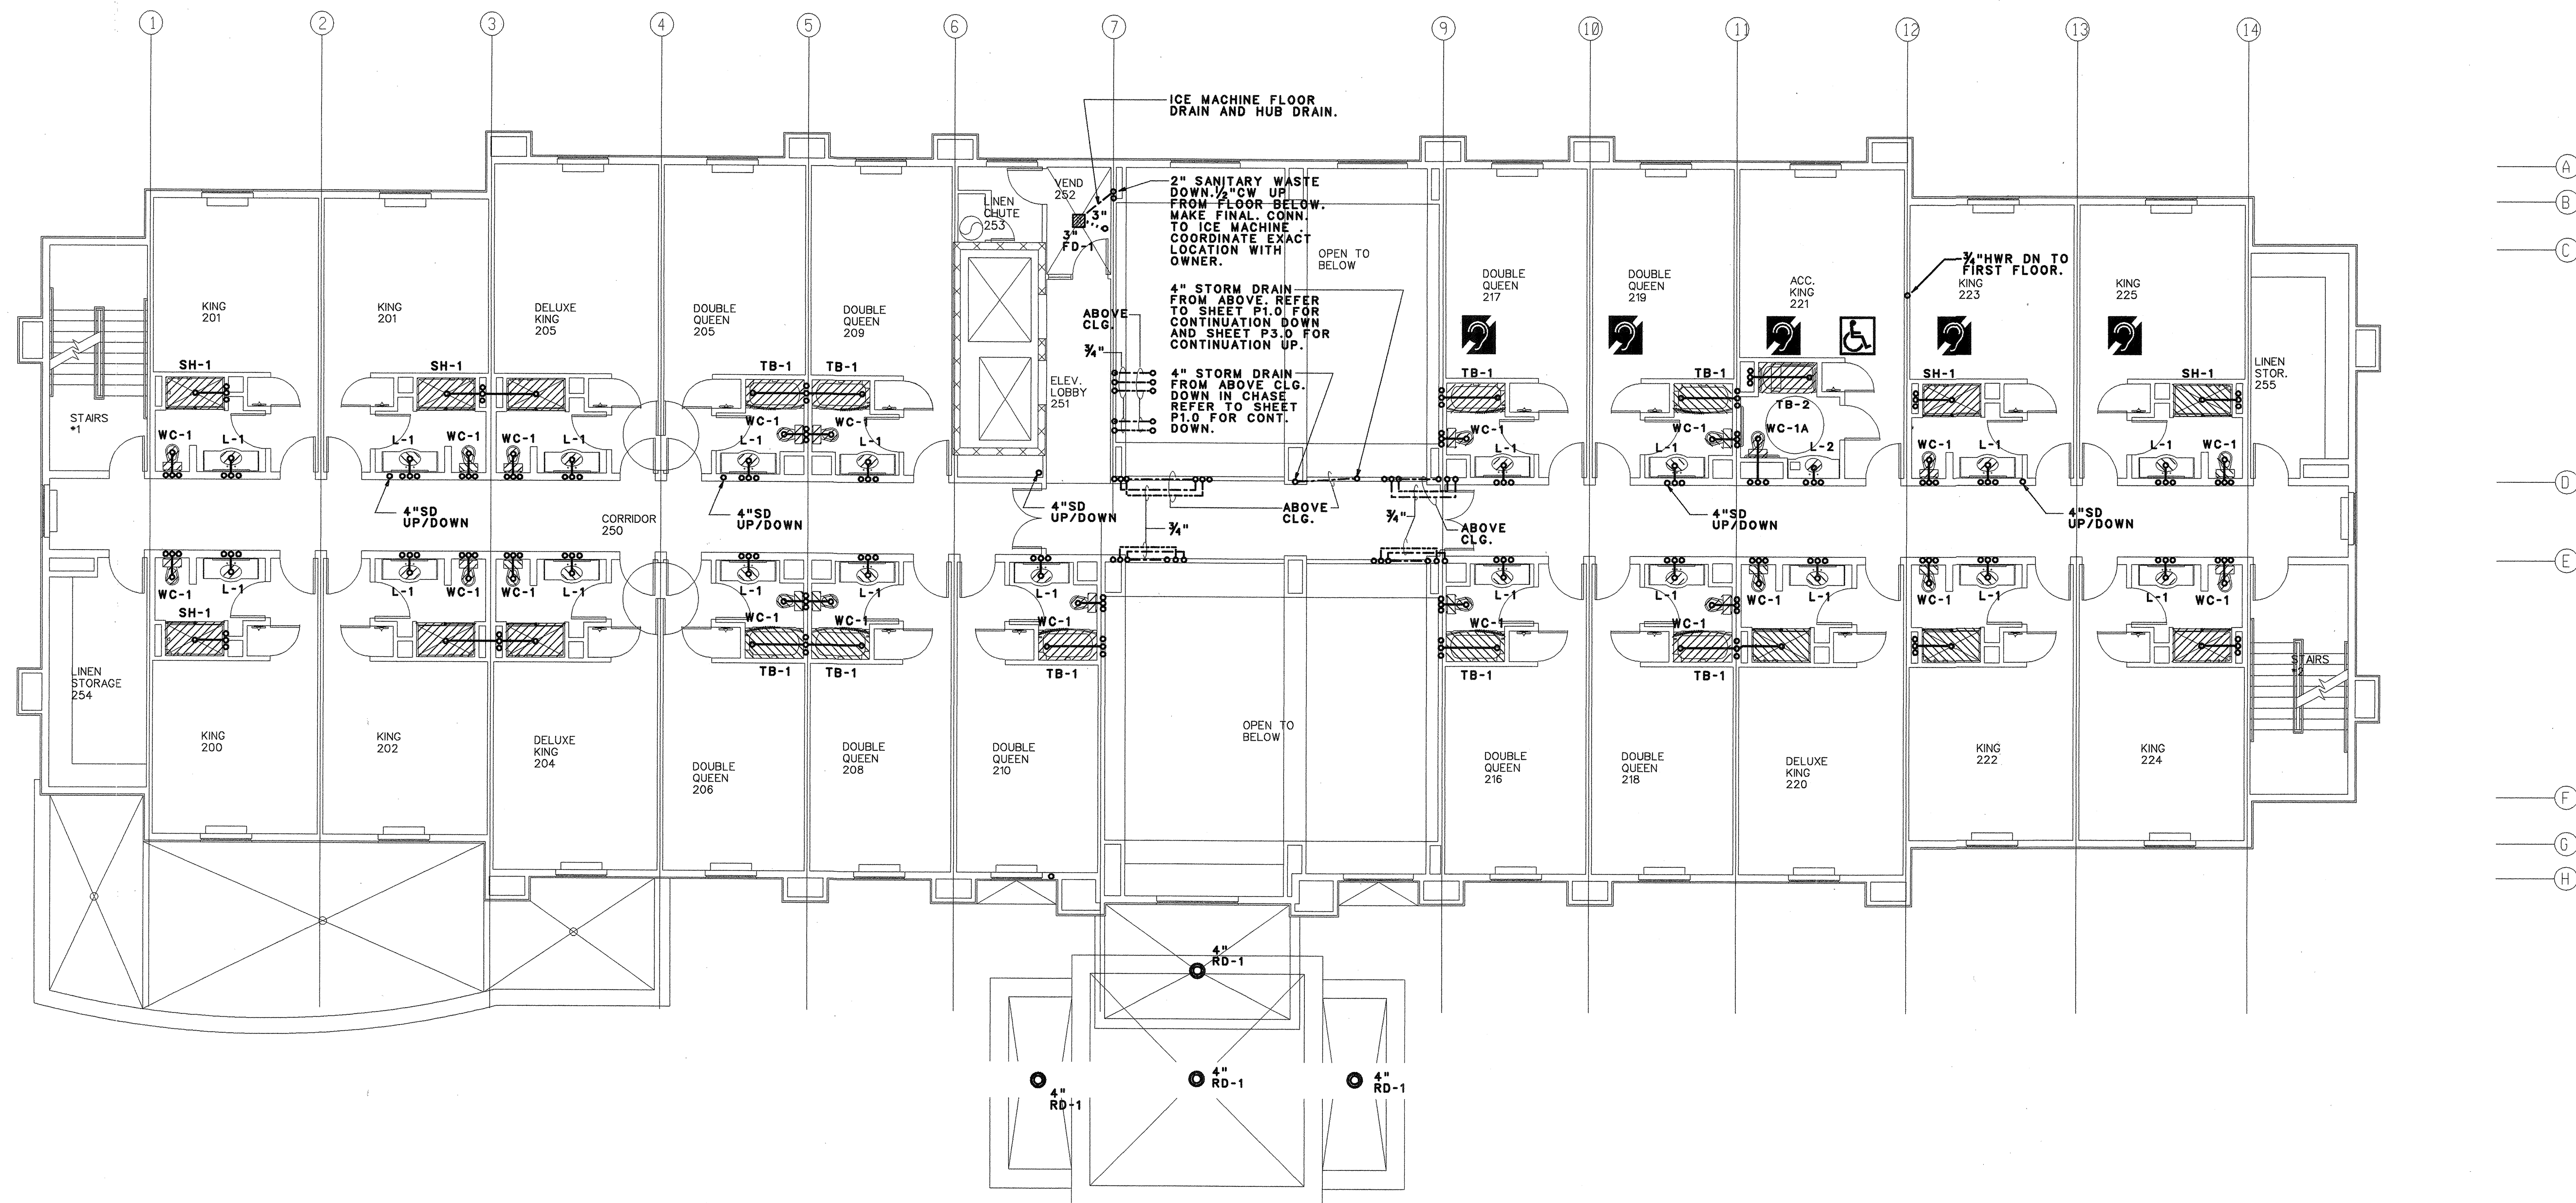

PLUMBING PLAN - SECOND FLOOR

SCALE: 1/8" = 1'-0"

RICHARD F. STELL
ARCHITECT
 (262) 502-4500
 N85 W16058 APPLETON AVE., MENOMONEE FALLS, WI 53051

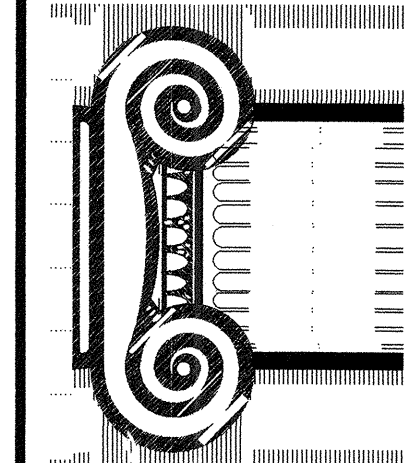

DRAWN:

APPROVED:

2-29-08 NO CHANGE

DATE COMMENTS

REVISIONS

JOB:

DATE: 12-07-07

Hampton Inn.

FLOWOOD, MS

98 UNITS

SHEET

P2.0

Fred Newton & Company, Inc.

Consulting Engineers-Mechanical and Electrical
 7013 Sand Beach Blvd. Shreveport, LA 71105
 318-524-2400 FAX 318-524-0700