



Richard Molenaar
ARCHITECT

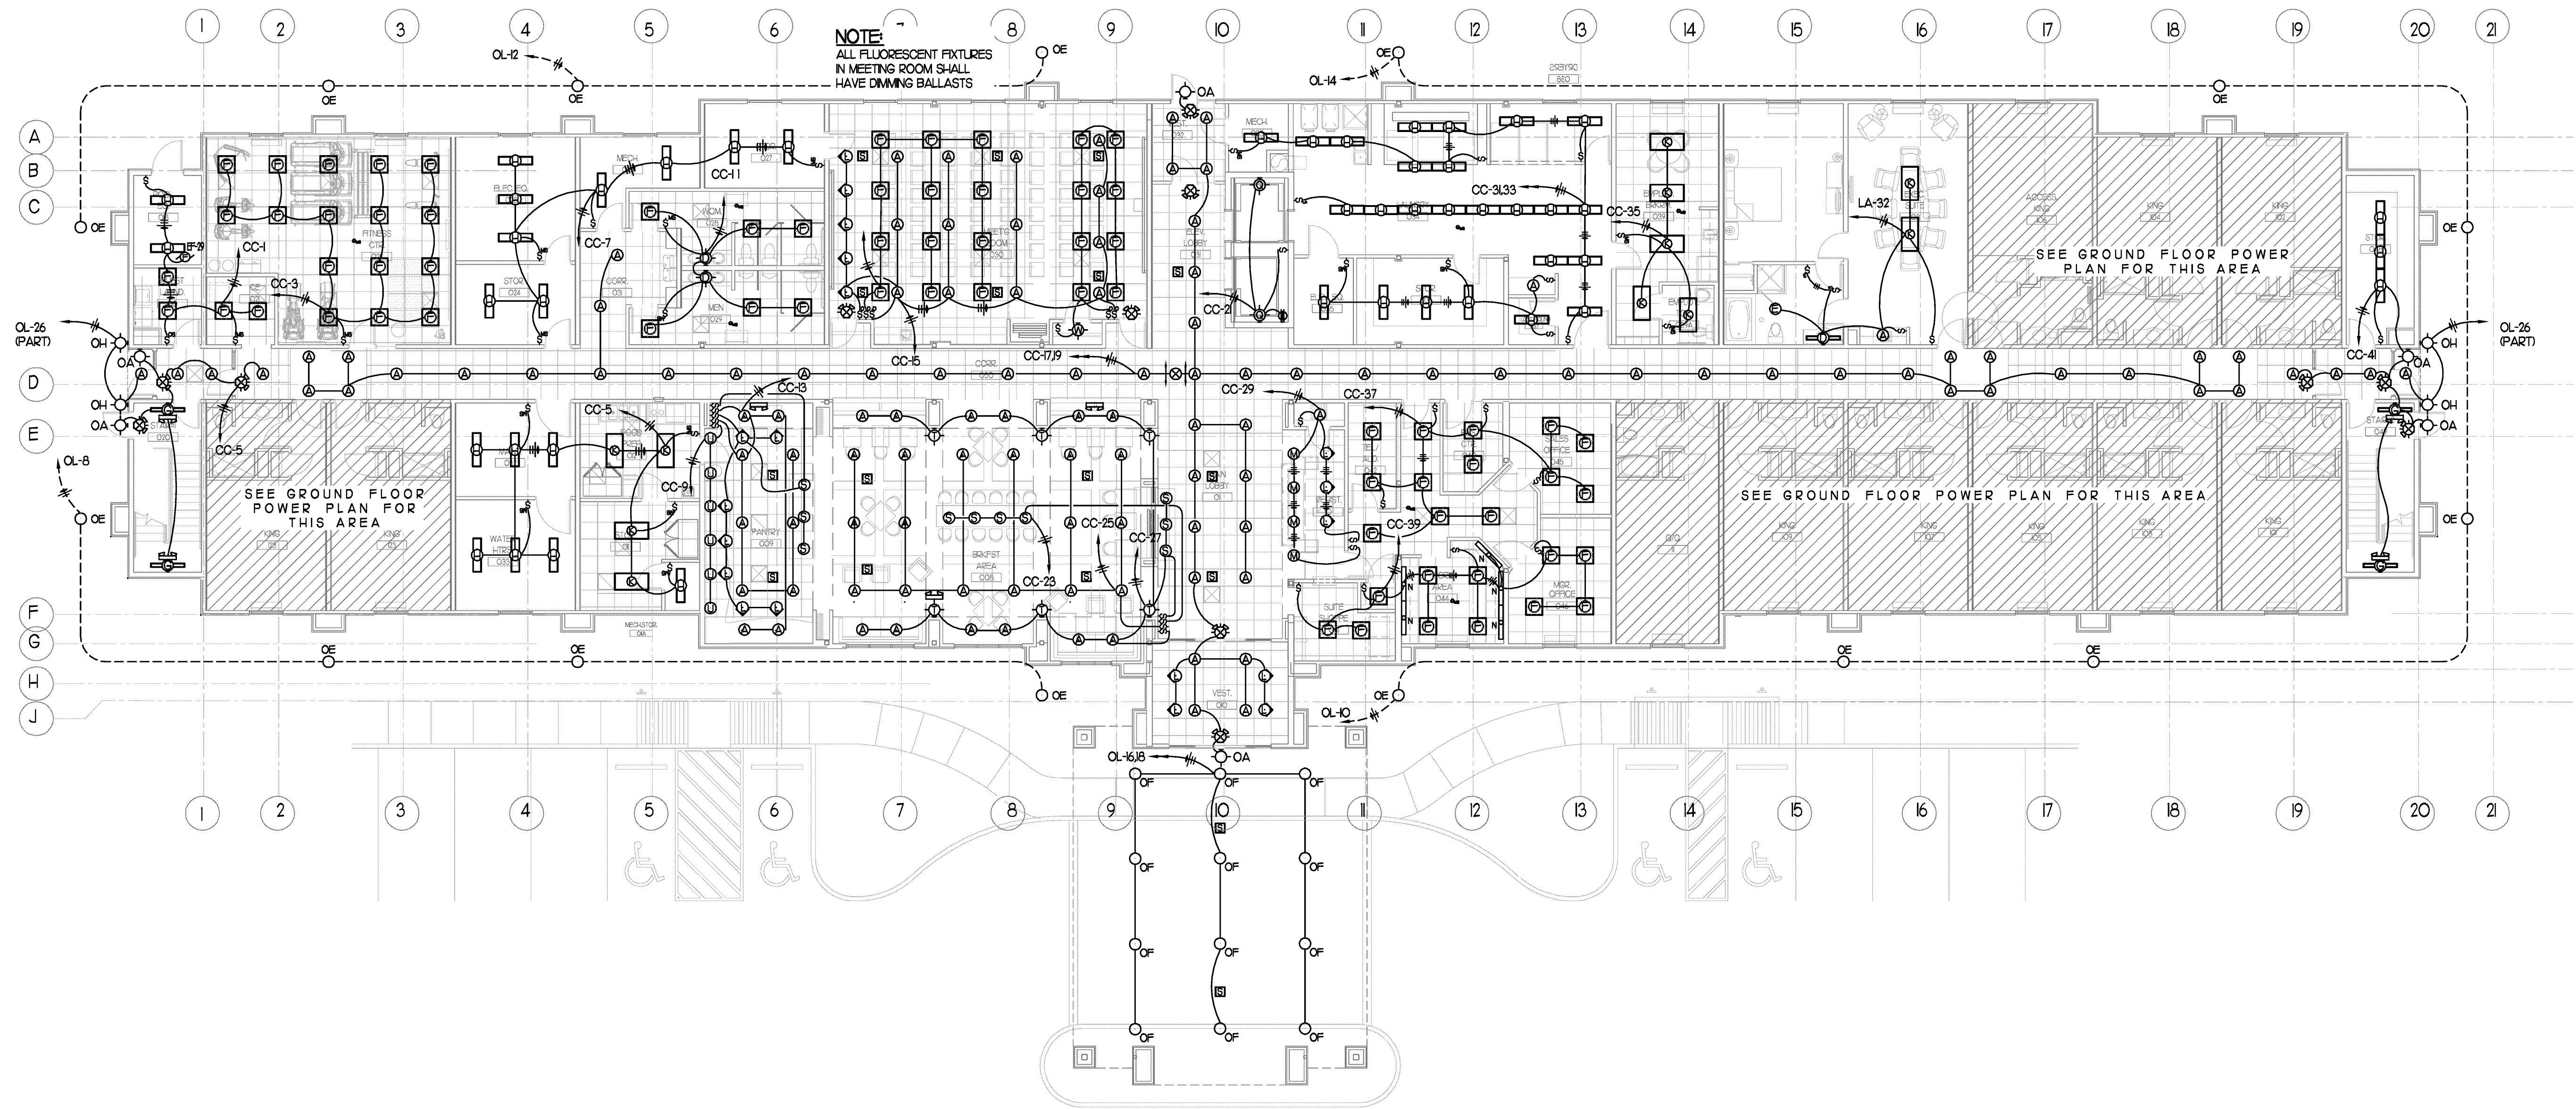

GROUND FLOOR LIGHTING PLAN
1/8" = 1'-0"

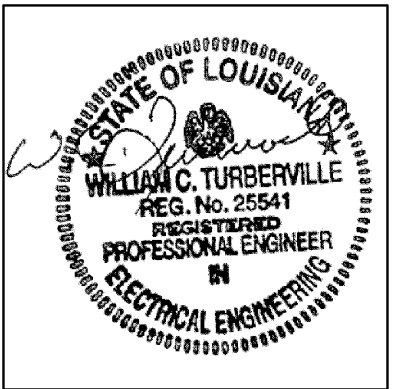

PROJECT NAME:
Hampton Inn
Mane Street
West Monroe, Louisiana

SHEET TITLE:
GROUND FLOOR POWER PLAN

Scale: 3/32" = 1' - 0"

PROJECT NO. 09017 LATEST REVISION:

DRAWN BY: SMJ CHECKED BY: SMJ SHEET NUMBER:

DATE:
09/13/10

E202

