
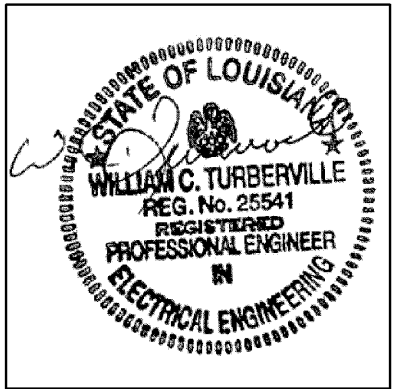


Richard Molenaar

ARCHITECT

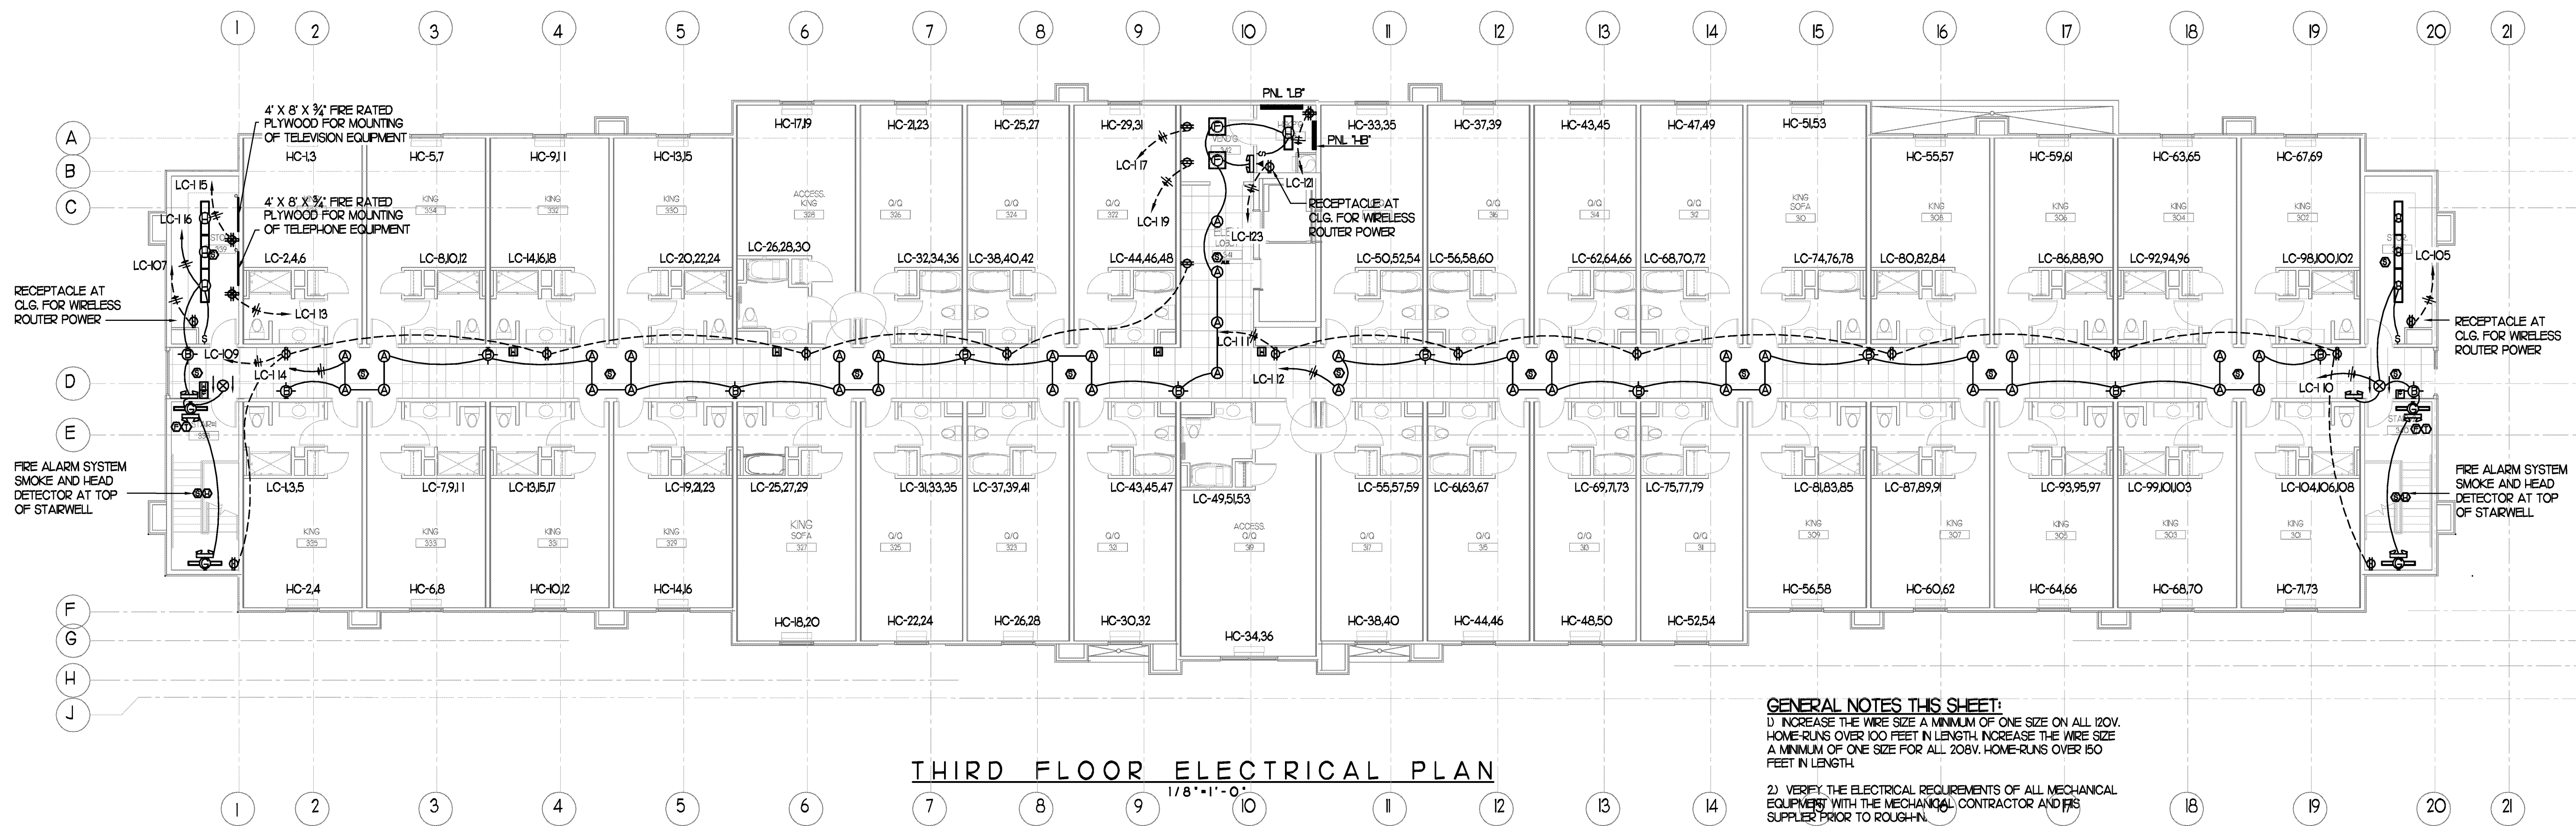

PROJECT NAME:

Hampton Inn
Main Street
West Monroe, Louisiana

SHEET TITLE:

THIRD FLOOR ELECTRICAL PLAN

Scale: 3/32" = 1' - 0"

PROJECT NO.

09017

LATEST REVISION:

DRAWN BY:

SMJ

CHECKED BY:

SMJ

SHEET NUMBER:

DATE:

09/13/10

E204