



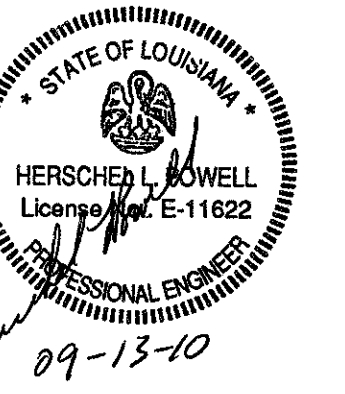

Richard Molenaar  
ARCHITECT

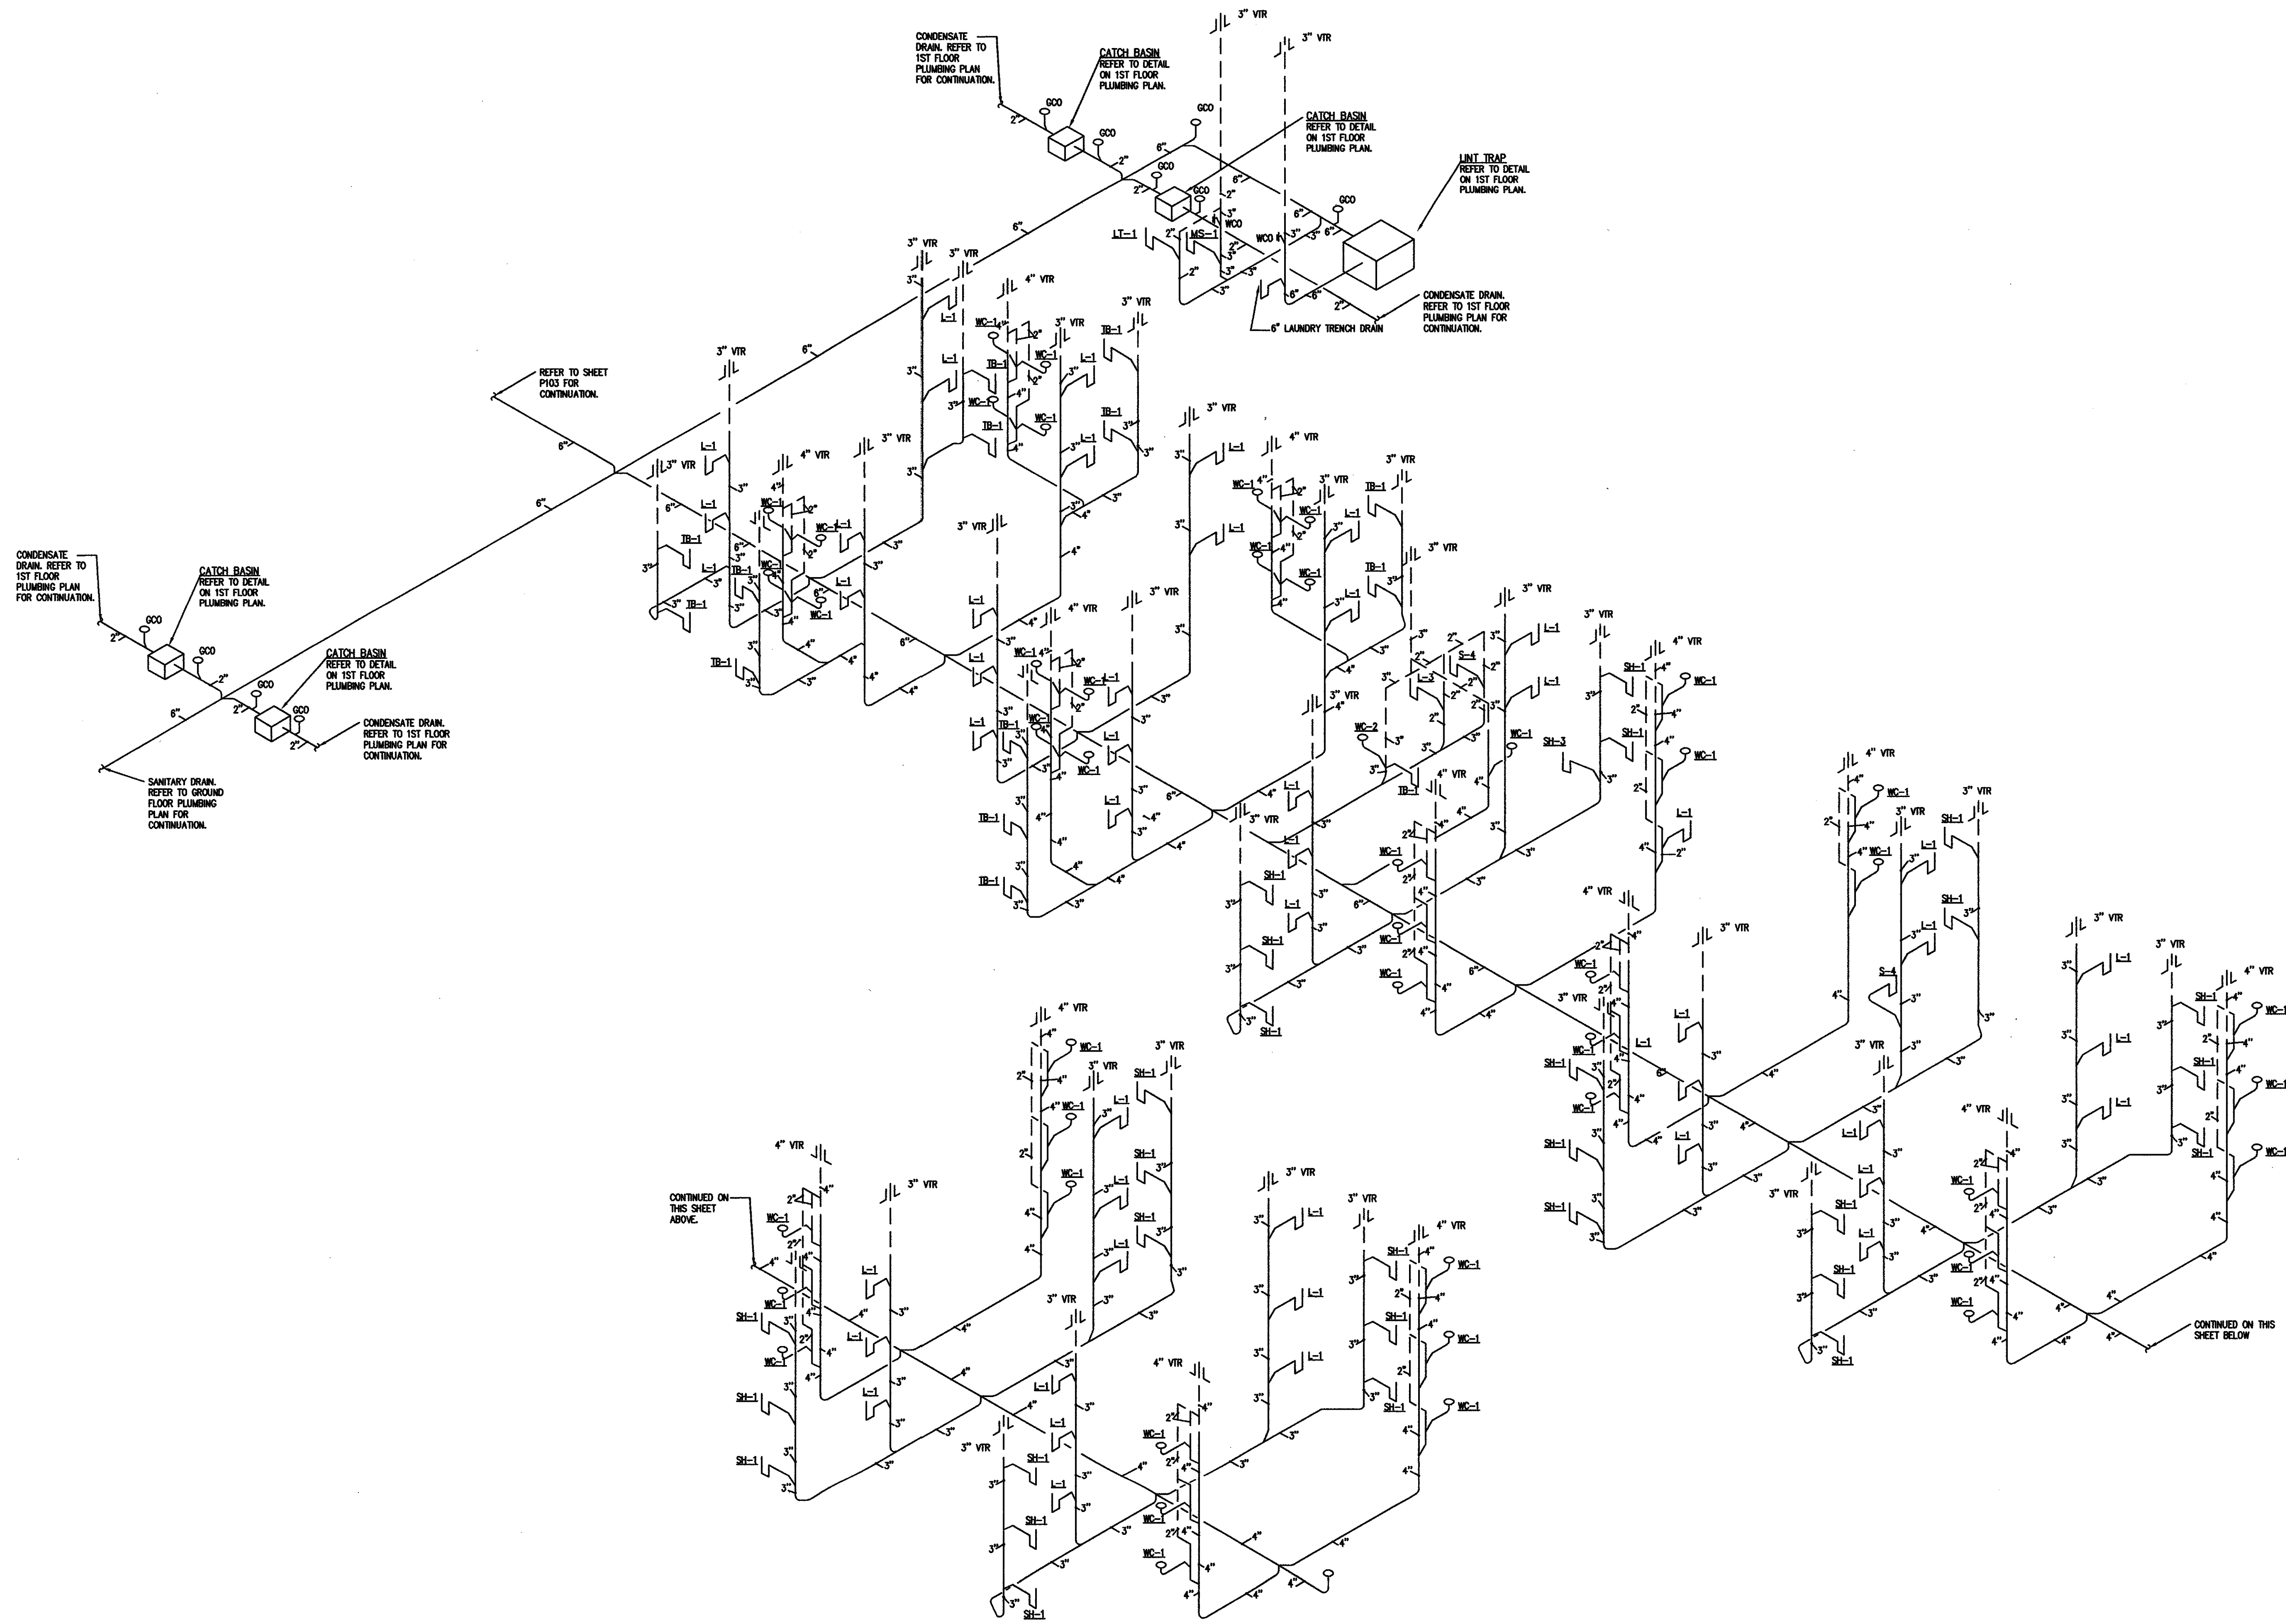

PROJECT NAME:  
**Hampton Inn**  
Main Street  
West Monroe, Louisiana

SHEET TITLE:  
**PLUMBING  
SANITARY RISERS**

PROJECT NO.	LATEST REVISION:
PROJ#	
DRAWN BY:	CHECKED BY:
RHP	HLP
DATE:	SHEET NUMBER:
09-13-10	<b>P107</b>