

by _____ date _____

drawn _____


checked _____

revised _____

revised _____

project no. _____

Sheet
A13
SET NO. ☐

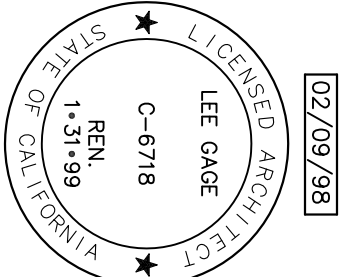

REVISIONS PER
CITY OF SOUTH SAN FRANCISCO
2/3/98

LEE GAGE C-6718

NOTE:
PROVIDE 25 GA. X 3 1/2" METAL FRAMING
@ 24" O.C. (TYP. @ ALL SOFFIT AREAS)
REFER TO SHEET S1 FOR SUSPENDED CEILING
ATTACHMENT RECTS.

HATCHING INDICATES LOWERED CEILING @ +7'-4" (B.O.F.)
(TYPICAL FOR 1ST, 2ND, 3RD, & 4TH FLOORS)
REFER TO SHEET A5 & A56 FOR CEILING JOIST DIRECTION & SIZE

NOTE:


COORDINATE WITH ELECTRICAL LIGHTING PLAN
FOR LIGHT FIXTURE LOCATIONS

COORDINATE WITH MECHANICAL FLOOR PLAN
FOR MECHANICAL DIFFUSER LOCATIONS

HATCHING INDICATES LOWERED CEILING @ +7'-4" (B.O.F.)
(TYPICAL FOR 1ST, 2ND, 3RD, & 4TH FLOORS)

REFER TO SHEET A5 & A56 FOR CEILING JOIST DIRECTION & SIZE

CEILING FINISH SCHEDULE		
SYMBOL	MATERIAL	FINISH REQUIREMENTS
1	GYPSUM BOARD	LIGHT KNOCK-DOWN TEXTURE & PAINT// REFER TO SHT. A9
2	SUSPENDED ACOUSTICAL CEILING	2x2 GRID/ 2nd LOOK
3	CEMENT PLASTER	REFER TO EXTERIOR ELEVATIONS FOR COLOR

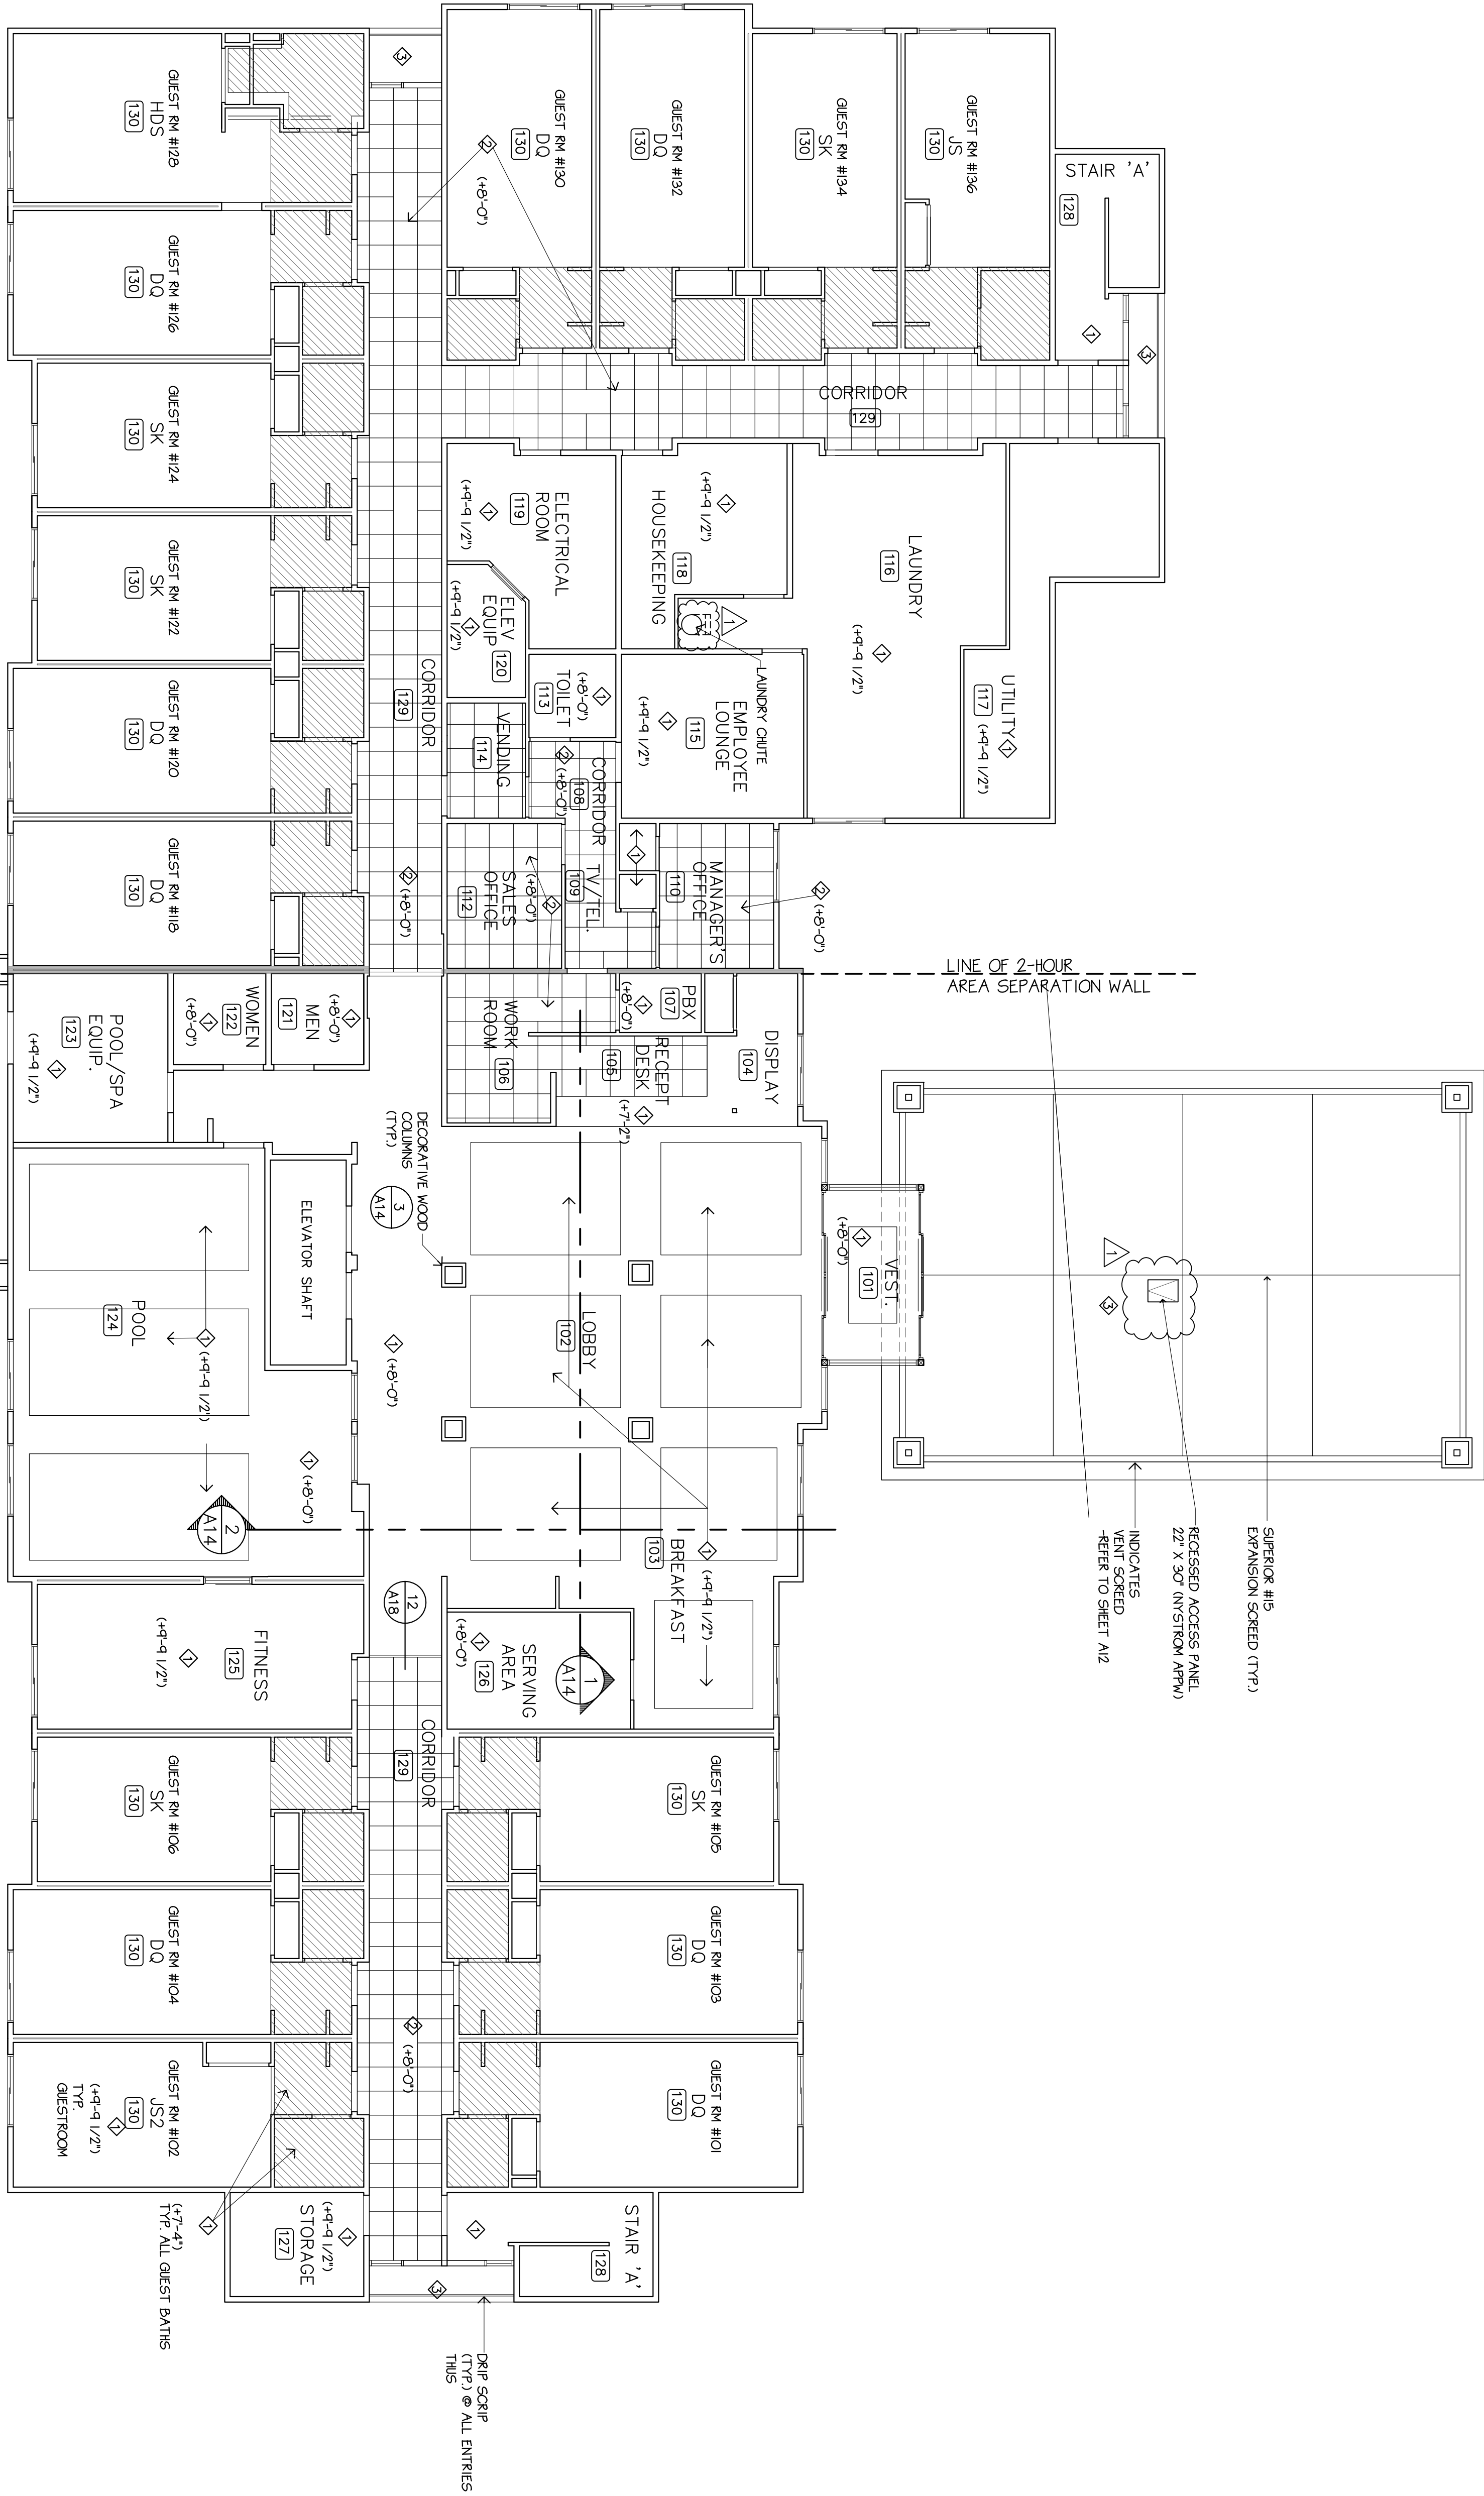


LINE OF 2-HOUR
AREA SEPARATION WALL

LINE OF 2-HOUR
AREA SEPARATION WALL

SUPERIOR #15
EXPANSION SCORED (TYP.)
RECESSED ACCESS PANEL
22" X 30" (NYS/STROM APPN)
INDICATES
VENT SCORED
-REFER TO SHEET A12

DROP SCRAP
(TYP.) @ ALL ENTRIES
THIS

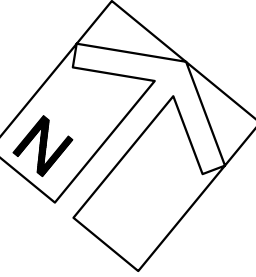

**MAIN FLOOR
REFLECTED
CEILING PLAN**

SCALE: 1/8"=1'-0"