


03/17/98

REVISIONS PER
CITY OF SOUTH SAN FRANCISCO
2/5/98

REVISIONS PER
CITY OF SOUTH SAN FRANCISCO
3/11/98

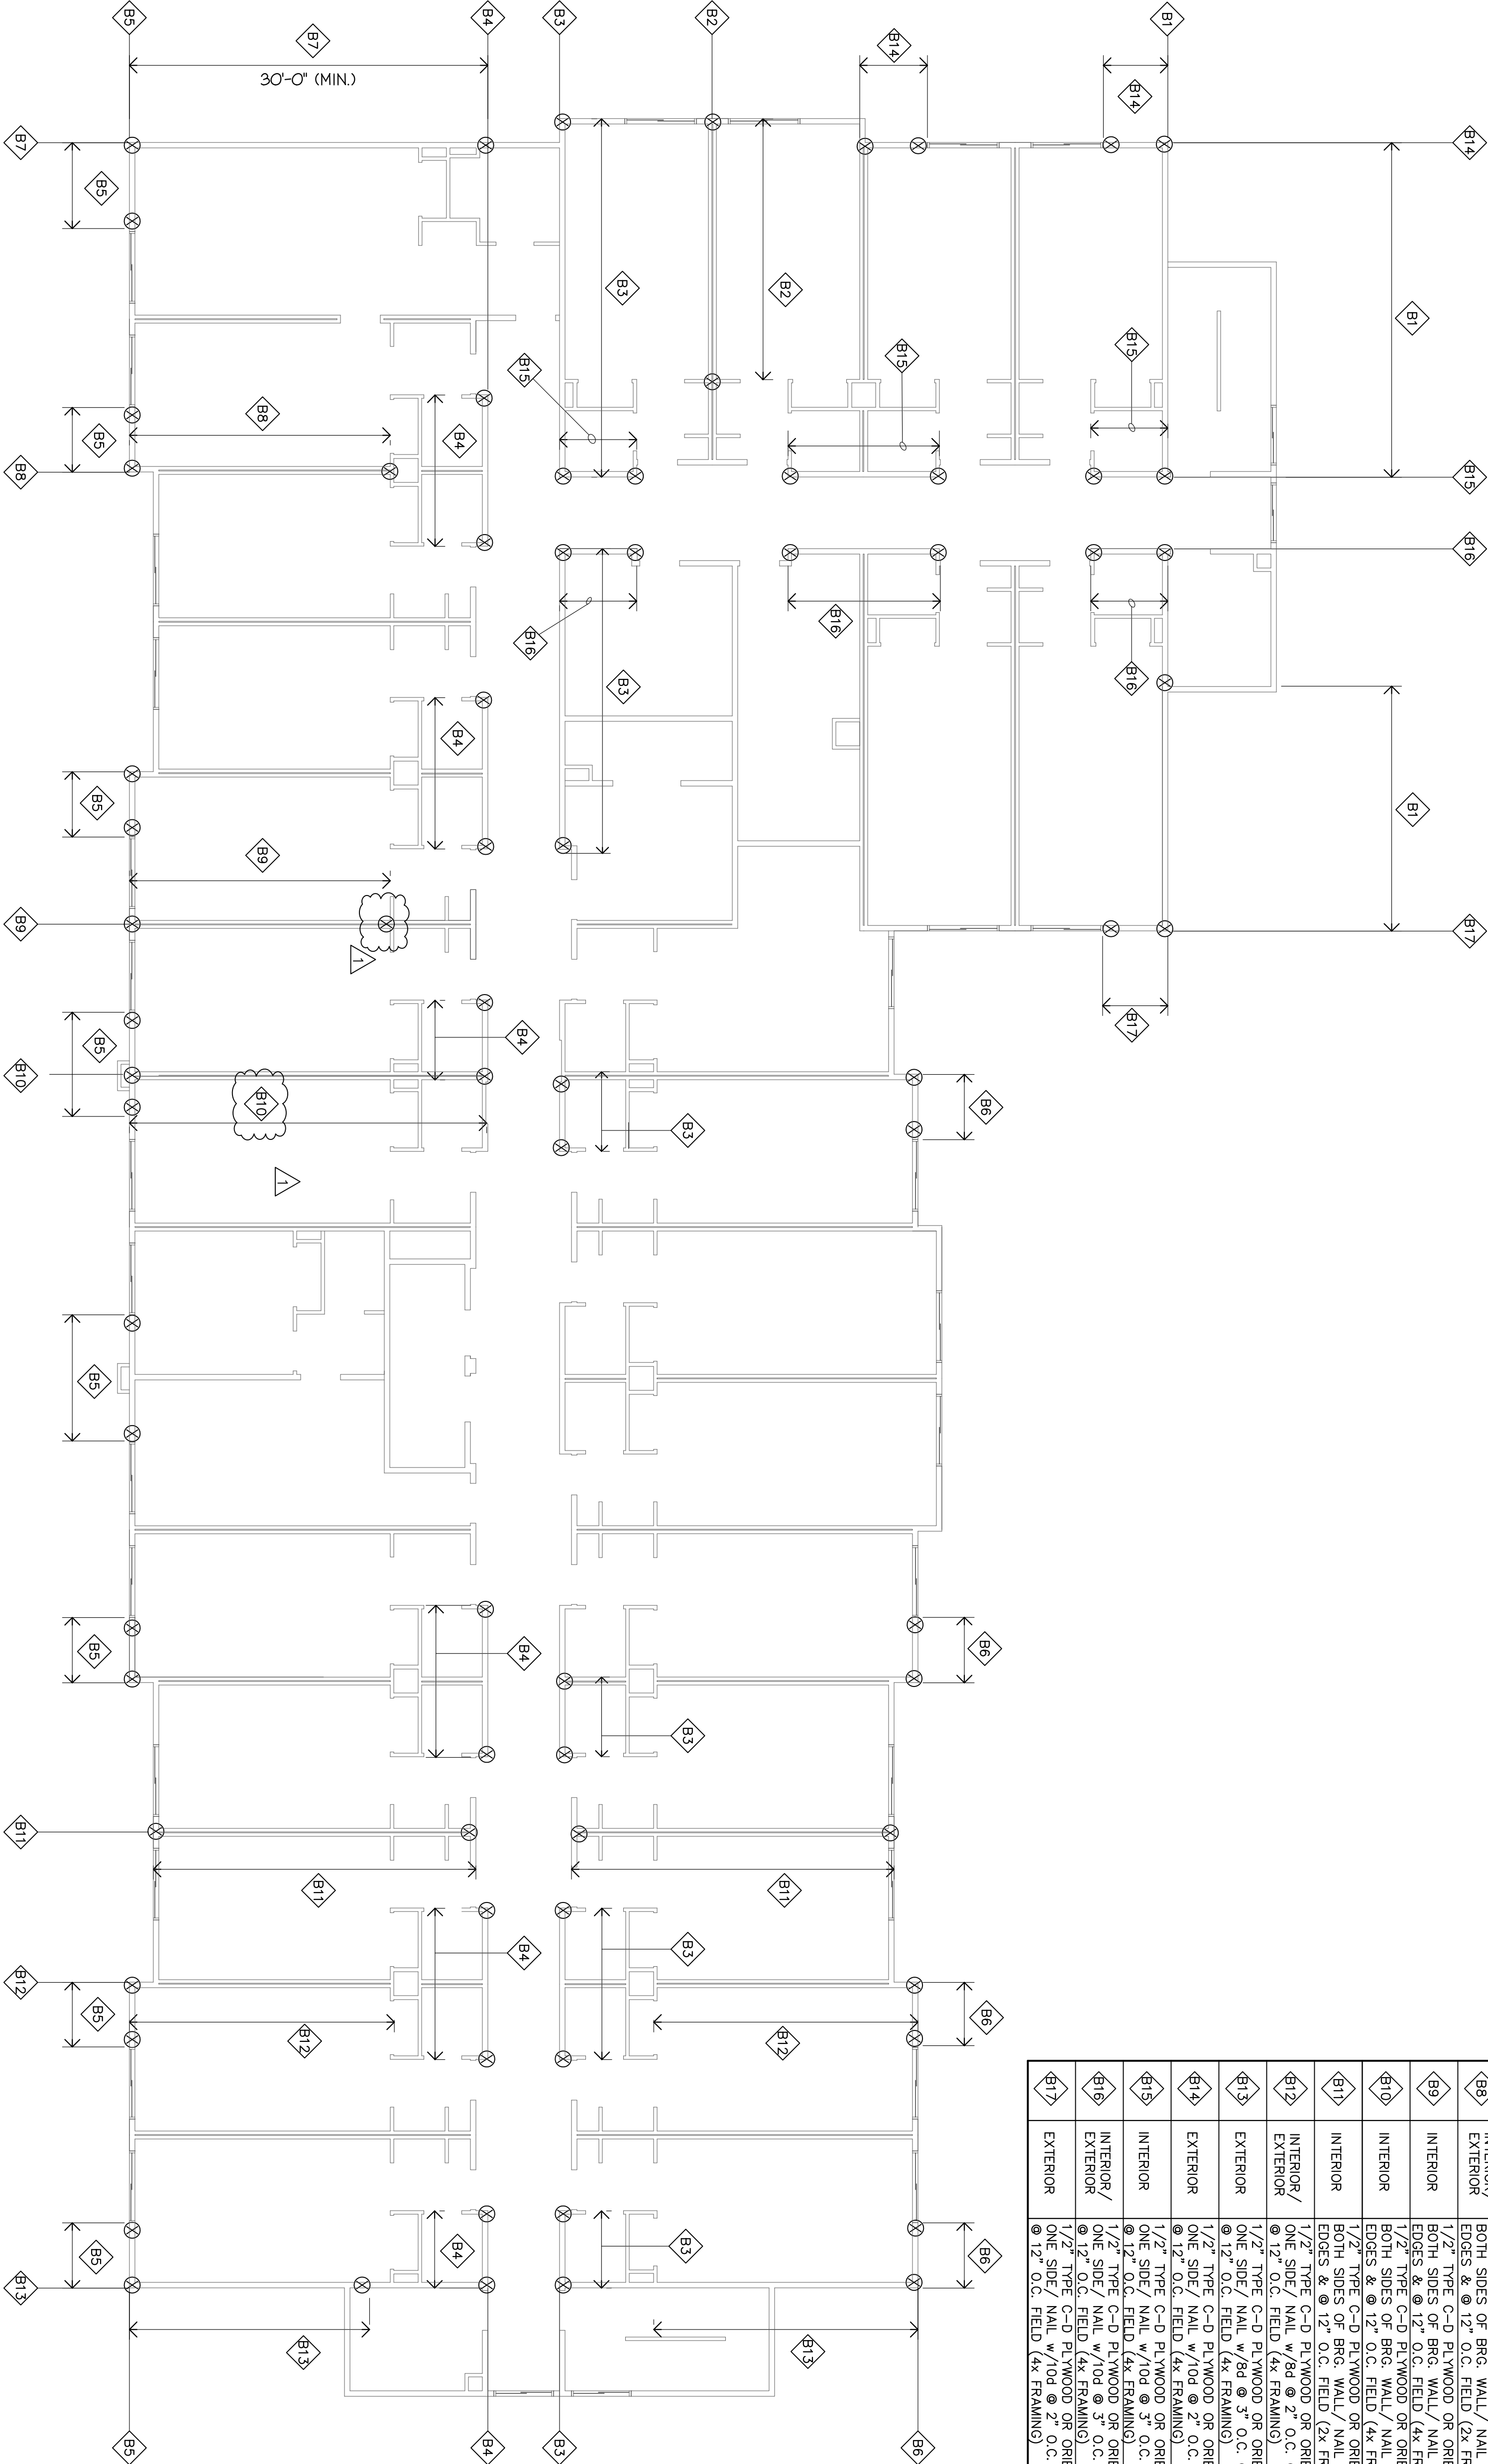

REFER TO SHEET S2A FOR
STUD WALL INDEX

NOTE:
FOR SILL PLATE NAILING AT SHEAR WALLS
USE 16d NAILS
- SPACE AT SAME NAILING AS SHEAR
PANEL EDGE NAILING
- REFER TO DETAILS 2/S6 & 11/S6

SHEAR PANEL SCHEDULE		
SYM.	LOCATION DESCRIPTION	FOUNDATION SUPPORT
2nd FLOOR WALLS		
B1	INTERIOR/ ONE SIDE / NAIL w/10d @ 2' O.C. @ ALL EDGES & @ 12" O.C. FIELD (4x FRAMING)	MS172 STRAP EA. END
B2	INTERIOR/ ONE SIDE / NAIL w/10d @ 2' O.C. @ ALL EDGES & @ 12" O.C. FIELD (4x FRAMING)	NONE REQUIRED
B3	INTERIOR/ ONE SIDE / NAIL w/10d @ 3" O.C. @ ALL EDGES & @ 12" O.C. FIELD (4x FRAMING)	CMST12 STRAP EA. END (11" END LENGTH)
B4	INTERIOR/ ONE SIDE / NAIL w/10d @ 3" O.C. @ ALL EDGES & @ 12" O.C. FIELD (4x FRAMING)	CMST12 STRAP EA. END (11" END LENGTH)
B5	EXTERIOR/ ONE SIDE / NAIL w/10d @ 2' O.C. @ ALL EDGES & @ 12" O.C. FIELD (4x FRAMING)	CMST12 STRAP EA. END (11" END LENGTH)
B6	EXTERIOR/ ONE SIDE / NAIL w/10d @ 2" O.C. @ ALL EDGES & @ 12" O.C. FIELD (4x FRAMING)	CMST12 STRAP EA. END (11" END LENGTH)
B7	EXTERIOR/ ONE SIDE / NAIL w/8d @ 4" O.C. @ ALL EDGES & @ 12" O.C. FIELD (2x FRAMING)	NONE REQUIRED
B8	INTERIOR/ BOTH SIDES OF BRG. WALL / NAIL w/8d @ 4" O.C. @ ALL EDGES & @ 12" O.C. FIELD (4x FRAMING)	CS16 STRAP @ EACH END ON BOTH WALLS (11" END LENGTH)
B9	INTERIOR/ BOTH SIDES OF BRG. WALL / NAIL w/8d @ 6" O.C. @ ALL EDGES & @ 12" O.C. FIELD (4x FRAMING)	CS16 STRAP @ EACH END ON BOTH WALLS (11" END LENGTH)
B10	INTERIOR/ BOTH SIDES OF BRG. WALL / NAIL w/8d @ 3" O.C. @ ALL EDGES & @ 12" O.C. FIELD (4x FRAMING)	MS180 STRAP EA. END (11" END LENGTH)
B11	INTERIOR/ BOTH SIDES OF BRG. WALL / NAIL w/8d @ 4" O.C. @ ALL EDGES & @ 12" O.C. FIELD (4x FRAMING)	MS137 STRAP EA. END (11" END LENGTH)
B12	INTERIOR/ ONE SIDE / NAIL w/8d @ 2" O.C. @ ALL EDGES & @ 12" O.C. FIELD (4x FRAMING)	NONE REQUIRED
B13	EXTERIOR/ ONE SIDE / NAIL w/8d @ 3" O.C. @ ALL EDGES & @ 12" O.C. FIELD (4x FRAMING)	CS16 STRAP EA. END (11" END LENGTH)
B14	EXTERIOR/ ONE SIDE / NAIL w/10d @ 2' O.C. @ ALL EDGES & @ 12" O.C. FIELD (4x FRAMING)	CMST12 STRAP EA. END (11" END LENGTH)
B15	INTERIOR/ ONE SIDE / NAIL w/10d @ 3" O.C. @ ALL EDGES & @ 12" O.C. FIELD (4x FRAMING)	CMST12 STRAP EA. END (11" END LENGTH)
B16	INTERIOR/ ONE SIDE / NAIL w/10d @ 3" O.C. @ ALL EDGES & @ 12" O.C. FIELD (4x FRAMING)	CMST12 STRAP EA. END (11" END LENGTH)
B17	EXTERIOR/ ONE SIDE / NAIL w/10d @ 2' O.C. @ ALL EDGES & @ 12" O.C. FIELD (4x FRAMING)	CMST12 STRAP EA. END (11" END LENGTH)

SHEAR WALL PLAN
2nd FLOOR
SCALE: 1/8"=1'-0"
LEE GAGE C-6718